
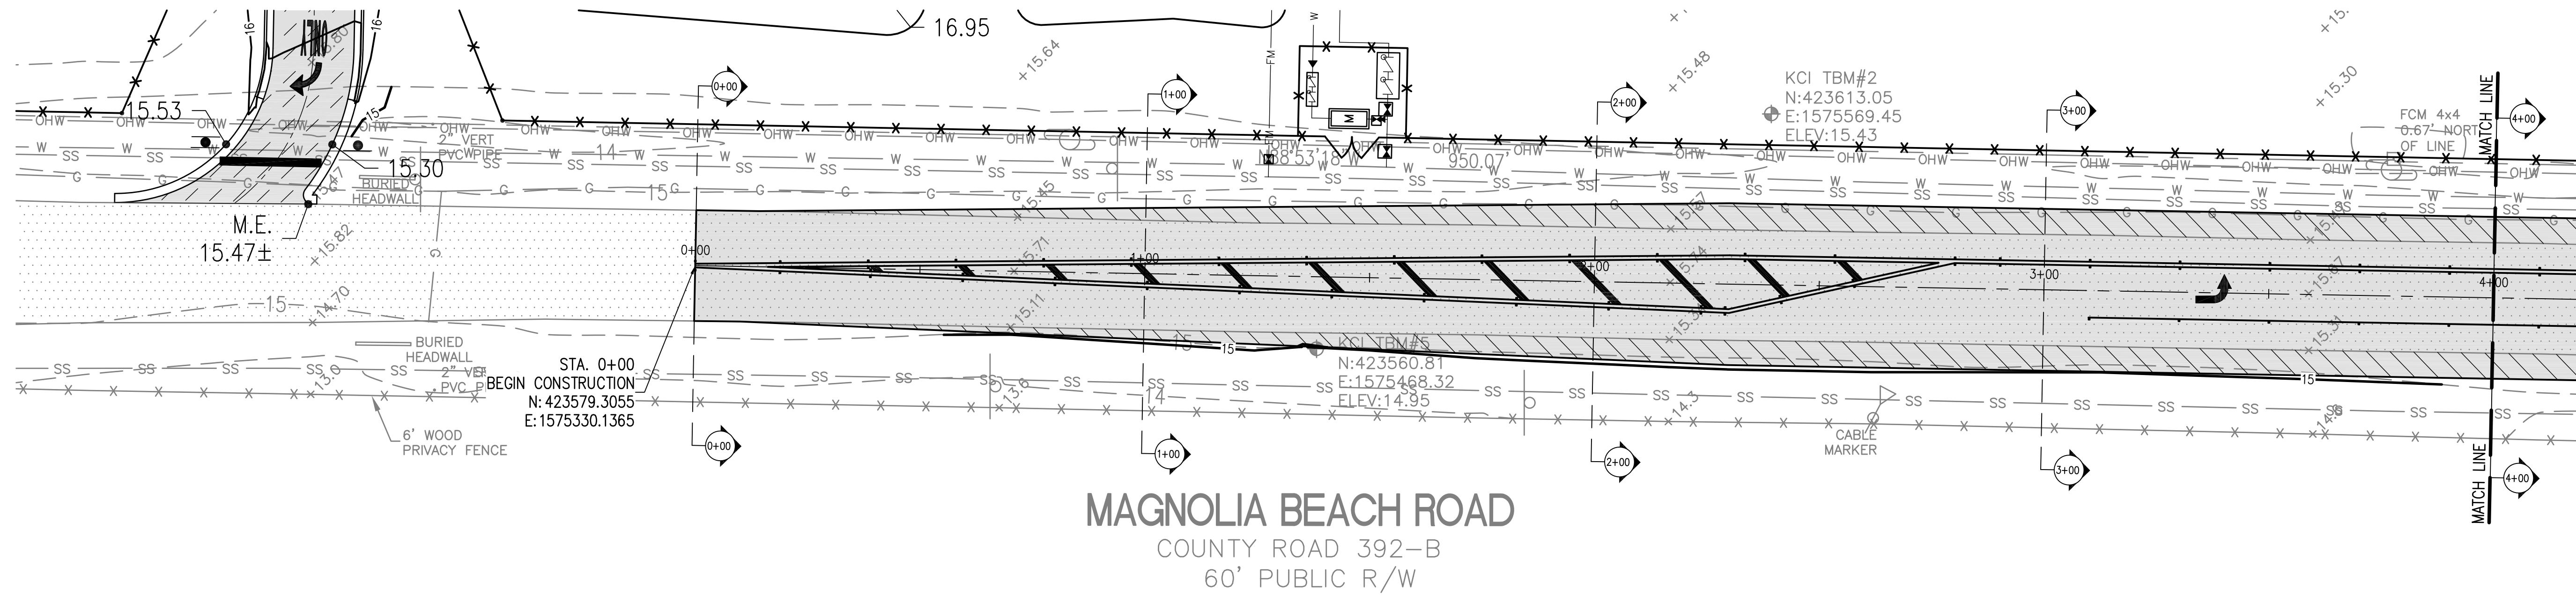
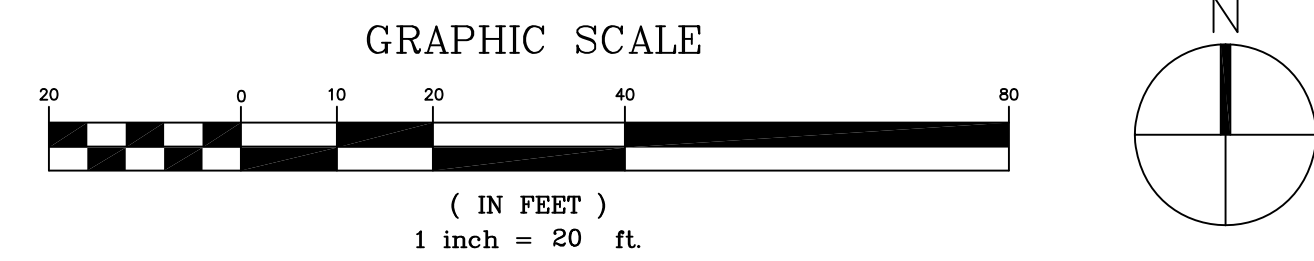


three inches = one foot
one and one half inches = one foot
one inch = one foot
three quarters inch = one foot
one half inch = one foot
three eighths inch = one foot
one quarter inch = one foot
one eighth inch = one foot


 
 


NOTES:
SEE SHEET CG111 FOR MAGNOLIA BEACH
ROAD SECTIONS.

- LEGEND:**
- EXISTING SPOT ELEVATION
 - PROPOSED SPOT ELEV., (S) SIDEWALK (P) PAVEMENT
 - EXISTING CONTOUR
 - PROPOSED CONTOUR
 - STORM
 - NEW CLEAN-OUT
 - NEW FDOT TYPE "E" INLET (B2/CG501)
 - NEW FDOT TYPE "3" CURB INLET (E4/CG501)
 - NEW FDOT TYPE "4" CURB INLET (E4/CG501)
 - STORMWATER FLOW DIRECTION

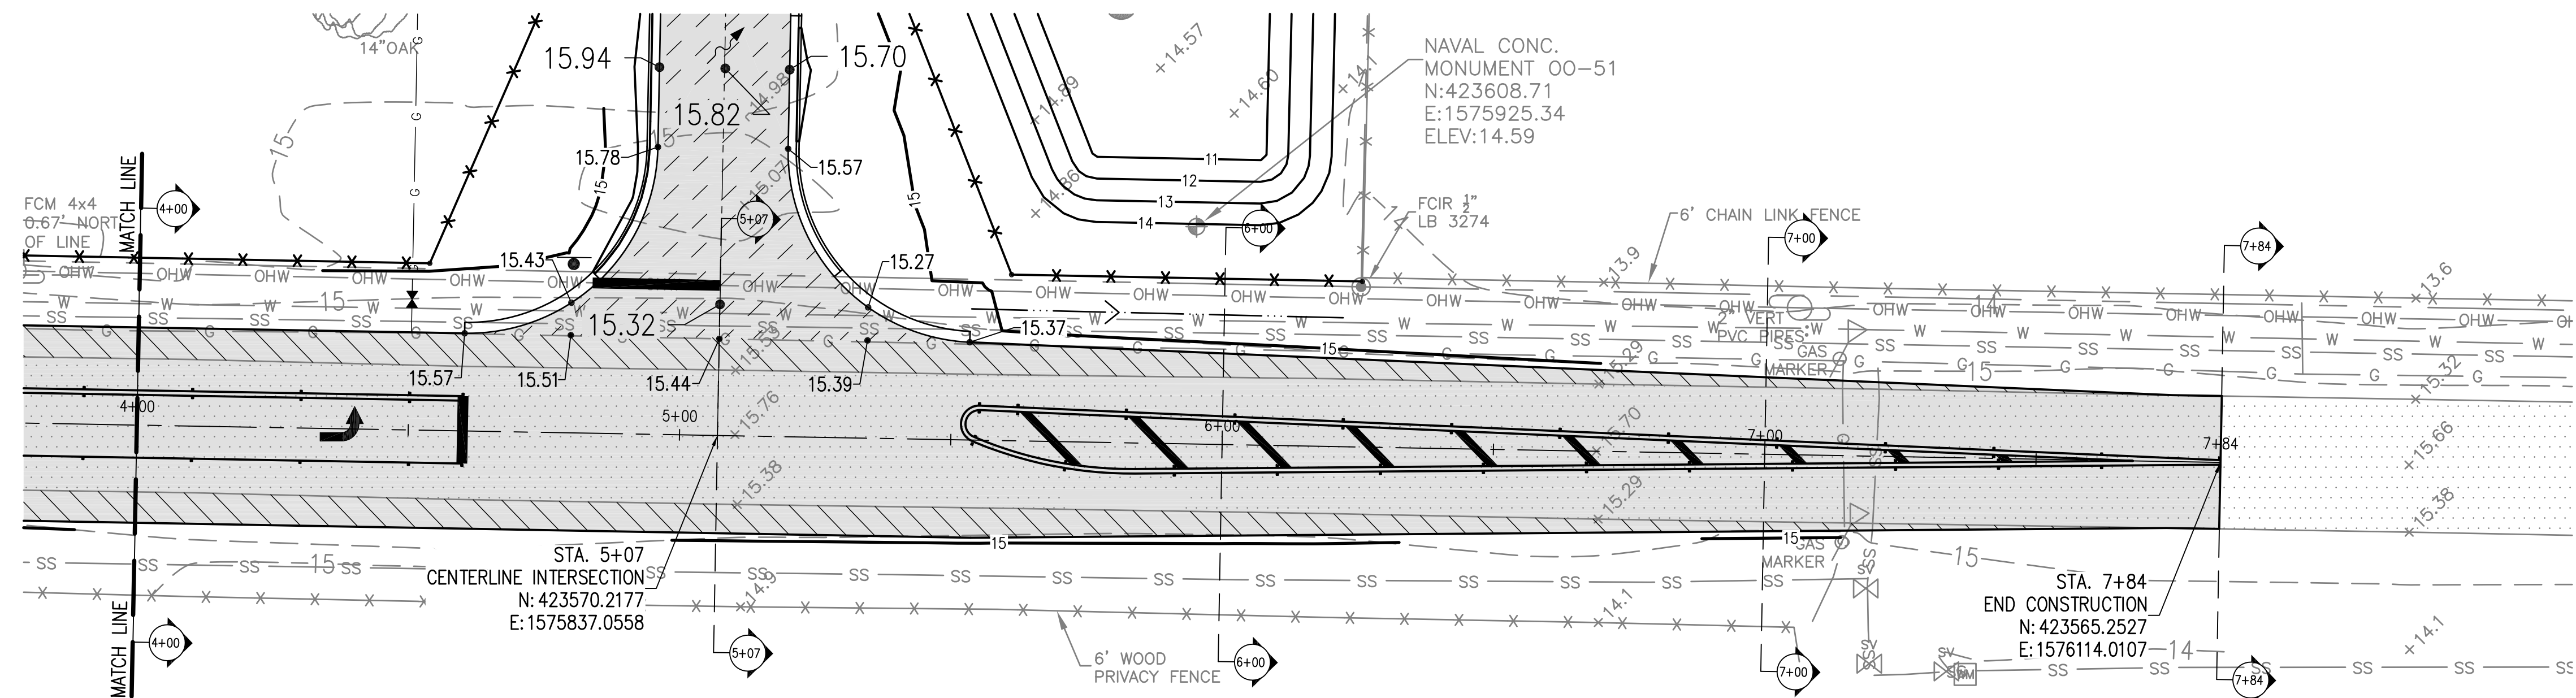

FINAL SUBMISSION

		CONSULTANTS:				ARCHITECT/ENGINEERS:		<div>Drawing Title MAGNOLIA BEACH ROAD GRADING PLAN</div>		<div>Project Title PANAMA CITY JOINT OUTPATIENT CLINIC VA GULF COAST HEALTH CARE</div>		<div>Project Number 520-326</div> <div>Building Number -</div>		<div>Office of Construction and Facilities Management</div> <div> Department of Veterans Affairs</div>			
		CIVIL: KENNETH HORNE & ASSOCIATES 7201 NORTH 4TH AVE., STE. 6 PENSACOLA, FLORIDA 32504 PH: (850) 471-9005 FX: (850) 471-0093		COMM/DR: SCHMIDT CONSULTING GROUP, INC. 40 S. PALMARO PLAZA, STE. 300 PENSACOLA, FLORIDA 32502 PH: (850) 438-0050 FX: (850) 432-0631		SURVEYORS: KCI TECHNOLOGIES, INC. 10401 HIGHLAND DRIVE, SUITE 120 TAMPA, FLORIDA 33610 PH: (813) 740-2300											
		LANDSCAPE ARCHITECT: CSA GROUP, INC. 6300 PICCOLINELLI SQUARE DRIVE MOBILE, ALABAMA 36609 PH: (251) 344-4023 FX: (251) 344-4052		ARCHITECTURE: BULLOCK TUCK ASSOCIATES, INC. 909 EAST CERVANTES STREET PENSACOLA, FL 32501 PH: (850) 454-5444 FX: (850) 432-5208		<div></div> <div>KCH FLA. #8268</div>		<div></div> <div>BES DESIGN/BUILD 766 Middle St, Fairhope, AL 36532 Phone: 251.990.5778 Fax: 251.990.3716</div>		<div>Approved Project Director</div>		<div>Location PANAMA CITY, FLORIDA</div>				<div>Drawing Number CG110 Dwg. 19 of 21</div>	
<div>Revisions:</div>		<div>Date</div>								<div>Date SEPTEMBER 5, 2012</div>		<div>Checked KCH</div>				<div>Drawn LRR</div>	