
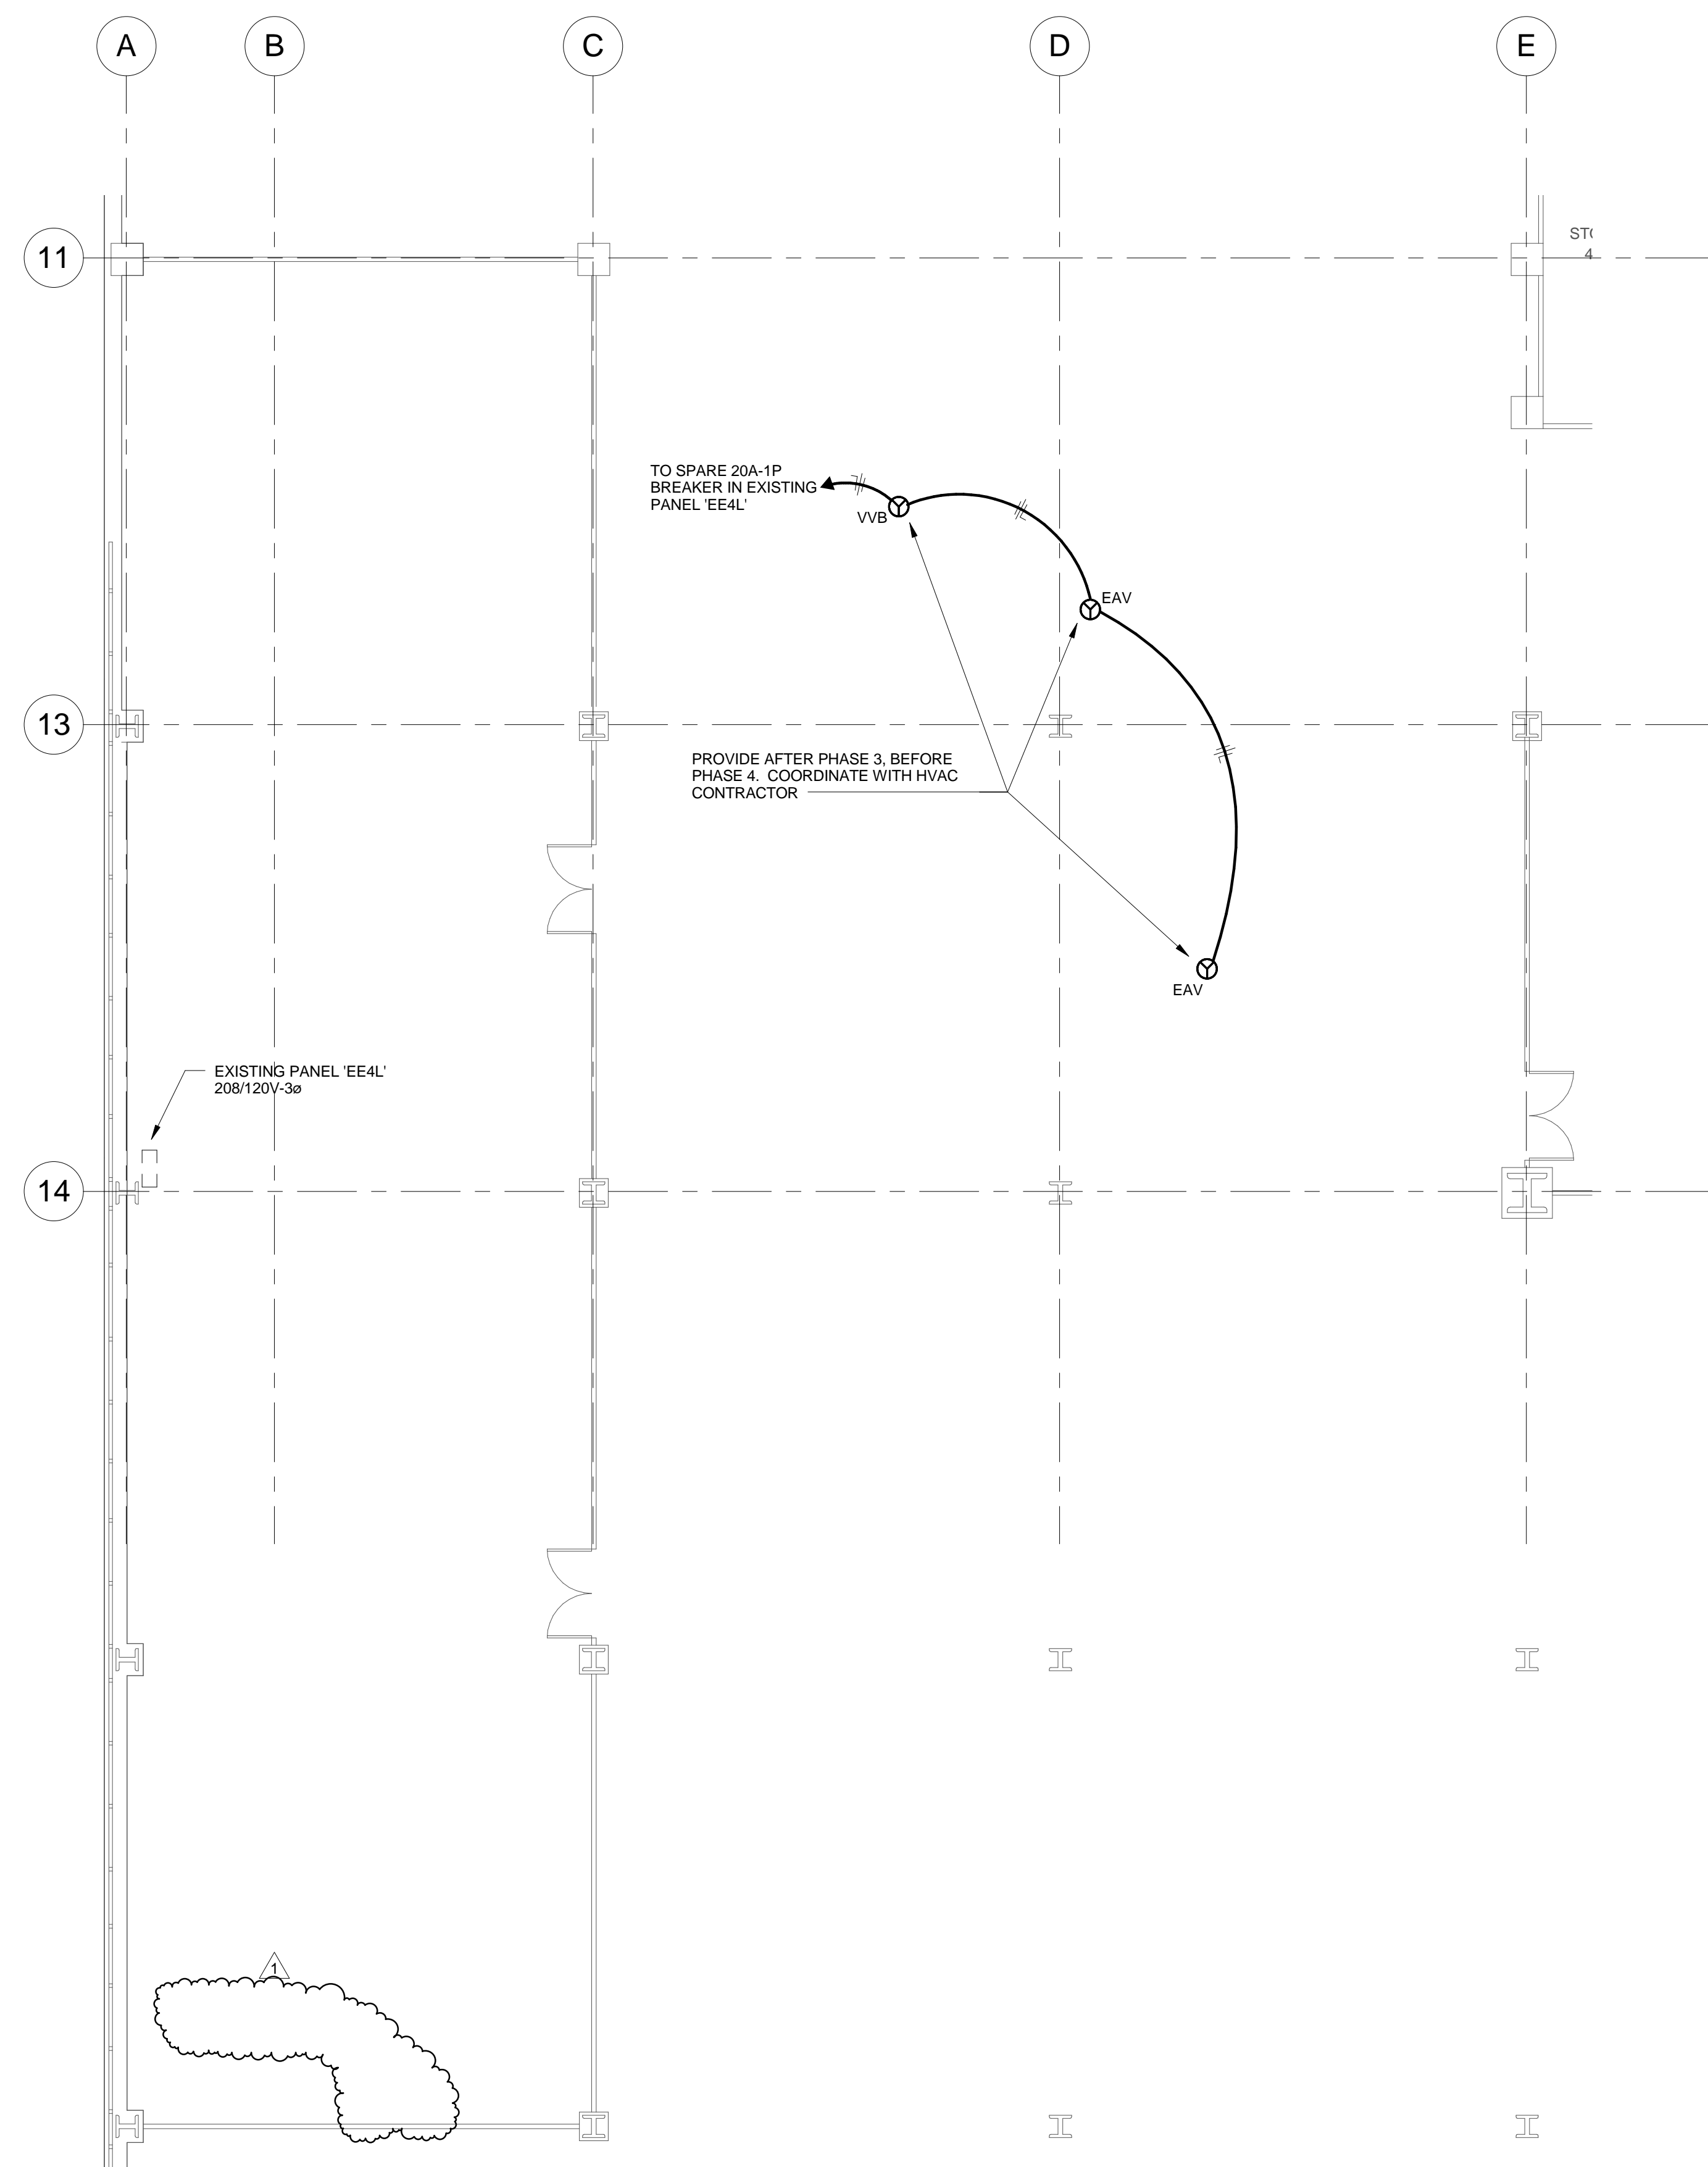


three inches = one foot
one and one half inches = one foot
one inch = one foot
three quarters inch = one foot
one half inch = one foot
three eighths inch = one foot
one quarter inch = one foot
one eighth inch = one foot

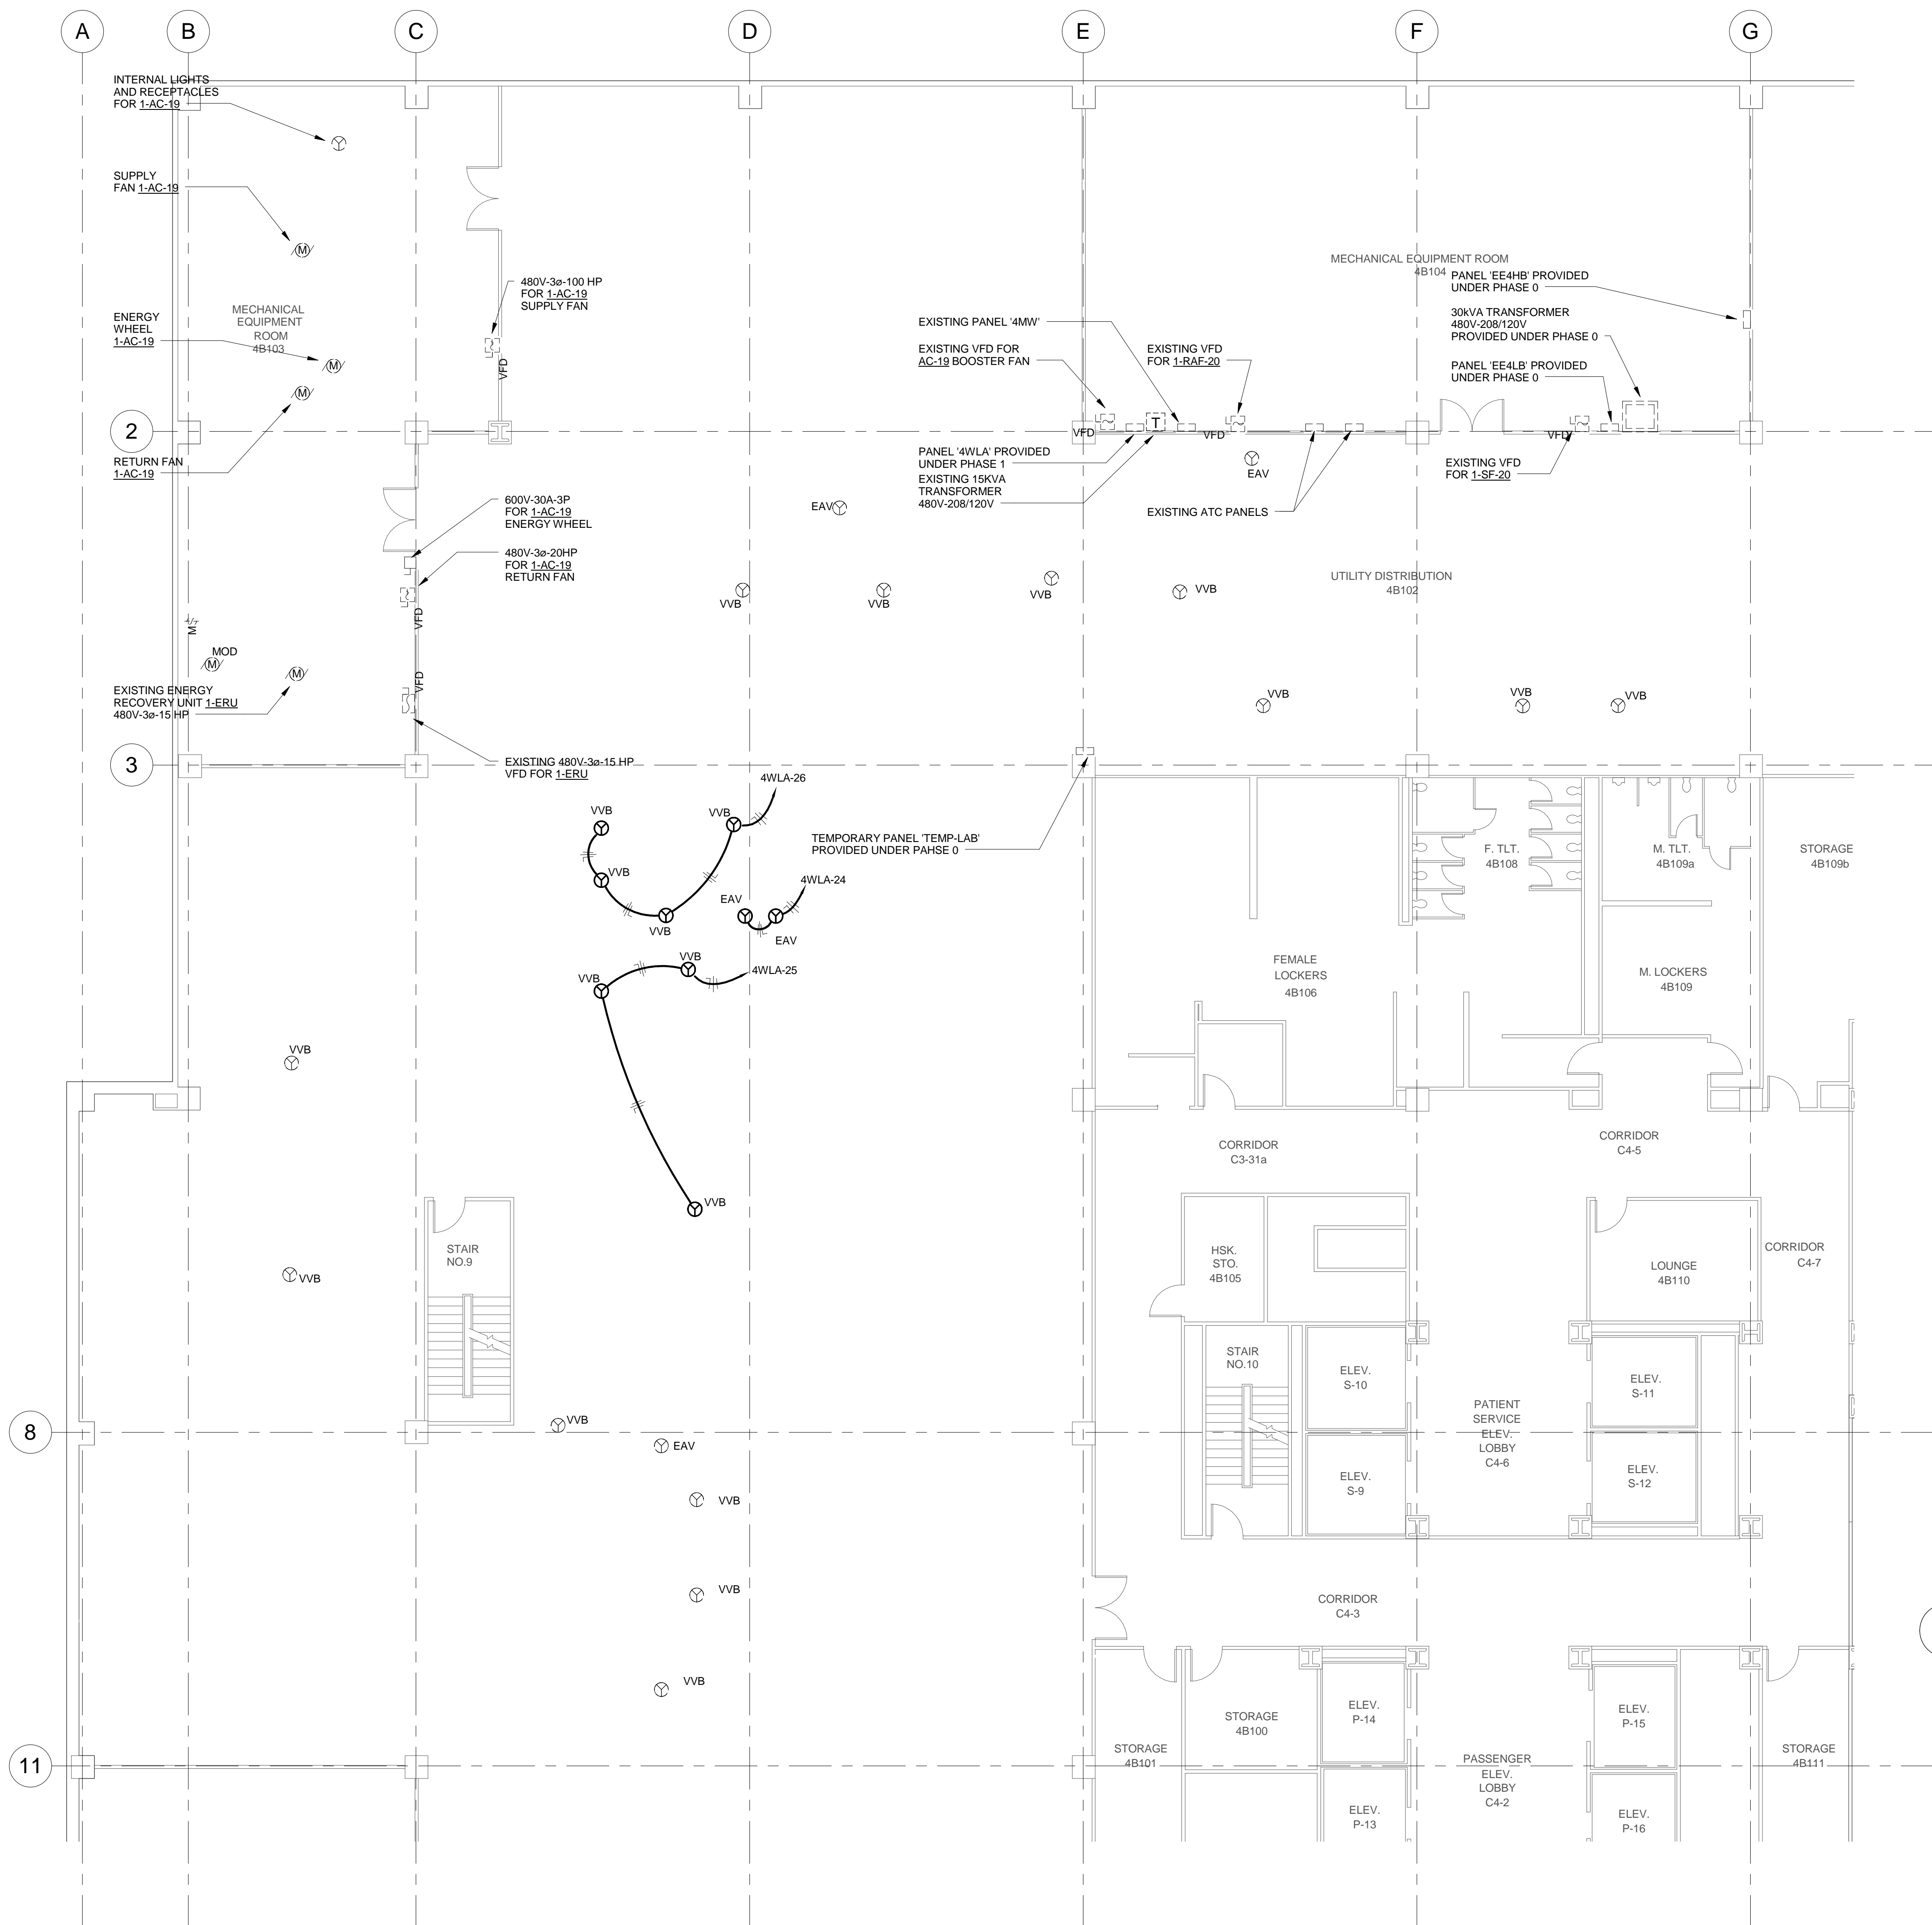

2 FOURTH FLOOR PLAN - PHASE 3 - POWER - AREA B
SCALE: 1/8" = 1'-0"

CONSULTANTS: Lab Consultant: HERA MEP Engineer: H.F. Lenz 230 S. Broad Street, Suite 201 Philadelphia, PA 19102 Tel: (215) 675-3333 Fax: (215) 675-3334 1407 Scalp Avenue Johnstown, PA 15004 Tel: (814) 269-9366 Fax: (814) 269-9301		KEY PLAN: AREA A AREA B BUILDING 2 N		ARCHITECT: ARRAY 2520 Renaissance Boulevard, Suite 110 King of Prussia, PA 19106 t: 610.270.0599 f: 610.270.0995 www.arrayhfs.com		Project Number: 3515 Scale: As indicated		Drawing Title: FOURTH FLOOR PLAN PHASE 3 ELECTRICAL POWER		Project Title: REPLACEMENT OF AC-19 AND LABORATORY RENOVATION		VA Project Number: VA244-P-1786 Building Number: 2		Office of Facilities Management Department of Veterans Affairs	
ISSUED FOR ADDENDUM NO. 1 09/12/12 Revisions: _____ Date: _____						Approved: Project Director		Location: 3900 WOODLAND AVENUE PHILADELPHIA, PA 19104		Drawing Number: ES-233 Dwg. of: _____					