


RFI-04364:
Revised Location

SEE RFI 03691:
Revises location of
waste and vent risers.

RFI-05441: As-built
location is acceptable

1 BLDG 4 FIRST FLOOR PLAN
3/32" = 1'-0"

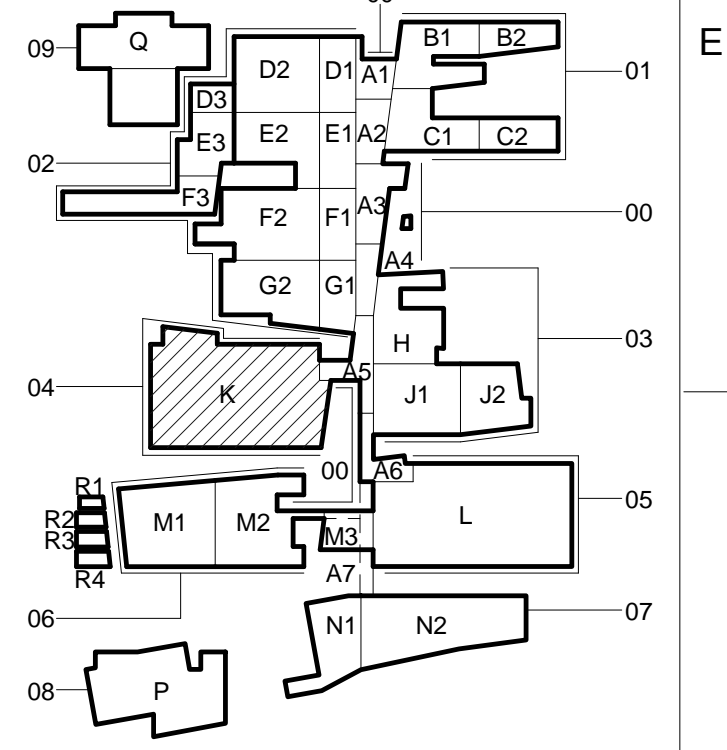

Construction Documents 1

ONE INCH = FORTY FEET (1" = 40')
ONE AND ONE HALF INCHES = ONE FOOT
THREE INCHES = ONE FOOT
THREE QUARTERS INCH = ONE FOOT
ONE HALF INCH = ONE FOOT
ONE QUARTER INCH = ONE FOOT
ONE EIGHT INCH = ONE FOOT
ONE SIXTEENTH INCH = ONE FOOT

CONSULTANTS:

DESMAN ASSOCIATES / PARKING
CODE CONSULTANTS, INC. / CODE CONSULTANT
THE SEXTANT GROUP / AV & ACOUSTICAL
HAMMER DESIGN ASSOCIATES / FOOD SERVICE
PYBURN & ODOM / ABATEMENT



ARCHITECT/ENGINEERS:

studio **NOVA**
SCHRENK & PETERSON CONSULTING ENGINEERS / CIVIL
KORDA/NEMETH ENGINEERS / STRUCTURAL
BR+A CONSULTING ENGINEERS / MECH, ELECT, PLUMBING, LOW VOLTAGE
ARCHITECTURAL ENGINEERS, INC. / PLUMBING
SCALES ASSOCIATES / FIRE PROTECTION

DRAWING TITLE
BLDG 4 FIRST FLOOR PLUMBING PLAN

APPROVED: PROJECT DIRECTOR

PROJECT TITLE
SLVHCS REPLACEMENT MEDICAL
CENTER PROJECT

LOCATION
NEW ORLEANS, LOUISIANA

 
PROJECT NUMBER
629-HS2-401

BUILDING NUMBER
4

DOCUMENT SET PACKAGE
EWP_04

DRAWING NUMBER
4PL101

**OFFICE OF
CONSTRUCTION
AND FACILITIES
MANAGEMENT**



REVISIONS:	DATE
13 BULL 107	2/3/2014
6 RFI 00375.1	6/22/1213
5 Addendum 5	11/30/11
2 Addendum 2	07/29/11