



REVISIONS	DATE

DATE	DATE	DATE	DATE

SERVICE PRE-APPROVAL	
CUSTOMER'S SERVICE CHIEF	
1331	
00 / 001	

CAD FILE NAME
MATHER SITE PLAN

DEPARTMENT
OF
VETERANS AFFAIRS

VA Northern California
Health Care System

PROJECT TITLE


MATHER SITE PLAN

BUILDING NO.
SITE
LOCATION
Mather
SCALE
NOT TO SCALE
CHECKED BY

DRAWING TITLE
MATHER SITE
DRAWN BY


DATE
MARCH 22, 2007
VA PROJ. NO.
DRAWING NO.
DWG. 1 OF 01

- BUILDING LEGEND**
- 650 HOSPITAL
 - 652 WAREHOUSE AND STORAGE
 - 700 HOSPITAL AND CLINIC
 - 701 GENERATOR BUILDING
 - 702 ENERGY CENTER
 - 707 NCHCS ADMINISTRATION
 - 720 EYE CLINIC/ONCOLOGY OFFICES
 - 722 MEDICAL OFFICES
 - 722A EMPLOYEE HEALTH OFFICES
 - 728 THERAPY SERVICES/POLICE BUILDING
 - 730 MAINTENANCE SHOPS
 - 731 MAINTENANCE SHOPS
 - 798 ADMINISTRATION OFFICES
 - 799 ENGINEERING OFFICES
 - 800 ADMINISTRATION OFFICES
 - 801 ADMINISTRATION/MEDICAL OFFICES
 - 802 SOCIAL WORK SERVICES
 - 803 X-RAY STORAGE
 - 805 OFFICES
 - 806 MEDICAL OFFICES
 - 807 RESERVES OFFICES
 - 810 ADMINISTRATION OFFICES
 - 811 ADMINISTRATION OFFICES

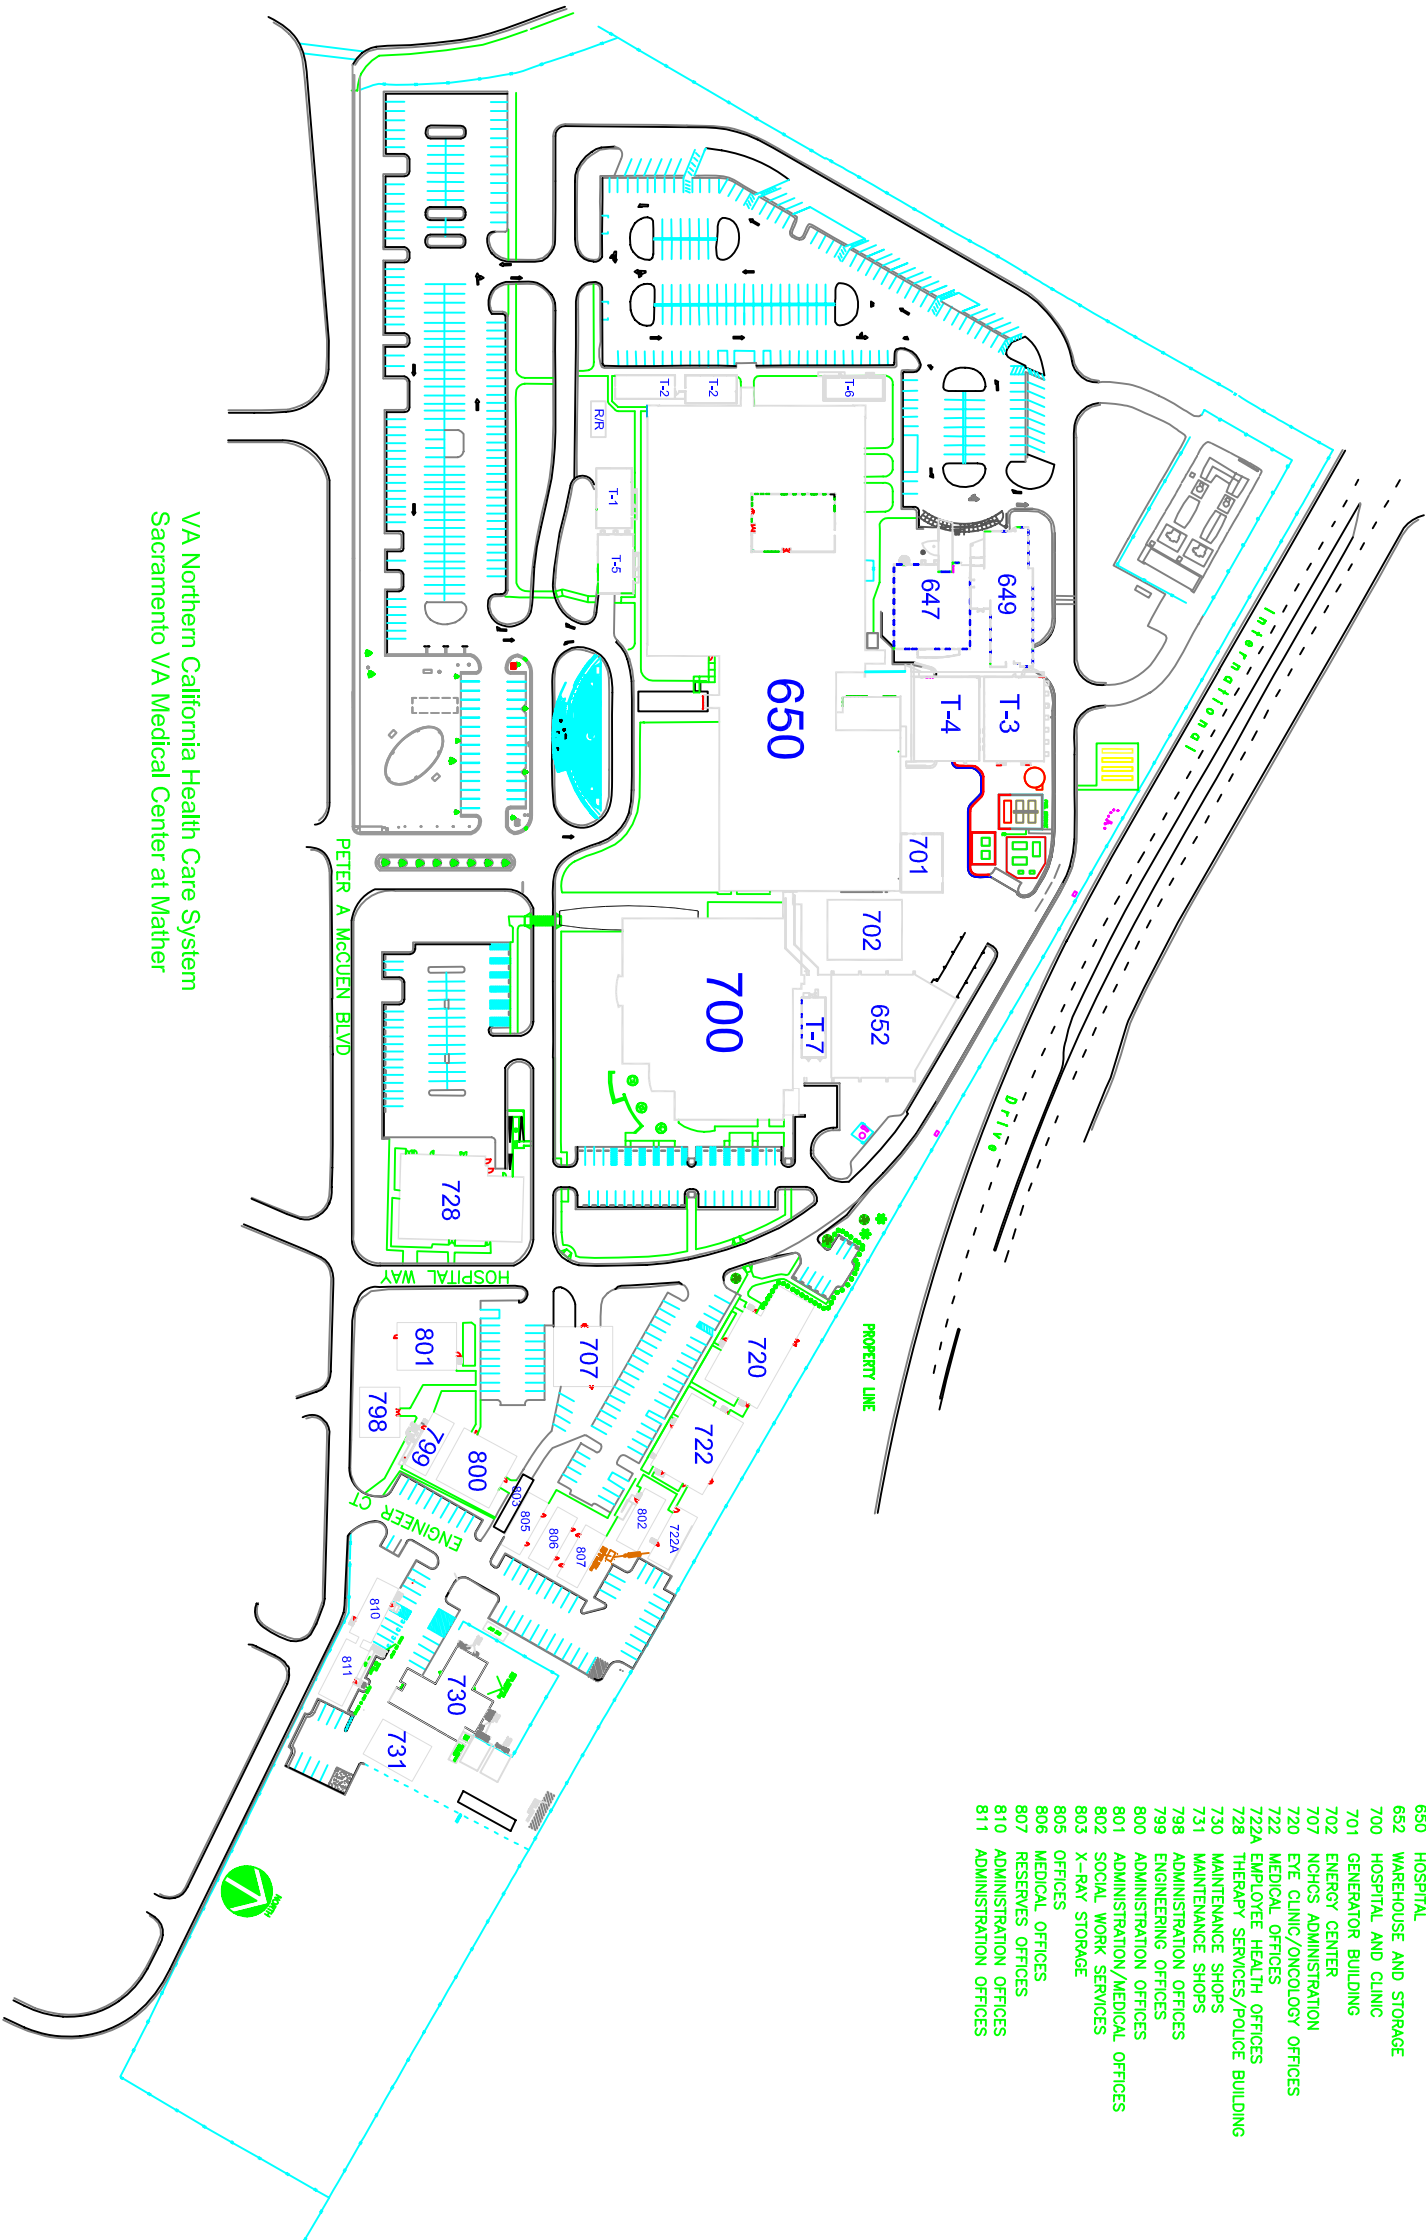

VA Northern California Health Care System
Sacramento VA Medical Center at Mather

DEPT OF VETERANS AFFAIRS

NCHCS



MATHER SITE PLAN

