



SECOND FLOOR PLAN

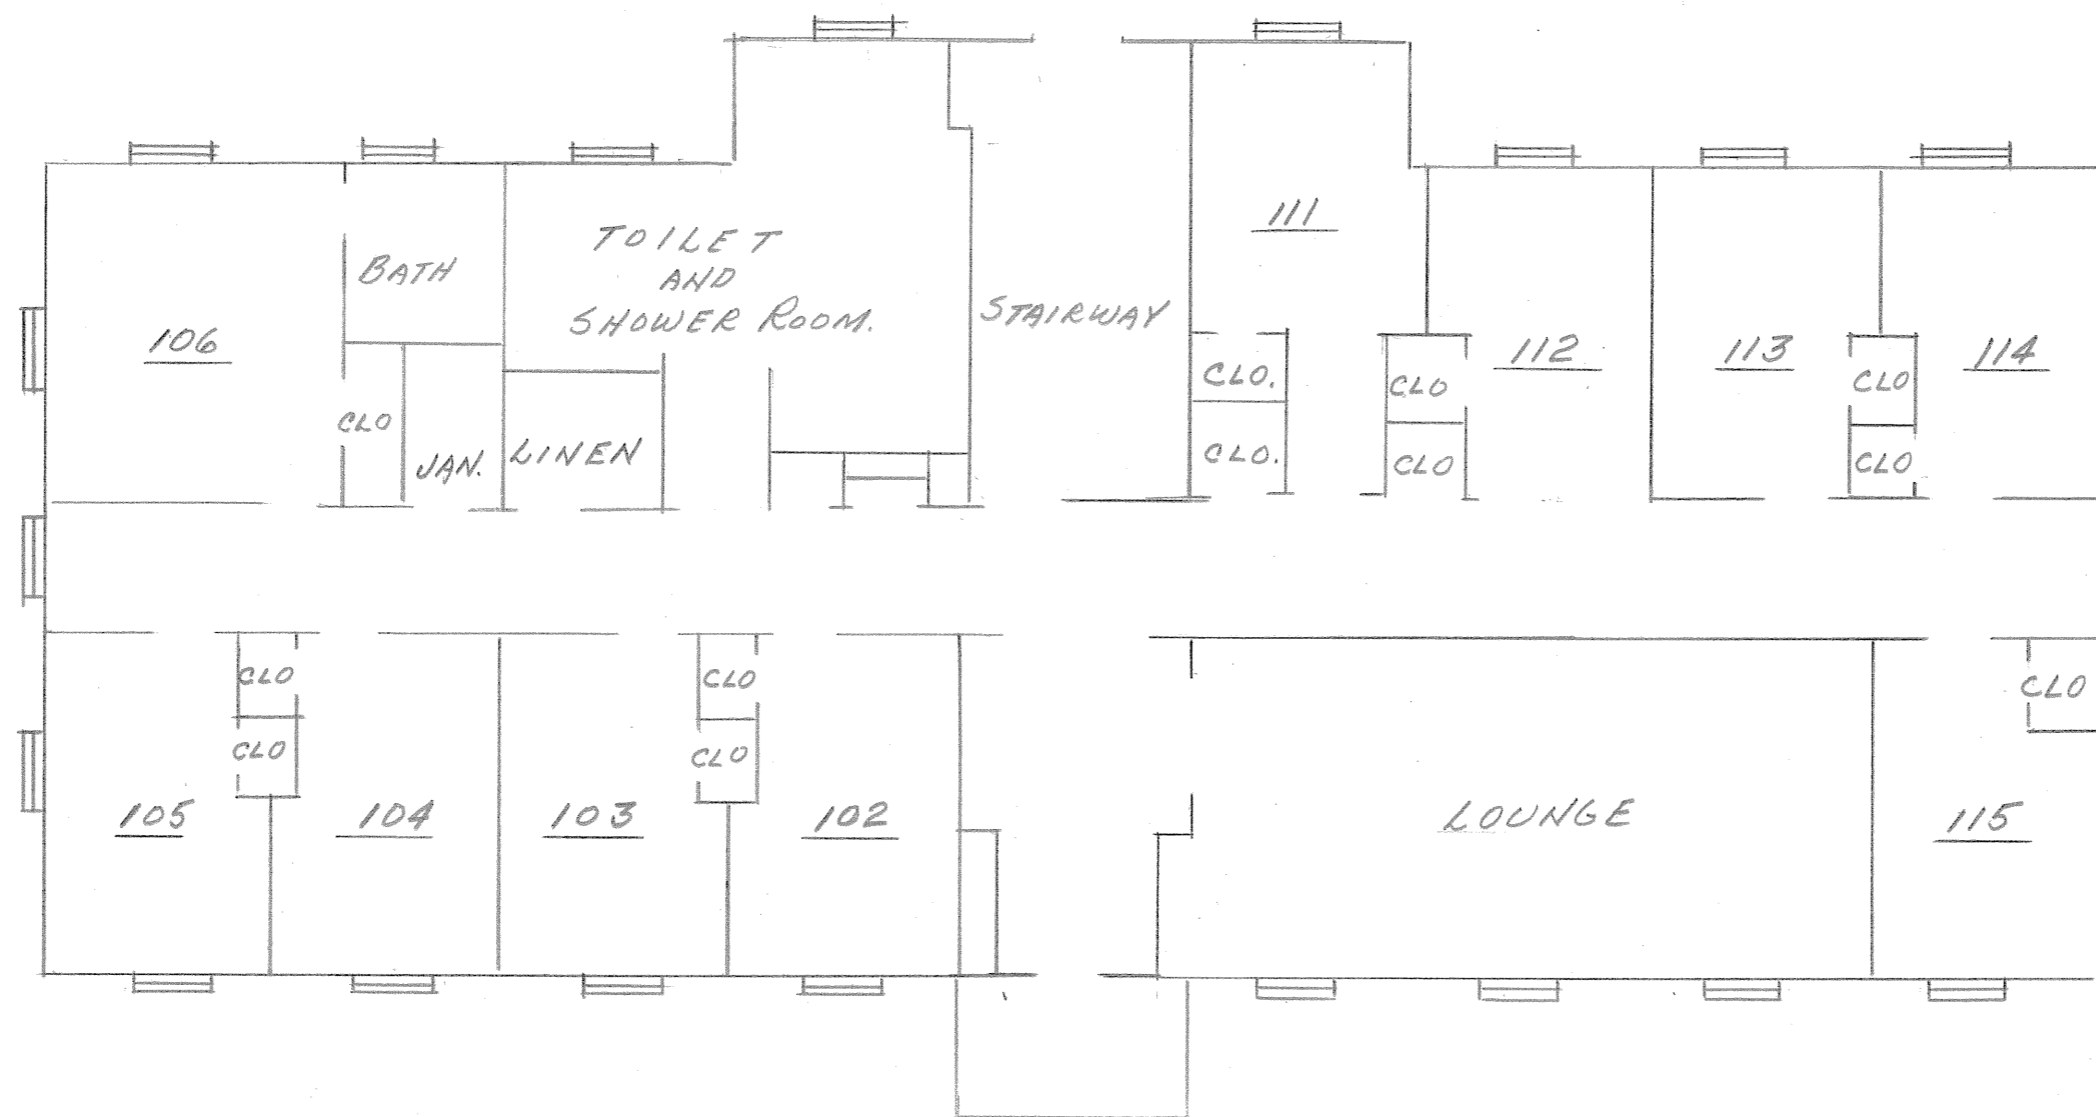

FIRST FLOOR PLAN


REVISIONS			BLDG. #27		
NO.	DATE	BY			
1					
2					
3			DRAWN BY	SCALE 1/8"=1'	MATERIAL
4			CHK'D	DATE	DRAWING NO.
5			TRACED	APP'D	

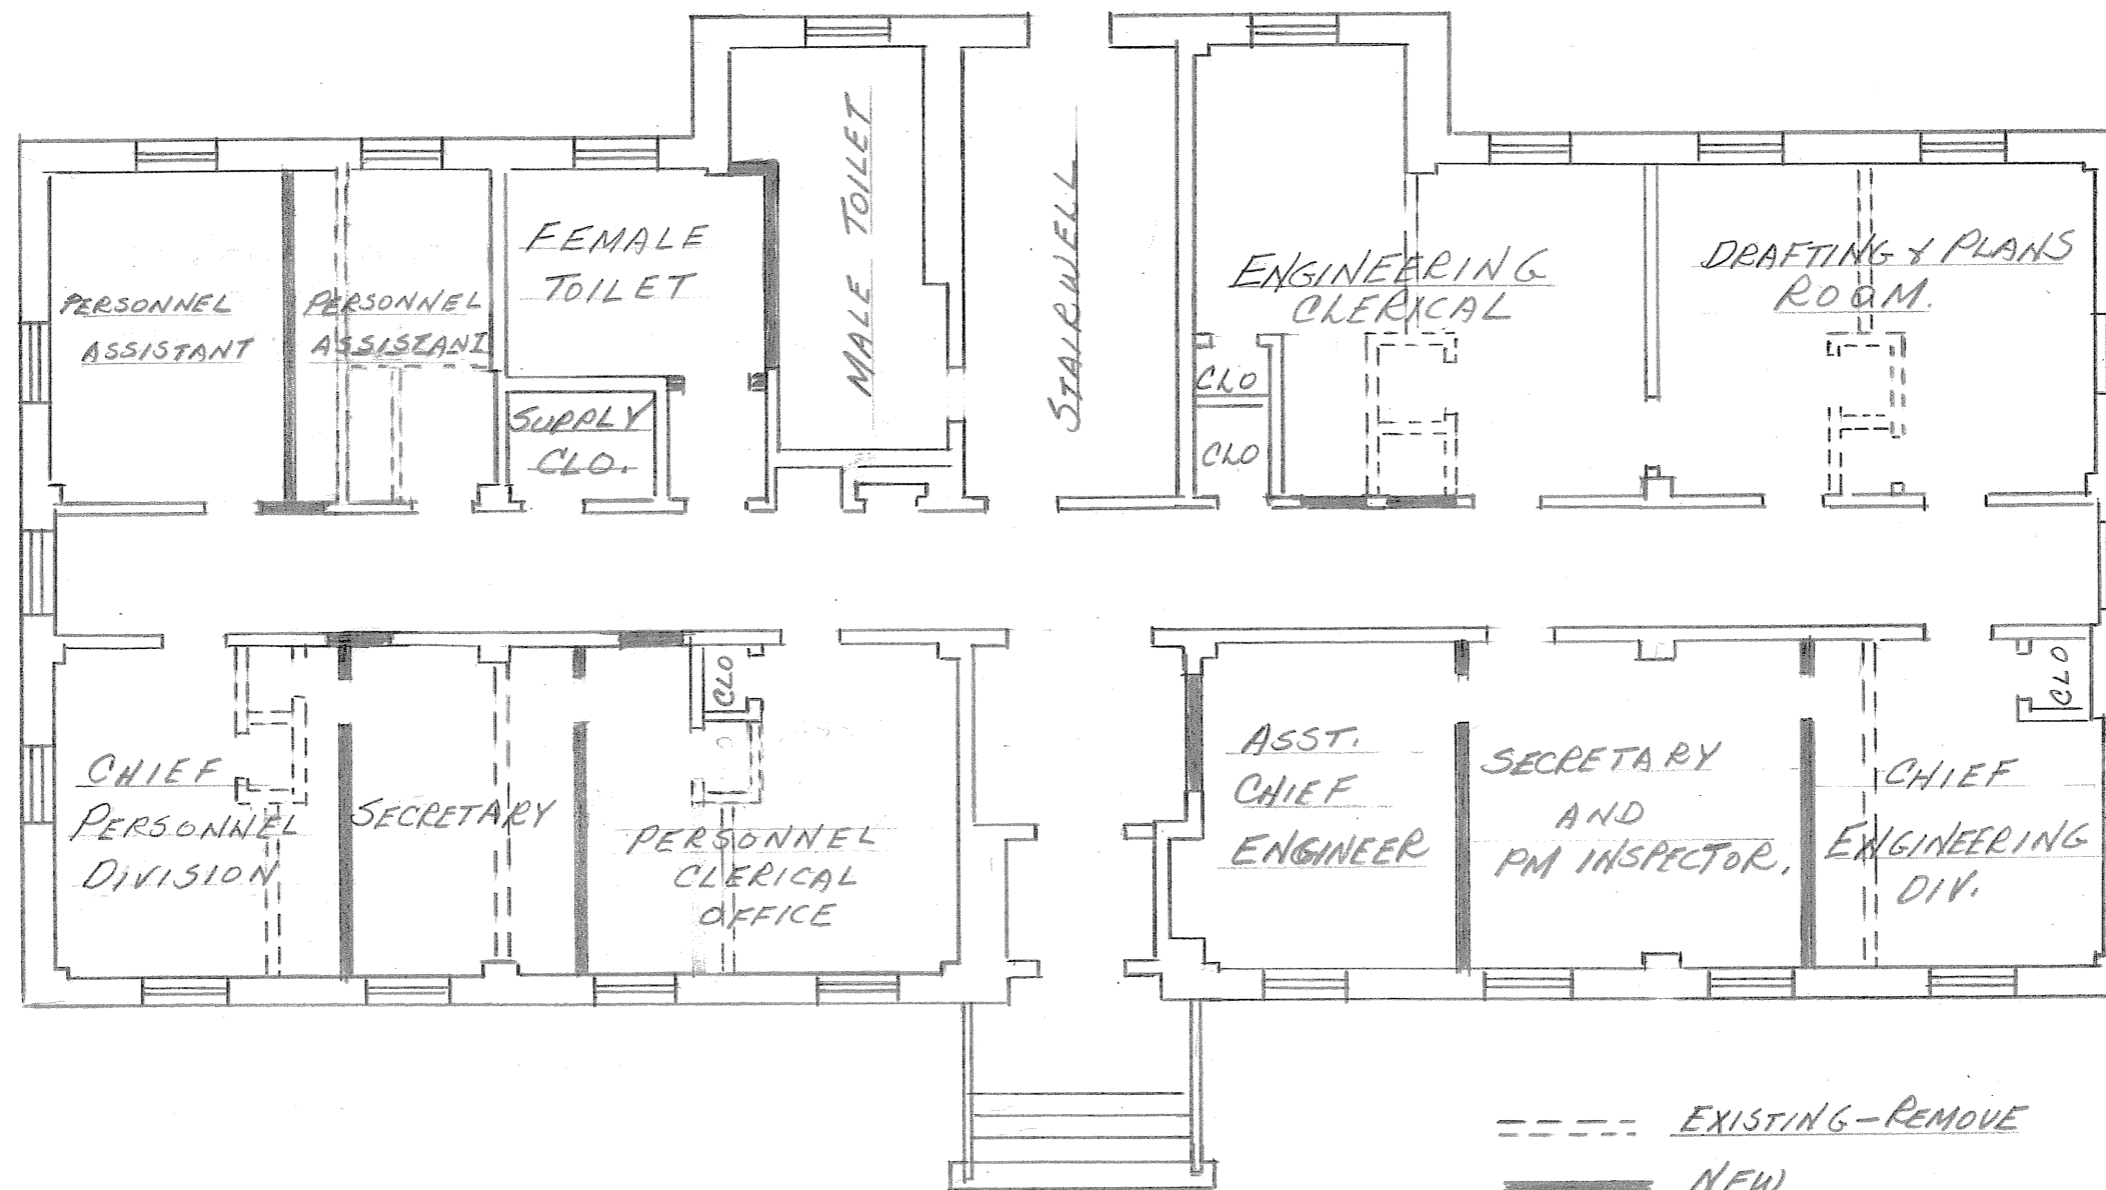

FIRST FLOOR PLAN
 BLDG No 27
 SCALE 1/8" = 1'-0"

- EXISTING-REMOVE
- NEW
- ==== EXISTING-REMAIN



CONVERT BLDG #27
 TO OFFICE SPACE
 VAH. LEBANON, PA

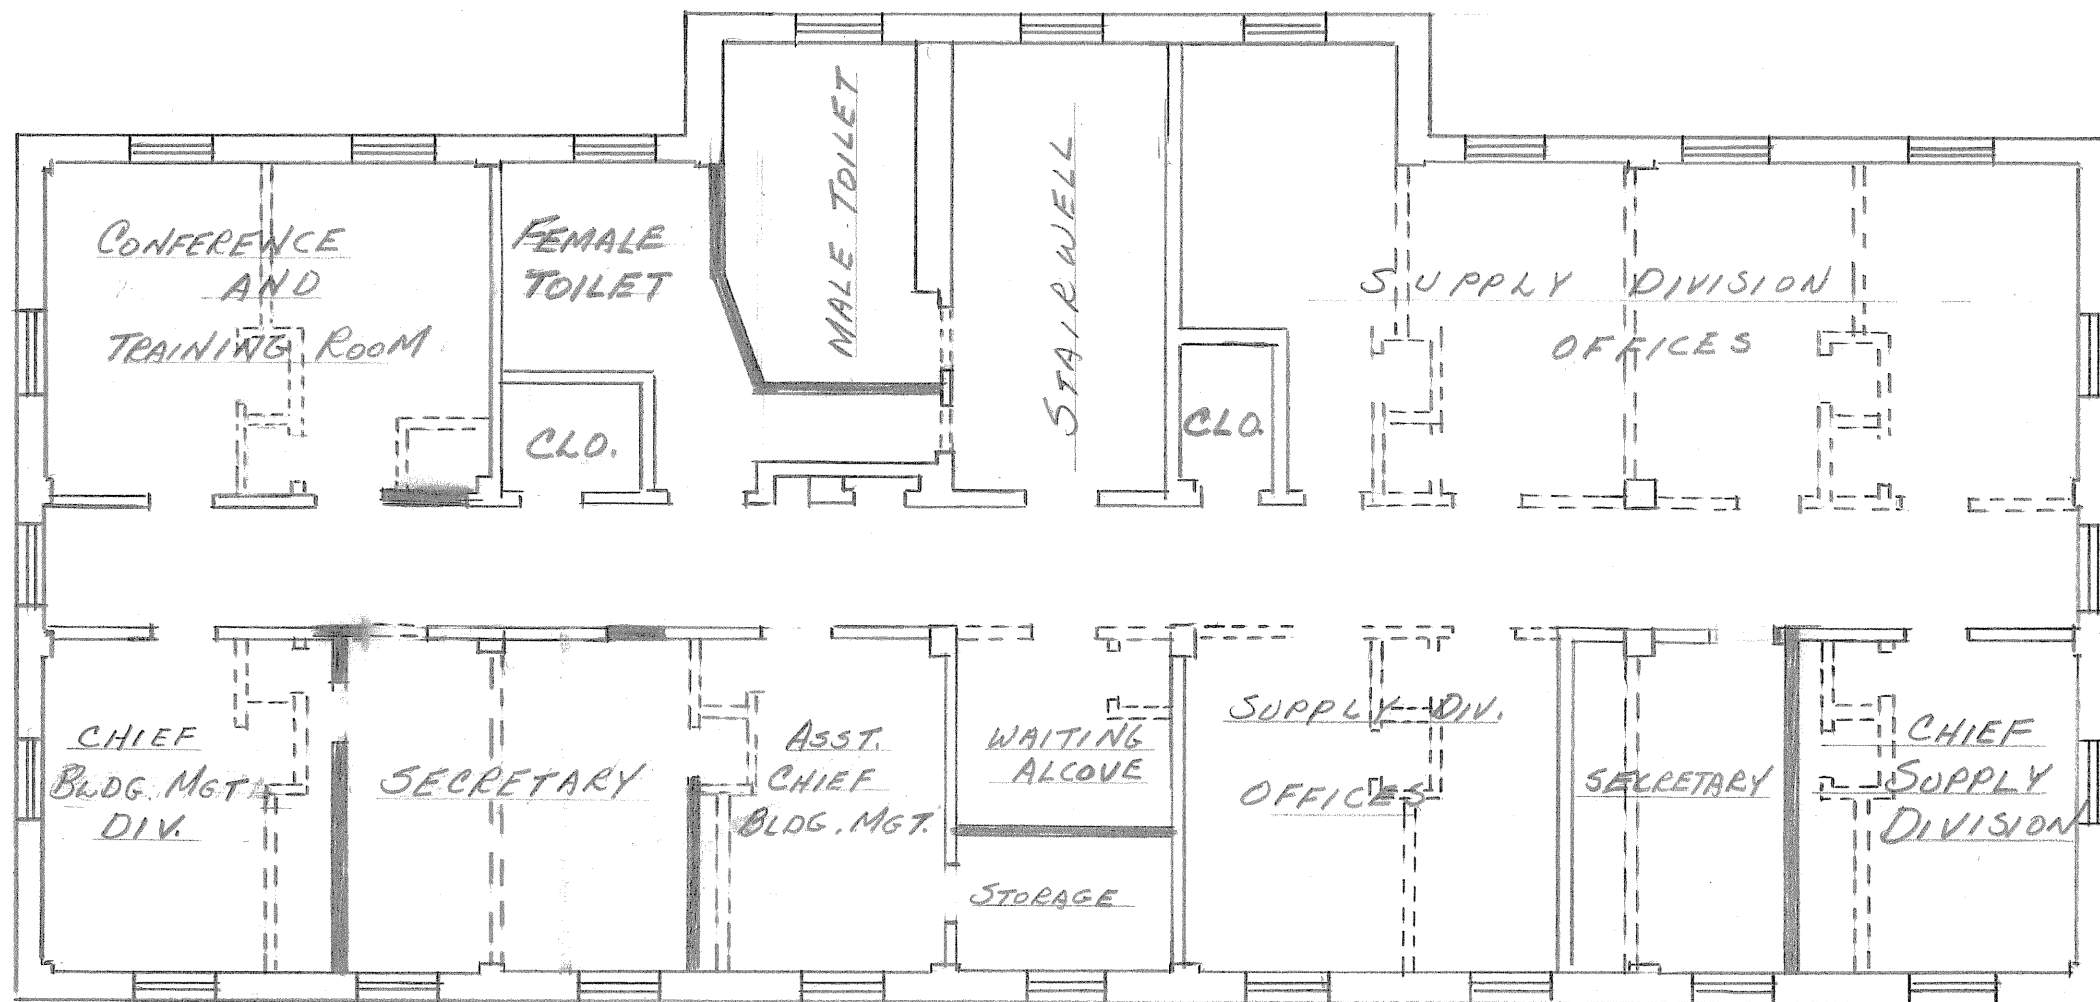

SECOND FLOOR PLAN
 BLDG. #27
 SCALE 1/8" = 1'-0"

--- EXISTING - REMOVE
 ——— NEW
 = = = EXISTING - REMAIN

CONVERT BLDG. #27
 TO OFFICE SPACE
 VAH, LEBANON PA.

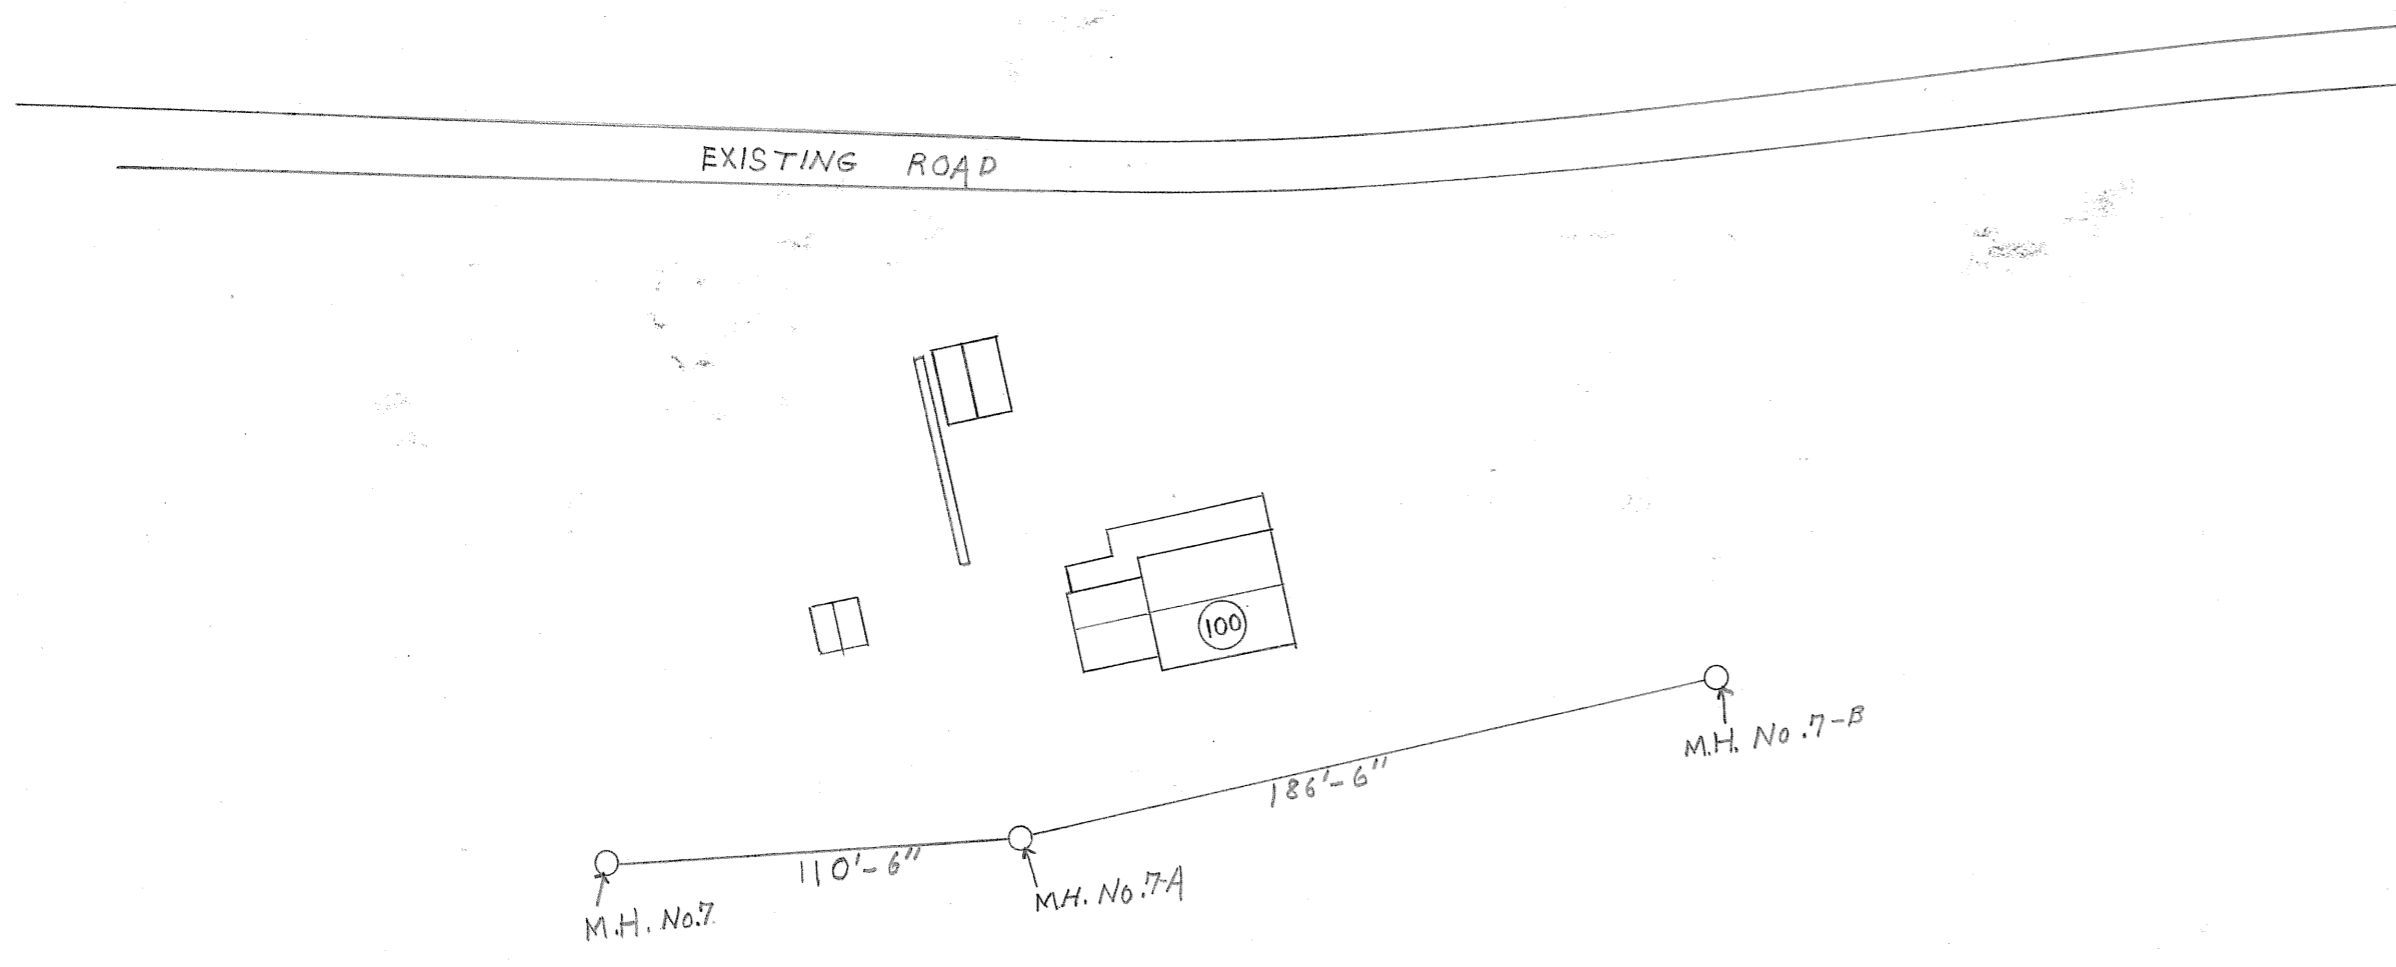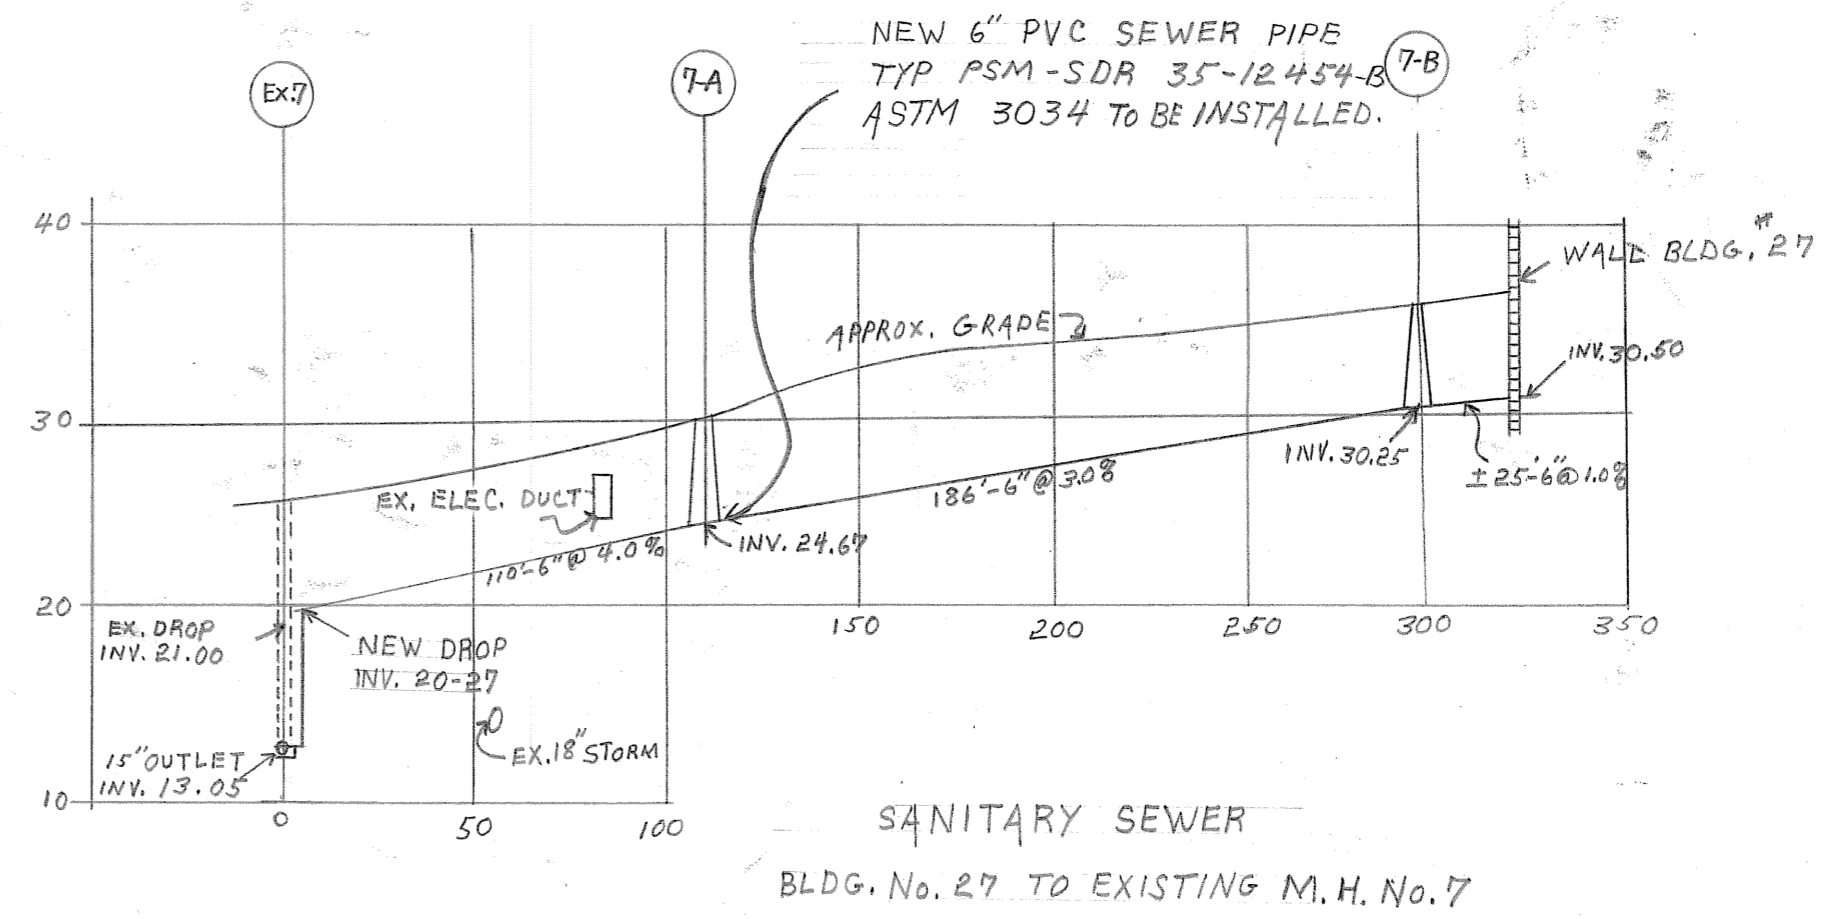

REPLACE SAITARY SEWER LINE			
SCALE	REVISIONS	BY	DATE
DATE MAY 30, 1980			
DR'N J.C.B.	CKD. HSA		
AP'VD.			
TITLE BLDG. 100 TO 27	NO. 4-27L		