
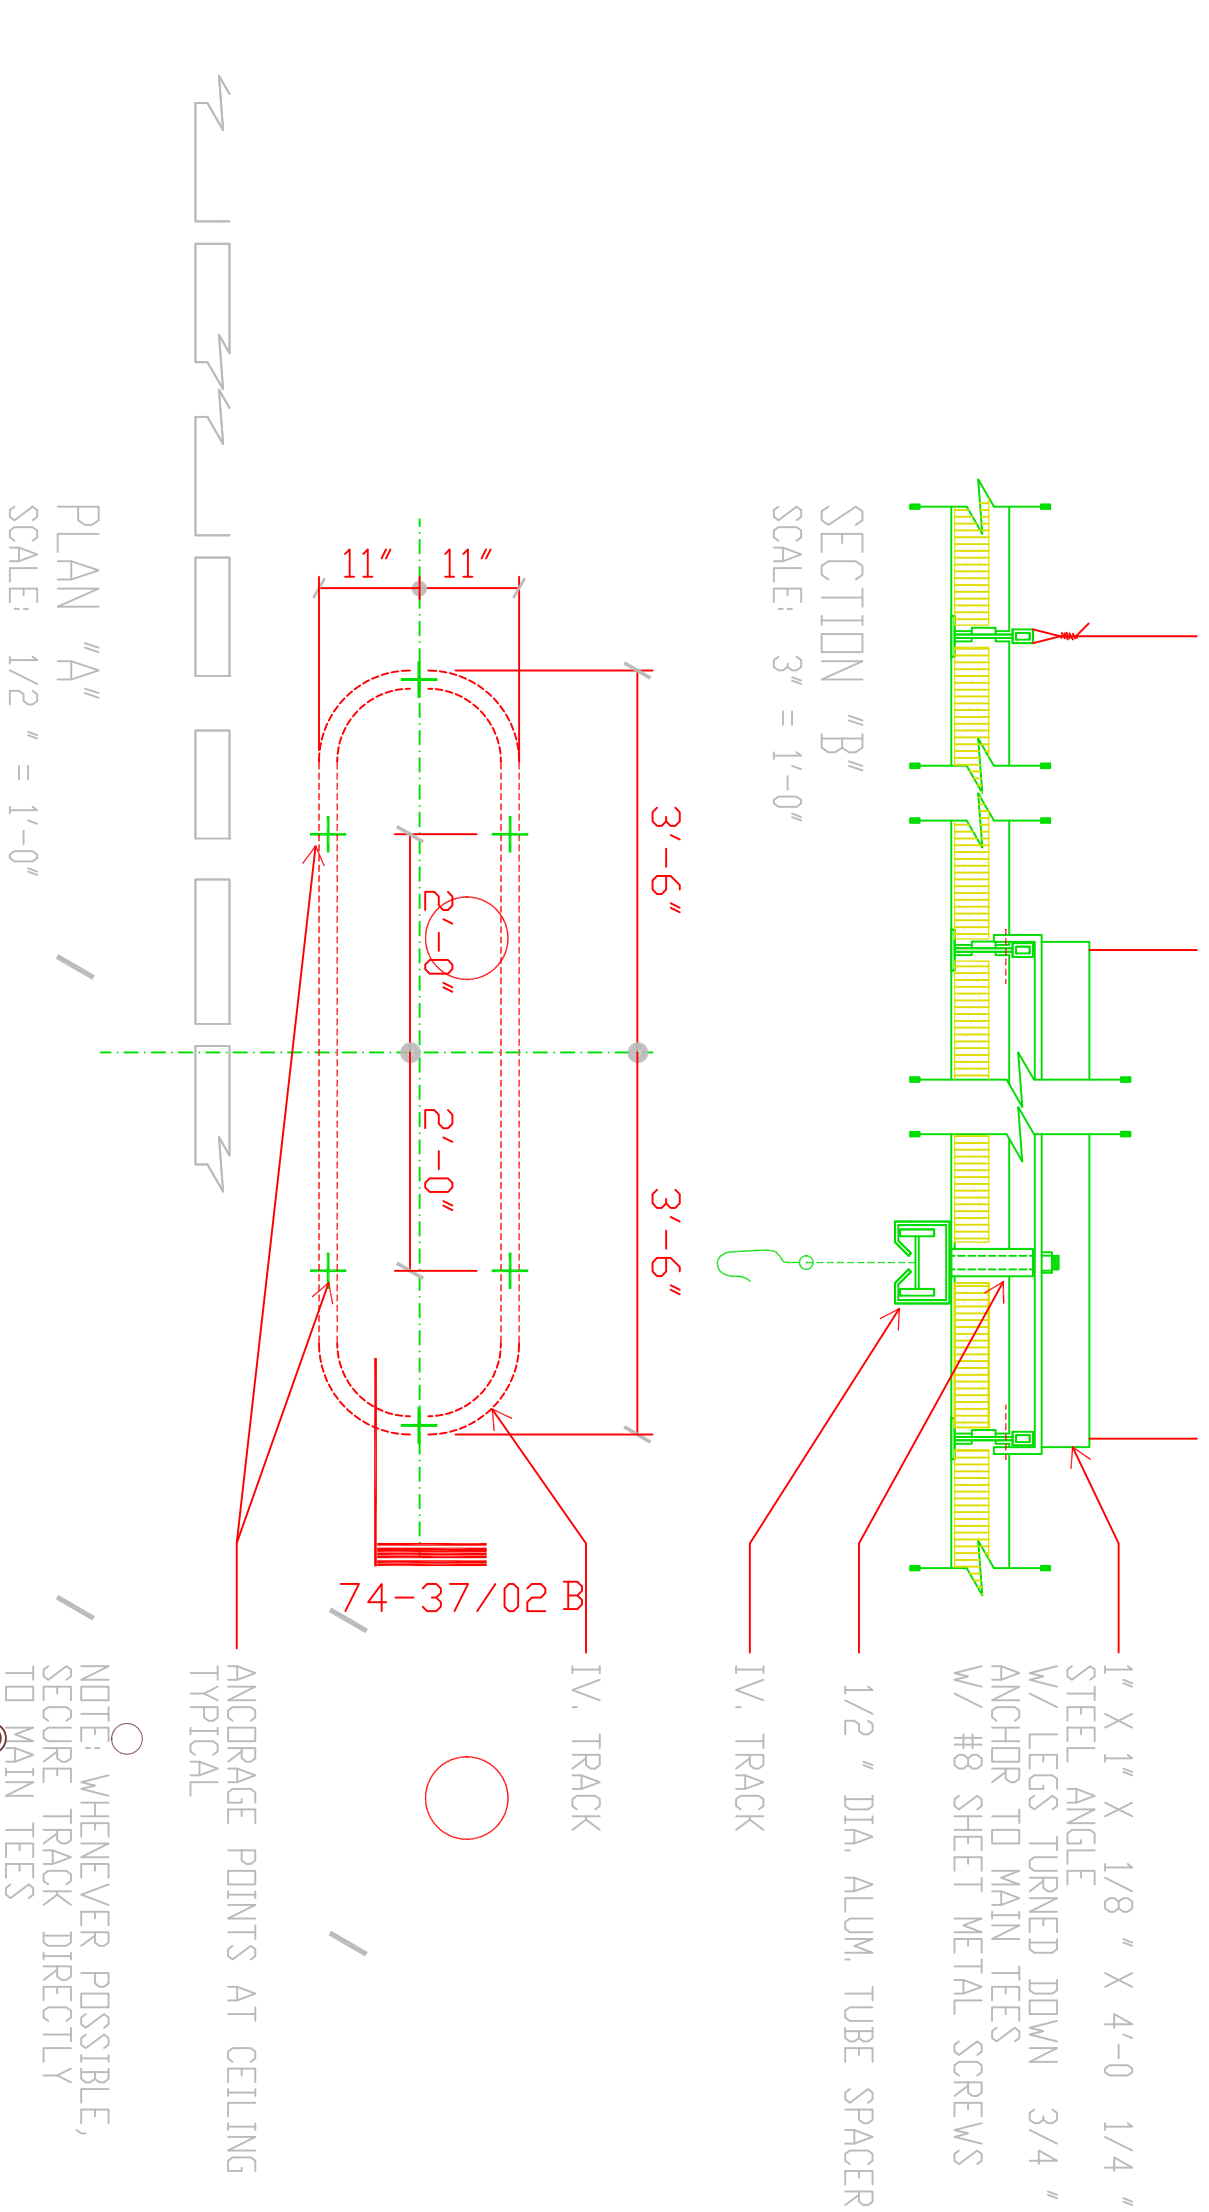
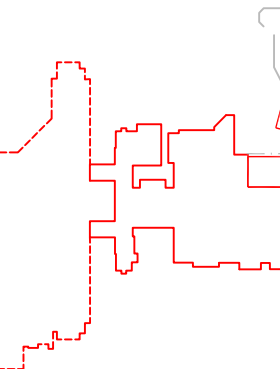



AUDIT	B21						
OVERLAY							
%SCREEN /COLOR							

AMENDMENT 1 1. DIMENSIONAL CODED Revisions	16 AUG. 93 Date
--	--------------------

Architect	Engineer
-----------	----------

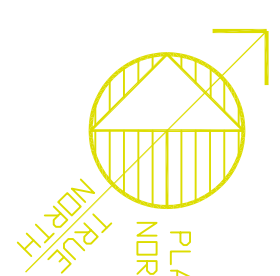

Drawing Title REFLECTED CEILING PLAN 1/8" LEVEL ONE AREA D		Project Title SPINAL CORD INJURY CENTER		Date 07/26/95	ISSUED 2300 ES987
Approved Area Project Manager		Building Number 74		Checked MA	Drawn TMC
		Location VA MEDICAL CENTER DALLAS, TEXAS		DRAWING NO. 74-37R	
				DIV. DF	



Office of Facilities

Department of
Veterans Affairs