




HH MCGUIRE  
VA MEDICAL CENTER  
RICHMOND, VIRGINIA

OFFICE RENOVATION  
PROJECT NO. 652-19-901

DRAWING INDEX:

DWG #	DWG TITLE	SHEET #
CS	COVER SHEET & DRAWING INDEX	1 OF 7
A-01	EXISTING CONDITIONS	2 OF 7
A-02	DEMO PLAN	3 OF 7
A-03	NEW CONSTRUCTION	4 OF 7
A-04	REFLECTED CEILING PLAN	5 OF 7
A-05	FINISH PLAN	6 OF 7
A-06	ELECTRICAL / DATA PLAN	7 OF 7

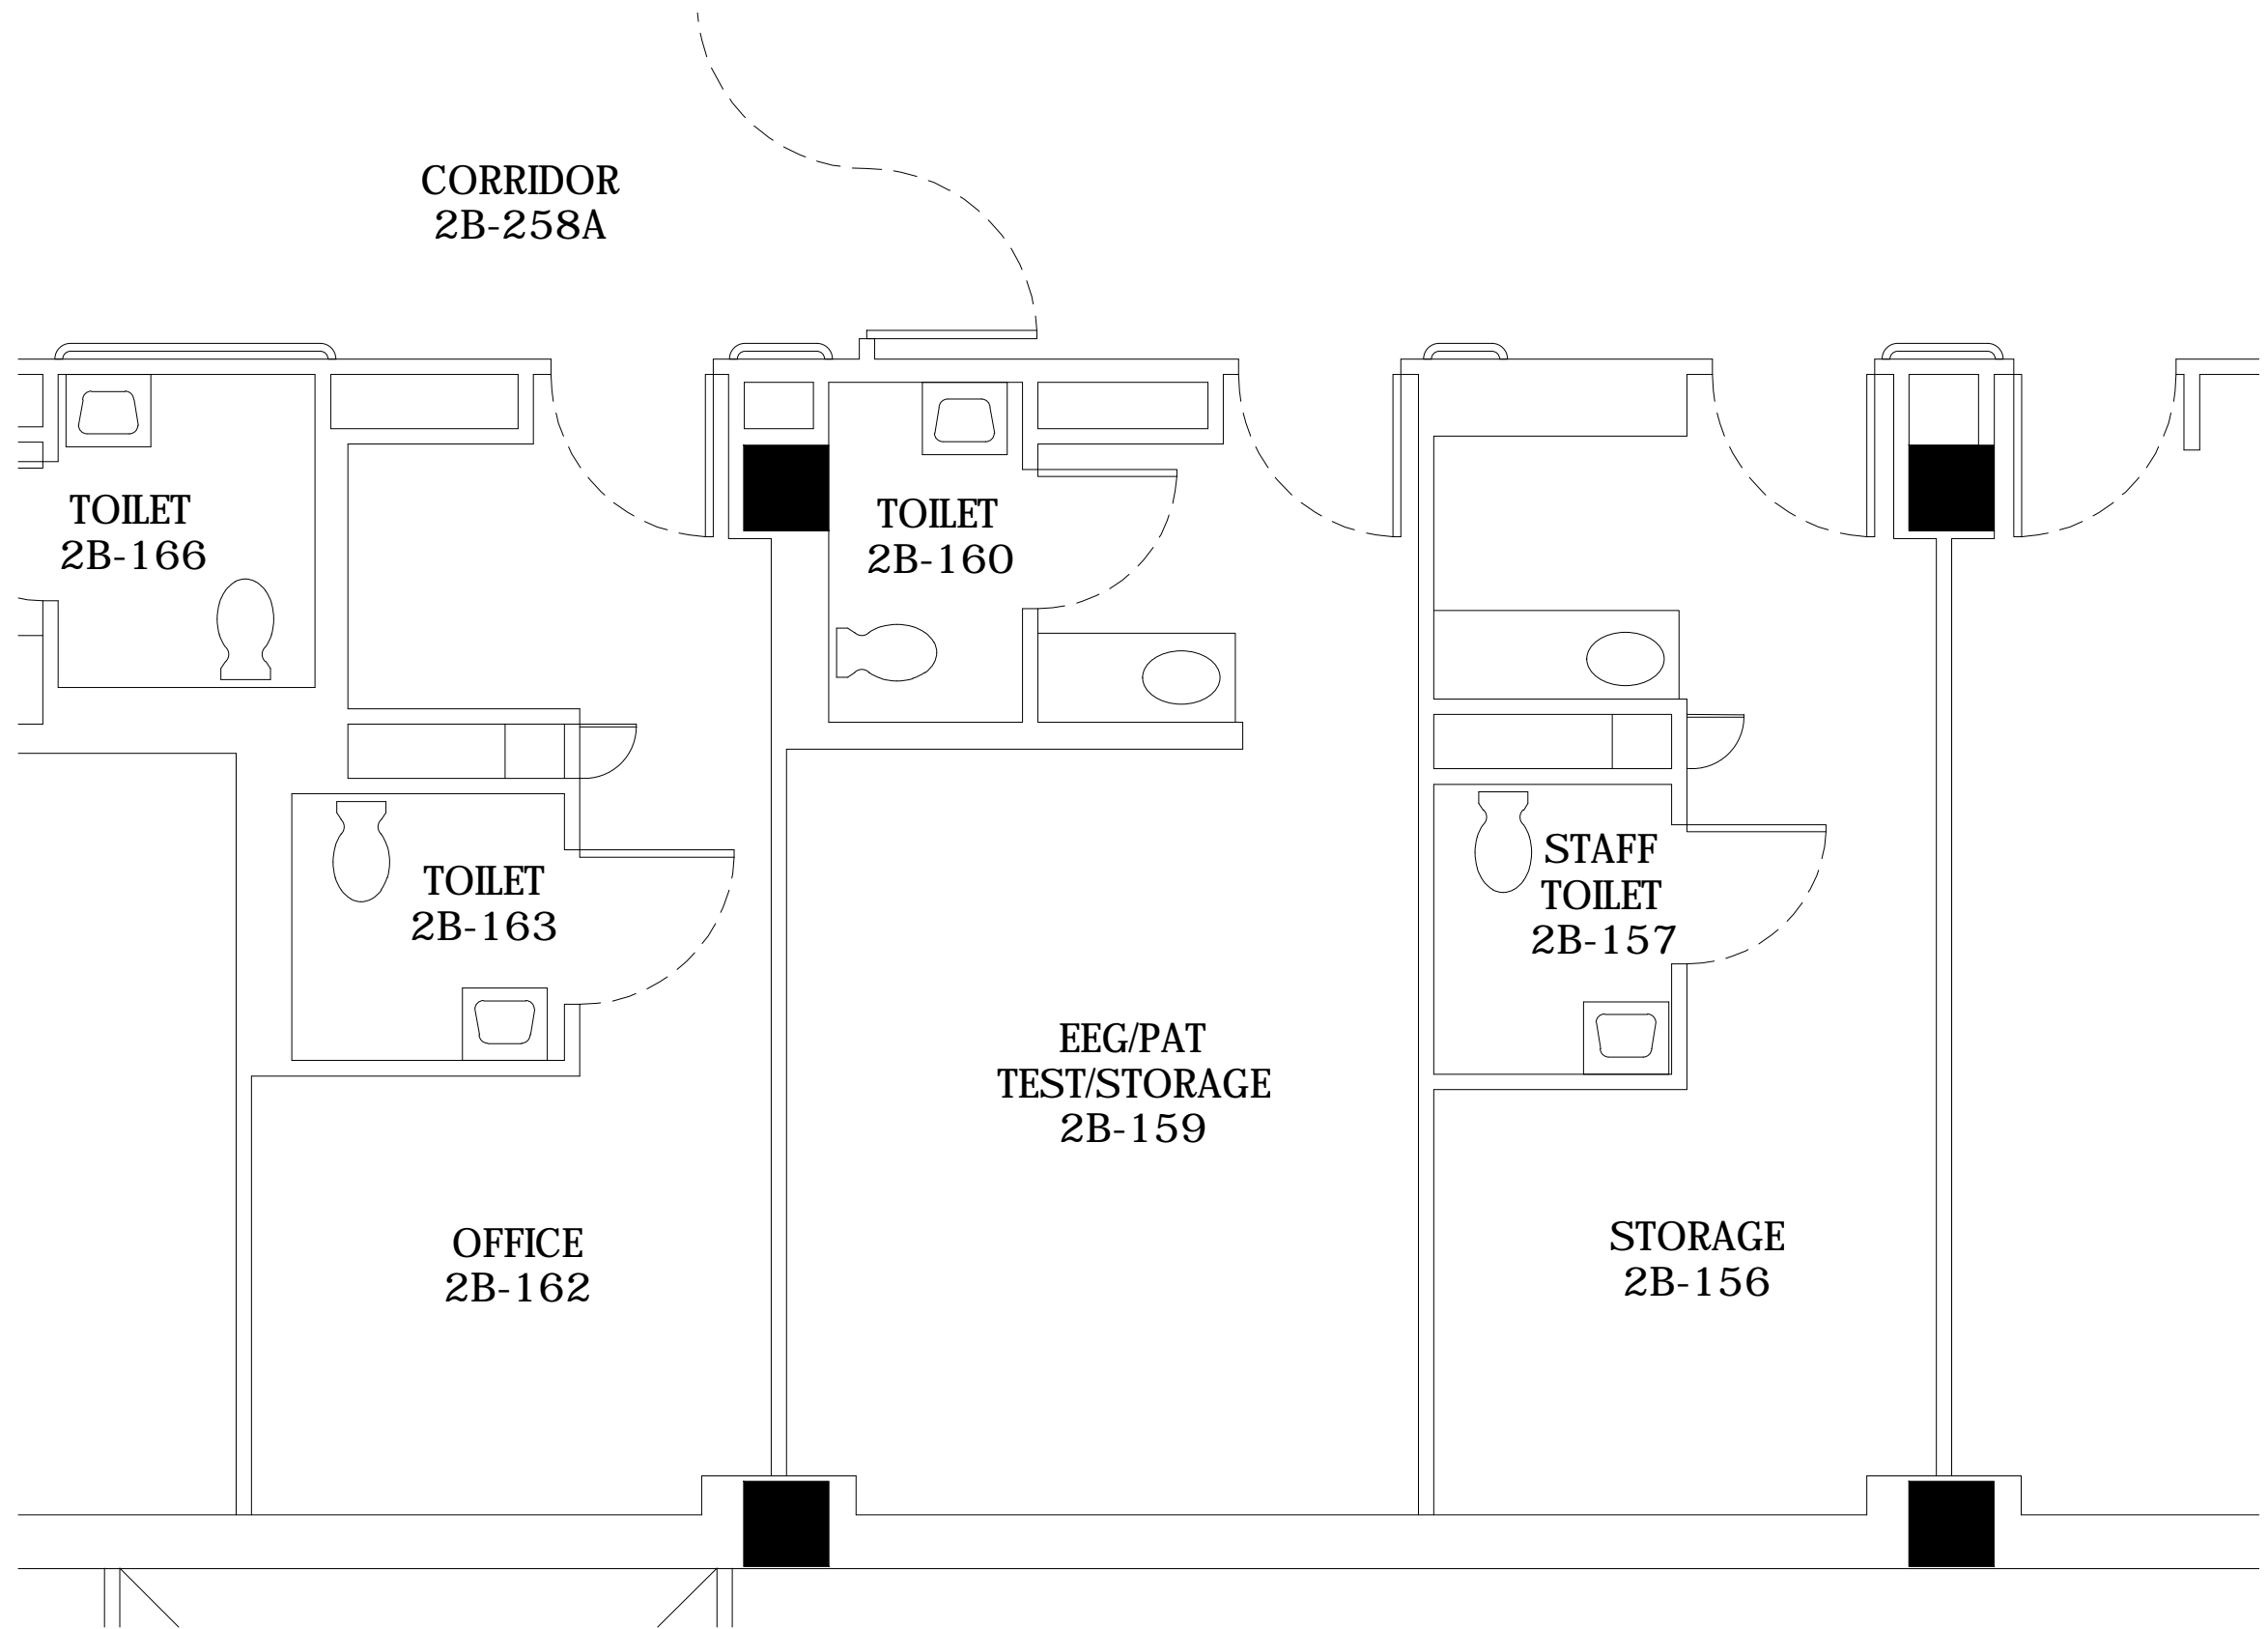



Revisions	Date	Approved: Service Chief	Date
		Approved: Engineering Technician	Date
		Approved: Trade Supervisor	Date
		Approved: Engineering Service Chief	Date


Drawing Title	
EXISTING CONDITIONS	
Approved: Biomedical Engineer	Date
Approved: OIT Service	Date

Project Title		
RENOVATE OFFICES		
Bldg. No.	Checked	Drawn
500-02		###
Location		Dwg No.
VAMC, RICHMOND, VA.		A-01

Date	
03-21-2019	
Project No.	
652-19-901	
Scale	
1/4" = 1'-0"	

Veterans Health Agency	
Department of Veterans Affairs	

 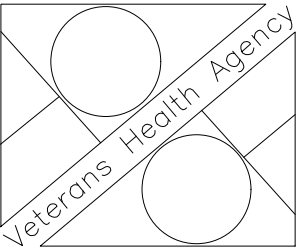

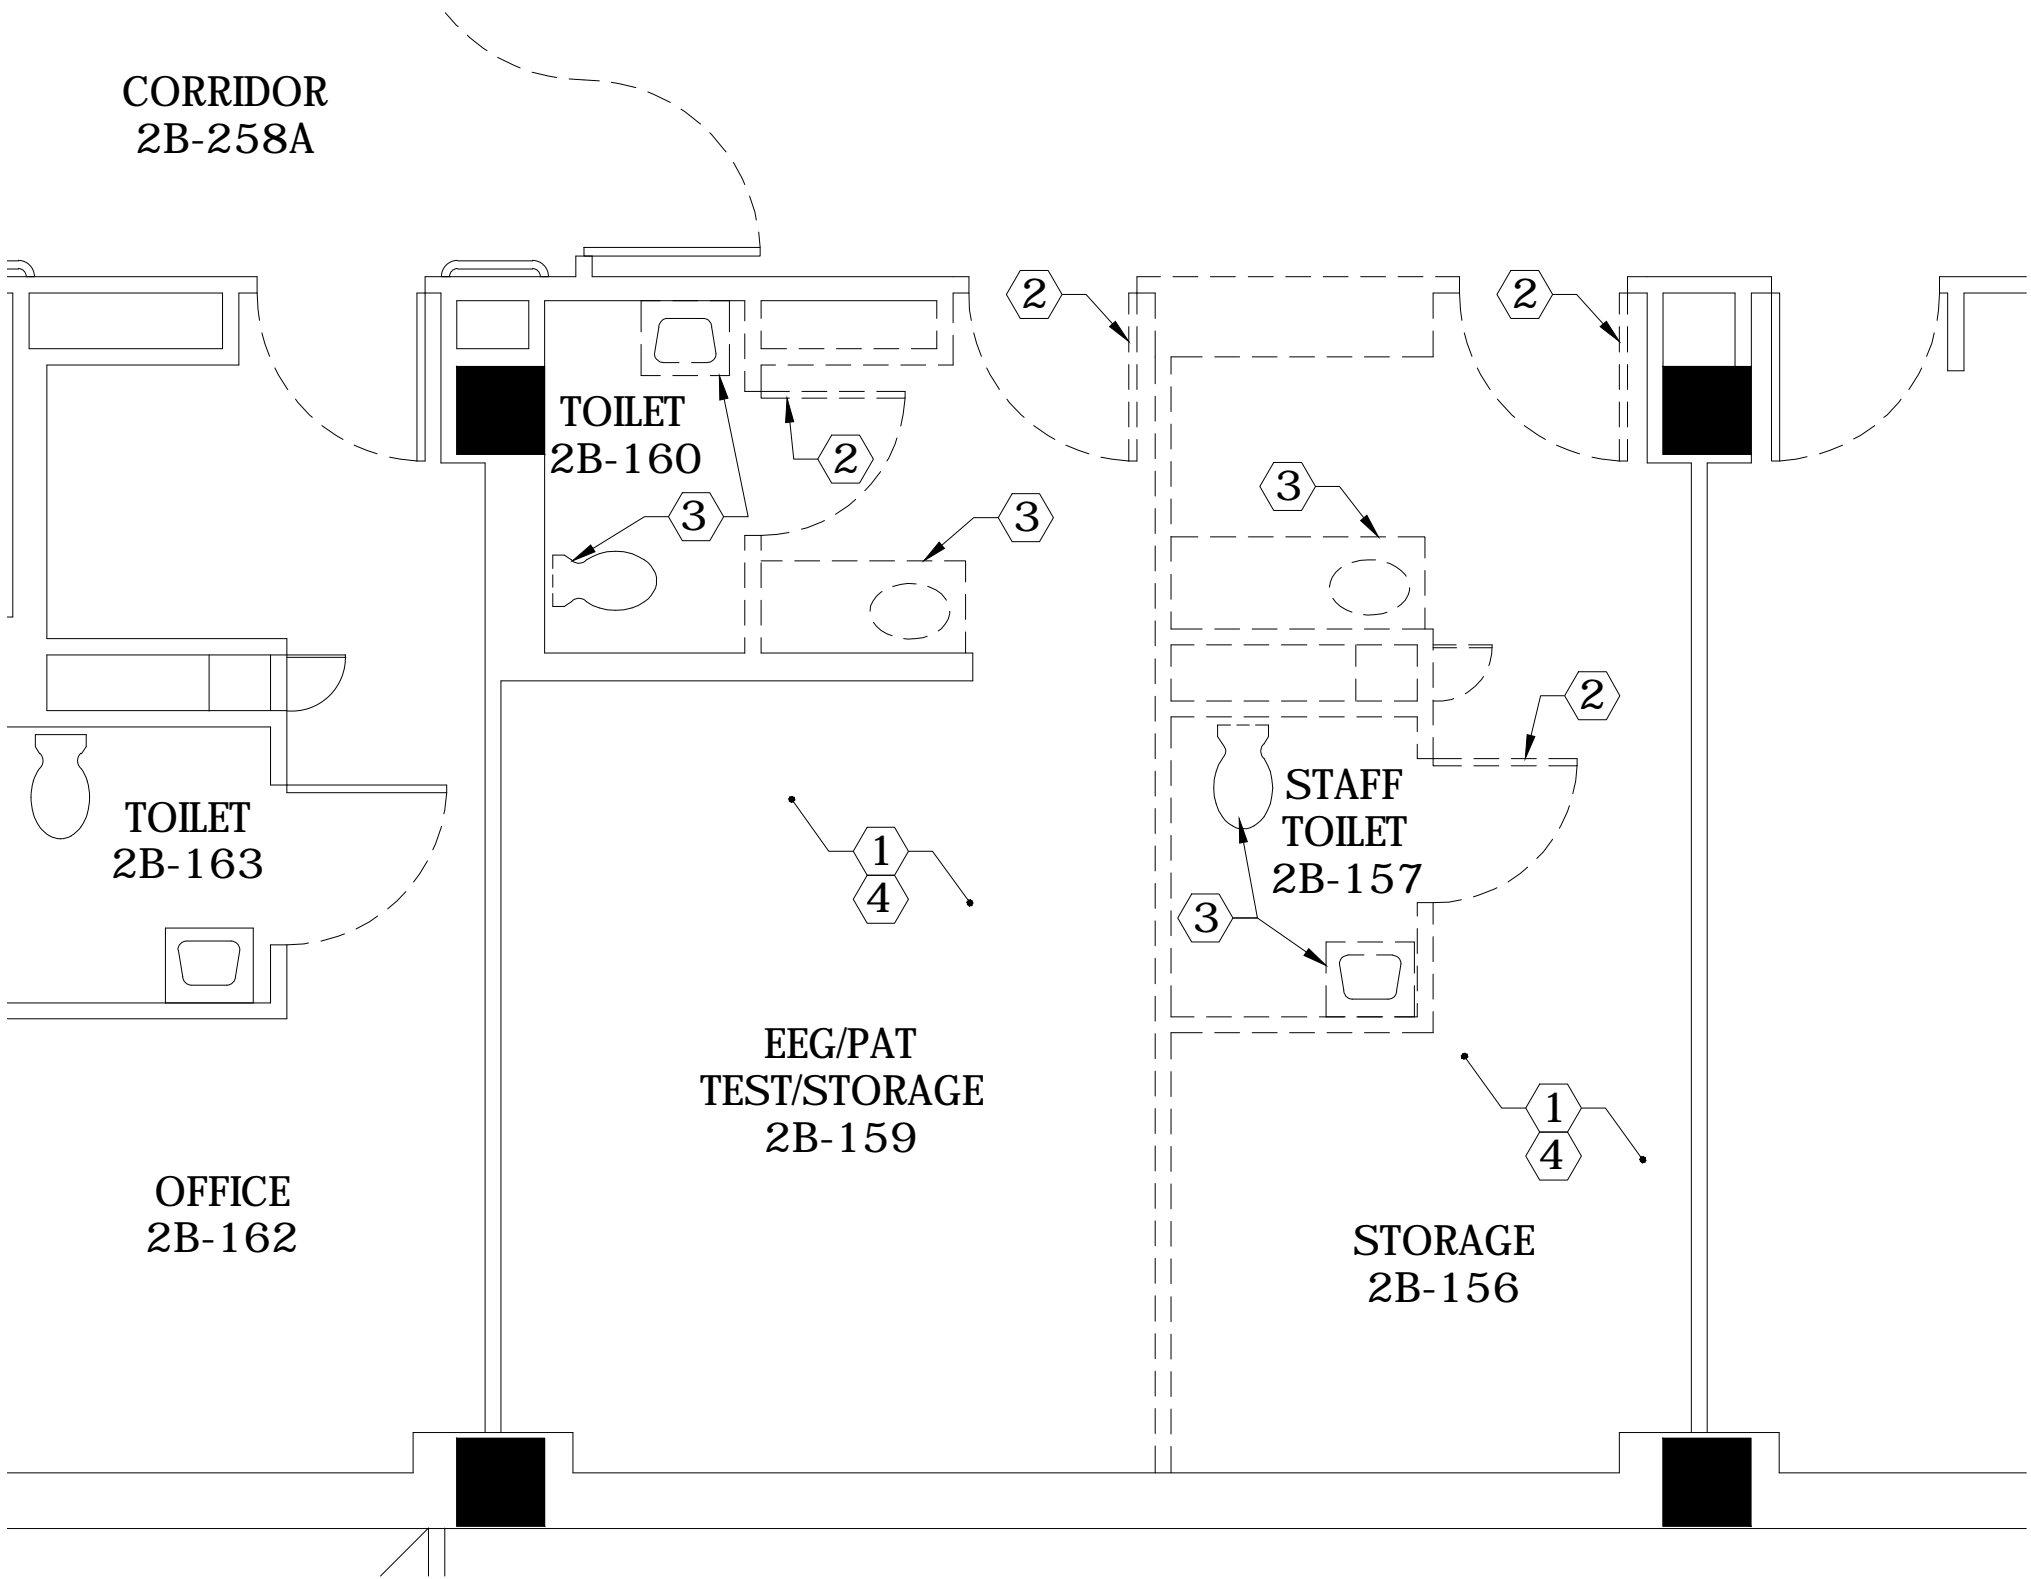

GENERAL DEMO NOTES

DEMO KEY NOTES

- 1 REMOVE INTERIOR WALLS
- 2 REMOVE ALL DOORS & METAL FRAMES
- 3 REMOVE ALL PLUMBING FIXTURES & TERMINATE SUPPLY & DRAINAGE LINES
- 4 REMOVE AND CAP ALL MEDICAL GAS LINES

DEMO LEGEND

- == == == == DEMO WALL
- ===== EXISTING WALL
- NEW WALL
- //// //// //// //// LOW WALL


Revisions	Date	Approved: Service Chief	Date
		Approved: Engineering Technician	Date
		Approved: Trade Supervisor	Date
		Approved: Engineering Service Chief	Date


Approved: Service Chief		Date
Approved: Engineering Technician		Date
Approved: Trade Supervisor		Date
Approved: Engineering Service Chief		Date

Drawing Title	
DEMOLITION PLAN	
Approved: Biomedical Engineer	Date
Approved: OIT Service	Date

Project Title		
RENOVATE OFFICES		
Bldg. No.	Checked	Drawn
500-02		###
Location		
VAMC, RICHMOND, VA.		

Date	03-21-2019
Project No.	652-19-901
Scale	1/4" = 1'-0"
Dwg No.	A-02

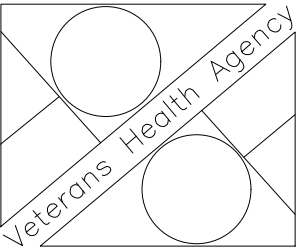

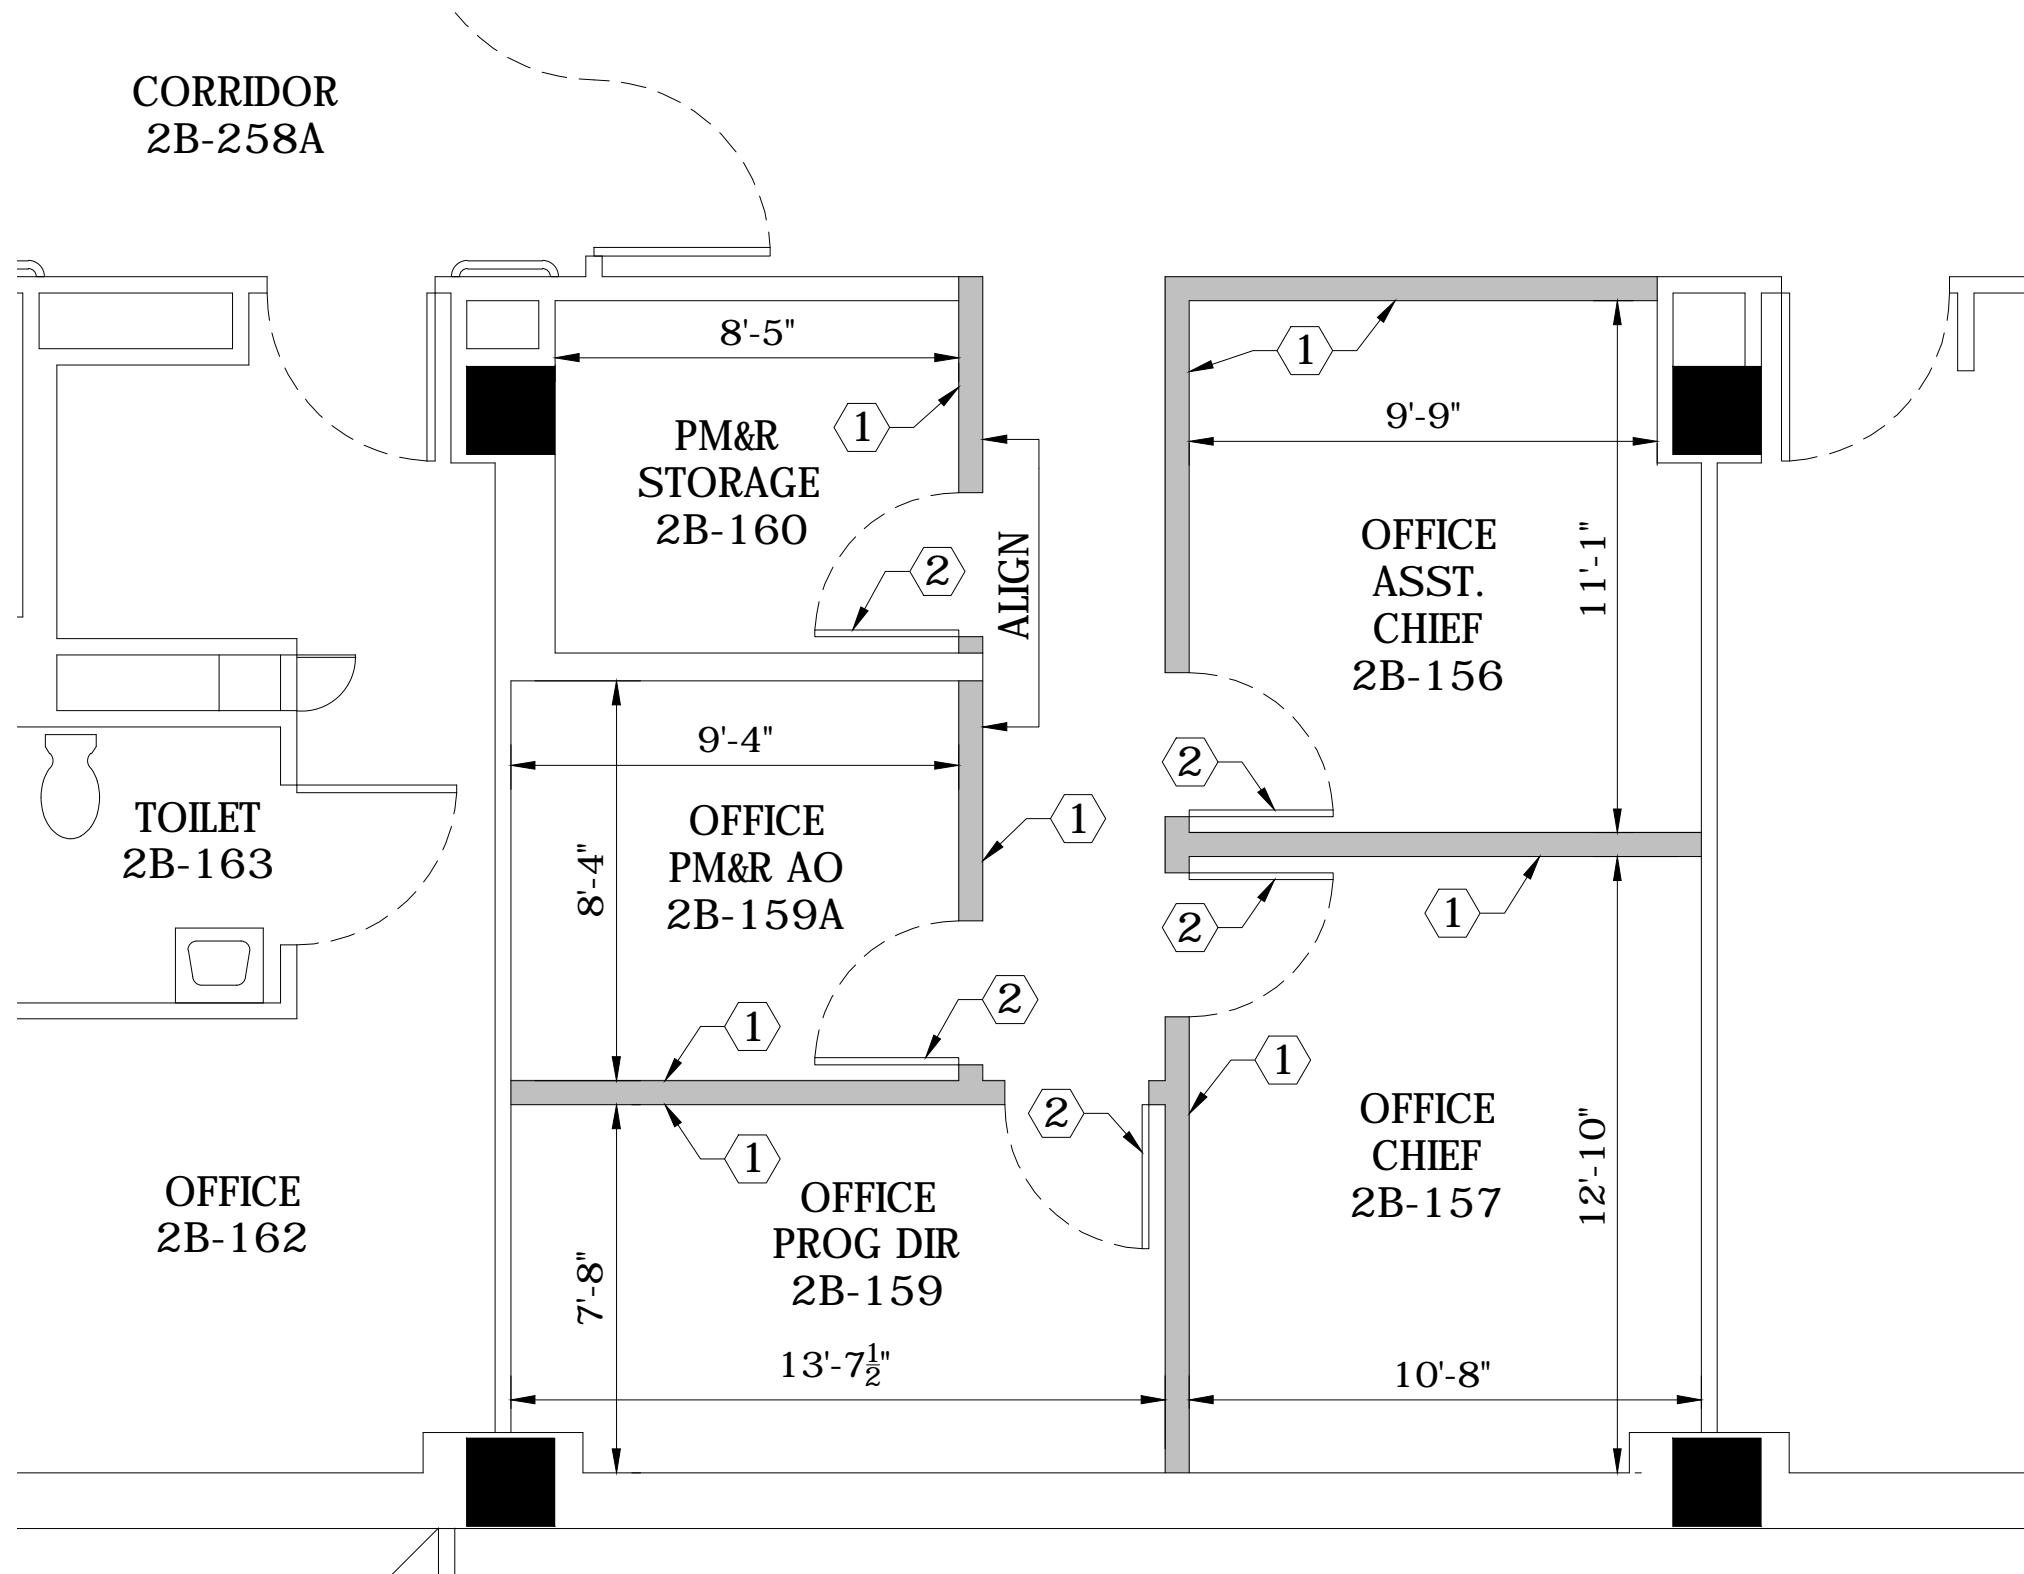



## GENERAL NEW WORK NOTES


### NEW WORK KEY NOTES

- 1 5/8" FIRE RATED GYP BOARD WITH 3-1/2" METAL STUDS, 20 GAUGE
- 2 3'-0"x7'-0" PLASTIC LAMINATE DOORS WITH METAL FRAMES

### NEW WORK LEGEND

- == == == == DEMO WALL
- ===== EXISTING WALL
- NEW WALL
- //// //// //// //// LOW WALL

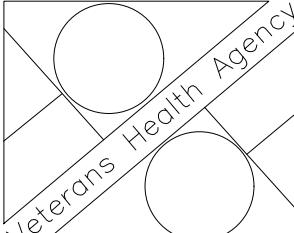Revisions	Date	Approved: Service Chief	Date	Drawing Title <b>NEW CONSTRUCTION PLAN</b>	Approved: Biomedical Engineer	Date	Project Title <b>RENOVATE OFFICES</b>	Date <b>03-21-2019</b>					
		Approved: Engineering Technician	Date					Project No. <b>652-19-901</b>					
		Approved: Trade Supervisor	Date					Bldg. No. <b>500-02</b>			Checked	Drawn <b>###</b>	Scale <b>1/4" = 1'-0"</b>
		Approved: Engineering Service Chief	Date					Approved: OIT Service			Date	Location <b>VAMC, RICHMOND, VA.</b>	Dwg No. <b>A-03</b>

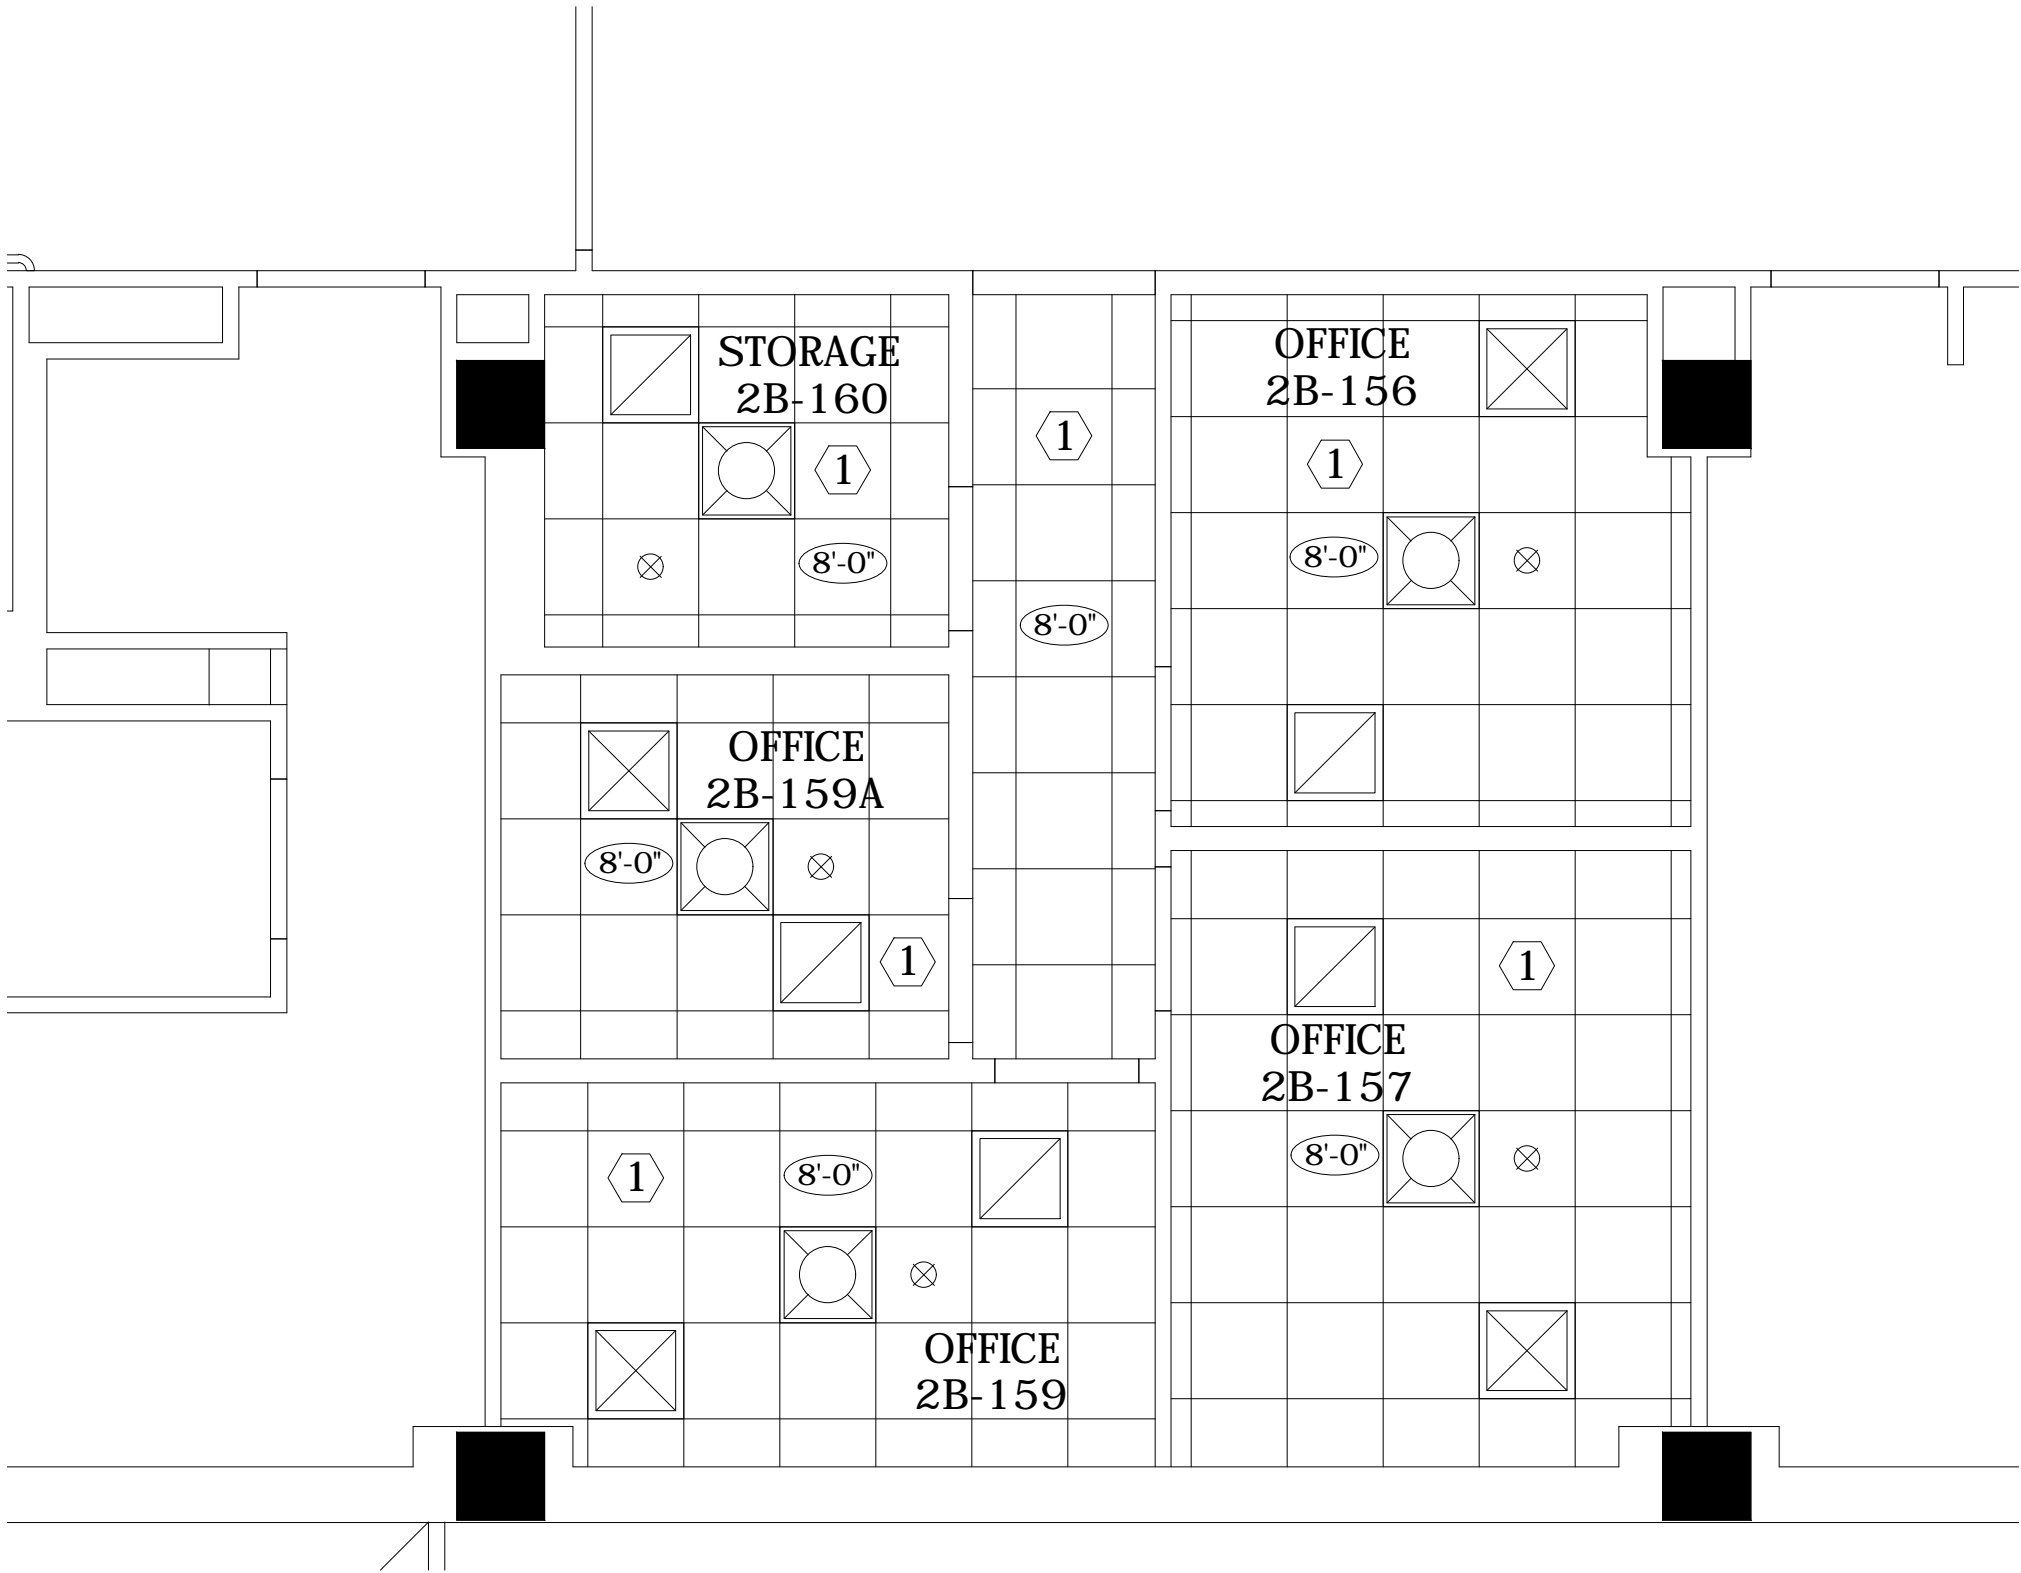

GENERAL CEILING NOTES

1. THE FOLLOWING ROOMS TO HAVE 6" DDC-VAV BOXES WITH REHEAT BOX CONTROLLED BY A THERMOSTAT IN EACH ROOM:  
2B-156  
2B-157  
2B-159  
2B-159A  
2B-160

CEILING KEY NOTES

CEILING LEGEND

- Return Diffuser
- Supply Diffuser
- 2x2 Fixture
- Sprinkler


Revisions	Date	Approved: Service Chief	Date
		Approved: Engineering Technician	Date
		Approved: Trade Supervisor	Date
		Approved: Engineering Service Chief	Date


Approved: Service Chief		Date
Approved: Engineering Technician		Date
Approved: Trade Supervisor		Date
Approved: Engineering Service Chief		Date

Drawing Title	
REFLECTED CEILING PLAN	
Approved: Biomedical Engineer	Date
Approved: OIT Service	Date

Project Title		
RENOVATE OFFICES		
Bldg. No.	Checked	Drawn
500-02		###
Location		
VAMC, RICHMOND, VA.		

Date	03-21-2019
Project No.	652-19-901
Scale	1/4" = 1'-0"
Dwg No.	A-04

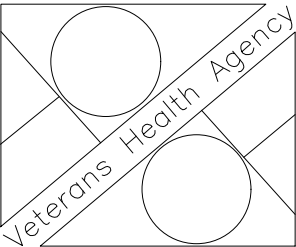

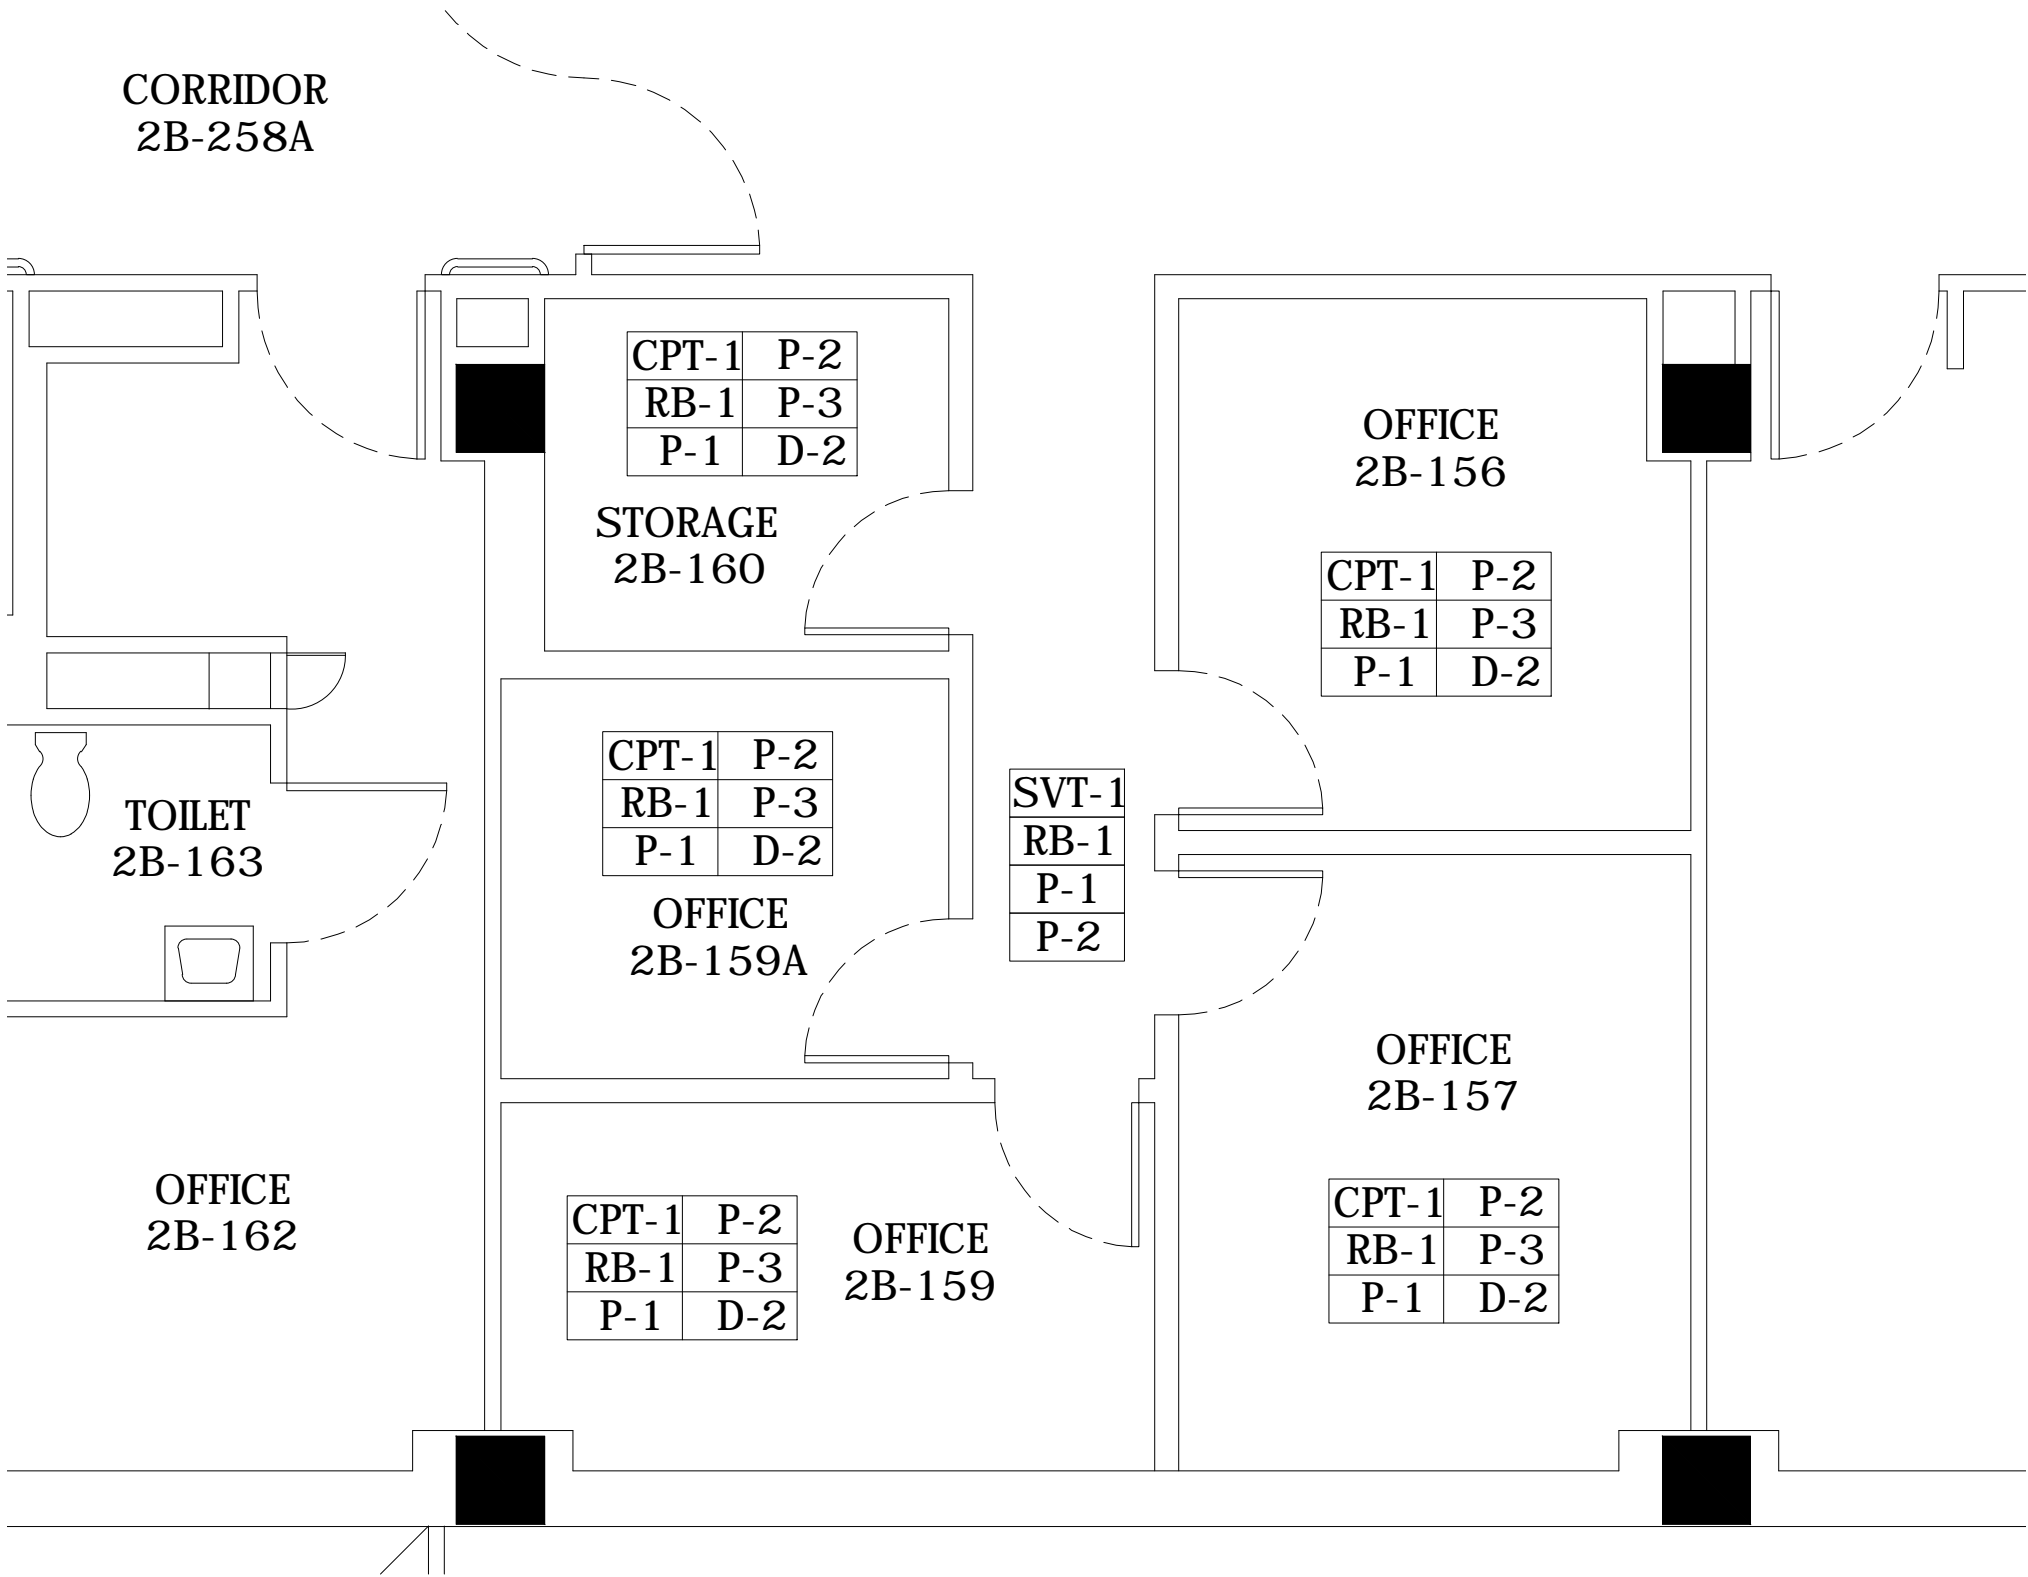

GENERAL FINISH NOTES

FINISHES KEY

CPT-1 (OFFICES)	CARPET TILE - MANNINGTON, SERIES RAMIE, 42332, BROOM
SVT-1 (CORRIDOR)	LUXURY VINYL TILE- MATCH FLOORING IN EXISTING ADJACENT CORRIDOR
RB-1	VINYL BASE- JOHNSONITE, 4" COVE, 49 BEIGE
P-1	TRIM PAINT, SHERWIN WILLIAMS, HARMONY SEMI-GLOSS, SW6107 NOMADIC DESERT
P-2	FIELD PAINT, SHERWIN WILLIAMS, HARMONY EGGSHELL, SW6140 MODERATE WHITE
P-3	ACCENT PAINT*, SHERWIN WILLIAMS, HARMONY EGGSHELL, SW7727 KOI POND
D-2	DOOR- PLASTIC LAMINATE, WILSONART, 7925, MONTICELLO MAPLE


Revisions	Date


Approved: Service Chief	Date
Approved: Engineering Technician	Date
Approved: Trade Supervisor	Date
Approved: Engineering Service Chief	Date

Drawing Title	
FINISH PLAN	
Approved: Biomedical Engineer	Date
Approved: OIT Service	Date

Project Title		
RENOVATE OFFICES		
Bldg. No.	Checked	Drawn
500-02		###
Location		
VAMC, RICHMOND, VA.		

Date	03-21-2019
Project No.	652-19-901
Scale	1/4"= 1'-0"
Dwg No.	A-05

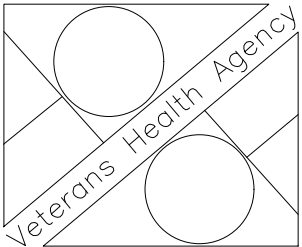

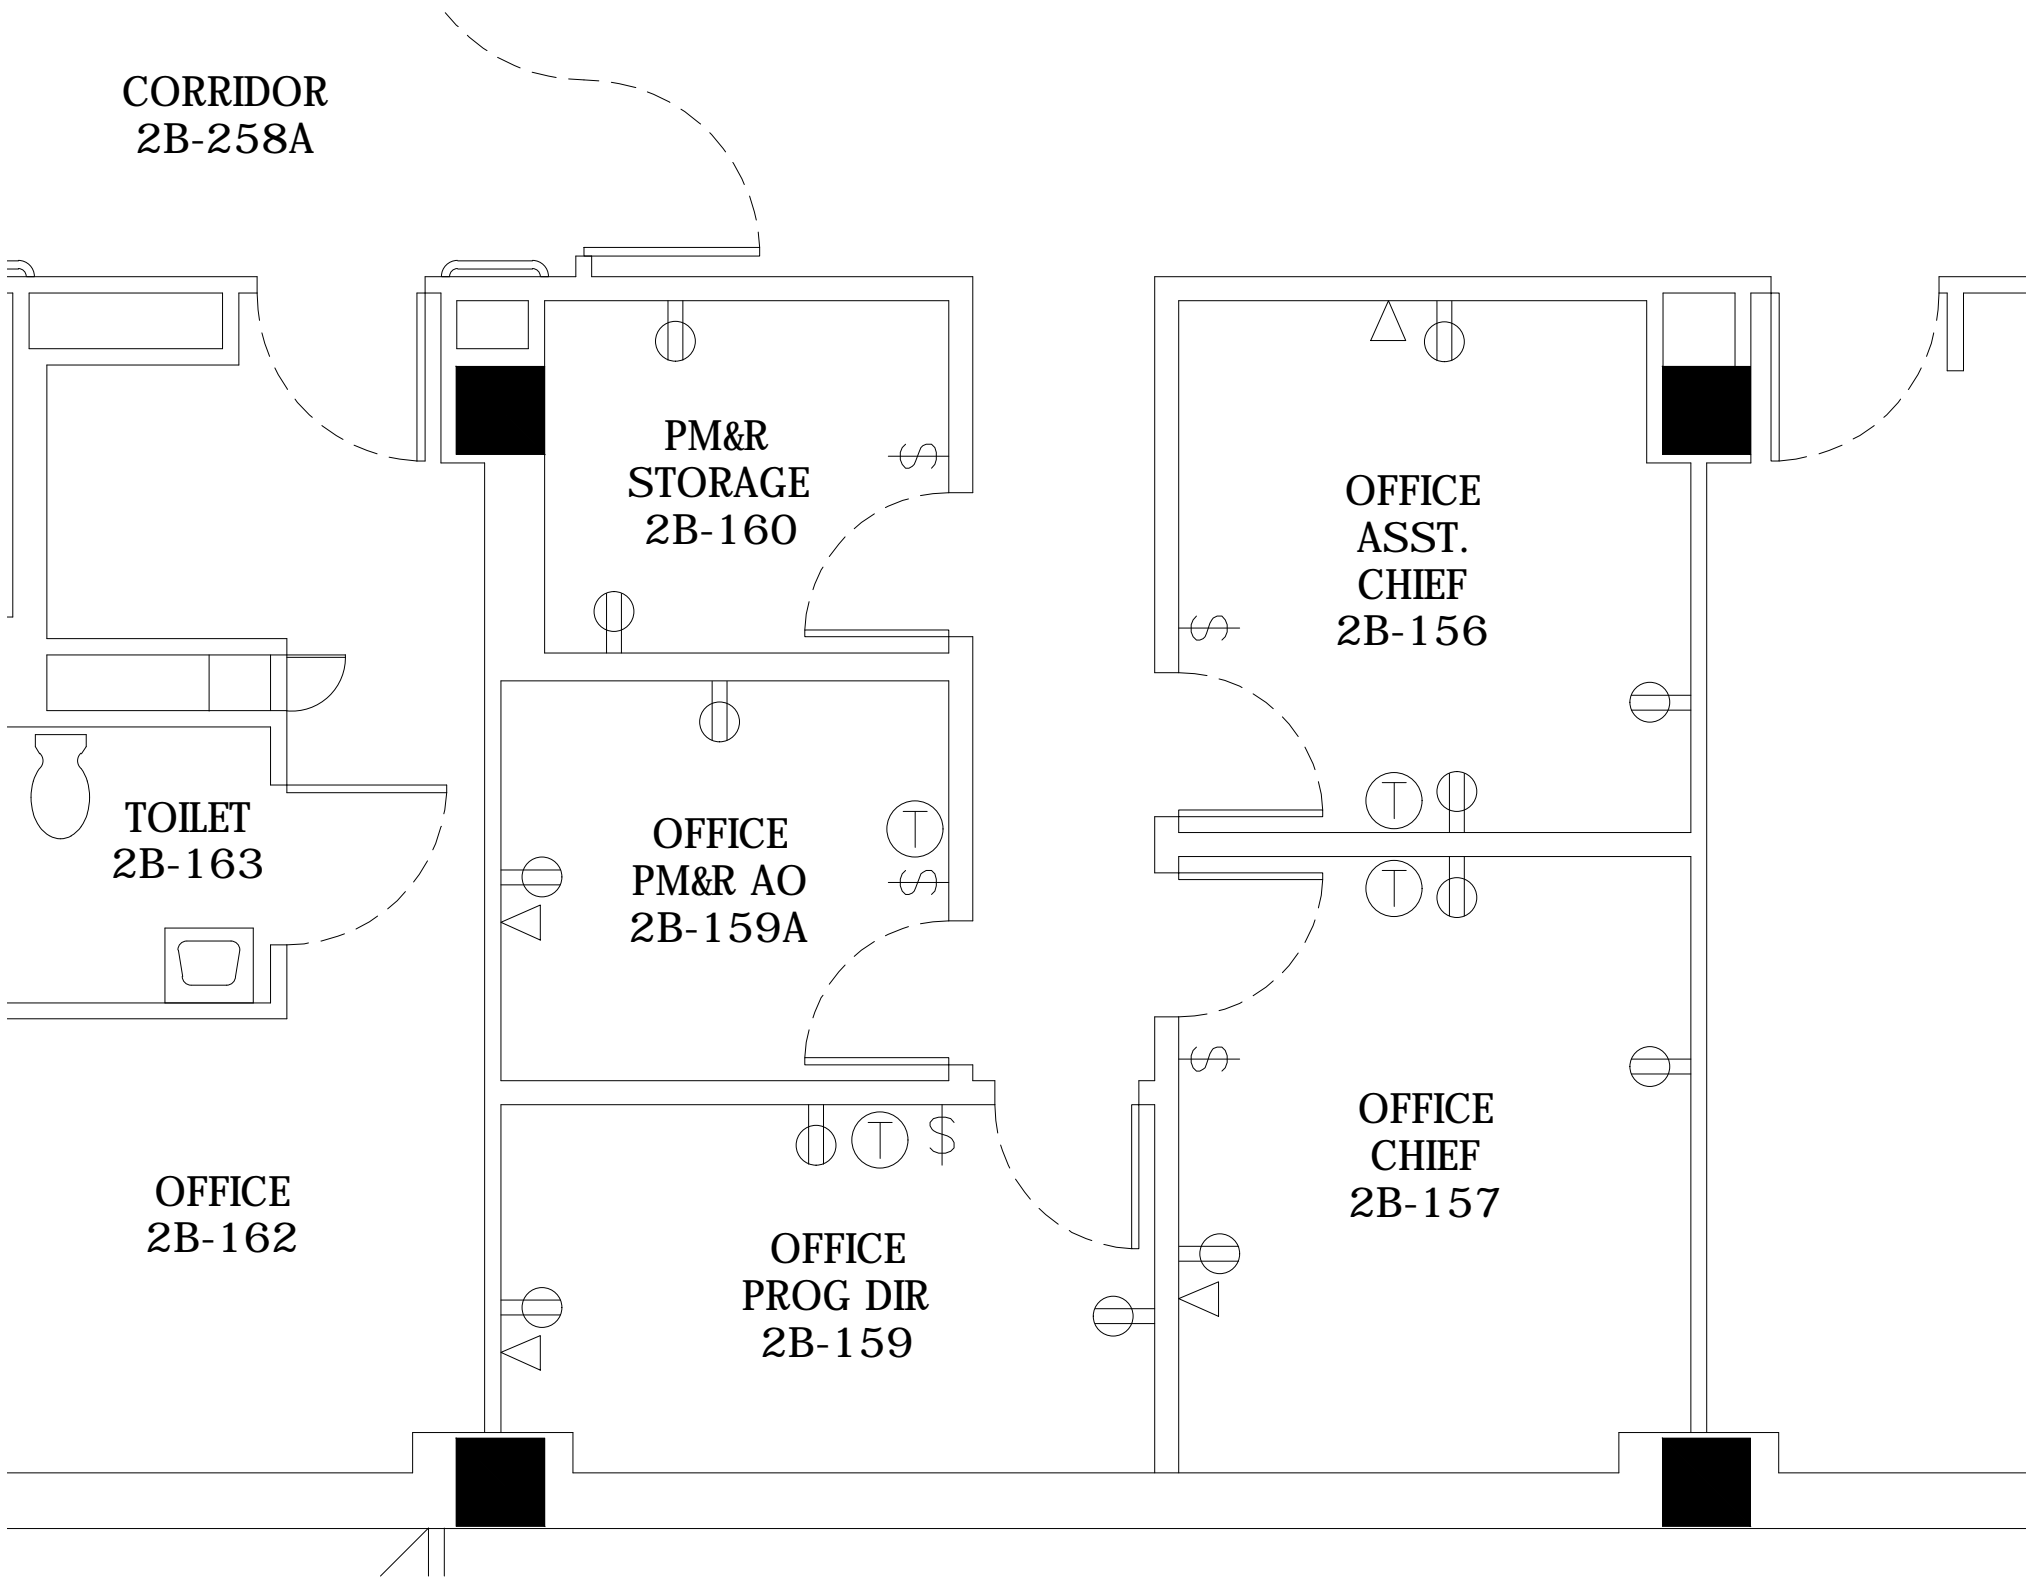

GENERAL ELECTRICAL NOTES

ELECTRICAL KEY NOTES

ELECTRICAL LEGEND

- DATA OUTLET
- DUPLEX RECEPTACLE
- THERMOSTAT
- SWITCH

Revisions	
	Date

Approved: Service Chief	Date
Approved: Engineering Technician	Date
Approved: Trade Supervisor	Date
Approved: Engineering Service Chief	Date

Drawing Title	
ELECTRICAL PLAN	
Approved: Biomedical Engineer	Date
Approved: OIT Service	Date

Project Title		
RENOVATE OFFICES		
Bldg. No.	Checked	Drawn
500-00		###
Location		
VAMC, RICHMOND, VA.		

Date	03-21-2019
Project No.	652-19-901
Scale	NTS
Dwg No.	A-06

