

ELECTRICAL/TELE/DATA PLAN FOR C&P AND AUDIOLOGY 1ST FLR.

PROJECT NO. 506-16-504

KEY:

- CR = CARD READER FOR DOOR
- = STANDARD DUPLEX AT 18" A.F.F. UNLESS NOTED.
- ⊕ = STANDARD QUADPLEX AT 18" A.F.F. UNLESS NOTED.
- △ = STANDARD DATA JACK.
- V = VIDEO COAXIAL CABLE
- = VIDEO CAMERA

DRAWN BY: N. ANDERSON


DATE: 9/14/16

GRAPHIC SCALE: FEET



2 4
SCALE: 1" = 10'-0"



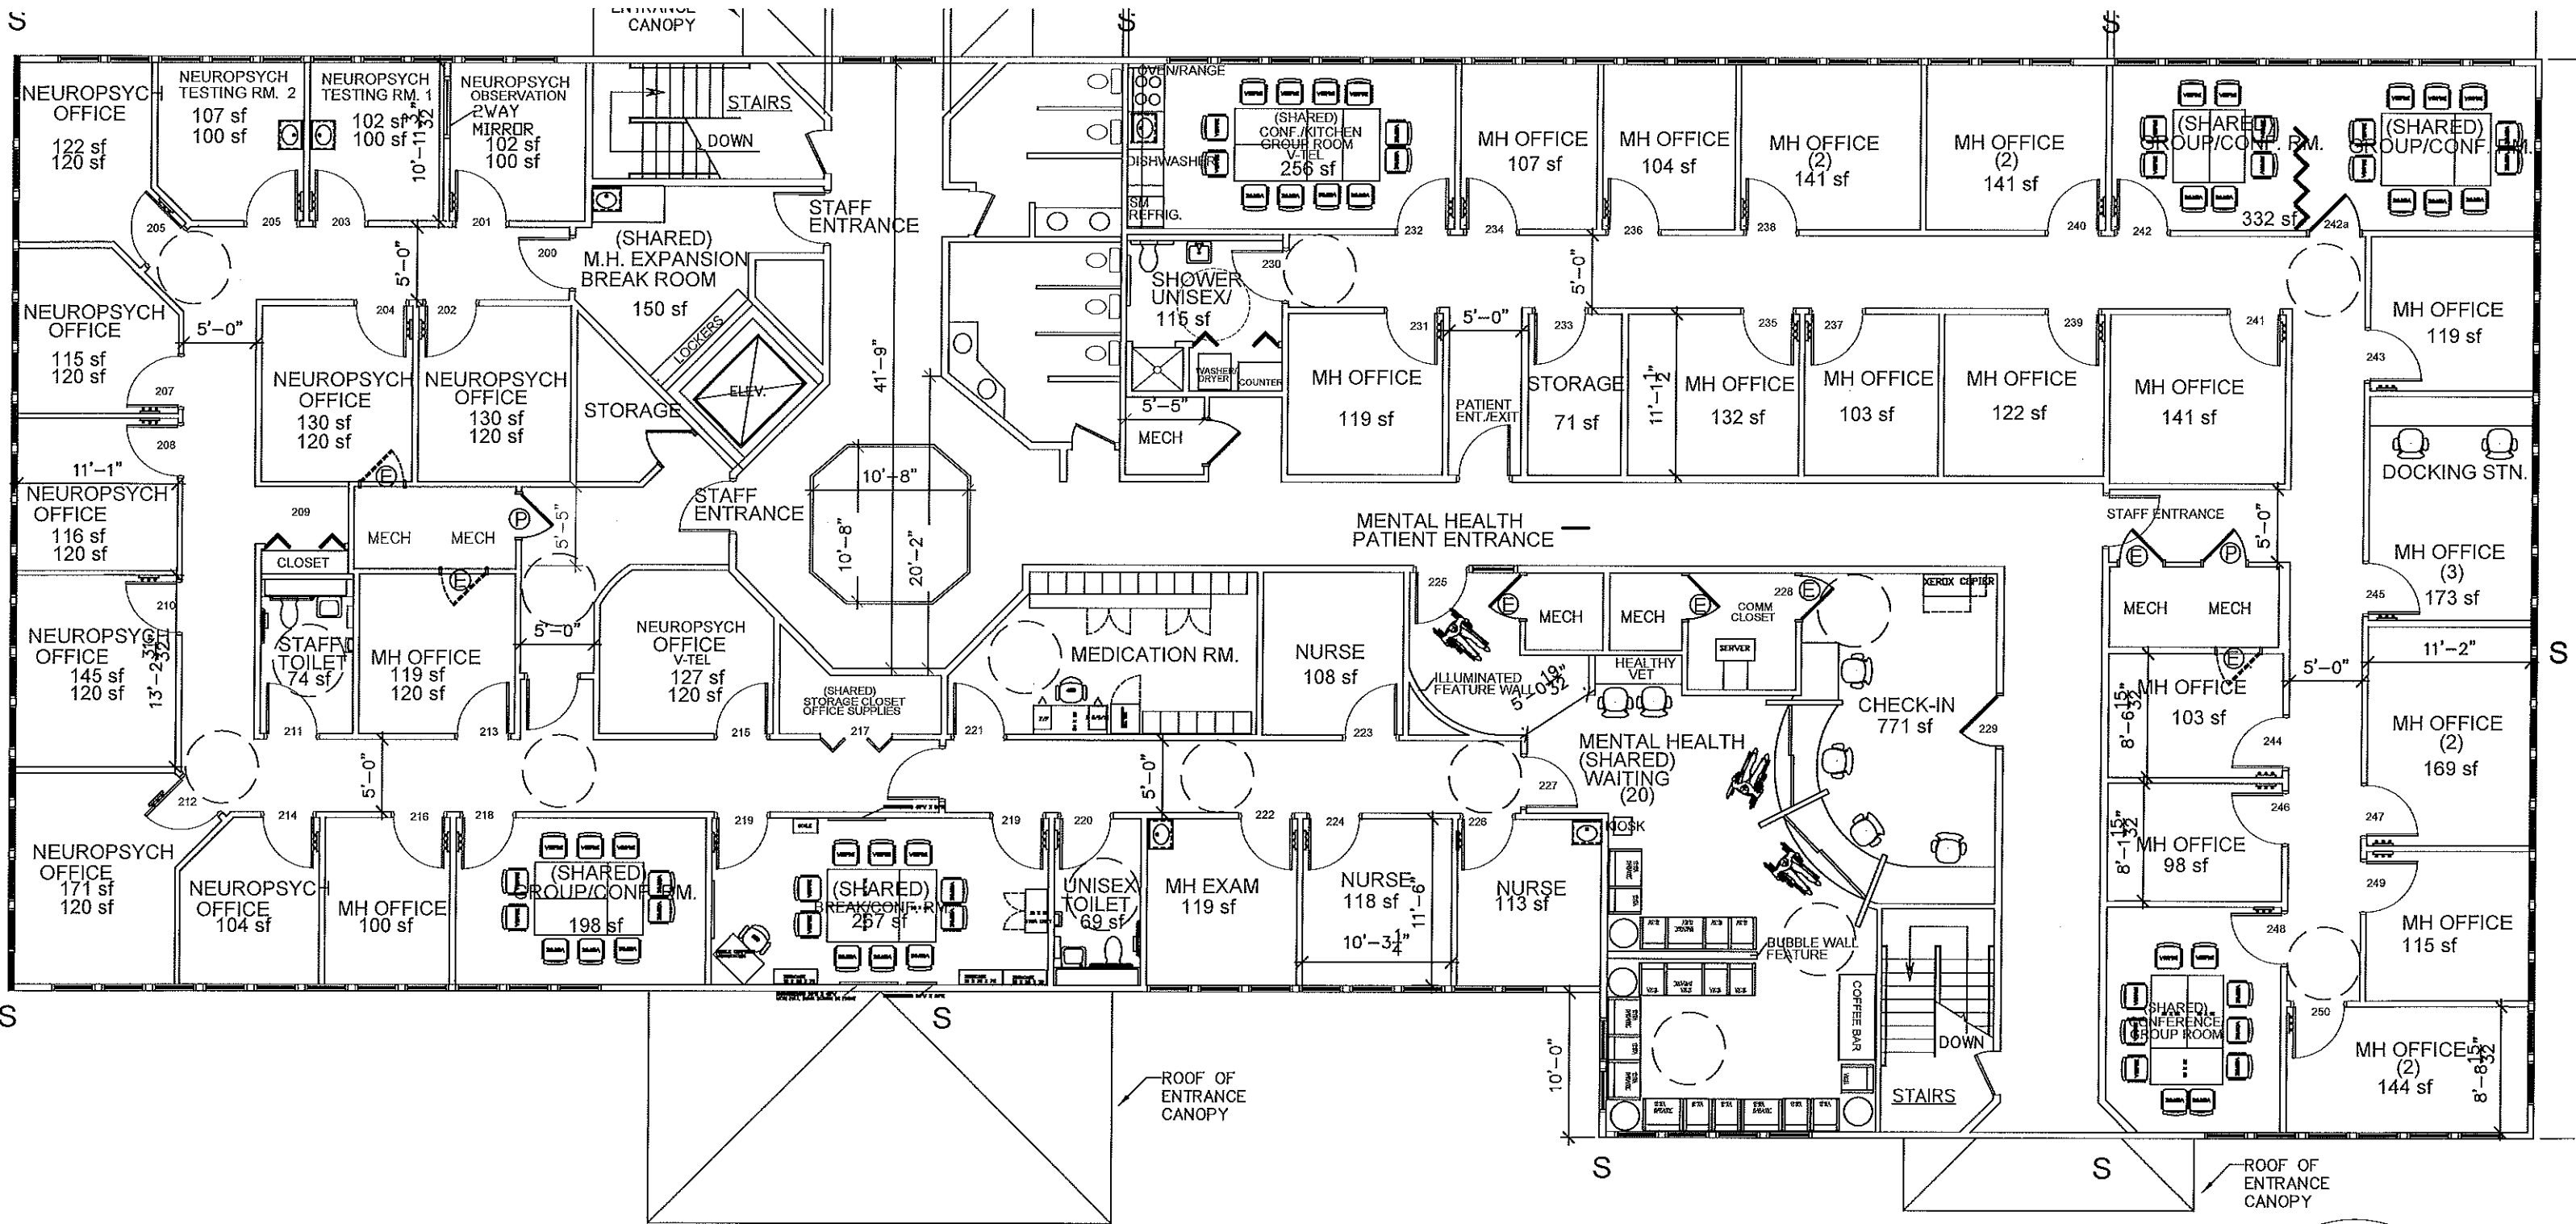

NEUROPSYCHOLOGY, MHICM, & CWT/PRRC/HOMELESS - SECOND FLOOR


DRAWN BY: N. ANDERSON

DATE: 9/14/16

GRAPHIC SCALE: FEET



2 4
SCALE: 1" = 10'-0"

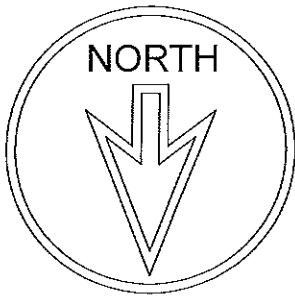

2500 GREEN ROAD SUITE 200, ANN ARBOR, MI 48105

DERM PHOTO THERAPY 153 sf 200 sf

UNISEX STAFF 38 sf

DERM RESIDENTS 166 sf 190 sf

HAC 69 sf 50 sf

MECH. 56 sf

VAC/SUC.

DERM CLEAN SUPPLY 84 sf 200 sf

TELEMED OFFICE 93 sf 100 sf V-TEL

DERM LINEN 80 sf 150 sf

C-LOCKERS

DERM OFFICE NURSE 140 sf 120 sf

DERM NURSE CARE MANAGER 93 sf 120 sf

DERM OFFICE 96 sf 120 sf

PATIENT BREAK 111 sf 84 sf

COMM CLOSET 77 sf 75 sf

UNISEX TOILET 90 sf 100 sf

DERM EXAM 106 sf 120 sf

DERM EXAM 107 sf 120 sf

DERM EXAM 107 sf 120 sf

DERM PROCEDURE 136 sf 200 sf

DERM PROCEDURE 146 sf 200 sf

DERM PROCEDURE 151 sf 200 sf

DERM MENTORS 81 sf 200 sf

DERM RESIDENTS 166 sf 190 sf

UNISEX TOILET 97 sf 100 sf

SLEEP LPN TRIAGE 83 sf 100 sf

SLEEP LPN TRIAGE 84 sf 100 sf

WAITING ROOM 562 sf 400 sf

VESTIBULE 57 sf C-100

EXT'G DOOR 36" W NEW DOOR 42" W

Staff Entrance

ACTUAL SF REQUESTED SF

EXT'G DOOR 36" W NEW DOOR 42" W

LOCKERS 64 sf

SLEEP CLEAN SUPPLY 101 sf 200 sf

SLEEP RME 91 sf 100 sf

WASHER/ DRYER VENT TO OUTSIDE

STORE & FOR. OFFICE V-TEL 76 sf 100 sf

SLEEP DIRECTOR 109 sf 120 sf

SLEEP PROVIDERS 145 sf 120 sf

SLEEP NURSE CARE MGR OFFICE 116 sf 120 sf

SLEEP RT EXAM 99 sf 120 sf

SLEEP RT EXAM 98 sf 120 sf

SLEEP RT EXAM 96 sf 120 sf

(SHARED) SOILED 91 sf 100 sf

EQUIPMENT STORAGE 211 sf 220 sf

OXYGEN STORAGE 74 sf

UNISEX TOILET 97 sf 100 sf

SLEEP 173 sf 200 sf

SLEEP 173 sf 200 sf

SLEEP 173 sf 200 sf

UNISEX TOILET 97 sf 100 sf

CONTROL RM 201 sf 400 sf

SLEEP 205 sf 200 sf

UNISEX TOILET 97 sf 100 sf

BARIATRIC SLEEP 225 sf 200 sf

NEW DOOR 42" W OPEN TO COURTYARD

Oxygen Deliveries

Entrance


PROPOSED NEW DOOR 42" WIDE

TOTAL SQUARE FOOTAGE: 9278

DATE: 9/6/16

0 2 4 8 16
SCALE: 1" = 10'-0"



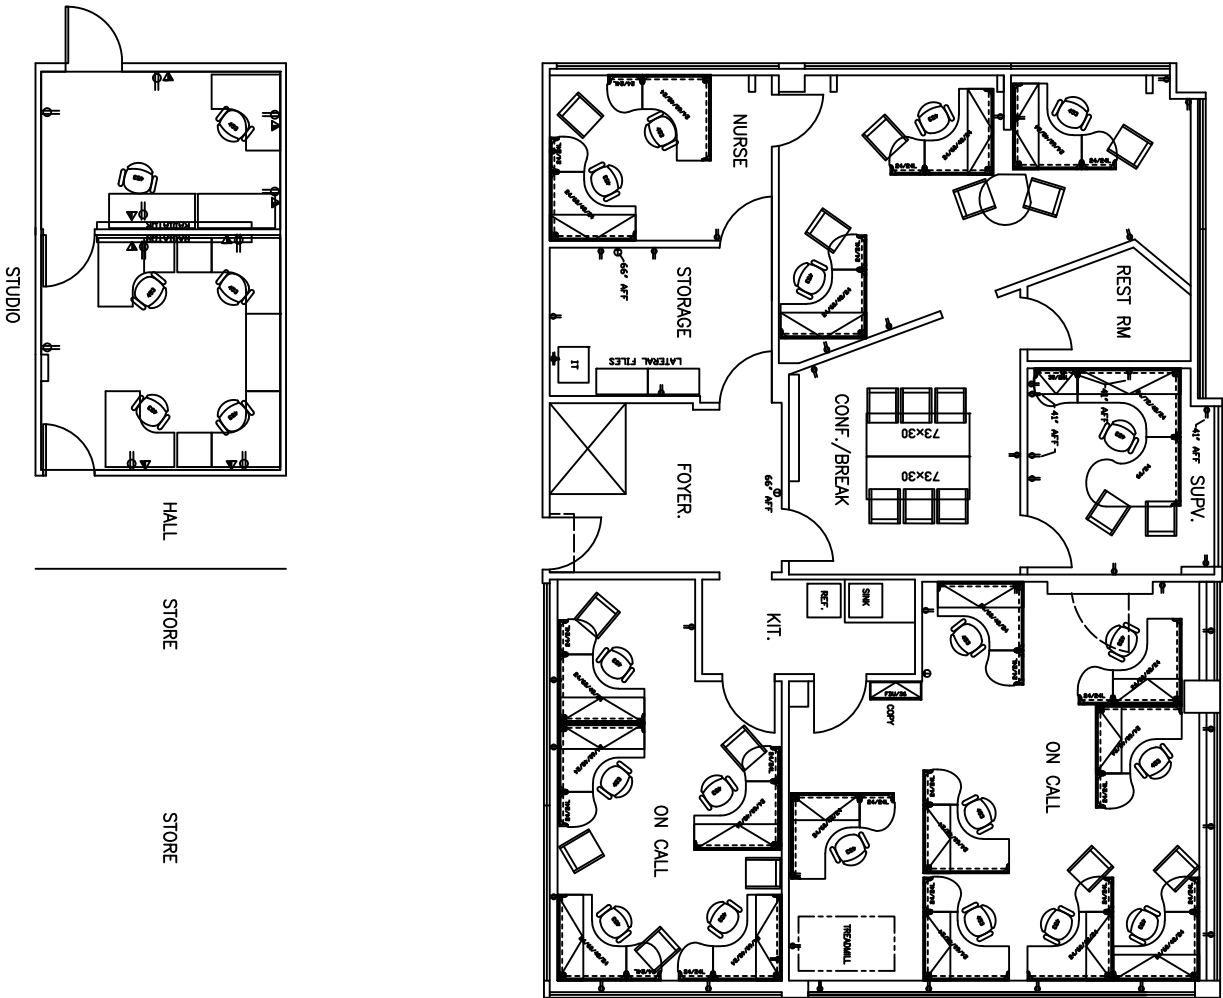

HURON TOWERS

CALL CENTER
EXPANSION SPACE
10.21.16