


GENERAL NOTES

1. EXISTING ROSES AND RISERS INCLUDE EXISTING EQUIPMENT (N) AND/OR SINKS INDICATE NEW.
2. SEE FIRE ALARM WASTEPY LEGEND AND GENERAL NOTES.
3. CONNECT NEW FIRE ALARM DEVICES TO EXISTING FIRE ALARM SYSTEM. PROVIDE ANY NECESSARY DEVICES TO EXISTING LOCAL RING AND/OR WIRE AND/OR CABLE AND/OR EQUIPMENT AND/OR WIRING. ALSO REPROGRAM AND CERTIFY SYSTEM AS TESTED AND FULLY OPERATIONAL.
4. PROVIDE NEW FIRE ALARM DEVICES TO EXISTING FIRE ALARM SYSTEM. PROVIDE ANY NECESSARY DEVICES TO EXISTING LOCAL RING AND/OR WIRE AND/OR CABLE AND/OR EQUIPMENT AND/OR WIRING. ALSO REPROGRAM AND CERTIFY SYSTEM AS TESTED AND FULLY OPERATIONAL.

 
SHEET NOTES

1. PROVIDE CONDUIT SUBS FOR DEVICES TO BE CIRCLED IN THE FUTURE. NO OTHER NEW WORK TO BE PROVIDED AS PART OF REDUCITIVE ALTERNATE.
2. PROVIDE CONDUIT SUBS FOR DEVICES TO BE CIRCLED IN THE FUTURE. NO OTHER NEW WORK TO BE PROVIDED AS PART OF REDUCITIVE ALTERNATE.
3. CONNECT (N) THE ALARM STINKS TO EXISTING CONDUIT STINKS.

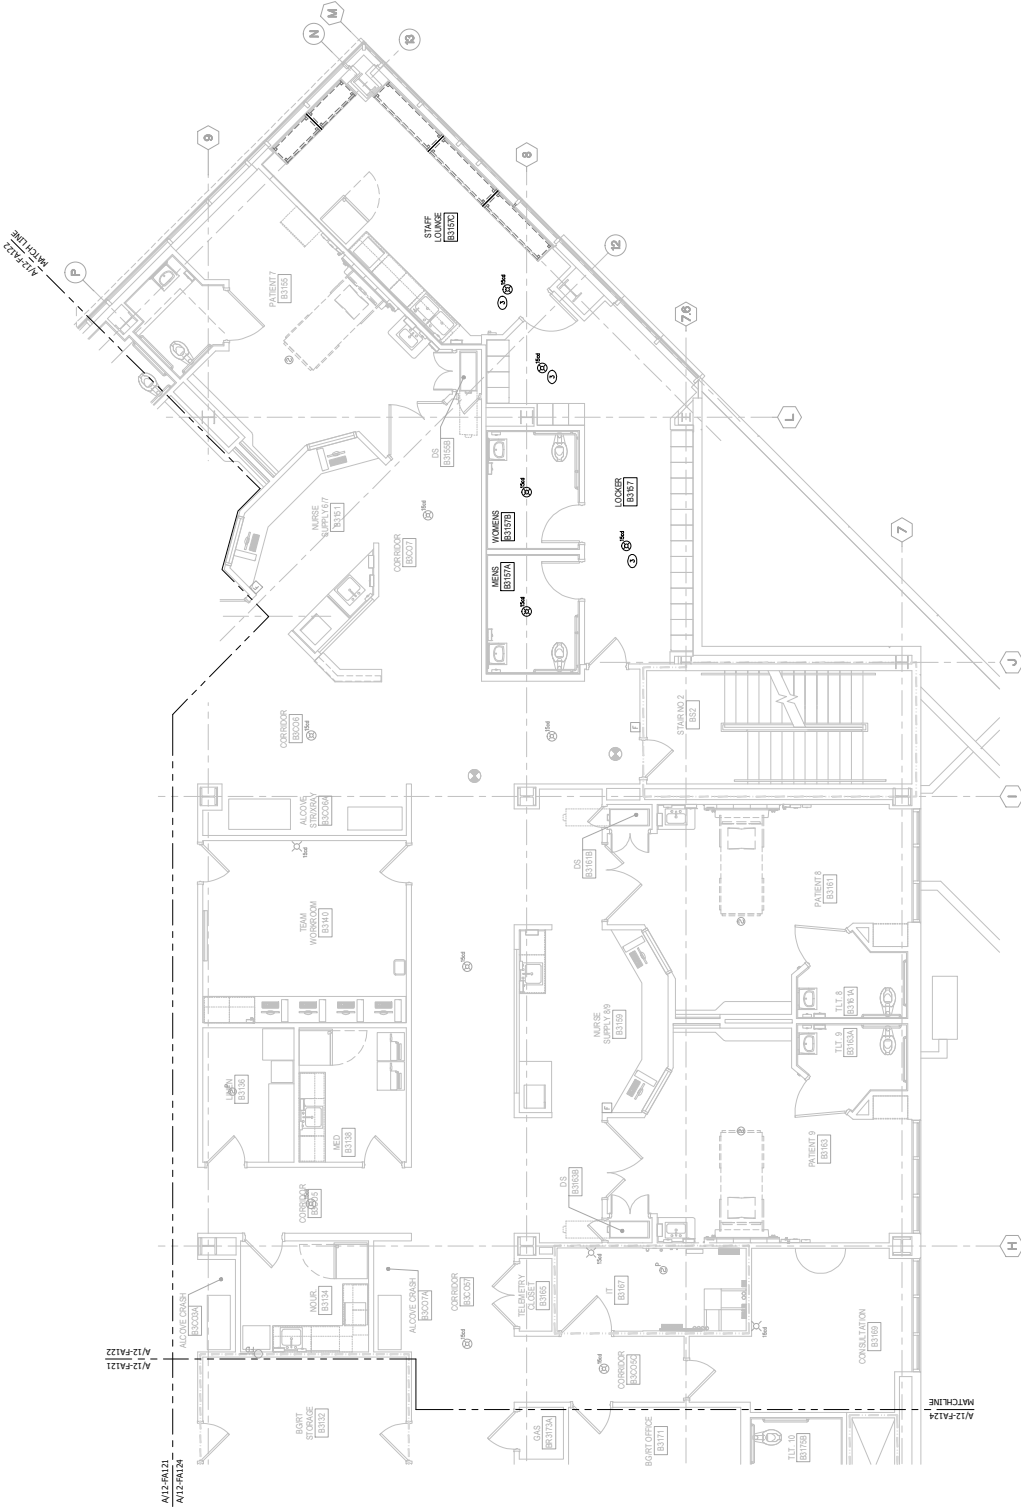

(A) THIRD FLOOR FIRE ALARM PLAN - AREA C

1" = 12'



CONSULTANT		ARCHITECT/ENGINEER OF RECORD		STAMP		Office of Construction and Facilities Management		Drawing Title		Phase		BID DOCUMENTS		Project File		Project Number	
KPA ARCHITECTS		paradigm		Seal		VA		THIRD FLOOR FIRE ALARM PLAN - AREA C		B3 UNFINISHED SPACE		B3 UNFINISHED SPACE		654-18-817		654-18-817	
6700 KALL CENTER PARKWAY, SUITE 125 PLEASANTON, CALIFORNIA 94566 TEL: 925.232.8217 WWW.PARADIGM.COM		Architecture Engineering Design-Build 200 Dwyer Drive, Suite 200, Loudon, VT 05209		Seal		U.S. Department of Veterans Affairs		Approved Project Director		Location: VA SERRANOVAH HEALTHCARE SYSTEM		Location: VA SERRANOVAH HEALTHCARE SYSTEM		Drawing Number		12-FA123	
THE KPA GROUP		THE KPA GROUP		Seal		U.S. Department of Veterans Affairs		Approved Project Director		Location: VA SERRANOVAH HEALTHCARE SYSTEM		Location: VA SERRANOVAH HEALTHCARE SYSTEM		Drawing Number		12-FA123	
THE KPA GROUP		THE KPA GROUP		Seal		U.S. Department of Veterans Affairs		Approved Project Director		Location: VA SERRANOVAH HEALTHCARE SYSTEM		Location: VA SERRANOVAH HEALTHCARE SYSTEM		Drawing Number		12-FA123	