
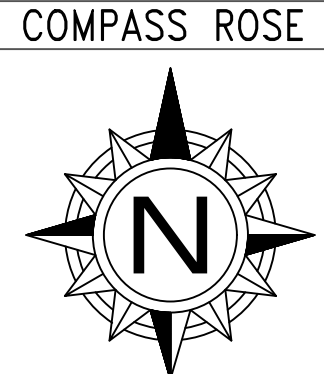
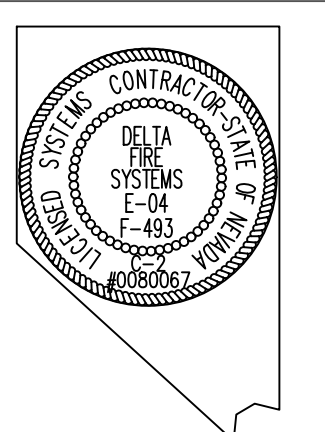


BUILDING 12 - THIRD FLOOR - FIRE ALARM PLAN

SCALE: 1/8" = 1'-0"

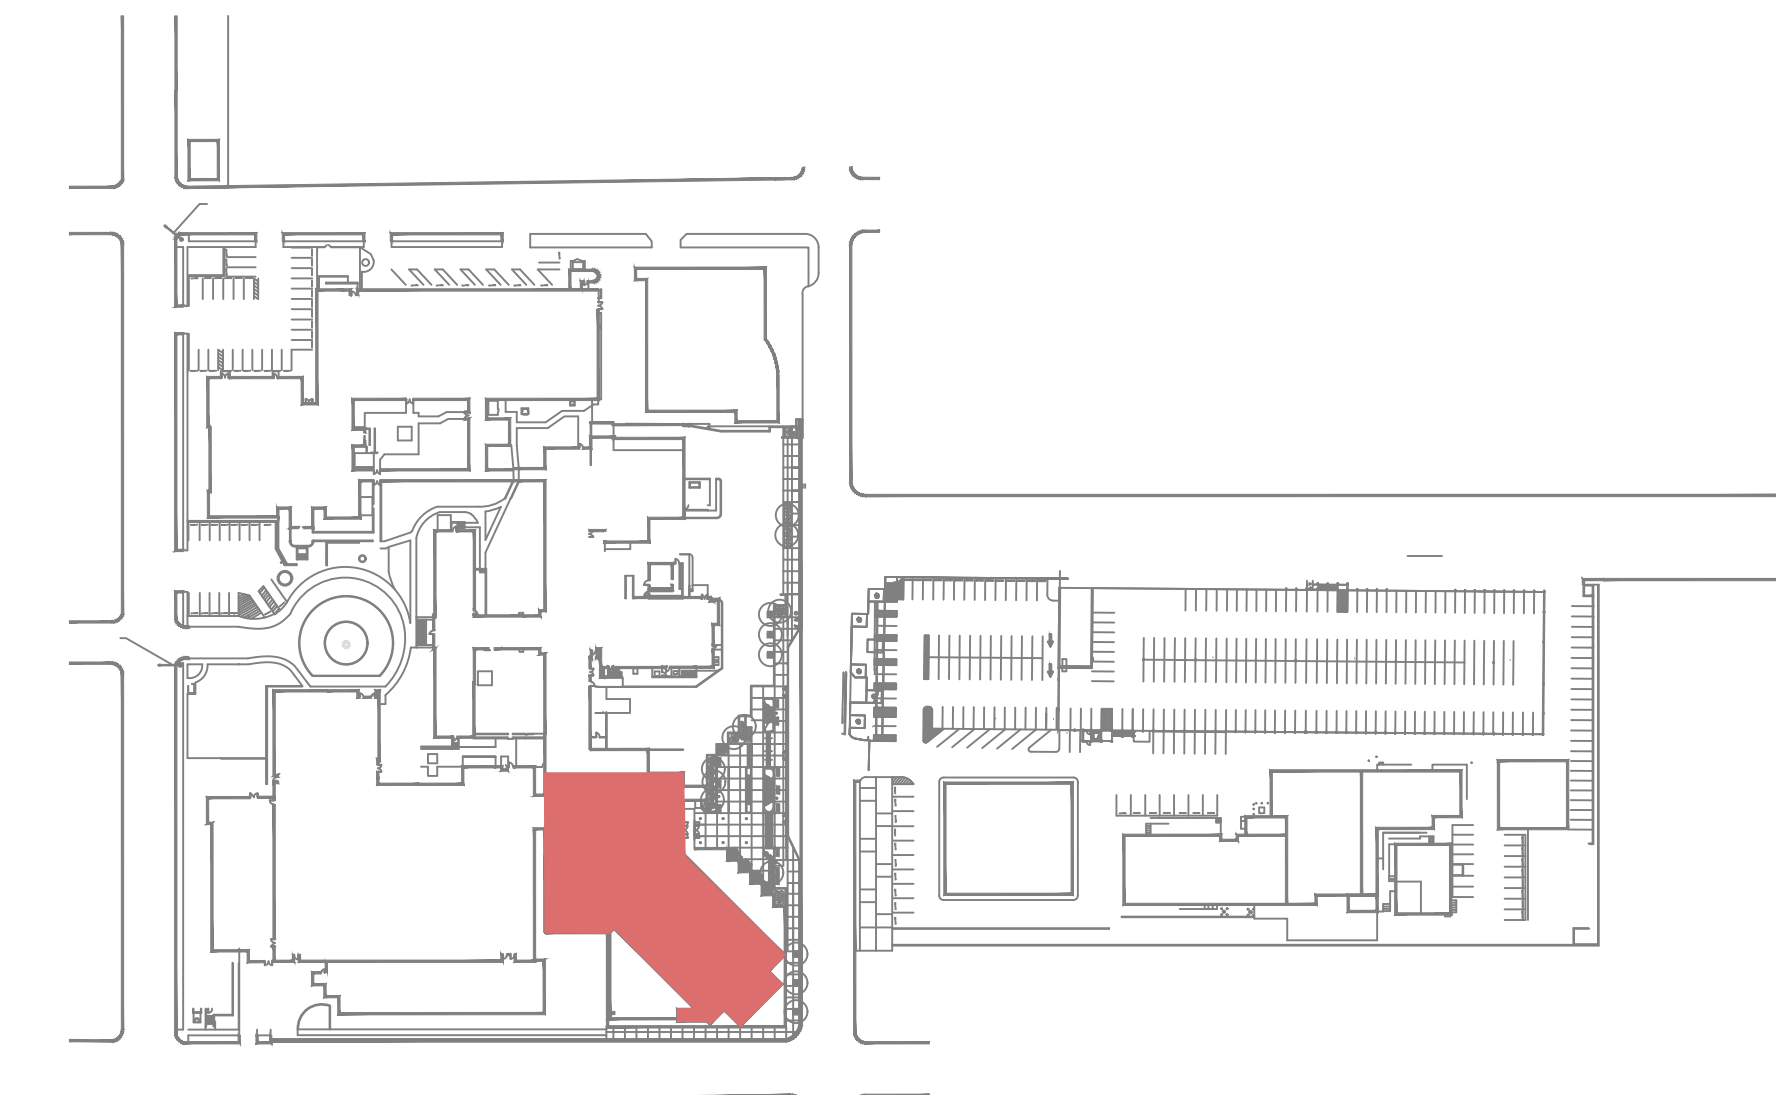

ABBREVIATIONS	
SLC = SIGNALING LINE CIRCUIT	NTS = NOT TO SCALE
NAC = NOTIFICATION APPLIANCE CIRCUIT	TRBL = TROUBLE
IDC = INITIATING DEVICE CIRCUIT	SUPV = SUPERVISORY
WP = WEATHERPROOF	NFPA = NATIONAL FIRE PROTECTION ASSOC.
XP = EXPLOSION PROOF	NEC = NATIONAL ELECTRICAL CODE
AFB = ABOVE FINISHED FLOOR	TYP = TYPICAL
EOL = END OF LINE	AUX = AUXILIARY POWER
FACP = FIRE ALARM CONTROL PANEL	WF = WATERFLOW
FAA = FIRE ALARM ANNUNCIATOR	TS = TAMPER SWITCH
FSD = FIRE SMOKE DAMPER	W = (eg. 1/4W) WATT
AFJ = ABOVE FINISHED FLOOR	W/ = WITH
ALM = ALARM	W/O = WITHOUT
(E) = EXISTING	

NOTICE
FACP REQUIRES 120 VAC DEDICATED 20 AMP CIRCUIT. THIS CIRCUIT SHALL BE PROVIDED BY A LICENSED ELECTRICAL CONTRACTOR, AND SHALL BE MARKED RED AND LABELED "FIRE ALARM DISCONNECT." THE LOCATION OF THE BRANCH CIRCUIT SHALL BE PERMANENTLY IDENTIFIED AT THE FIRE ALARM CONTROL PANEL.

SYSTEM DESCRIPTION	
OCCUPANCY TYPE:	I-2
WIRING	
INITIATING CIRCUITS:	CLASS B
SCOPE OF WORK	
UPGRADED FIRE ALARM SYSTEM FOR AN EXISTING FACILITY. THIS SYSTEM SHALL INCLUDE SPRINKLER RISER MONITORING, AREA SMOKE DETECTION, MANUAL PULL STATIONS, ELEVATOR RECALL FUNCTIONS AND ADA COMPLIANT AUDIO-VISUAL NOTIFICATION.	

SPRINKLER PROTECTION: Y FULLY SPRINKLERED

NOTIFICATION CIRCUITS: CLASS B

ISSUES / REVISIONS	
DATE	DESCRIPTION
4/4/17	AS BUILT DRAWINGS

DELTA
FIRE SYSTEMS INC.
"Fire Protection at its BEST."

1507 PIONEER RD.
SALT LAKE CITY, UTAH 84104
PH: (801) 972-4000
FAX: (801) 972-6883
UT CON. LICENSE NO. 22-2294-162885, N.E.
22-2294-162885, N.E.
1655 MARBETTA WAY
SPARKS, NEVADA 89431
PH: (775) 368-7700
NV CON. LICENSE NO. 020518
CA CON. LICENSE NO. 589168

ISSUE " 1 "
REVIEWED BY TE
DRAWN BY TLM
CHECKED BY T12734
DATE 4/4/17
SCALE As Noted
SHEET FA24
JOB NUMBER 1037-0004816

DEPT. OF VETERANS AFFAIRS MEDICAL CENTER
975 KIRMAN AVENUE
RENO, NEVADA 89502
BUILDING 12 - THIRD FLOOR - FIRE ALARM PLAN

1037-0004816 - VAMC