





<div>Notes and/or Revisions:</div> <div>Date</div>		Approved: Assistant Chief, Engineering Service		Project Title Preventive Maintenance Service Contract HVAC/R		Drawing Title MECHANICAL SITE PLAN		Project Number 20 PM HVAC/R		<div>Engineering Service</div> <div></div> <div>VETERANS HEALTH CARE SYSTEM OF THE OZARKS</div>	
		Approved: Utility Systems Supervisor		One inch or not to scale: 		Location Fayetteville, Arkansas		Building Number 564 STA			
				Scale: 1"=50 Yards		Drawing Number MS101		Drawing Number MS101			
						Checked TRB		Drawn JCH			

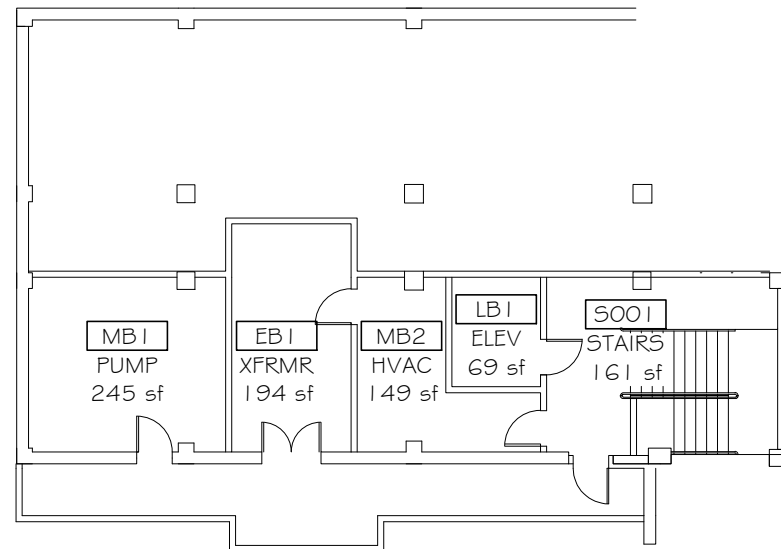


B-4
BASEMENT
AND CRAWL SPACE

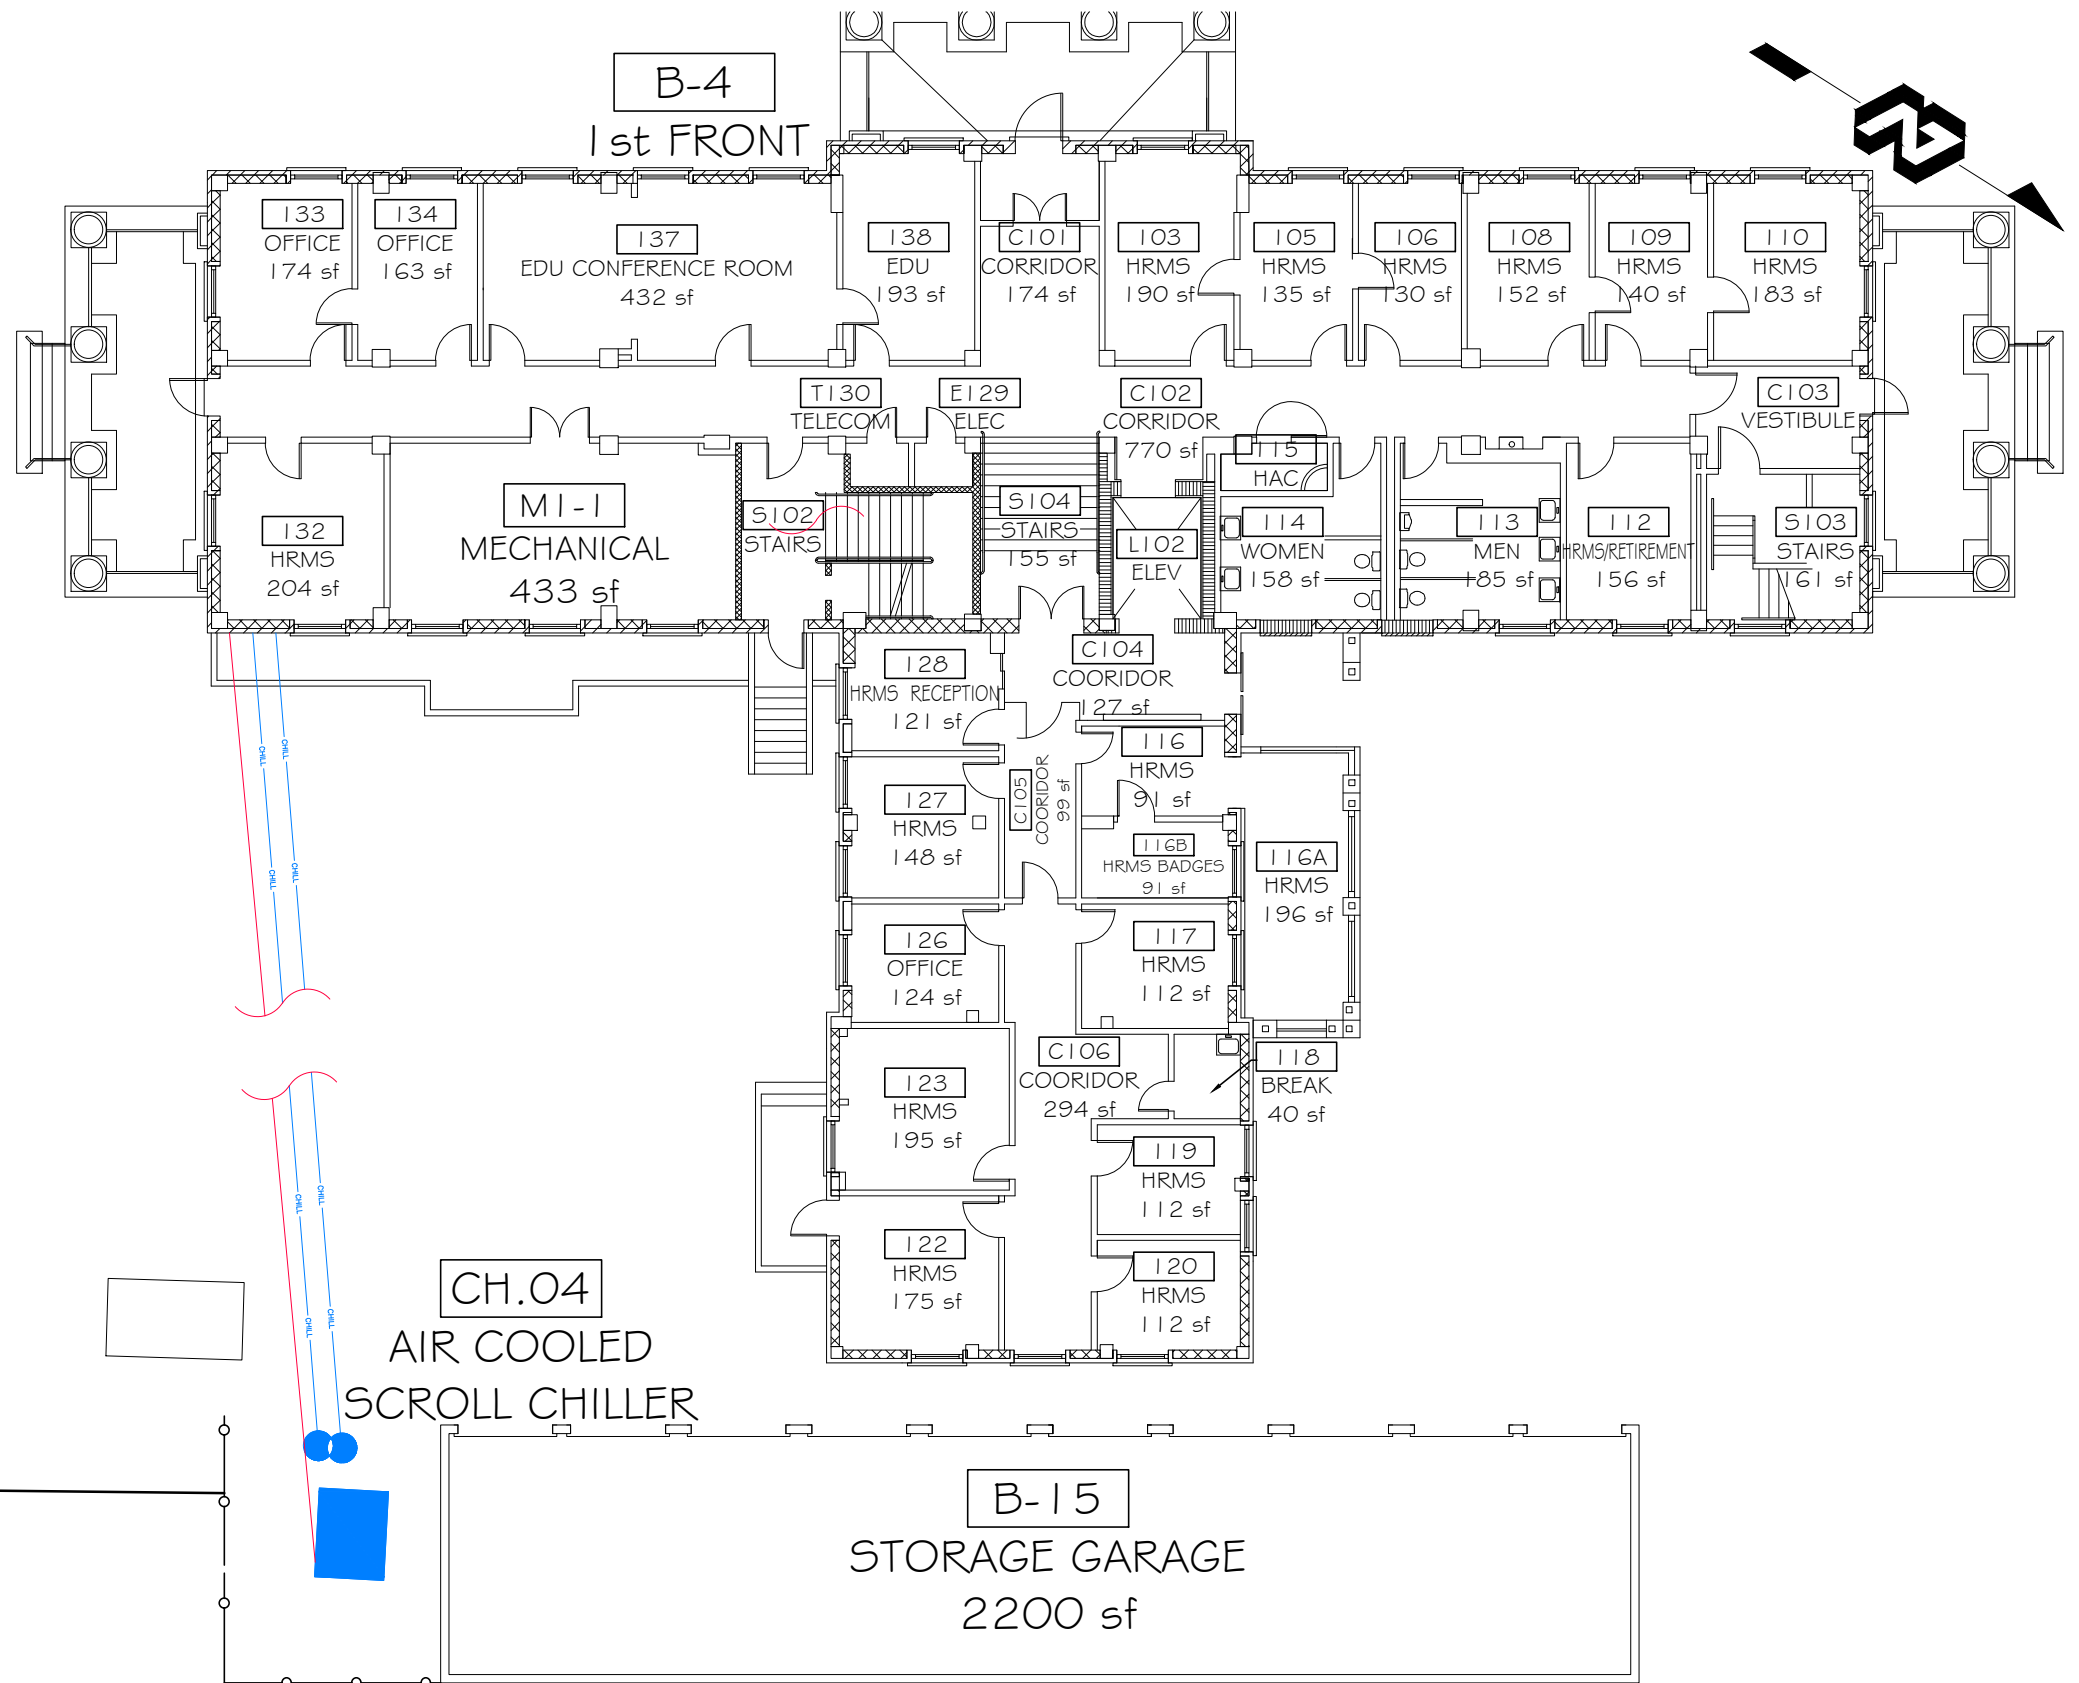

		Approved: Assistant Chief, Engineering Service	Project Title Preventive Maintenance Service Contract HVAC/R		Drawing Title EQUIPMENT LOCATION PLAN		Project Number 20 PM HVAC/R		<div>Engineering Service</div> <div></div> <div>VETERANS HEALTH CARE SYSTEM OF THE OZARKS</div>			
							Building Number FOUR (04)					
		Approved: Utility Systems Supervisor	One inch or not to scale! 		Scale: 1/16"= 1'-0"		Location Fayetteville, Arkansas				Drawing Number ME103	
Notes and/or Revisions:		Date			Checked TRB		Drawn JCH				Date 1 JUL 19	

CUSTOM VA FORM 08-6231B, MAY 2012

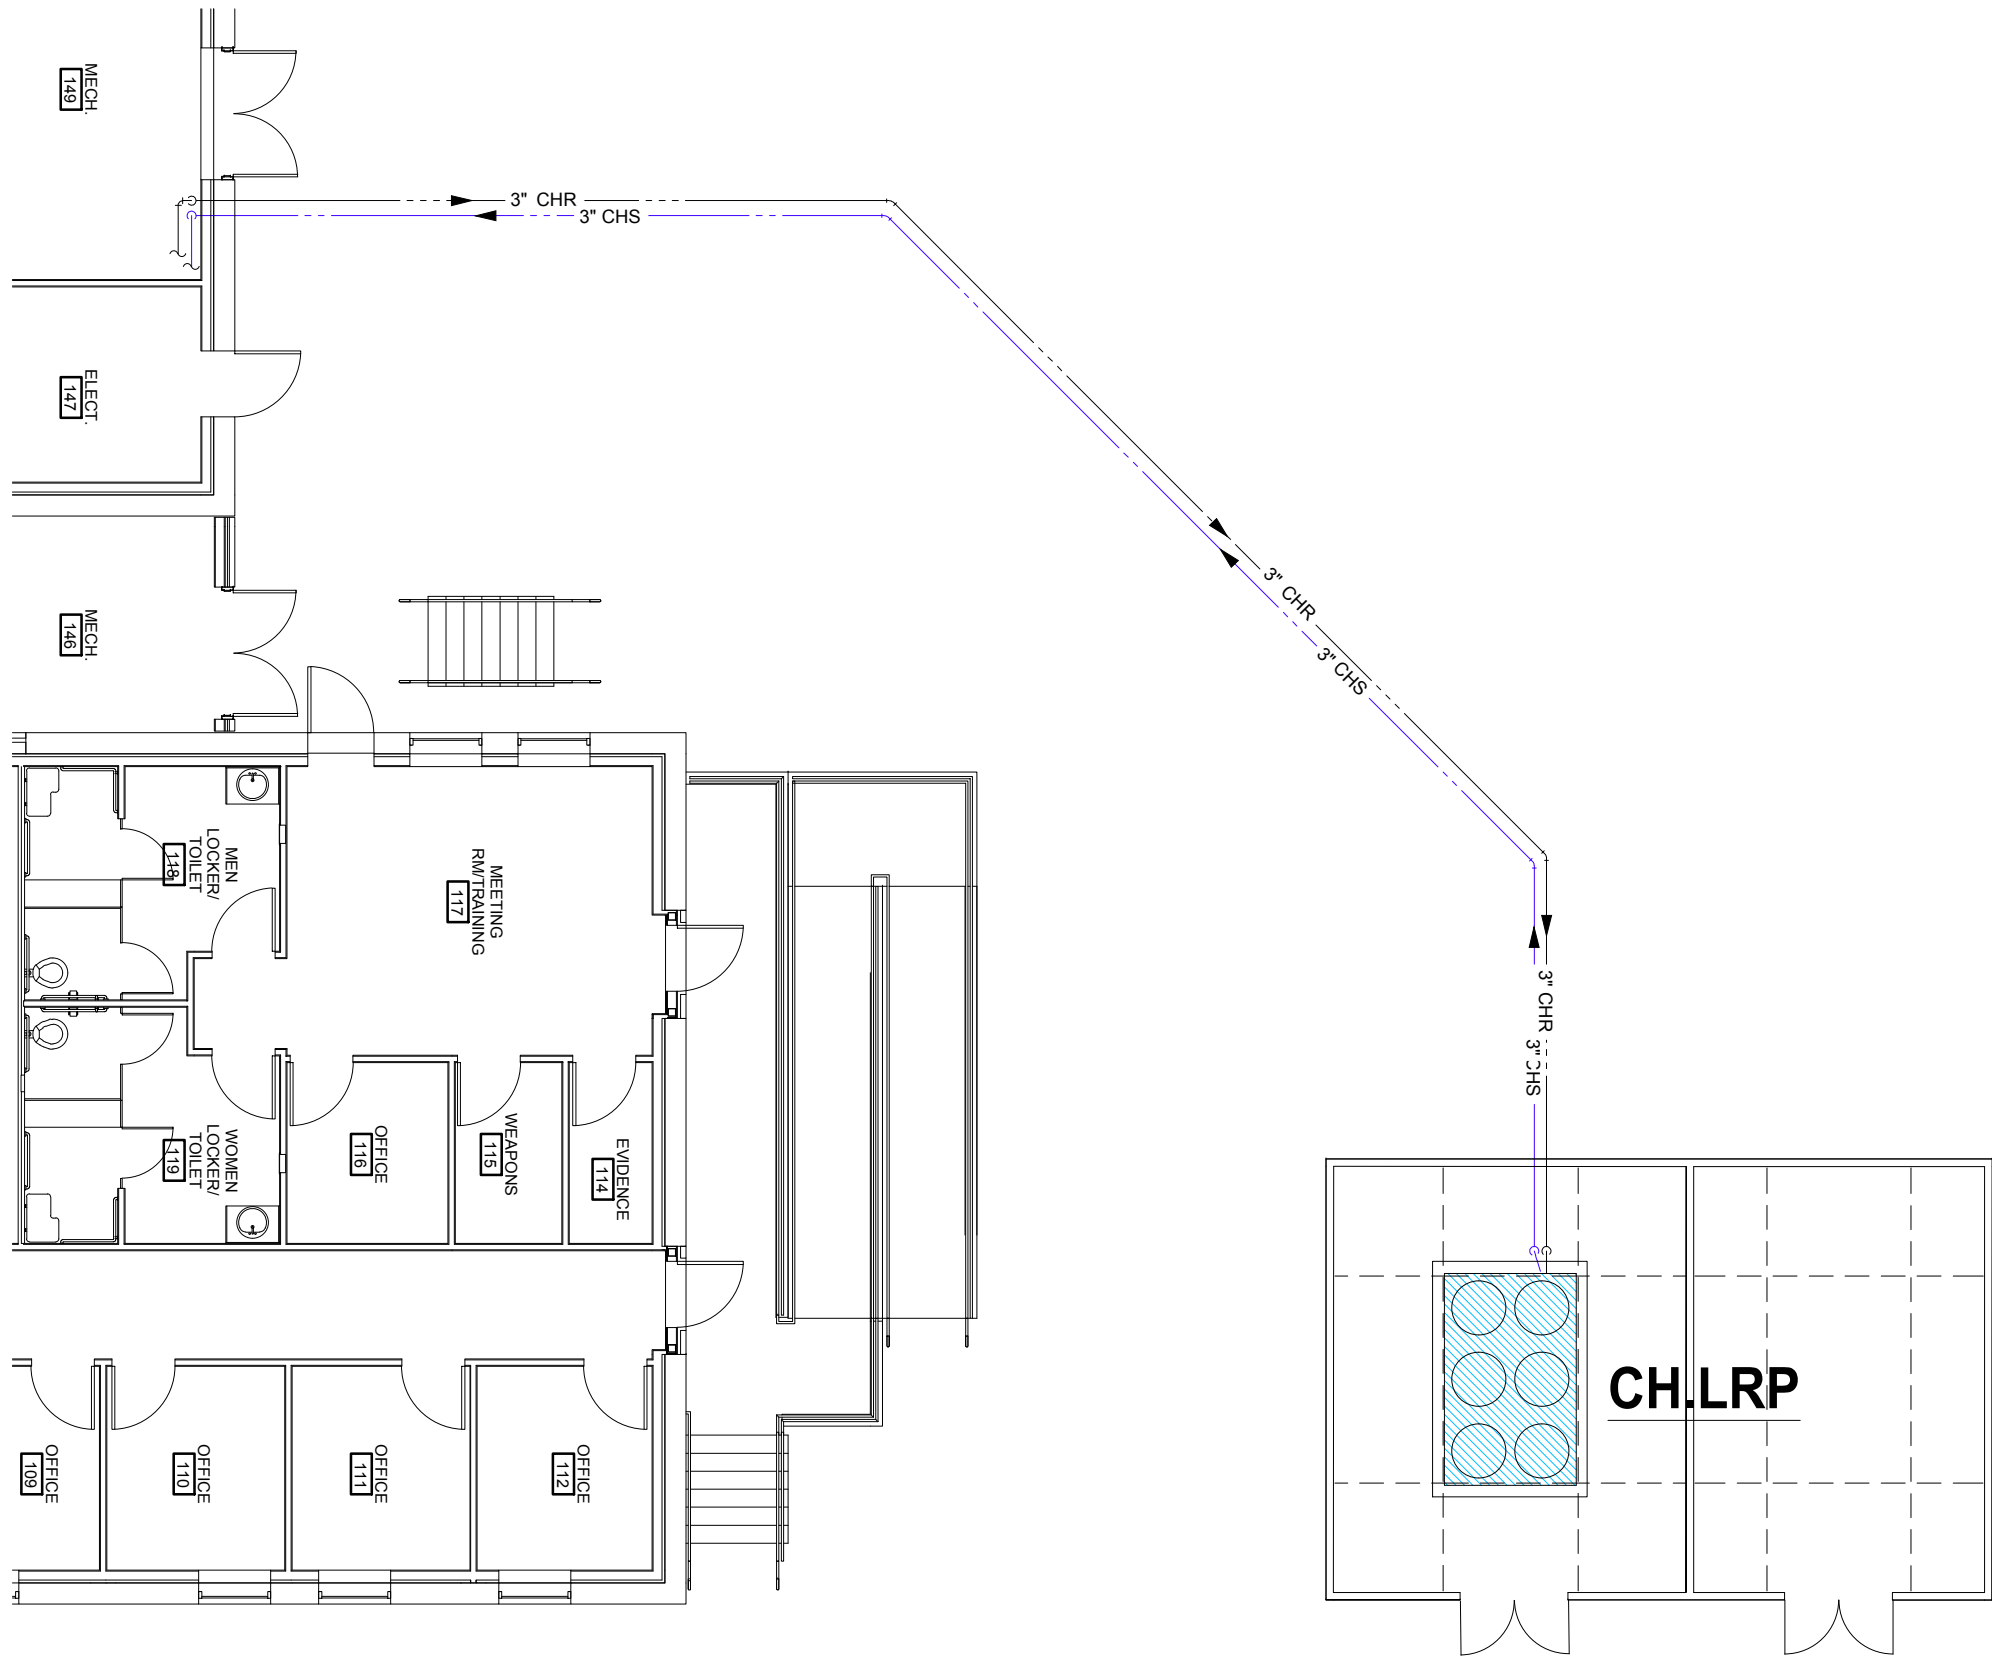

Notes and/or Revisions:	Date

CUSTOM VA FORM 08-6231B, MAY 2012

Approved: Assistant Chief, Engineering Service
Approved: Utility Systems Supervisor


Project Title	Preventive Maintenance Service Contract HVAC/R
One inch or not to scale!	Scale: 3/32"= 1'-0"

Drawing Title	EQUIPMENT LOCATION PLAN
Location	Fayetteville, Arkansas
Checked	TRB
Drawn	JCH
Date	1 JUL 19


Project Number	20 PM HVAC/R
Building Number	32
Drawing Number	ME104
Sheet	5 of 10

Engineering Service

VETERANS HEALTH CARE SYSTEM
OF THE OZARKS

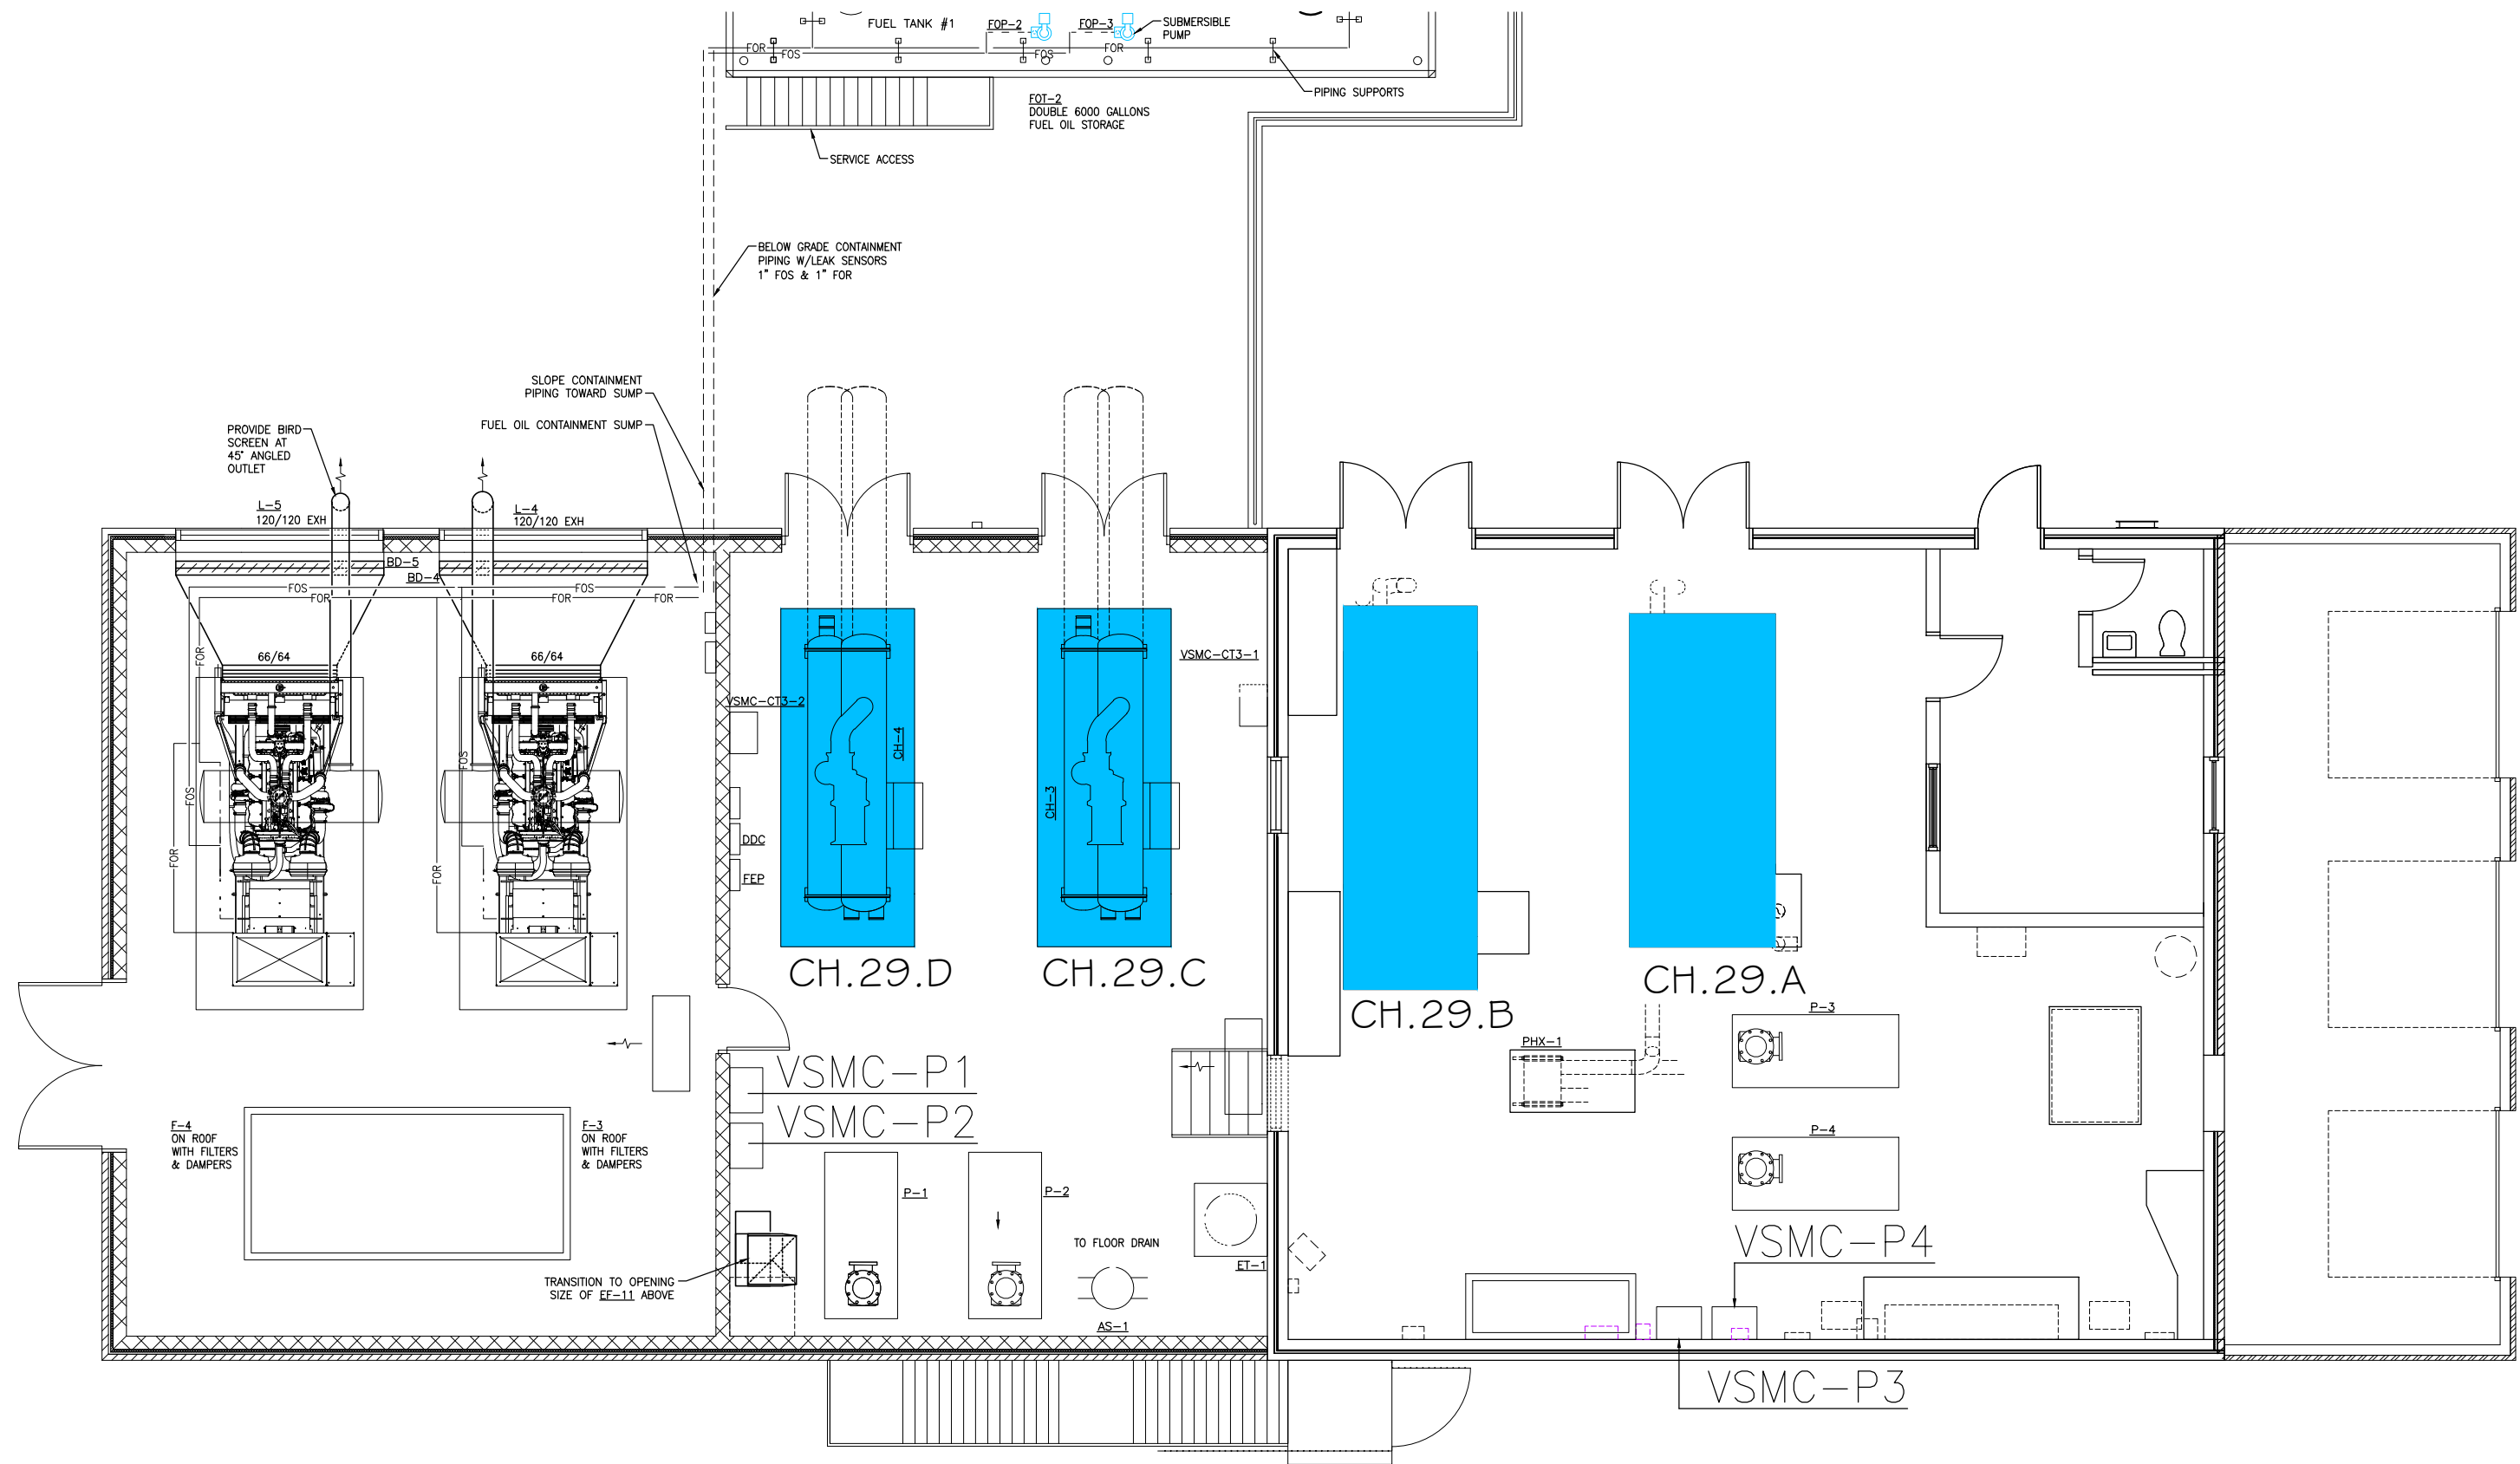

<div>Notes and/or Revisions:</div> <div>CUSTOM VA FORM 08-6231B, MAY 2012</div>		Approved: Assistant Chief, Engineering Service		Project Title Preventive Maintenance Service Contract HVAC/R		Drawing Title EQUIPMENT LOCATION PLAN		Project Number 20 PM HVAC/R		<div>Engineering Service</div> <div>VETERANS HEALTH CARE SYSTEM OF THE OZARKS</div>
		Approved: Utility Systems Supervisor		One inch or not to scale: 0 1		Location Fayetteville, Arkansas		Building Number 29		
				Scale: 1/8" = 1'-0"		Drawing Number ME105		Drawing Number ME105		
				Checked TRB		Date 2 JUL 19		Sheet 6 of 10		

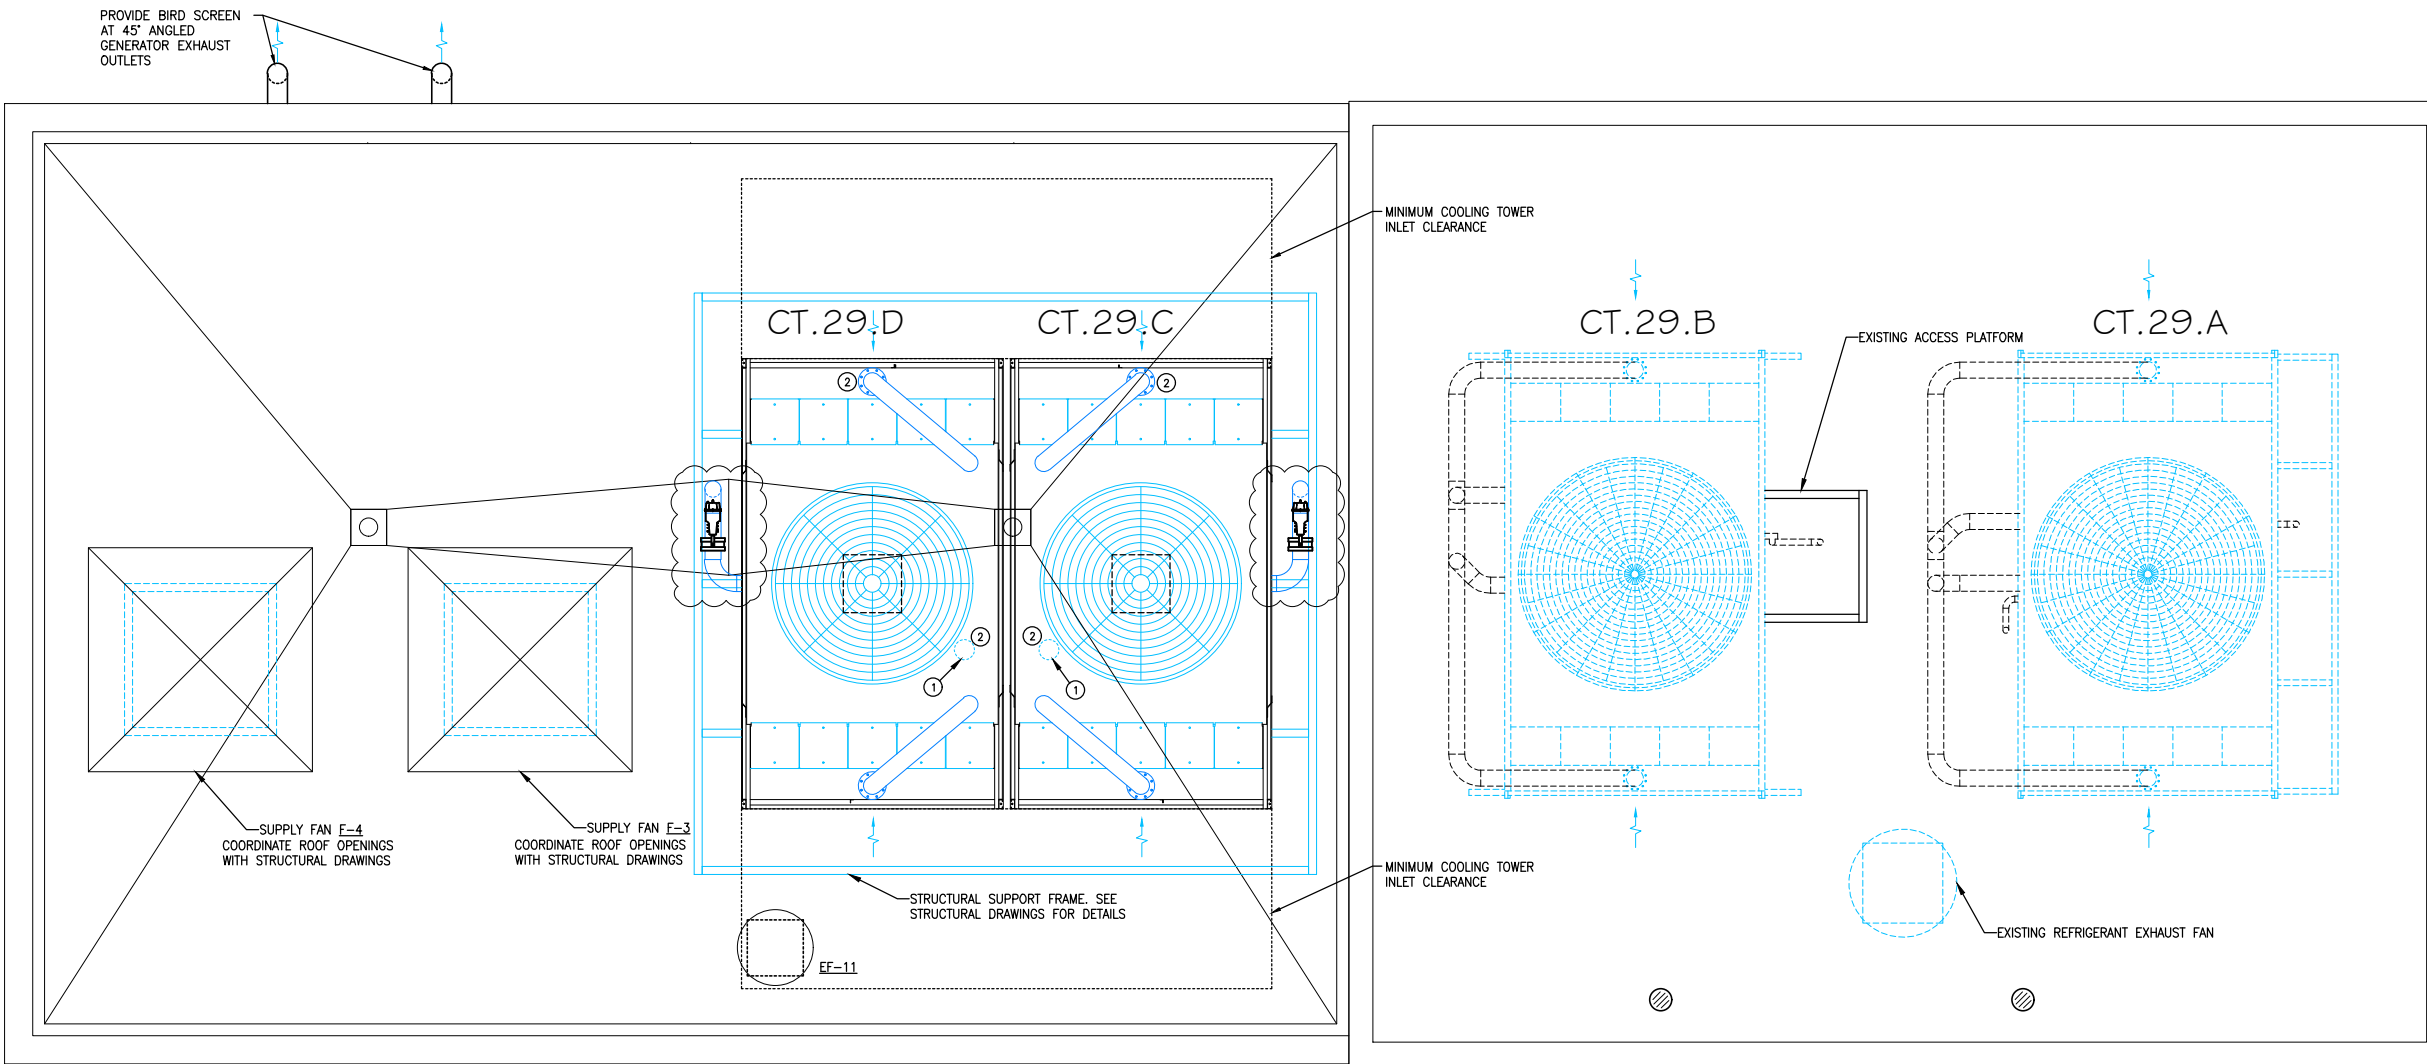

ROOF PLAN - BUILDING 29
SCALE: 1/8" = 1'-0"

Notes and/or Revisions:	Date

CUSTOM VA FORM 08-6231B, MAY 2012

Approved: Assistant Chief, Engineering Service
Approved: Utility Systems Supervisor


Project Title Preventive Maintenance Service Contract HVAC/R
One inch or not to scale! 0 1
Scale: 1/8" = 1'-0"


 
Drawing Title EQUIPMENT LOCATION PLAN
Location Fayetteville, Arkansas
Checked TRB
Drawn JCH
Date 1 JUL 19


Project Number 20 PM HVAC/R
Building Number 29
Drawing Number ME106
Sheet 7 of 10



Engineering Service

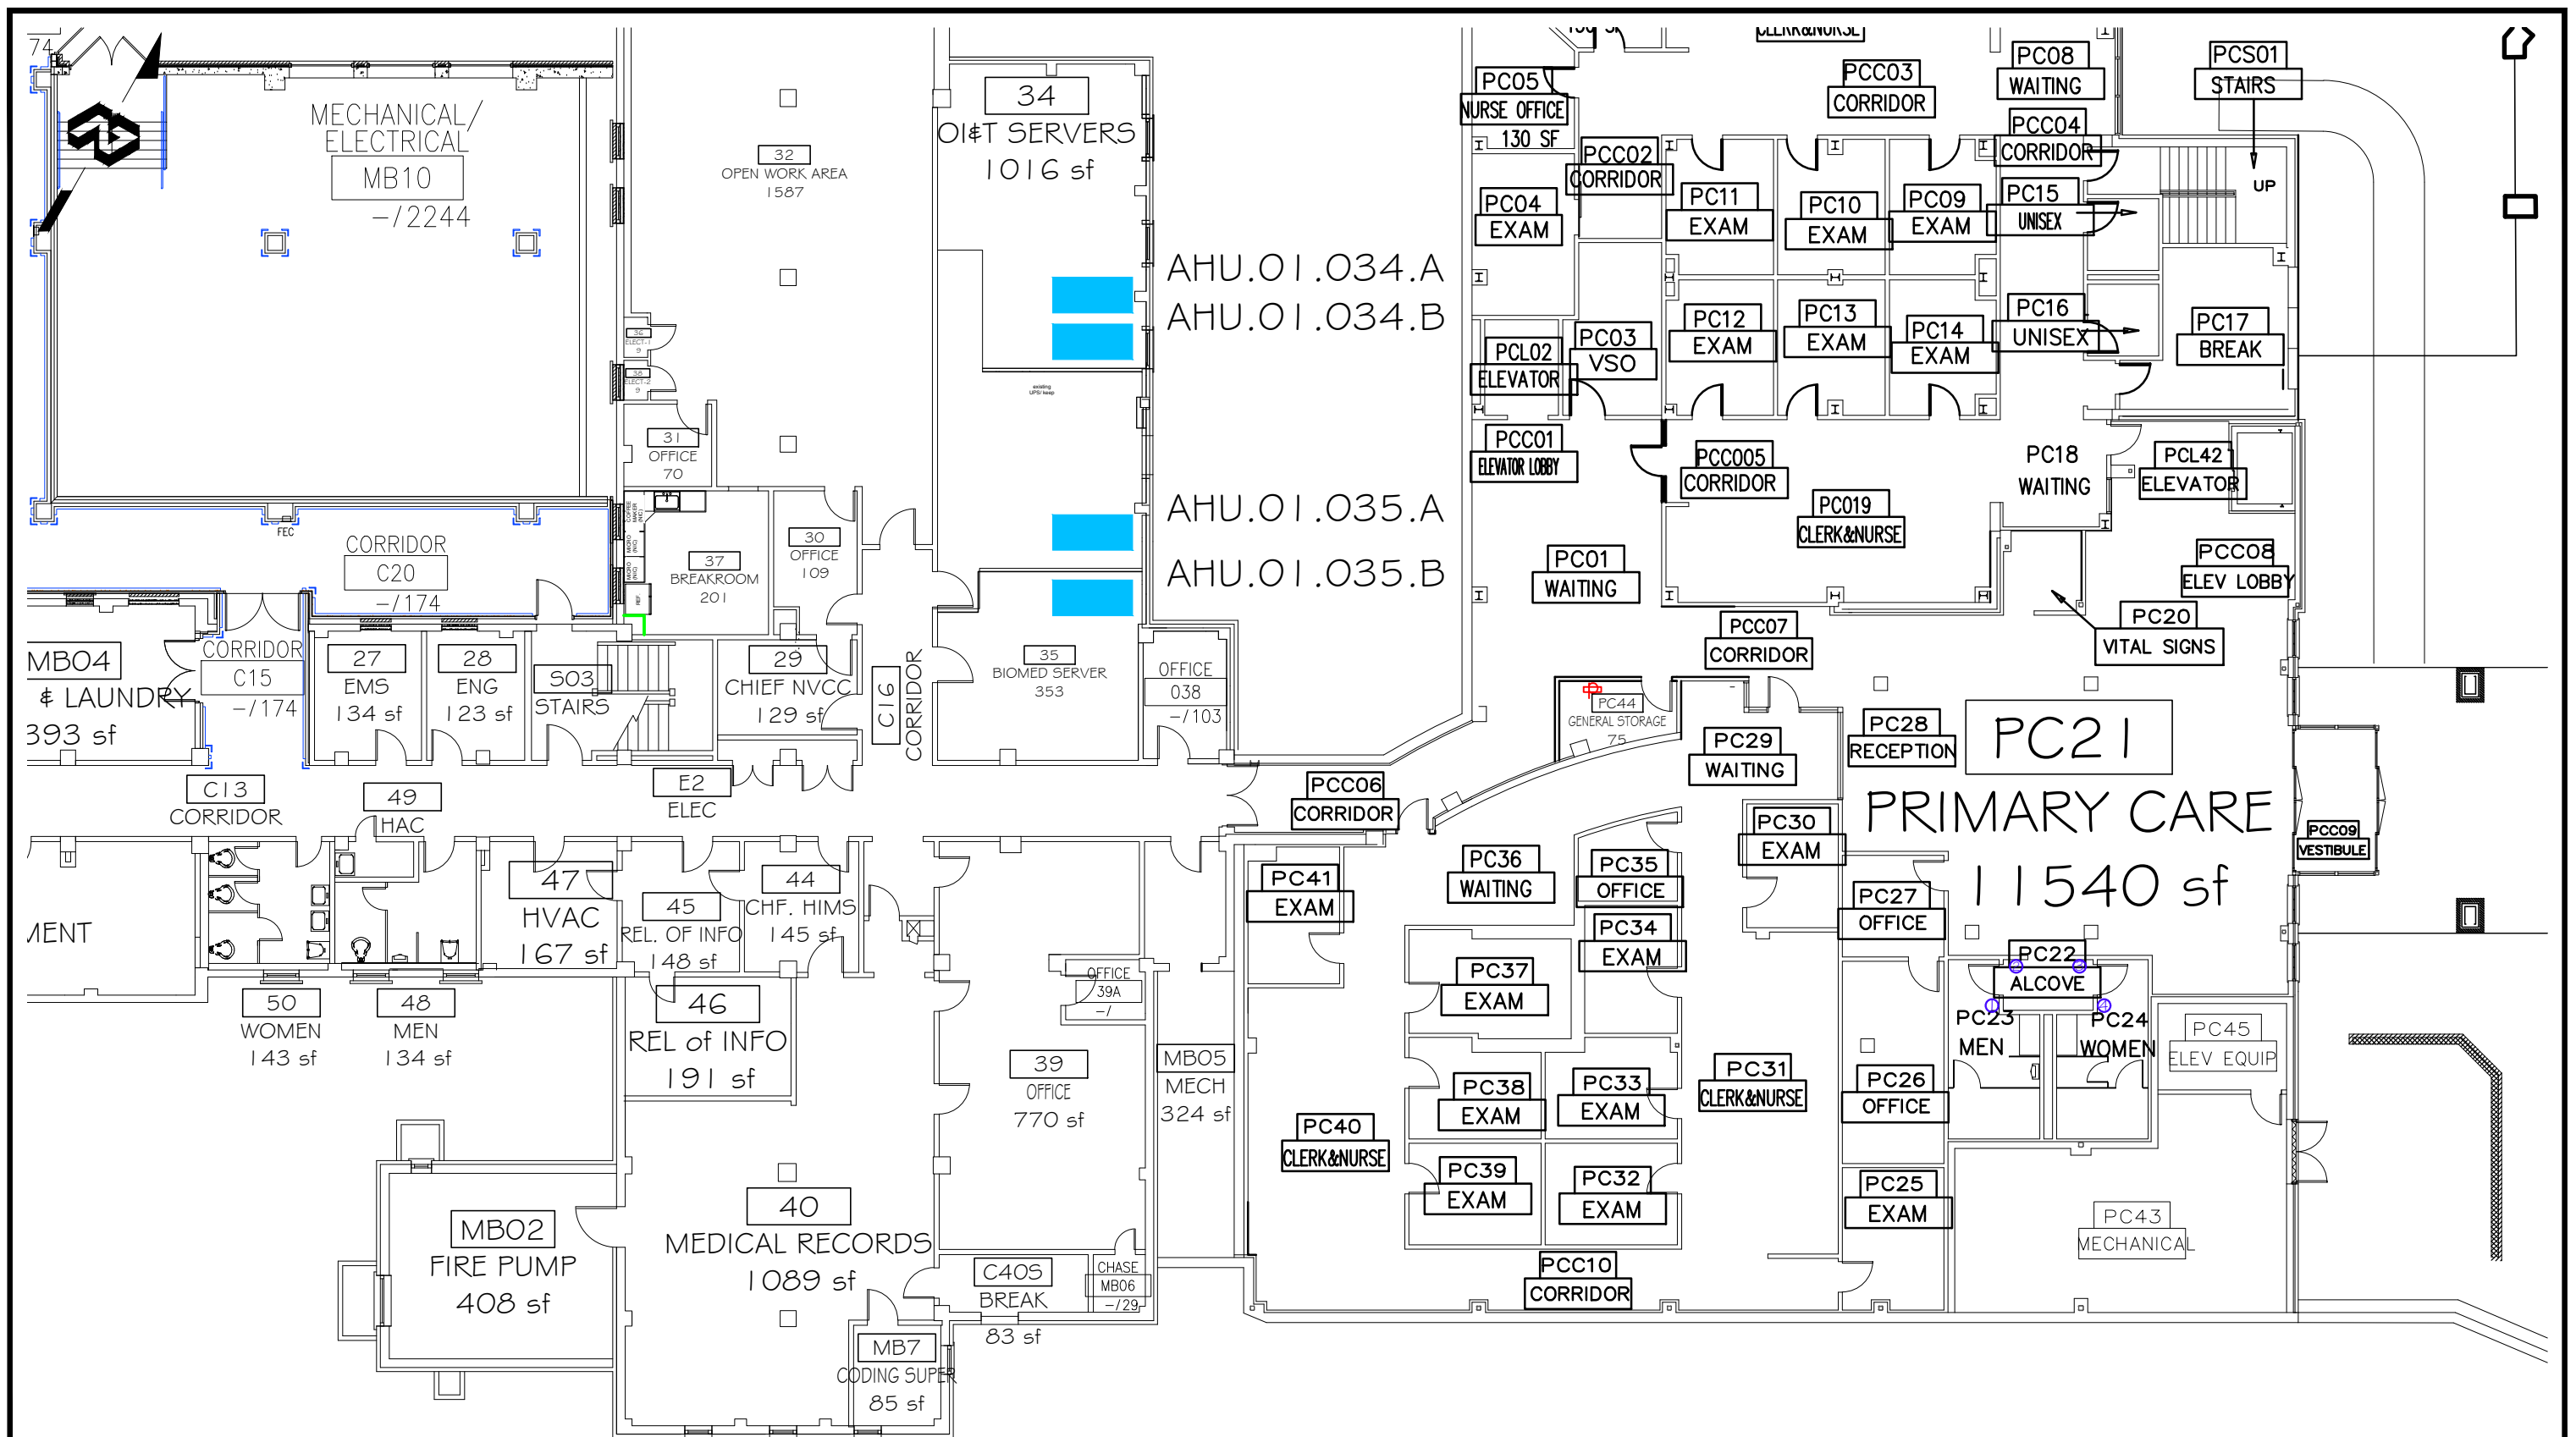
**VETERANS HEALTH CARE SYSTEM
OF THE OZARKS**


 


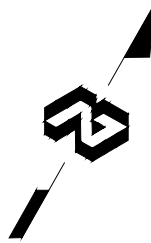Notes and/or Revisions: Date		Approved: Assistant Chief, Engineering Service		Project Title Preventive Maintenance Service Contract HVAC/R		Drawing Title EQUIPMENT LOCATION PLAN		Project Number 20 PM HVAC/R		Engineering Service  VETERANS HEALTH CARE SYSTEM OF THE OZARKS			
		Approved: Utility Systems Supervisor		One inch or not to scale: 		Scale: 1/32" = 1'-0"		Location Fayetteville, Arkansas					
						Checked TRB		Drawn JCH				Date 1 JUL 19	
								Building Number ONE (01)		Drawing Number ME107		Sheet 8 of 10	



AHU.02.1185.A[CU] 
AHU.02.1186.A[CU] 

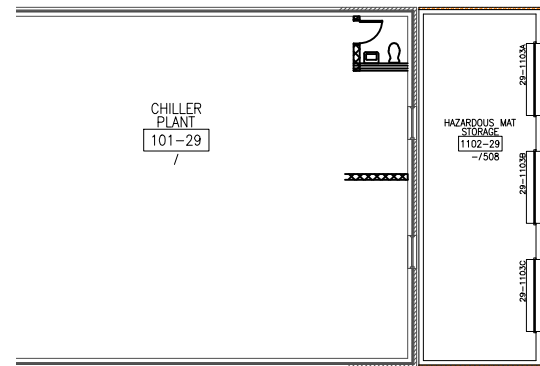

		Approved: Assistant Chief, Engineering Service	Project Title Preventive Maintenance Service Contract HVAC/R	Drawing Title EQUIPMENT LOCATION PLAN	Project Number 20 PM HVAC/R	Engineering Service  VETERANS HEALTH CARE SYSTEM OF THE OZARKS
					Building Number ONE (01)	
		Approved: Utility Systems Supervisor	One inch or not to scale! 	Scale: 3/64"= 1'-0"	Drawing Number ME109	
Notes and/or Revisions:	Date			Location Fayetteville, Arkansas	Sheet 10 of 10	
				Checked TRB	Drawn JCH	Date 2 JUL 19

CUSTOM VA FORM 08-6231B, MAY 2012