


Building 43

SYMBOL LIST	
	FEEDER
	BUS
	LOAD
	MEDIUM VOLTAGE BREAKER
	CT AND MEDIUM VOLTAGE RELAY
	TRANSFORMER
	FUSE
	CIRCUIT BREAKER
	ENGINE-GENERATOR SET
	TRANSFER SWITCH
	EQUIPMENT NOT IN SERVICE (OFF STATE)

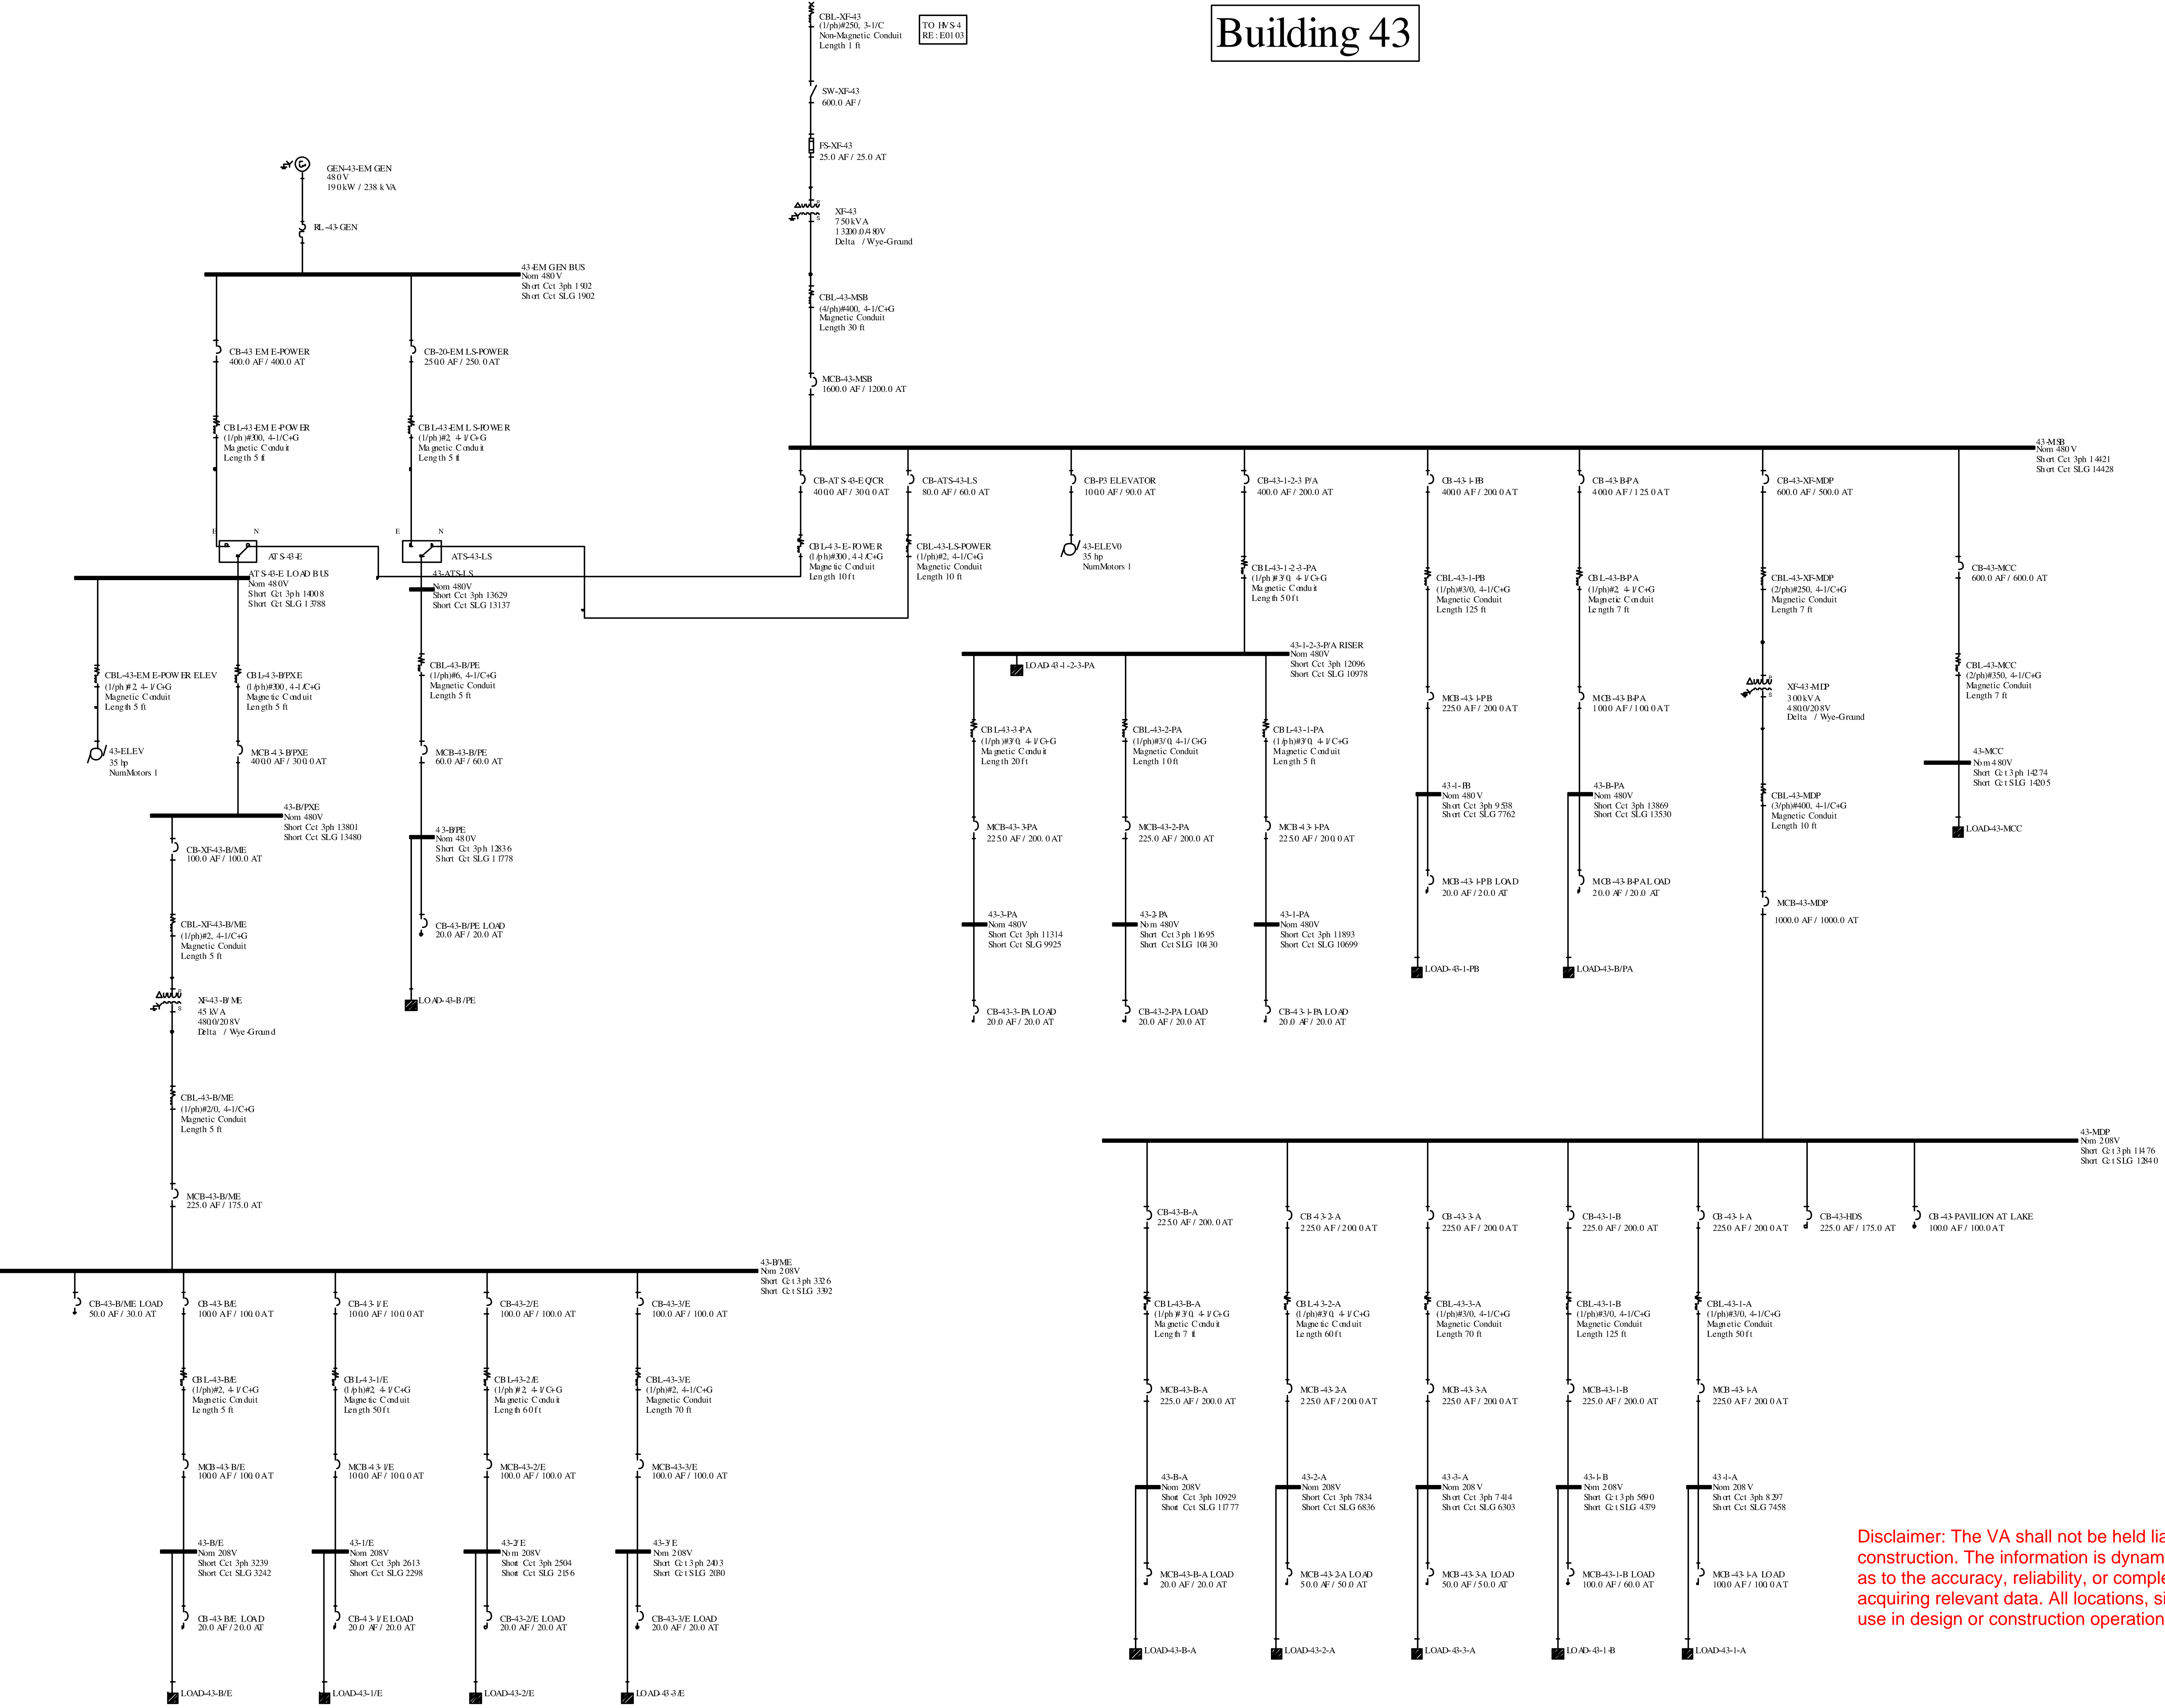

Disclaimer: The VA shall not be held liable for the accuracy of this one-line for design or construction. The information is dynamic and may change over time. The VA gives no warranty as to the accuracy, reliability, or completeness of the data. These plans are intended to aid in acquiring relevant data. All locations, sizes, and other information shall be field verified before use in design or construction operations.

<div>Revisions:</div>		CONSULTANTS:		ARCHITECT/ENGINEER:		<div></div>		Drawing Title BUILDING 43 ONE-LINE DIAGRAM		Project Title VETERANS HEALTH CARE SYSTEM MILWAUKEE, WI ELECTRICAL CONDITION ASSESSMENT		Project Number Building Number 43		Office of Construction and Facilities Management	
								Approved: Project Director		Location MILWAUKEE, WI		Drawing Number E0116			
Date										Date 11/24/2017		Checked Drawn			

Dwg 16 of 45