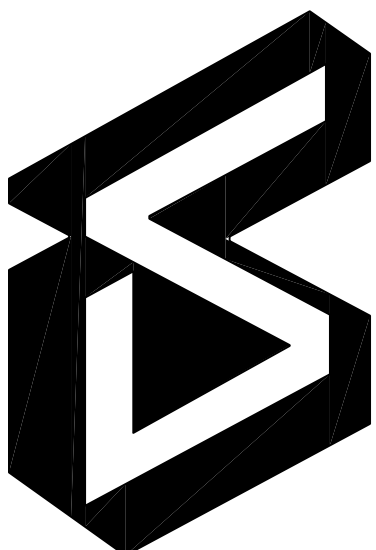


[illegible]

Dept. of Veterans Affairs
Medical Center
2101 Elm Street North
Fargo, ND 58102




IMAGE GROUP INC.
403 CENTER AVENUE, SUITE 300
MOORHEAD, MN 56560


IMAGE GROUP INC., Architecture & Interiors
SOLEN & LARSON ENGINEERING, Structural Engineers
OBERMILLER NELSON ENGINEERING, Mechanical Engineers

I hereby certify that this plan specification, or report was prepared by me or under my direct supervision, and that I am duly Registered Architect under the laws of the State of North Dakota.


Plummer Manning

Date 7/11/2012 Reg. No. 378


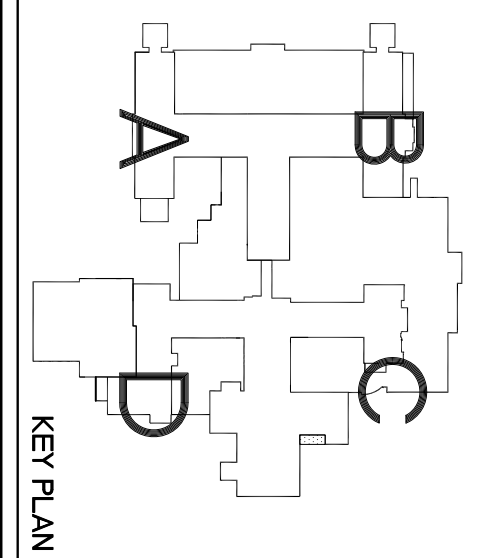


Drawing Title CANOPY PLANS AND DETAILS	Project Title VA MEDICAL CENTER SMOKING SHELTER ROOF	Date JULY 11, 2012
VA Project No. Contract No. VA263-P-1217 VA263-C-	Designed By RM	Scale AS SHOWN
Building No. 1	Checked By RM	Drawing No. A1
Alternate Title PLAN BASEDING	Location VA MEDICAL CENTER PARO, IN	Date 2 of 3
 Department of Veterans Affairs		


EAST ELEVATION
1/8"-1'-0"

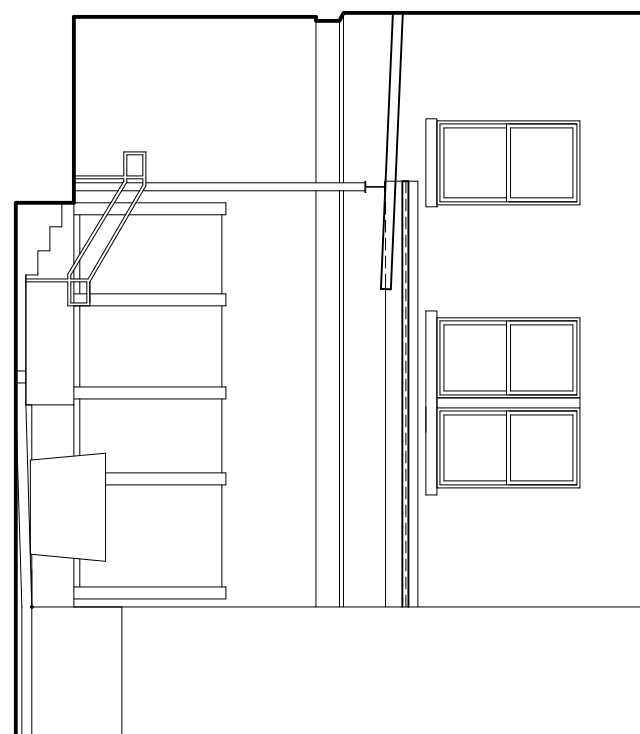


NORTH ELEVATION
1/8"=1'-0"

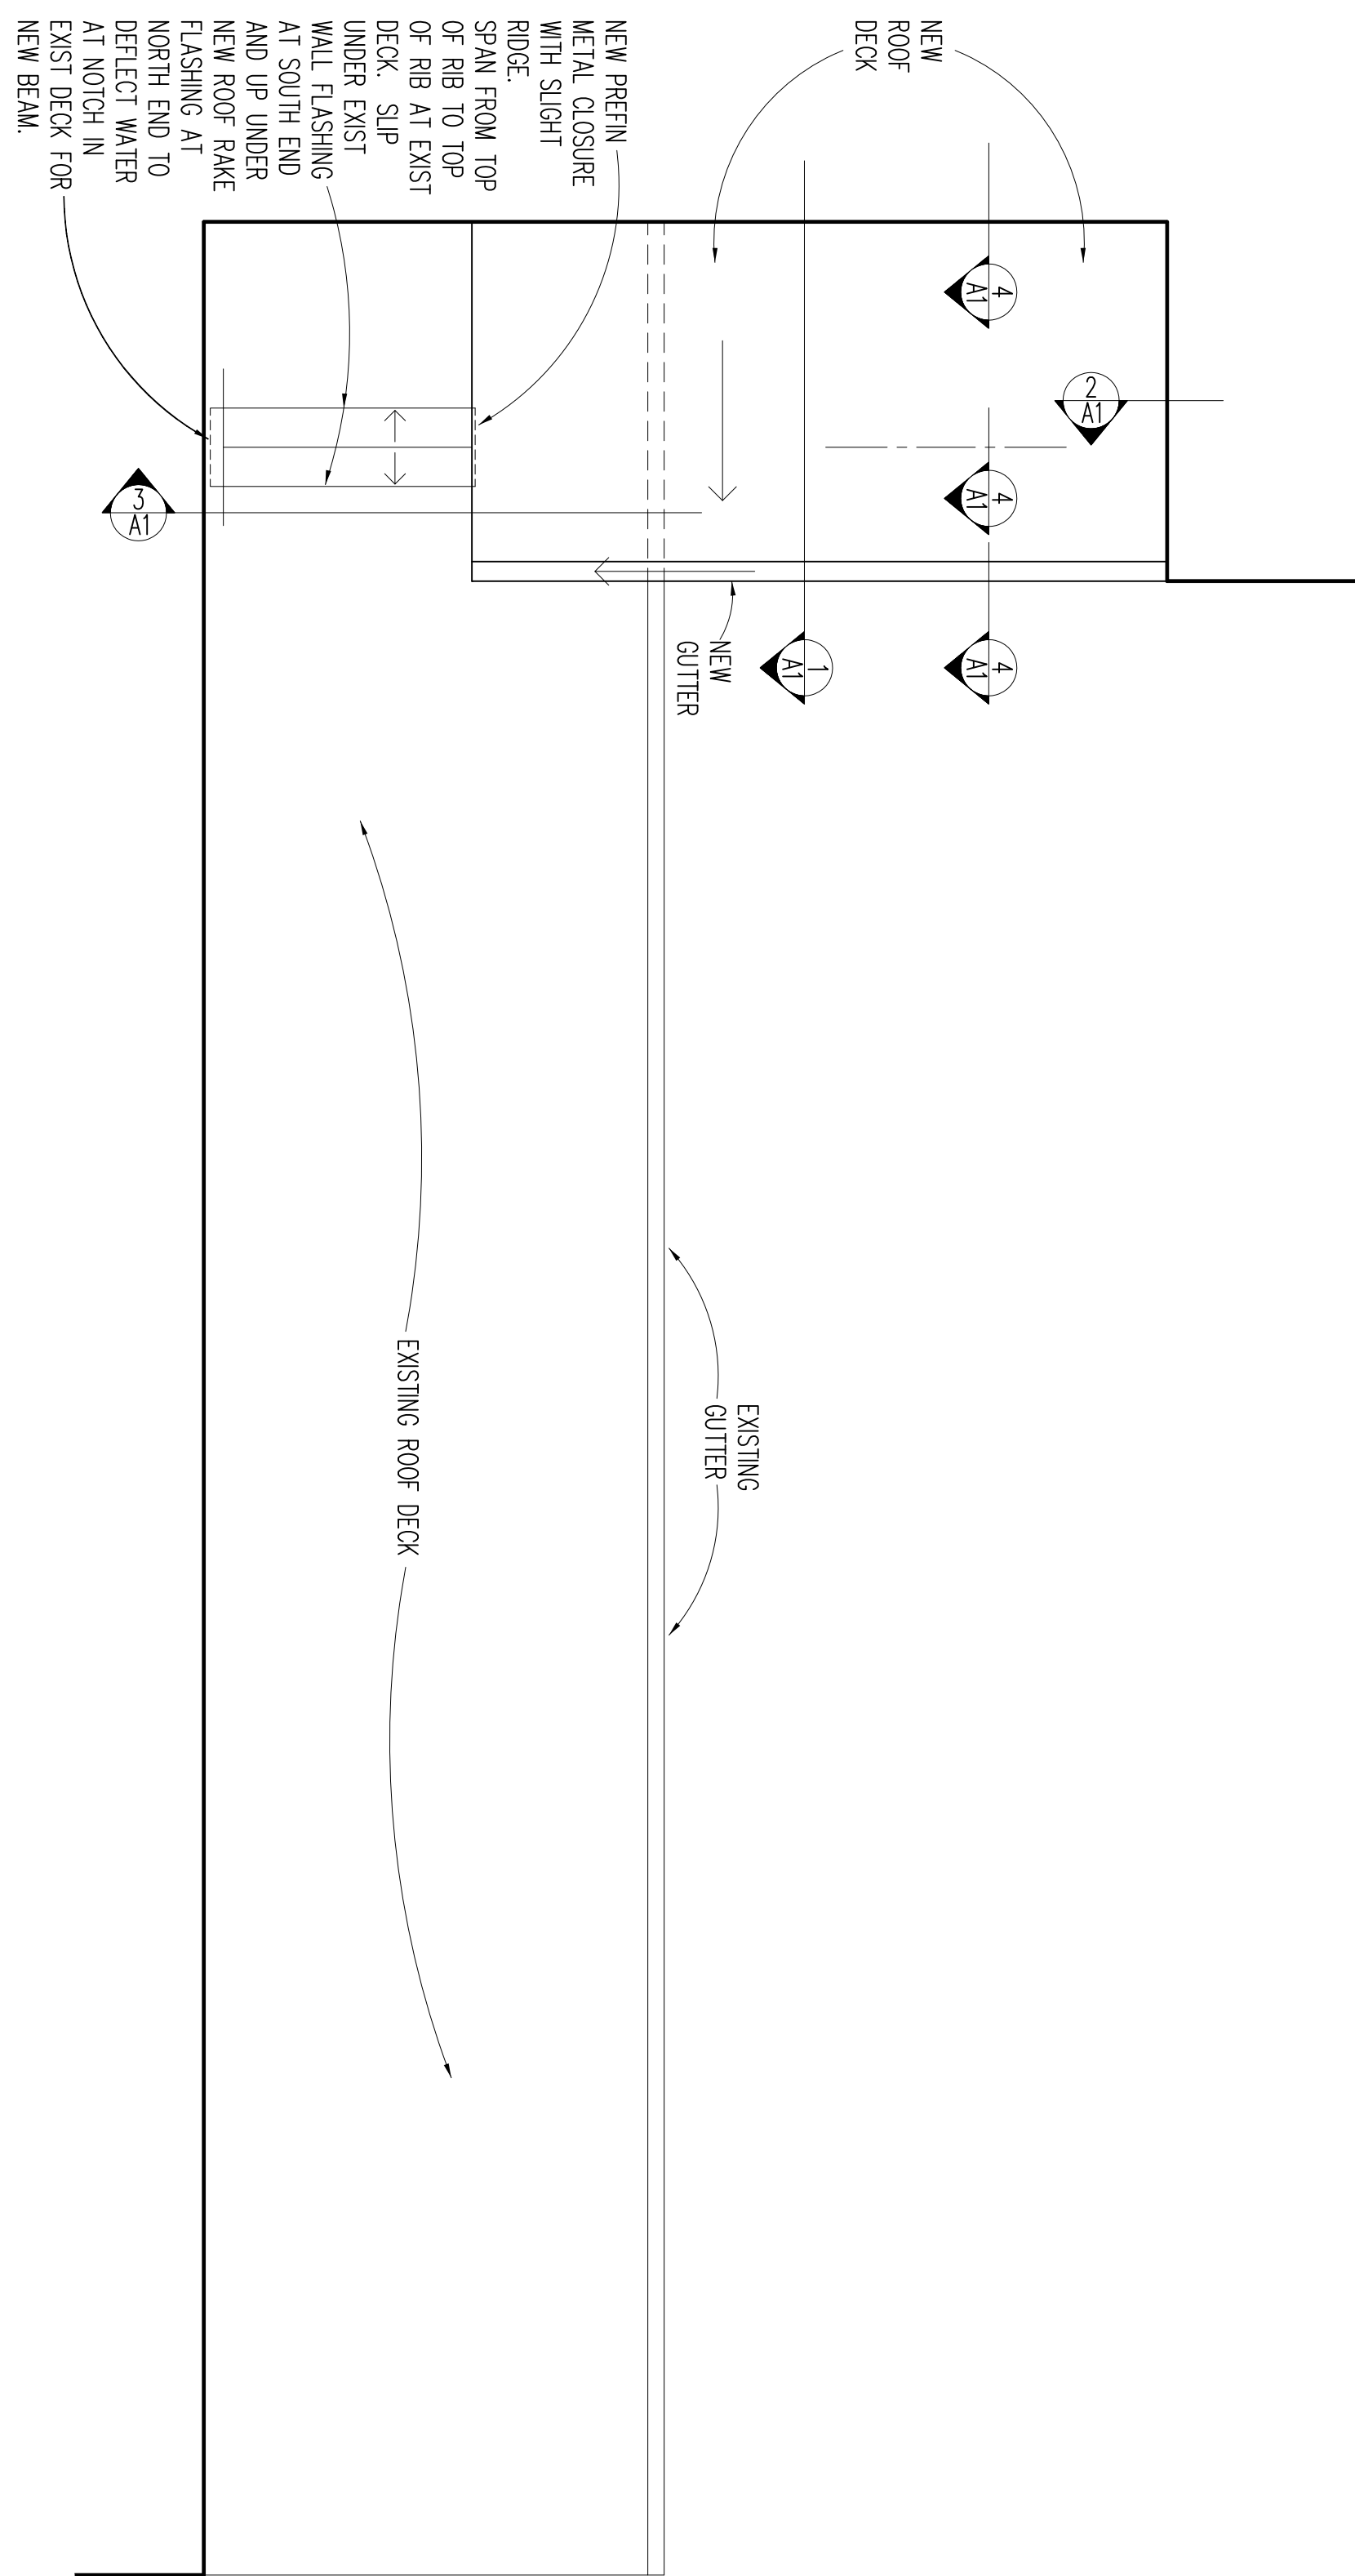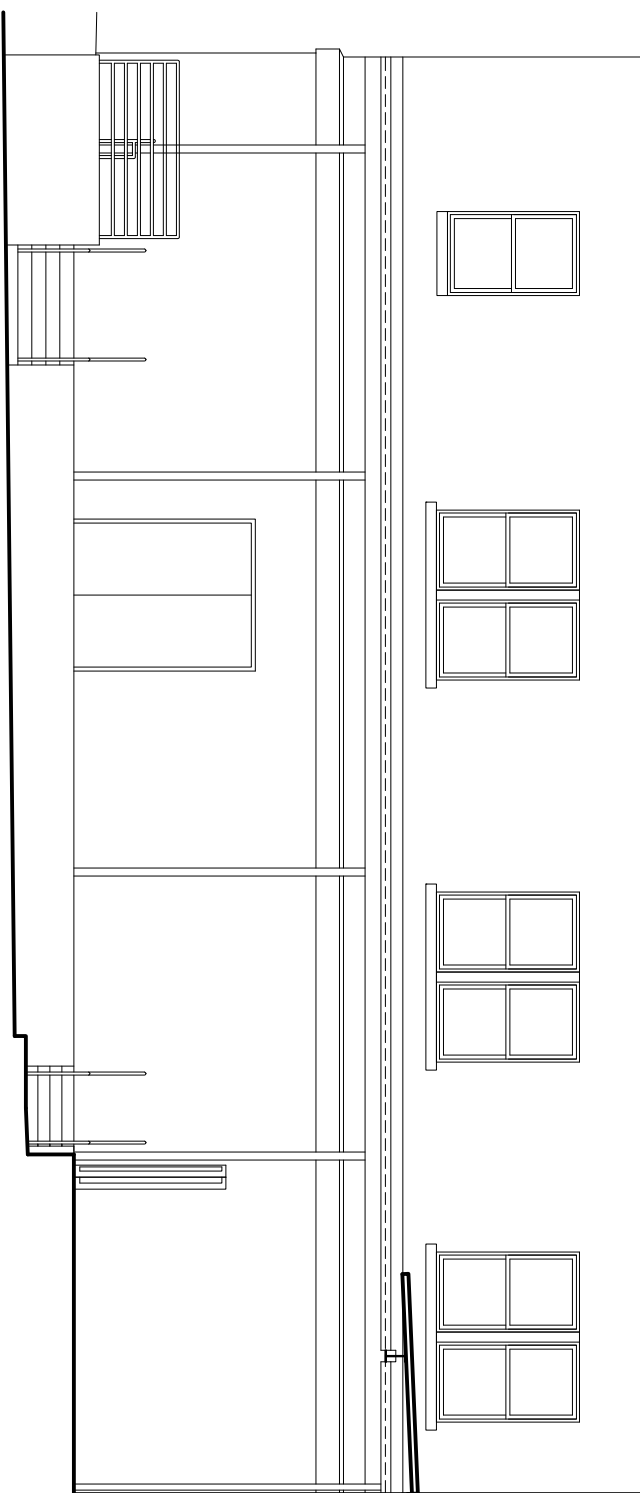


PARTIAL CANOPY PLAN

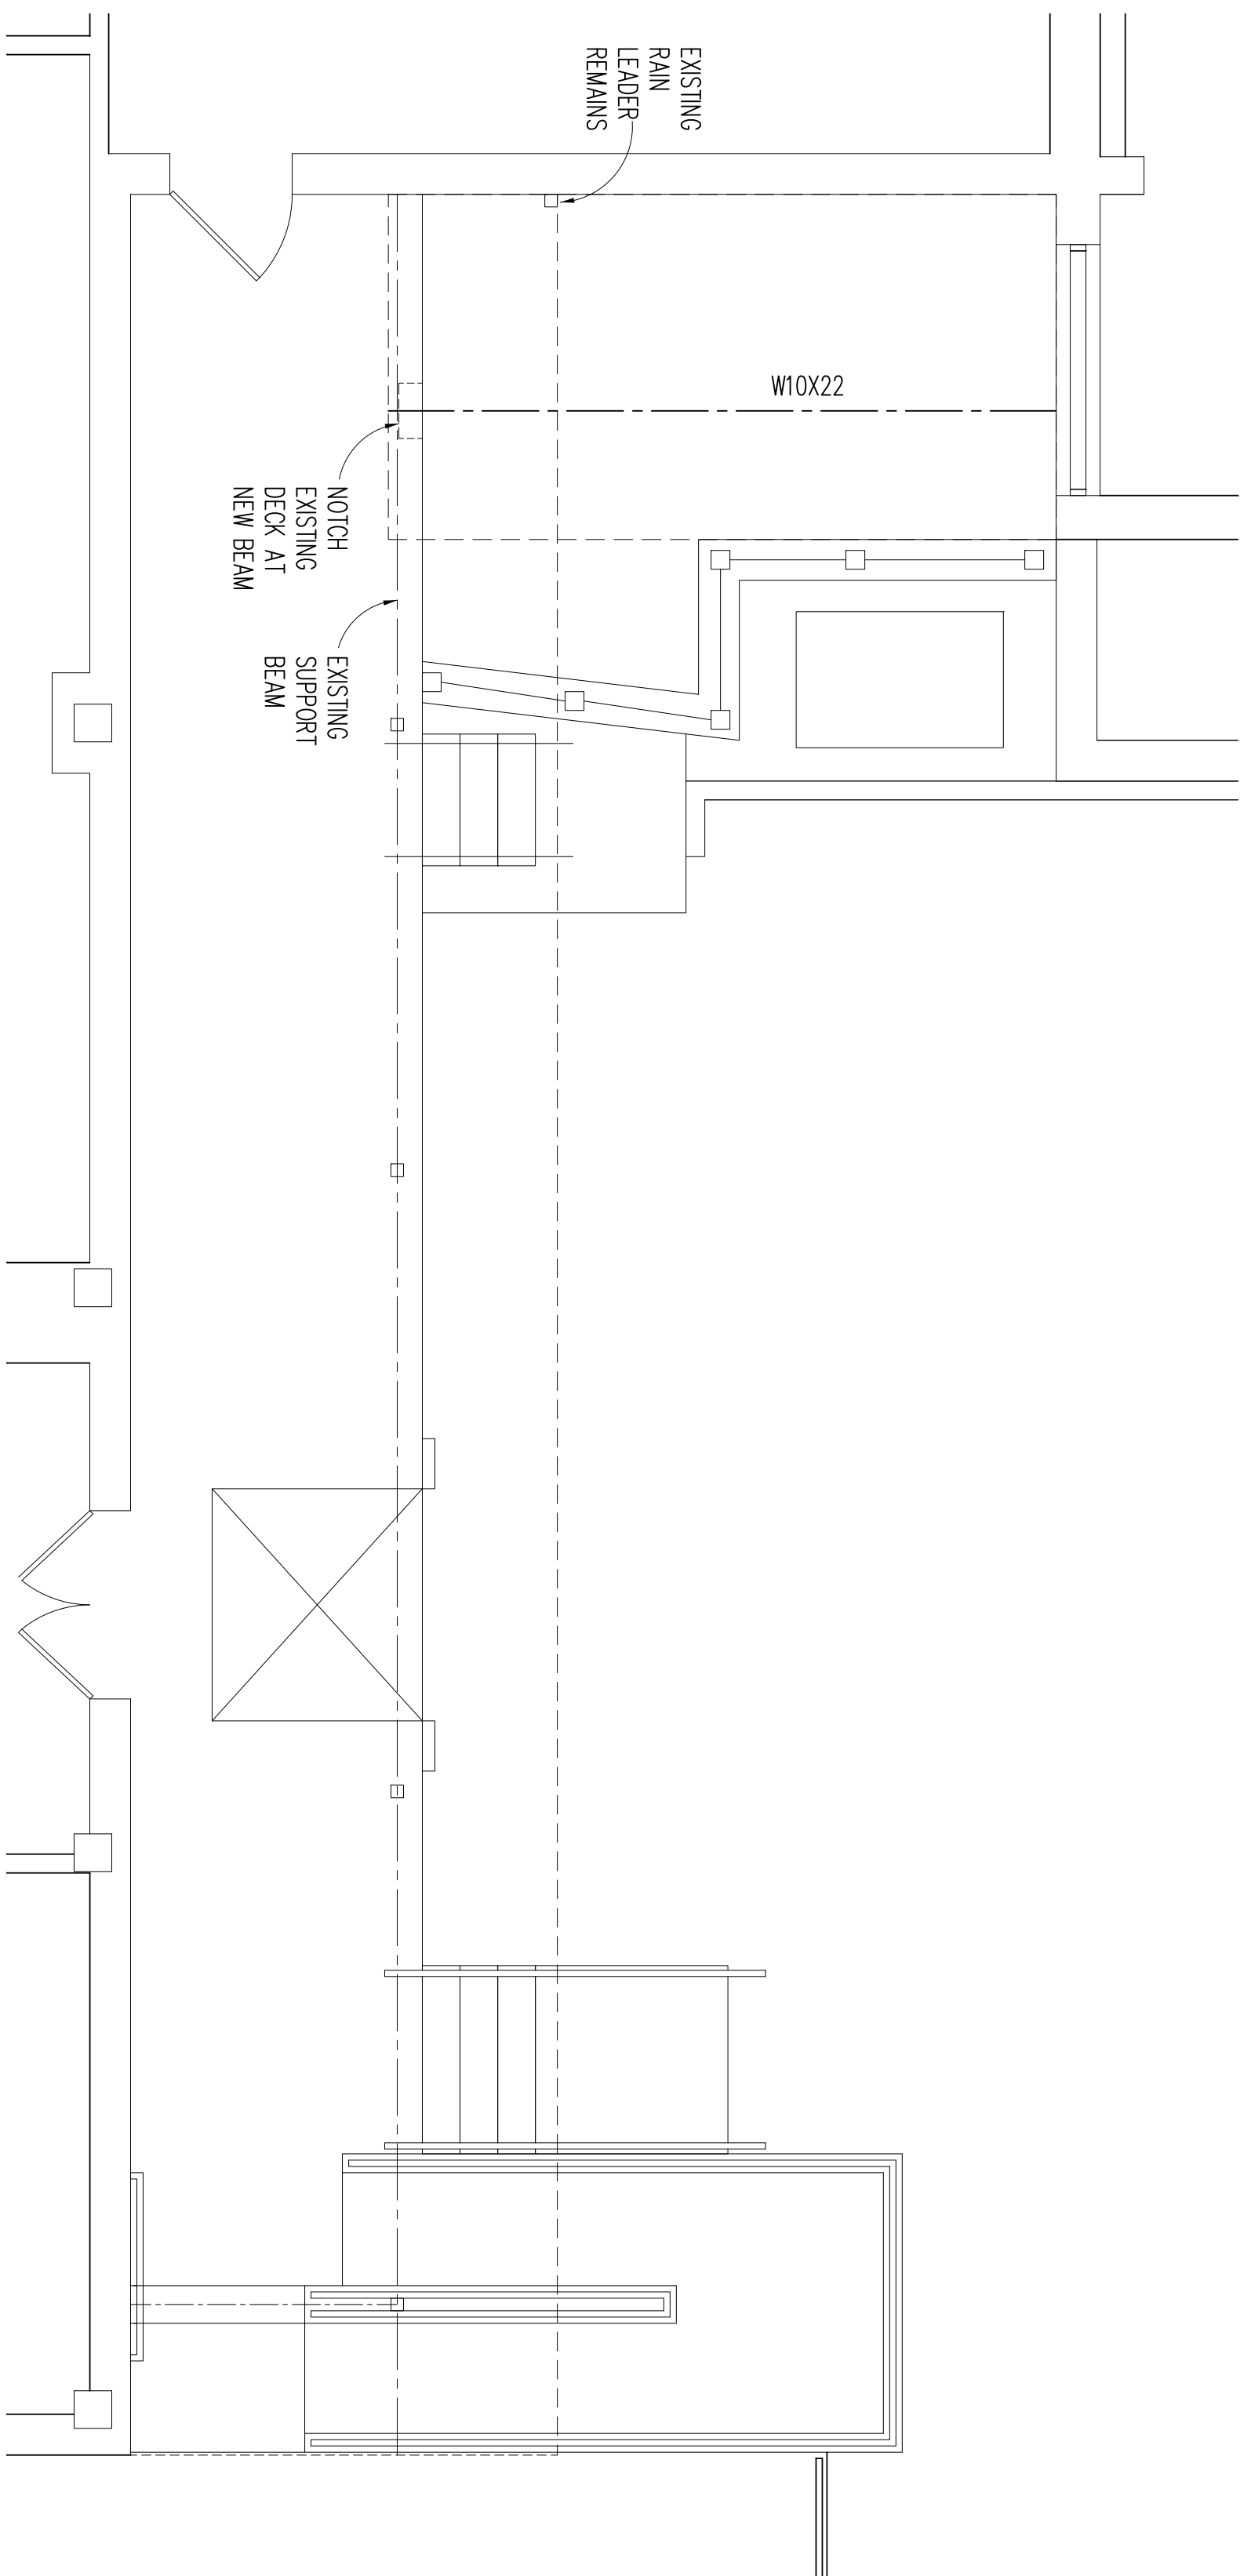


CANOPY FRAMING PLAN

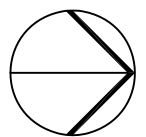


1 DETAIL • EXISTING CANOPY AND MASONRY

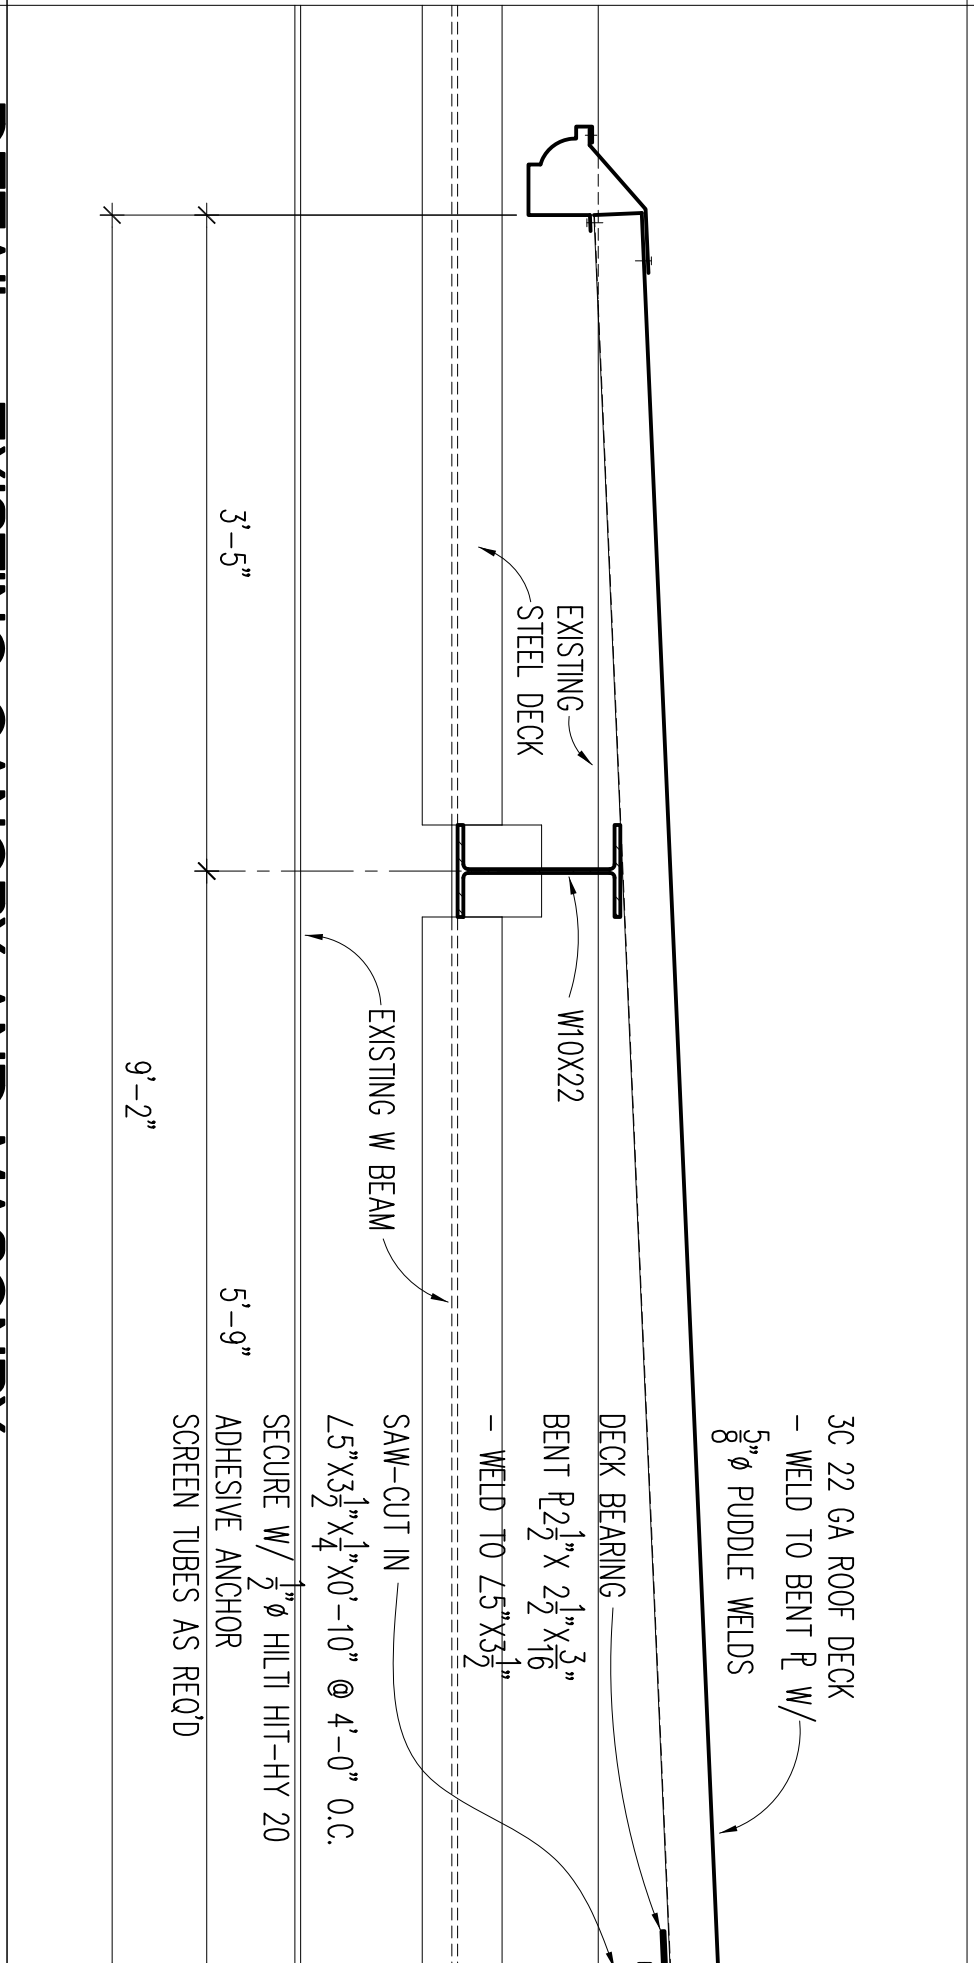


2 DET. • EXIST. MASONRY
A1 $1^{\circ}=1^{\circ}-0^{\circ}$

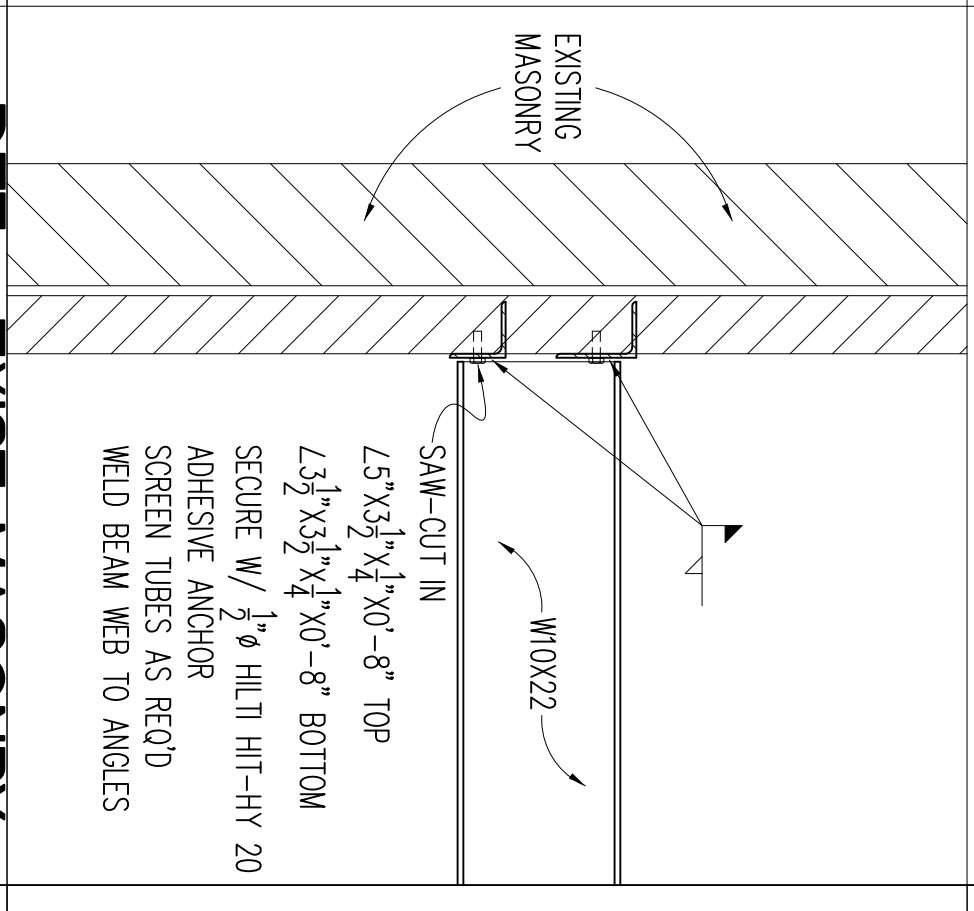

3 FLASHING DETAIL AT EXISTING AND NEW CANOPIES

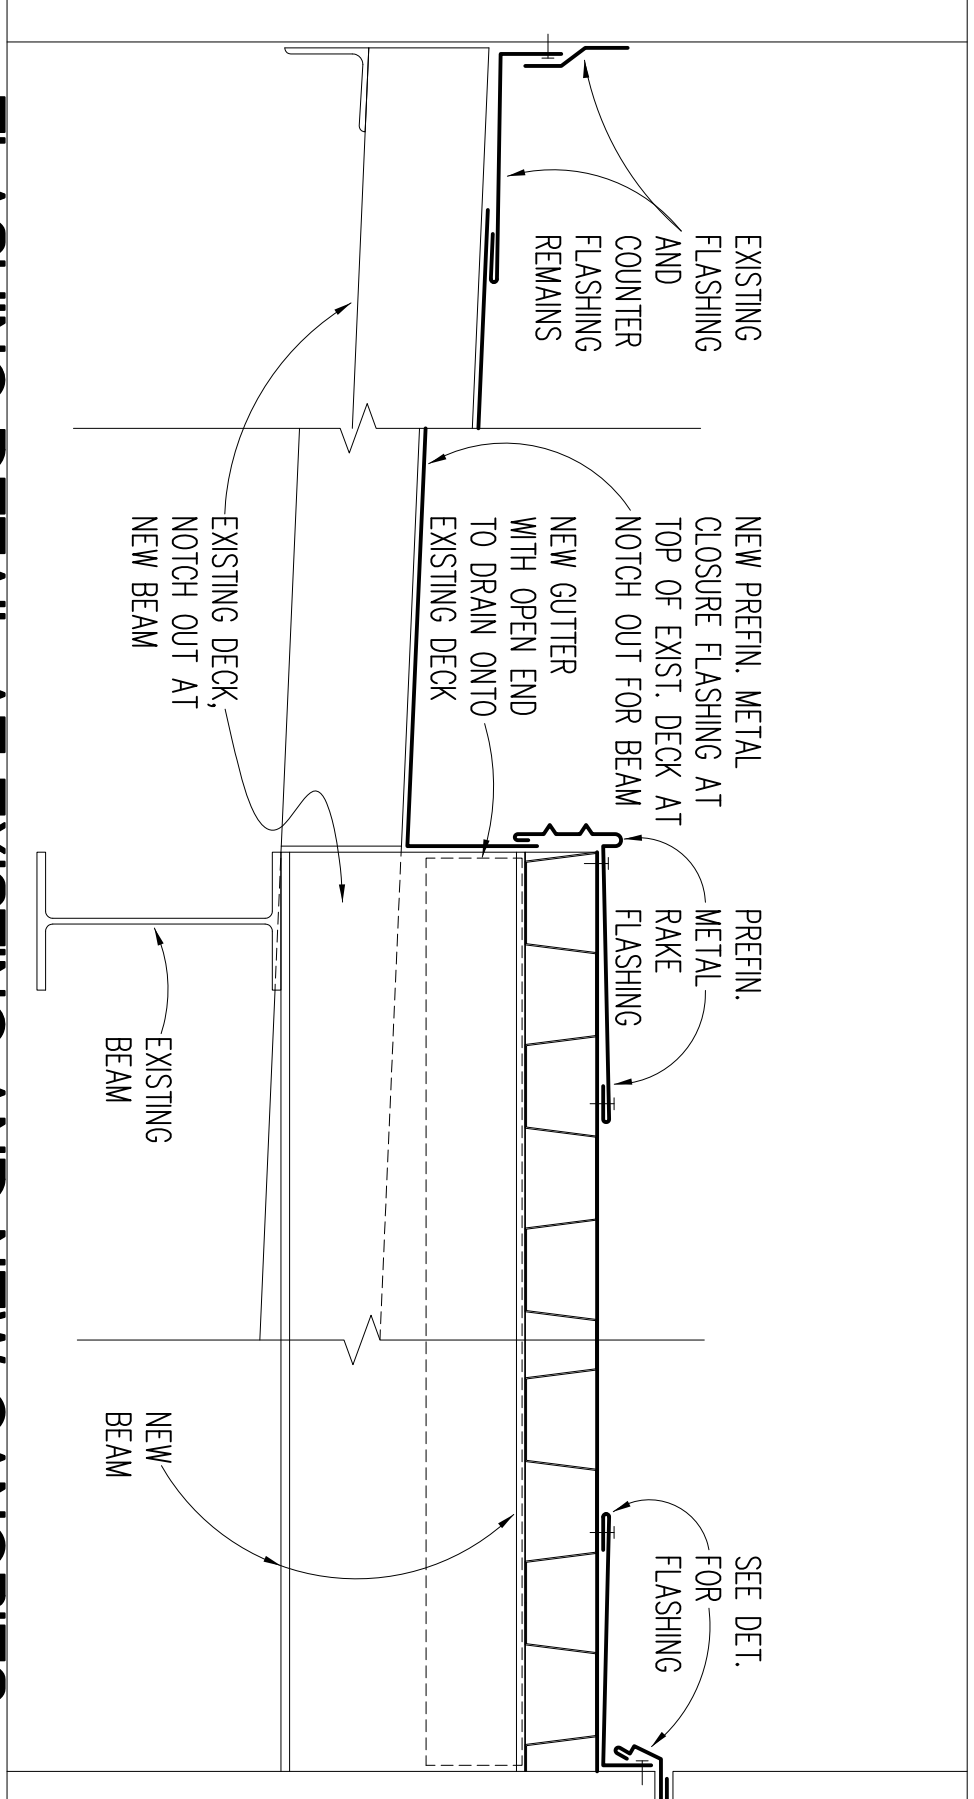

4 FLASHING DETAIL AT NEW CANOPY

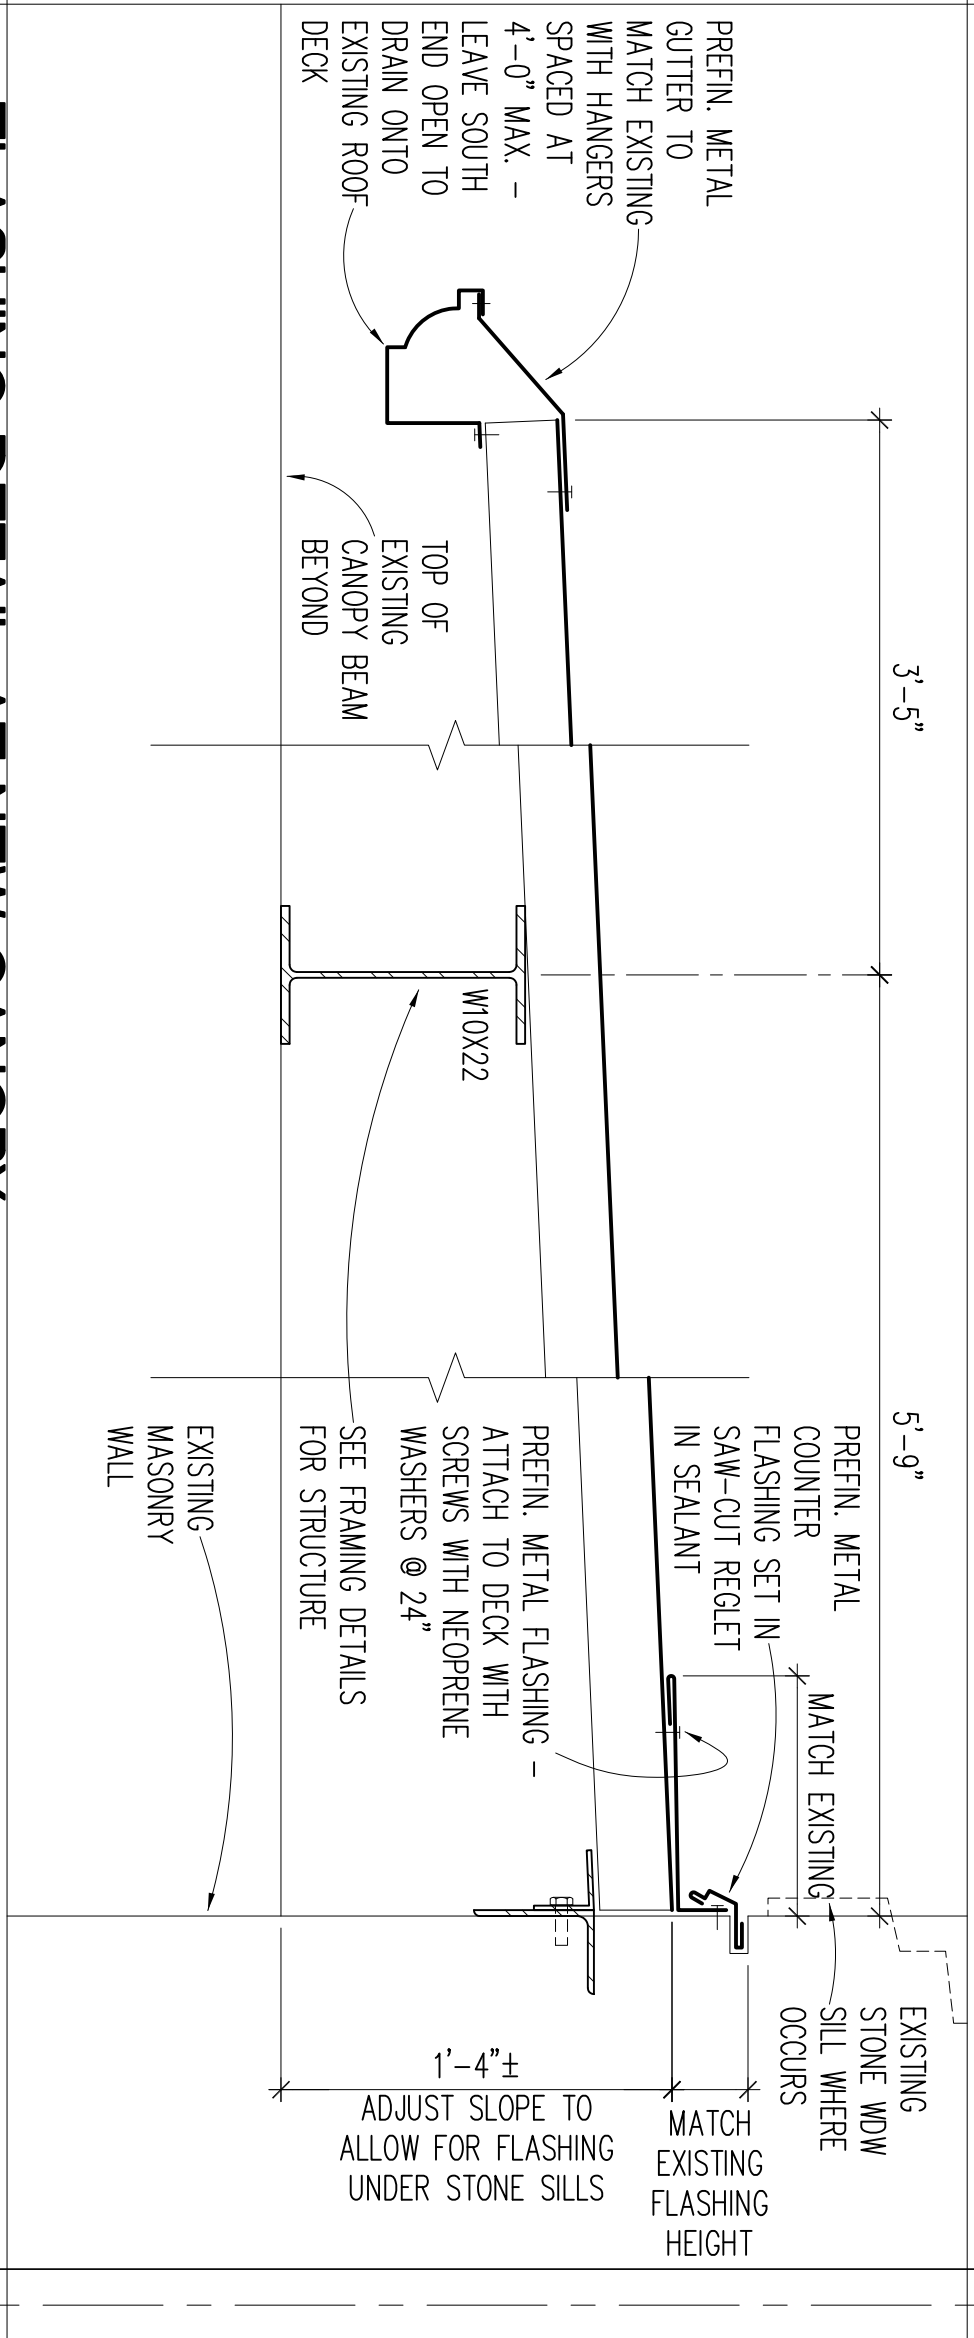


VA MEDICAL CENTER SMOKING SHELTER CANOPY

Fargo, North Dakota

GENERAL
X1 COVER SHEET

ARCHITECTURAL
A1 CANOPY PLANS AND DETAILS

FIRE PROTECTION
FPI CANOPY FIRE PROTECTION PLAN

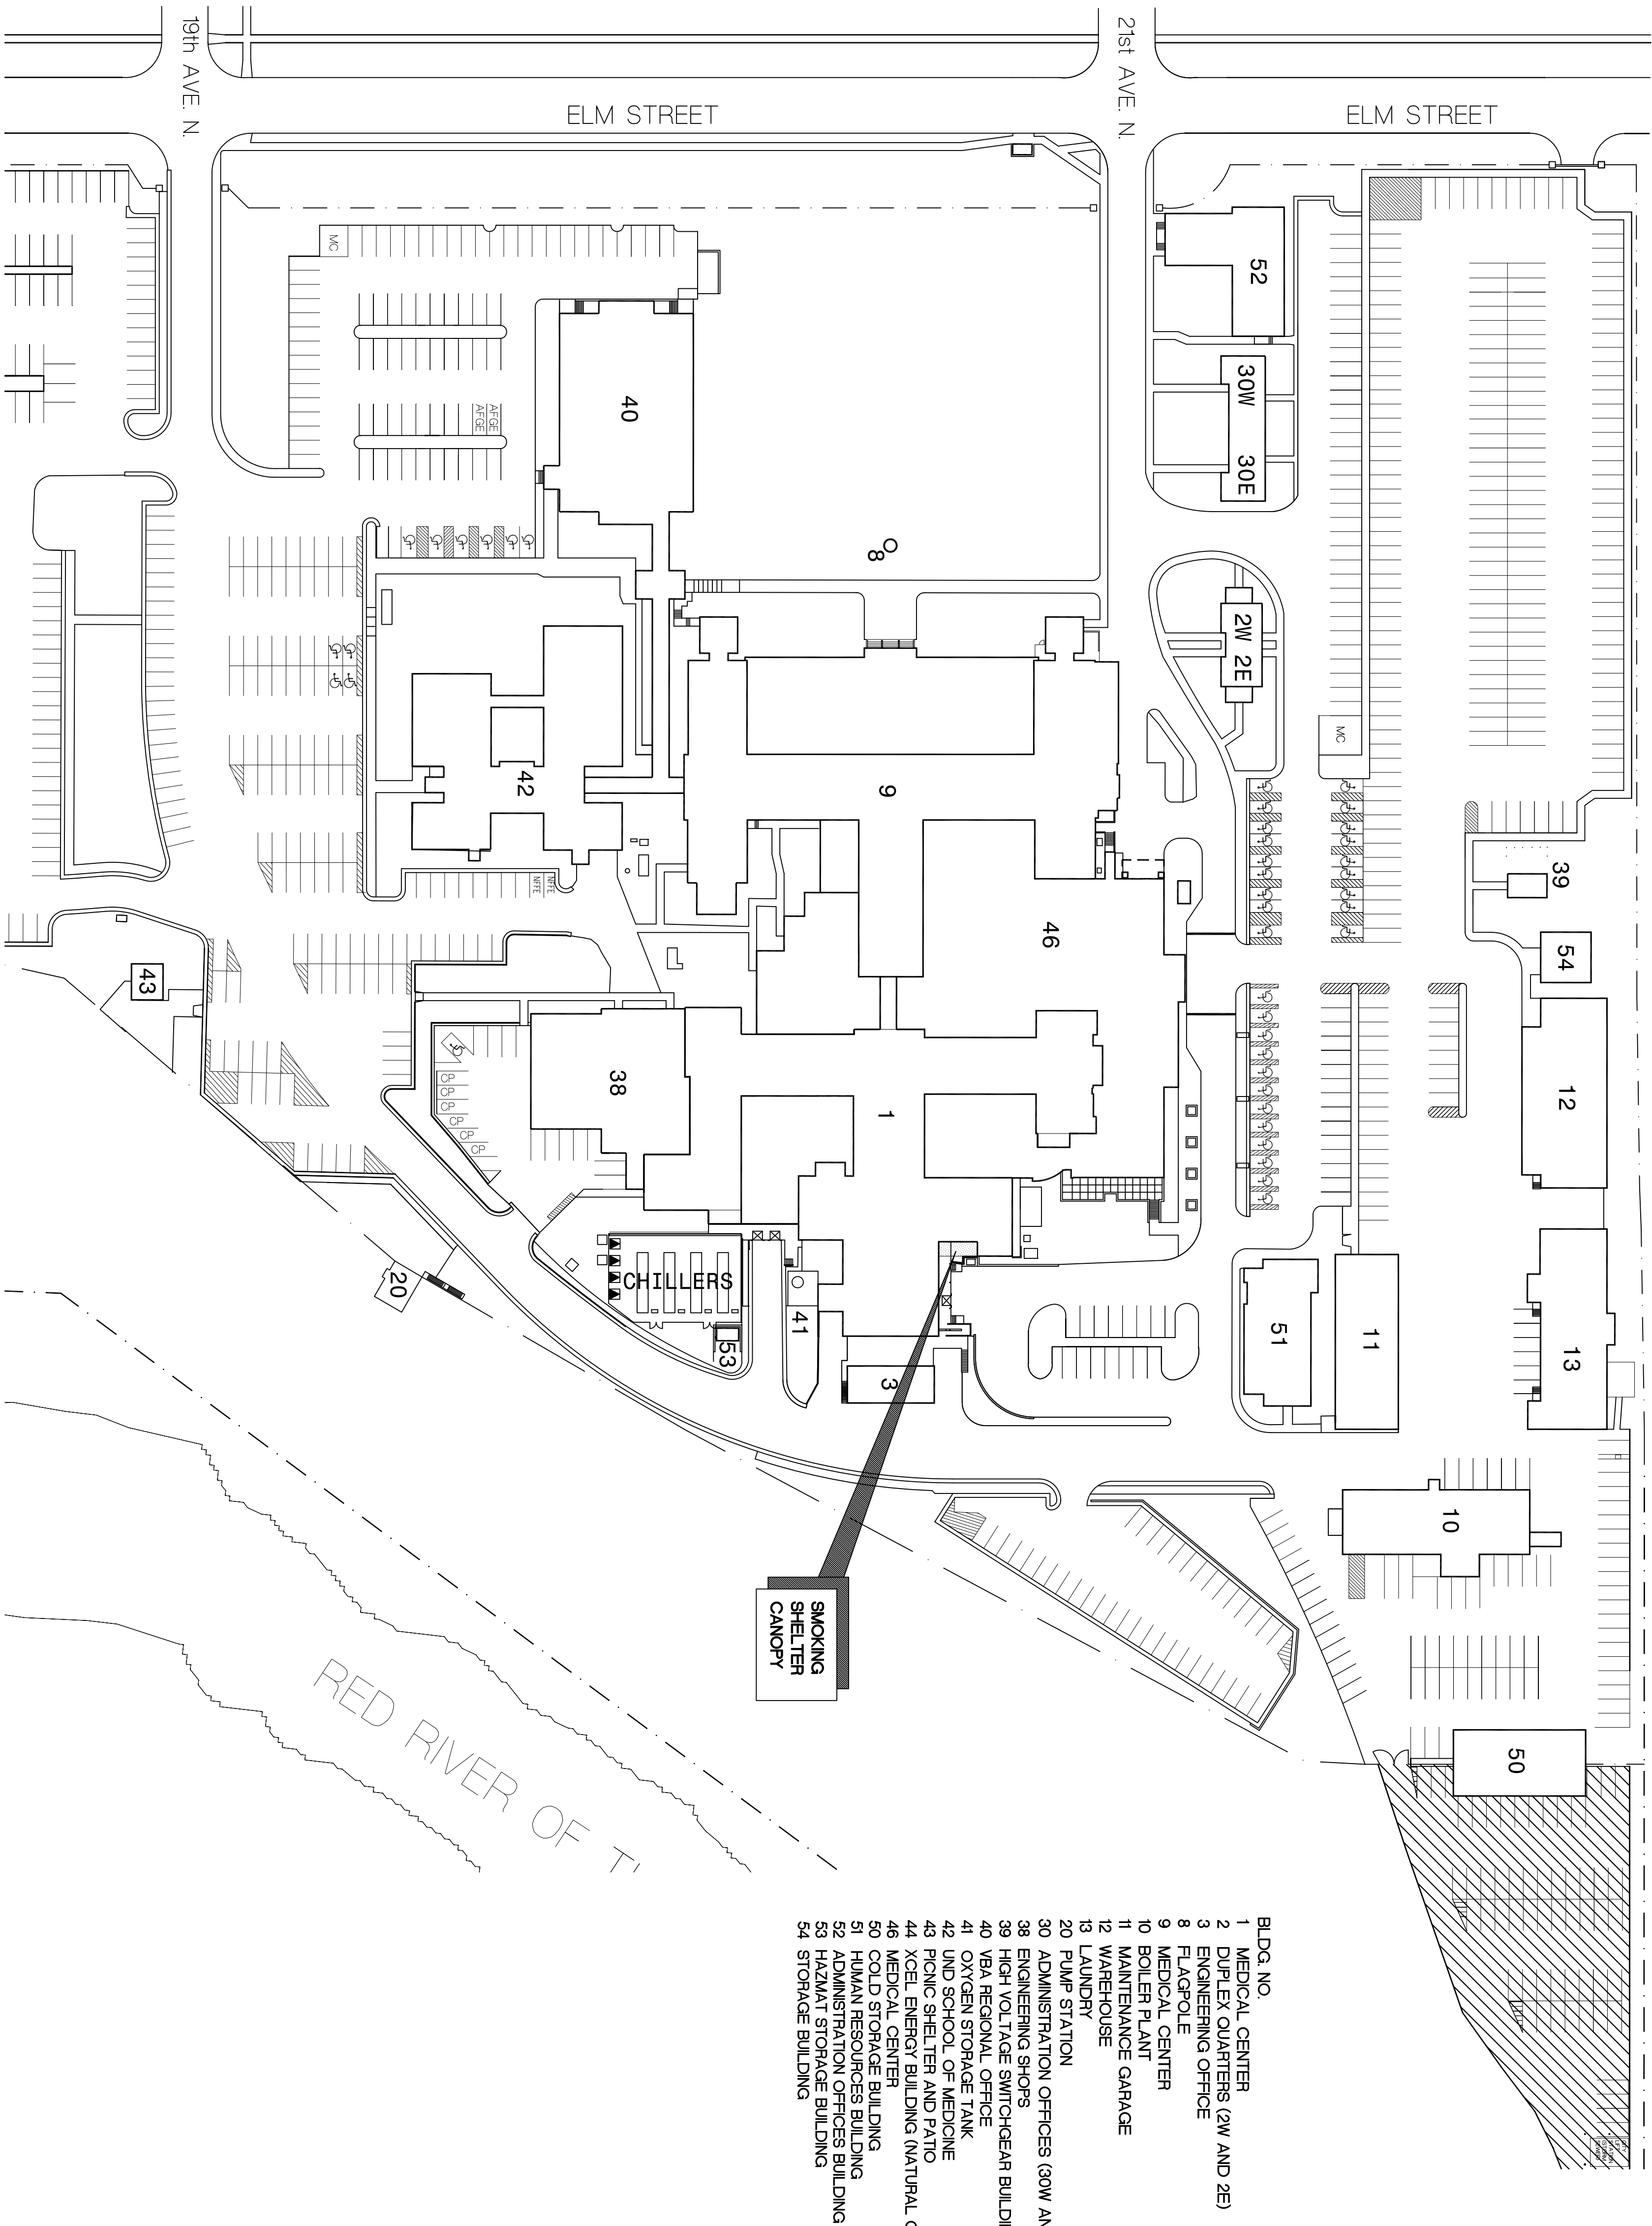




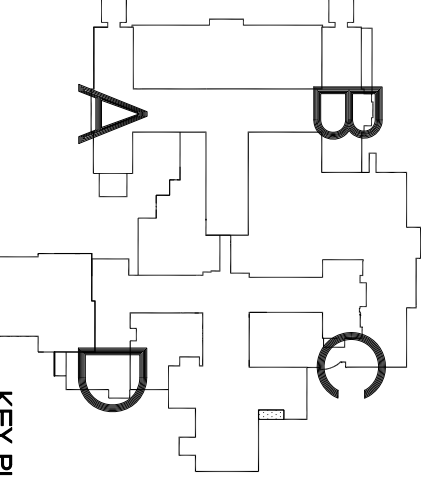

- BLDG. NO.
- 1 MEDICAL CENTER
 - 2 DUPLEX QUARTERS (2W AND 2E)
 - 3 ENGINEERING OFFICE
 - 4 LABORATORY
 - 5 MEDICAL CENTER
 - 10 BOILER PLANT
 - 11 MAINTENANCE GARAGE
 - 12 WAREHOUSE
 - 13 LAUNDRY
 - 20 PUMP STATION
 - 30 ADMINISTRATION OFFICES (30W AND 30E)
 - 38 ENGINEERING SHOPS
 - 39 HIGH VOLTAGE SWITCHGEAR BUILDING
 - 40 OXYGEN STORAGE TANK
 - 41 OXYGEN STORAGE TANK
 - 42 OXYGEN STORAGE TANK
 - 43 PUMP SHELTER AND PLANT
 - 44 XCEL ENERGY BUILDING (NATURAL GAS)
 - 46 MEDICAL CENTER
 - 50 COLD STORAGE BUILDING
 - 51 HUMAN RESOURCE BUILDING
 - 52 ADMINISTRATION OFFICES BUILDING
 - 53 HUMAN RESOURCE BUILDING
 - 54 STORAGE BUILDING


KEY TO SITE PLAN



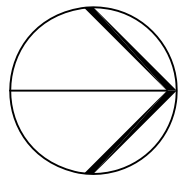


CONTRACTOR STAGING AREA, SHARED WITH VA AND OTHER CONTRACTORS.

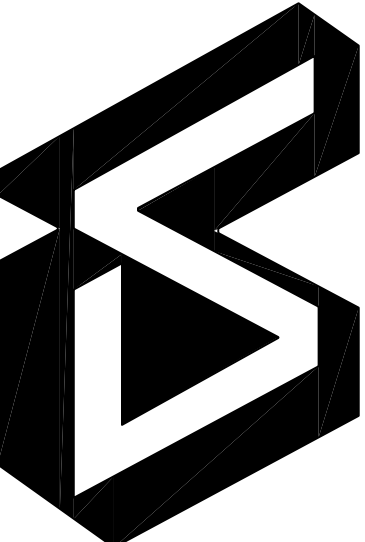SITE PLAN 1'-60'-0"

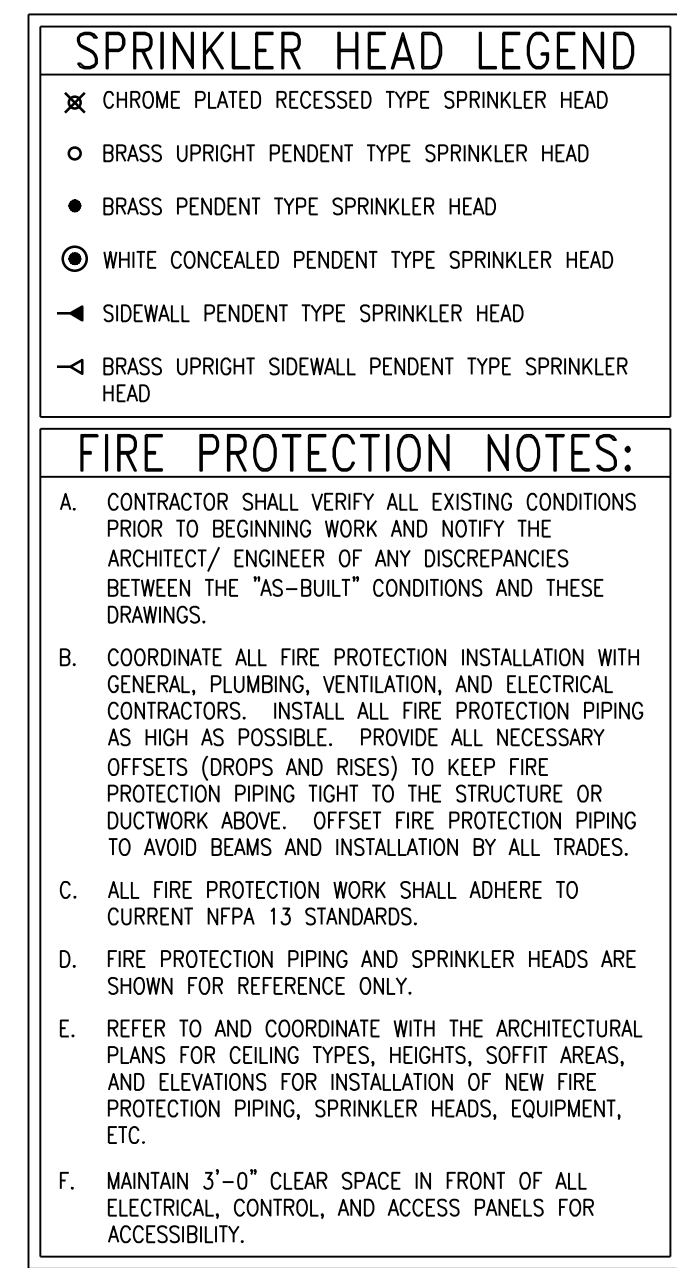

Revisions		Date	
<div><div>Dept. of Veterans Affairs Medical Center 2101 Elm Street North Fargo, ND 58102</div></div>			
<div><div>MAGE GROUP INC. 403 CENTER AVENUE, SUITE 300 MOOREHEAD, MN 56560</div></div>		<div>MAGE GROUP INC. Architecture & Interiors STEVEN & LARSON ENGINEERING, Structural Engineers OBERMAYER NELSON ENGINEERING, Mechanical Engineers</div>	
<p>I hereby certify that this plan specification, or report was prepared by me or under my direct supervision, and that I am duly Registered Architect under the laws of the State of North Dakota. <i>Steven Nelson</i></p> <p>Date 7/11/2012 Reg. No. 378</p>			
<div><div>KEY PLAN</div></div>		Drawing Title COVER SHEET	
VA Project No. Building No. 1		Contract No. VA263-P-1217 VA263-C-	
Designed By RM		Checked By RM	
Location VA MEDICAL CENTER FARGO, ND		Drawn By AH	
Scale 1'-60'-0"		Drawing No. X1	
Date JULY 11, 2012		Drawing No. X1	
<div> Department of Veterans Affairs</div>			



		 <div>Dept. of Veterans Affairs Medical Center 2101 Elm Street North Fargo, ND 58102</div>	 <div>IMAGE GROUP INC. 400 CENTER AVENUE, SUITE 300 MOORHEAD, MN 56560</div>	IMAGE GROUP INC., Architecture & Interiors SOLLEN & LARSON ENGINEERING, Structural Engineers OBERMILLER NELSON ENGINEERING, Mechanical Engineers	 <div>ONE BUILDING SYSTEMS CONSULTANTS Fargo, ND • Grand Forks, ND • Alexandria, MN 701.280.0500 • 701.775.2594 • 320.846.0300</div>		 <div>KEY PLAN</div>	Drawing Title CANOPY FIRE PROTECTION PLAN		Project Title VA MEDICAL CENTER SMOKING SHELTER ROOF		Date JULY 11, 2012	Department of Veterans Affairs				
										Scale AS SHOWN							
Revisions								Date									
								VA Project No.		Contract No. VA263-P-127 VA263-C-		Designed By JP	Checked By JP	Drawn By JF	Drawing No. FP1	Dwg. 2 of 3	
								Building No. 1		AutoCAD File Name		Location VA MEDICAL CENTER FARGO, ND					