
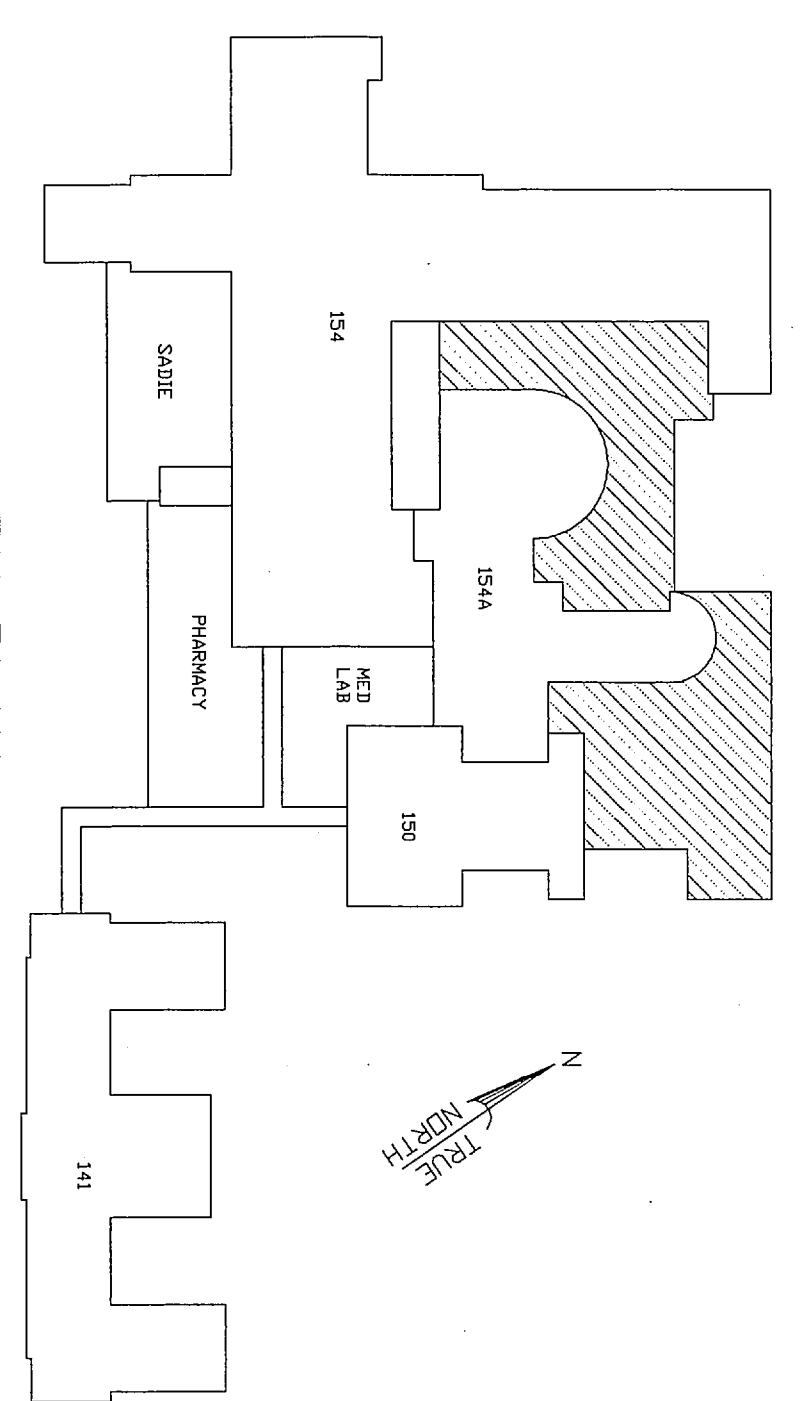


REVISION	DESCRIPTION	CHECKED BY:	DATE:
1	ADD ONE-LINE, CORRECT HEADEND ROOM NUMBER	KAS	12/6/2007

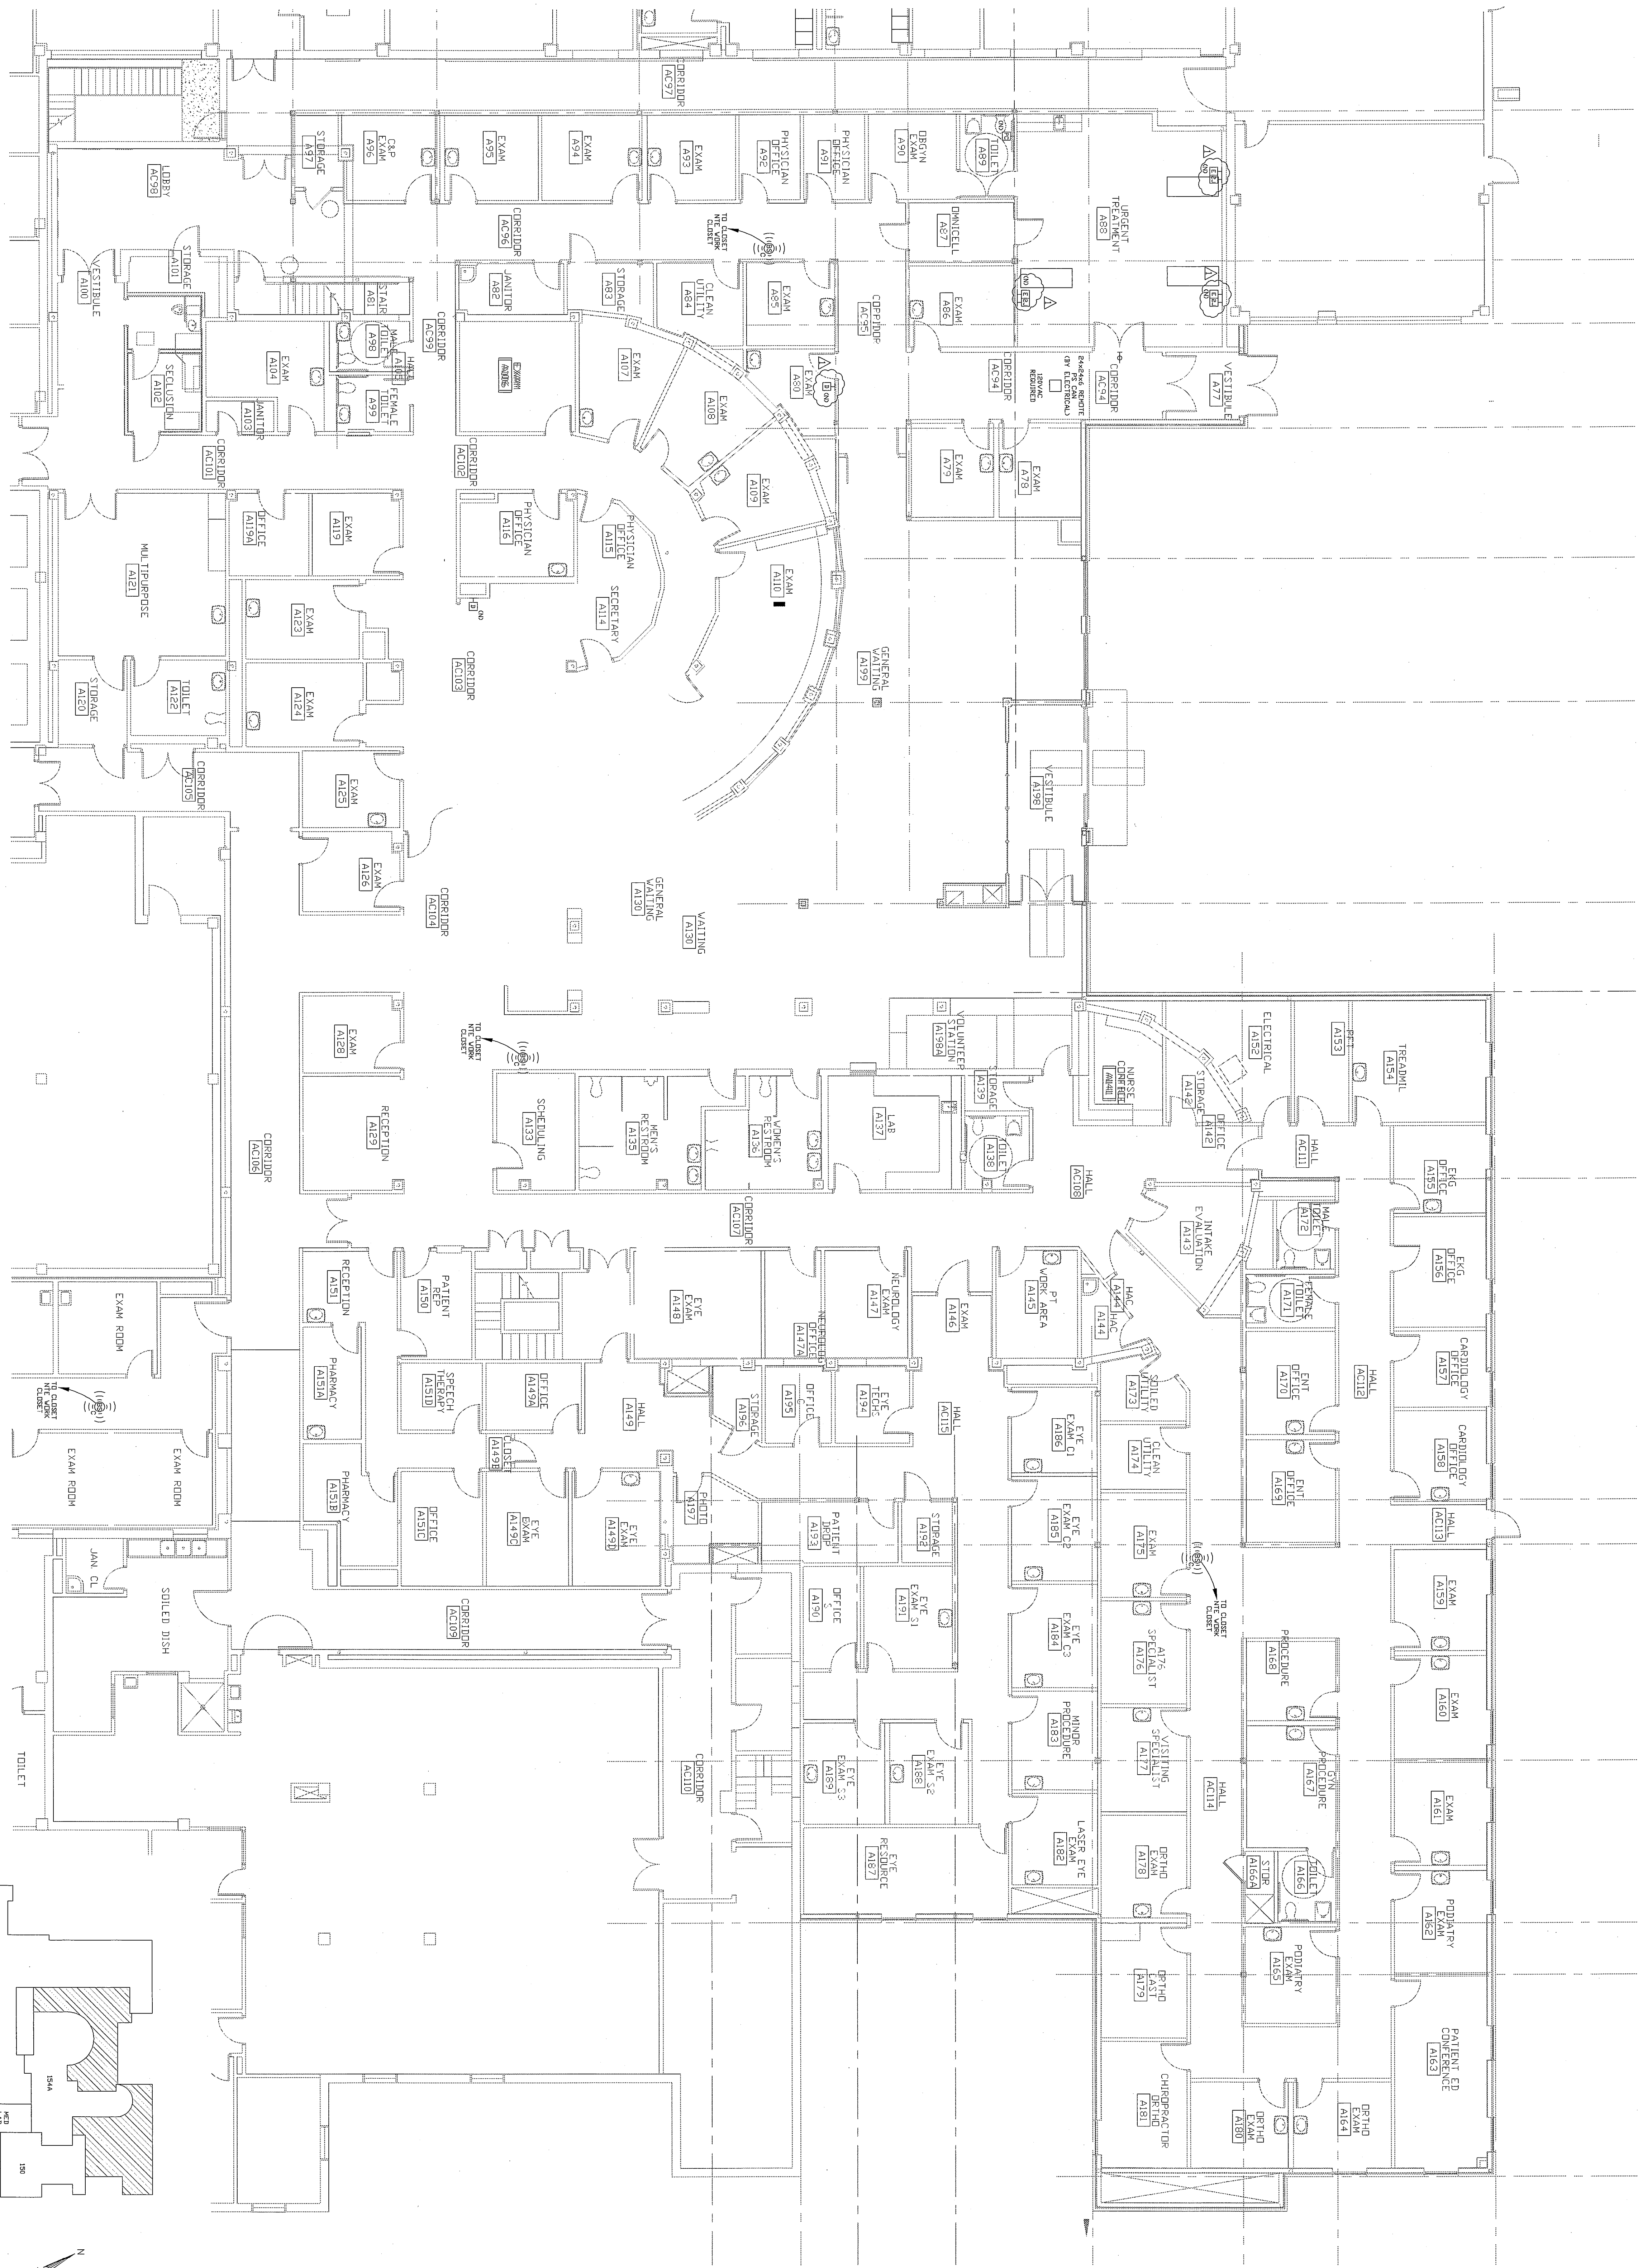

1 FLOOR PLAN
1/8" = 1'-0"

HELENA VA HOSPITAL
HELENA, MT

NURSE CALL SYSTEM
FLOOR PLAN
SHOP DRAWING

NC2-4
 EXCO SHEET NO.
 REFERENCE TO DRAWING SHEET

DATE: 10/02/2007
SCALE: 1/8" = 1'-0"
FILE NAME: 07-286-EST-1.AWG

CHECKED BY: KAS
DRAWN BY: KAS
JOB NUMBER: 07-286

DATE: 10/02/2007
SCALE: 1/8" = 1'-0"
FILE NAME: 07-286-EST-1.AWG