



REVISION	DESCRIPTION	CHECKED BY:	DATE:
1	ADD ONE-LINE, CORRECT HEADEND ROOM NUMBER	KJS	12/6/2007

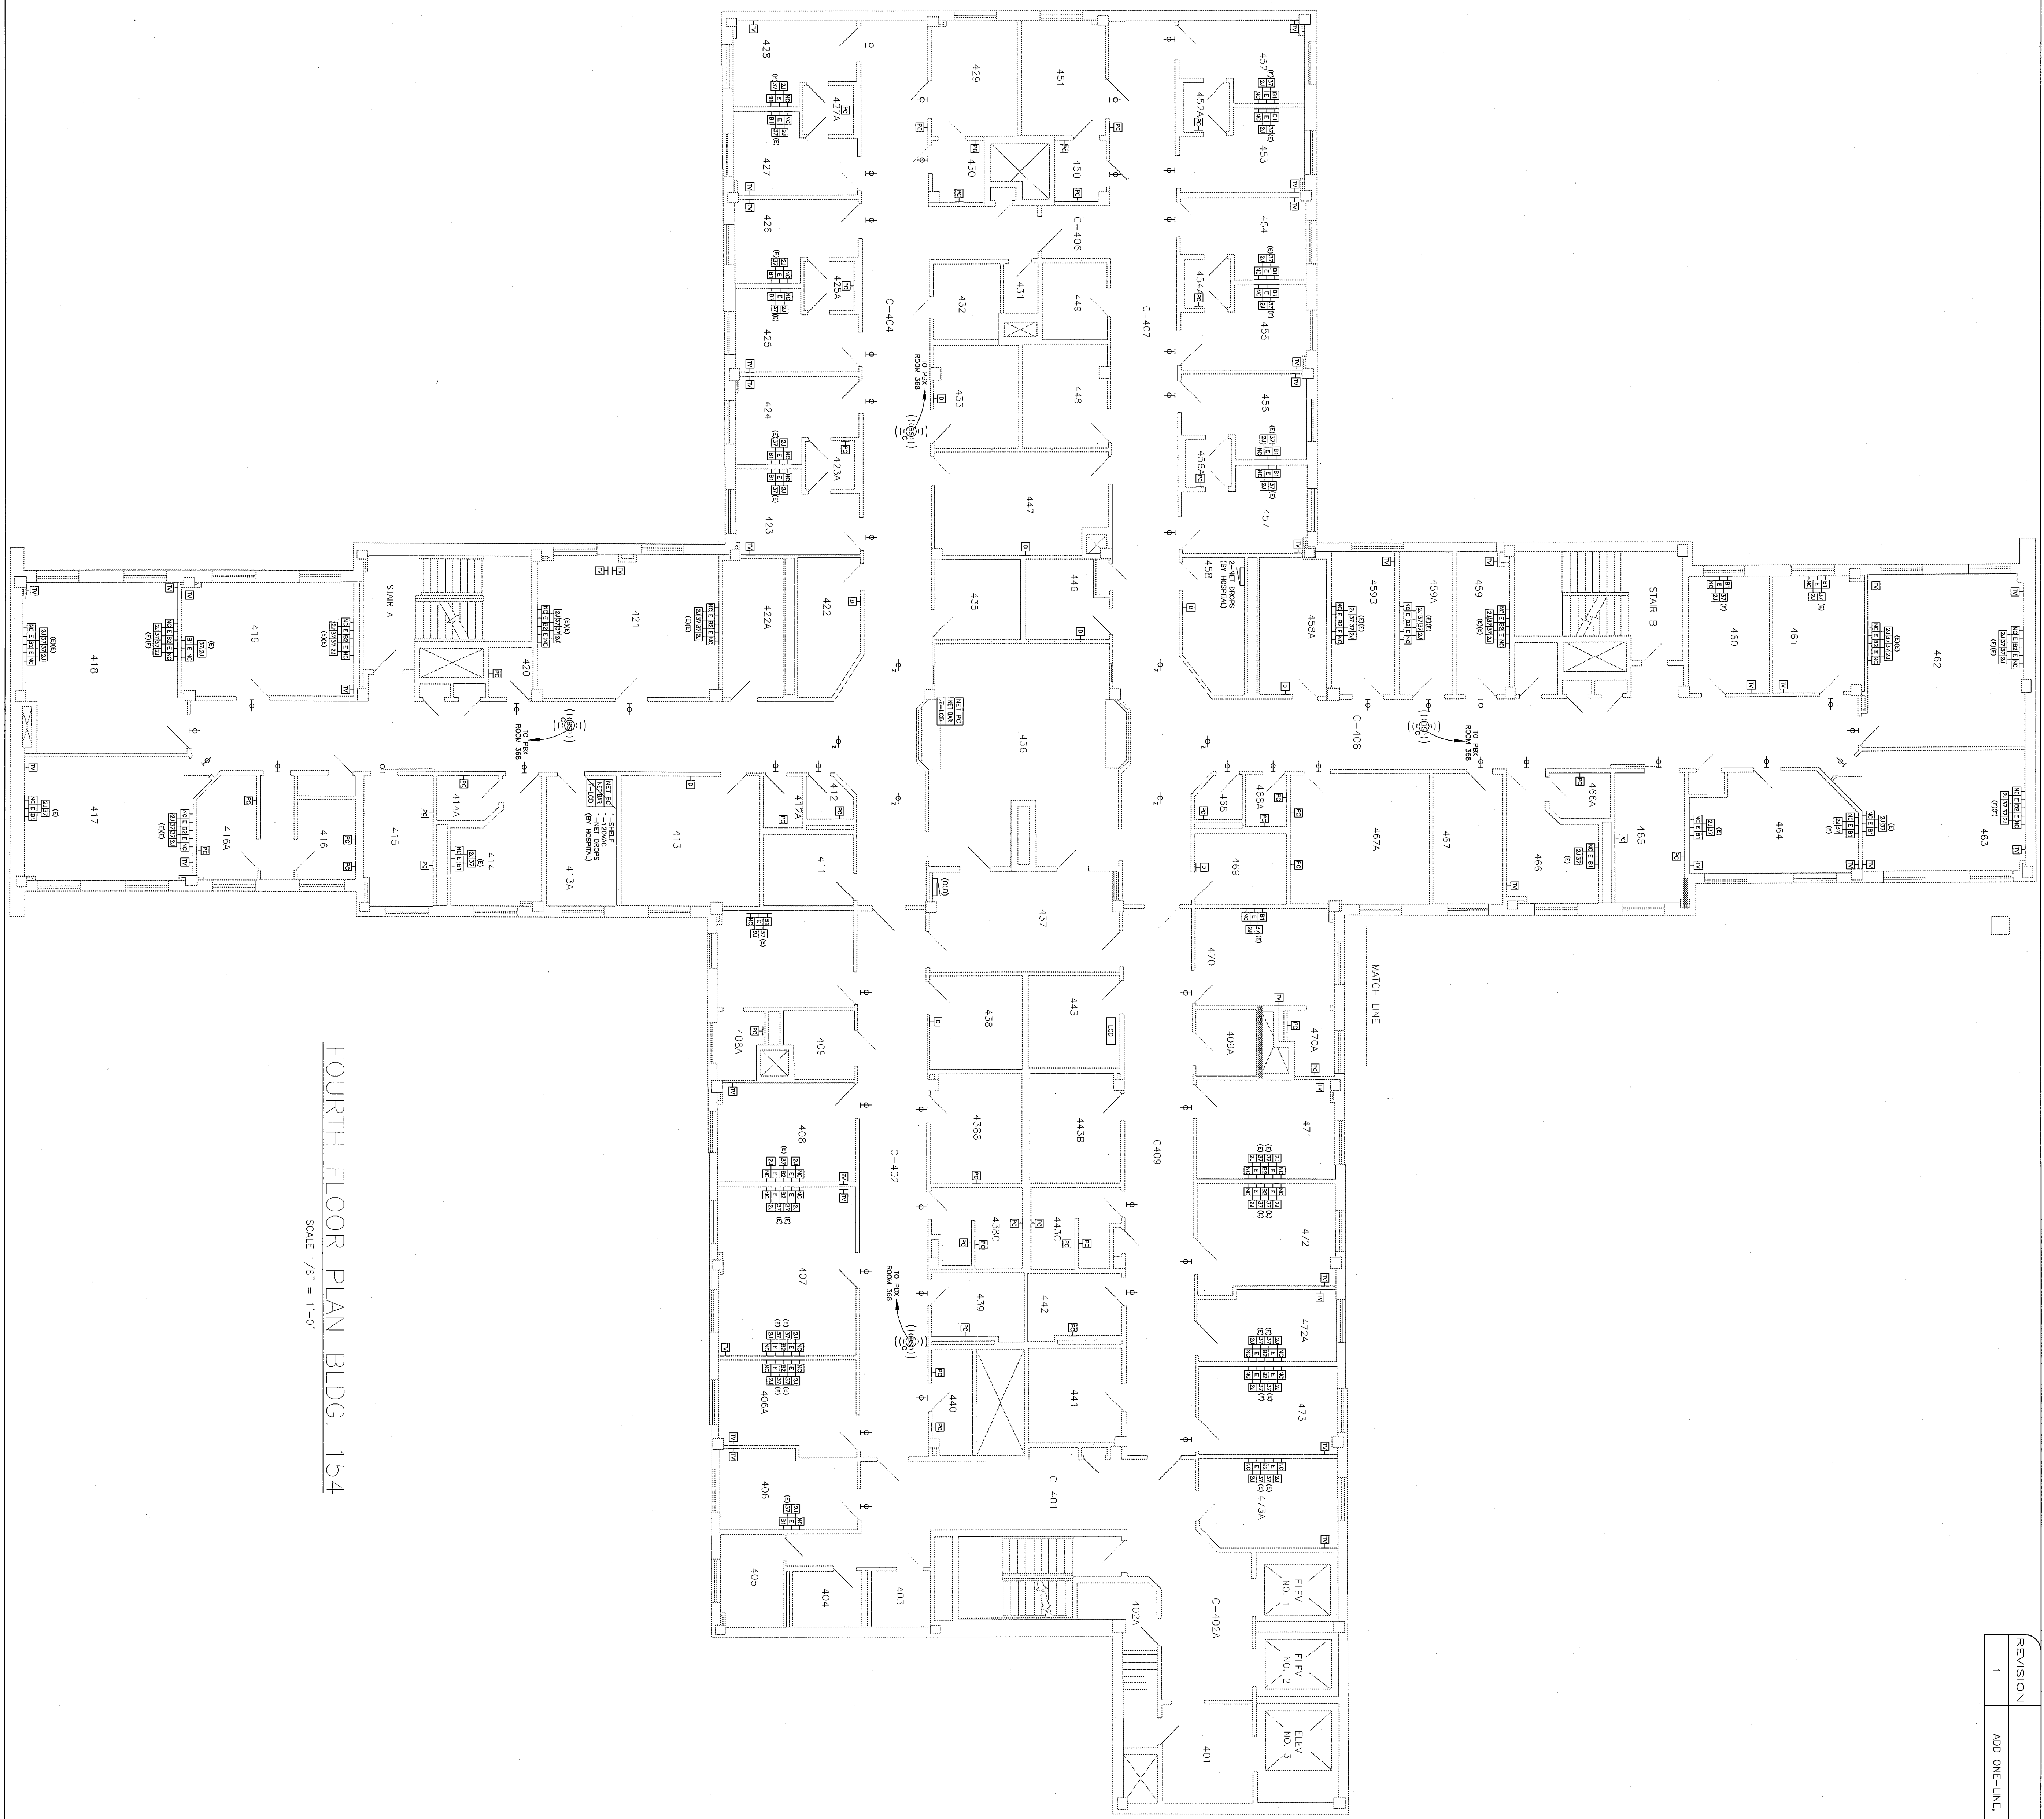

FOURTH FLOOR PLAN BLDG. 154

SCALE 1/8" = 1'-0"

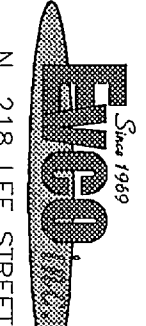

N. 218 LEE STREET
SPokane, WA 99202
PH: 534-2795
FAX: 534-2795

JOB NUMBER:
07-266

DRAWN BY:
KJS

CHECKED BY:
DTM

DATE:
10/02/2007

SCALE:
1/8" = 1'-0"

FILE NAME:
07-266-4th.dwg

NC4-4

EICO SHEET NO.

REFERENCE TO DOCUMENT SHEET

HELENA VA HOSPITAL

HELENA, MT

NURSE CALL SYSTEM
FLOOR PLAN
SHOP DRAWING