



1. ALL CONDUIT AND/OR STUB-OUTS SHALL BE A MINIMUM OF 3/4" UNLESS NOTED OTHERWISE ON VENDOR DRAWINGS.
2. ALL EQUIPMENT LOCATIONS SHALL BE CONFIRMED WITH ACTUAL FIELD CONDITIONS PRIOR TO START OF ANY WORK.
3. INSTALLATION OF ANY CABLE SHALL BE DONE IN A NEAT AND SYSTEMATIC MANNER. ALL CABLES SHALL BE SUPPORTED BASED ON CURRENT LOCAL CODES AND SHALL NOT DRAPE ACROSS ANY DEVICE OR OTHER CABLES.
4. ALL PENETRATIONS OF FIRE WALLS SHALL BE COORDINATED AND FOLLOW HOSPITAL STANDARDS.
5. ALL "END USER" TRAINING WILL BE DONE PER A SET SCHEDULE ARRANGED AND APPROVED BY THE HOSPITAL.
6. ANY ASBESTOS ABATEMENT OR AIR FILTRATION SYSTEMS REQUIRED FOR WORK IN EXISTING CEILING SPACE IS NOT INCLUDED IN OUR SCOPE OF WORK.
7. ABOVE ALL (RTTS) AND (ZONE LIGHTS) THERE IS A J-BOX WITH COMMON COLLECTOR TYPICAL OF ALL.

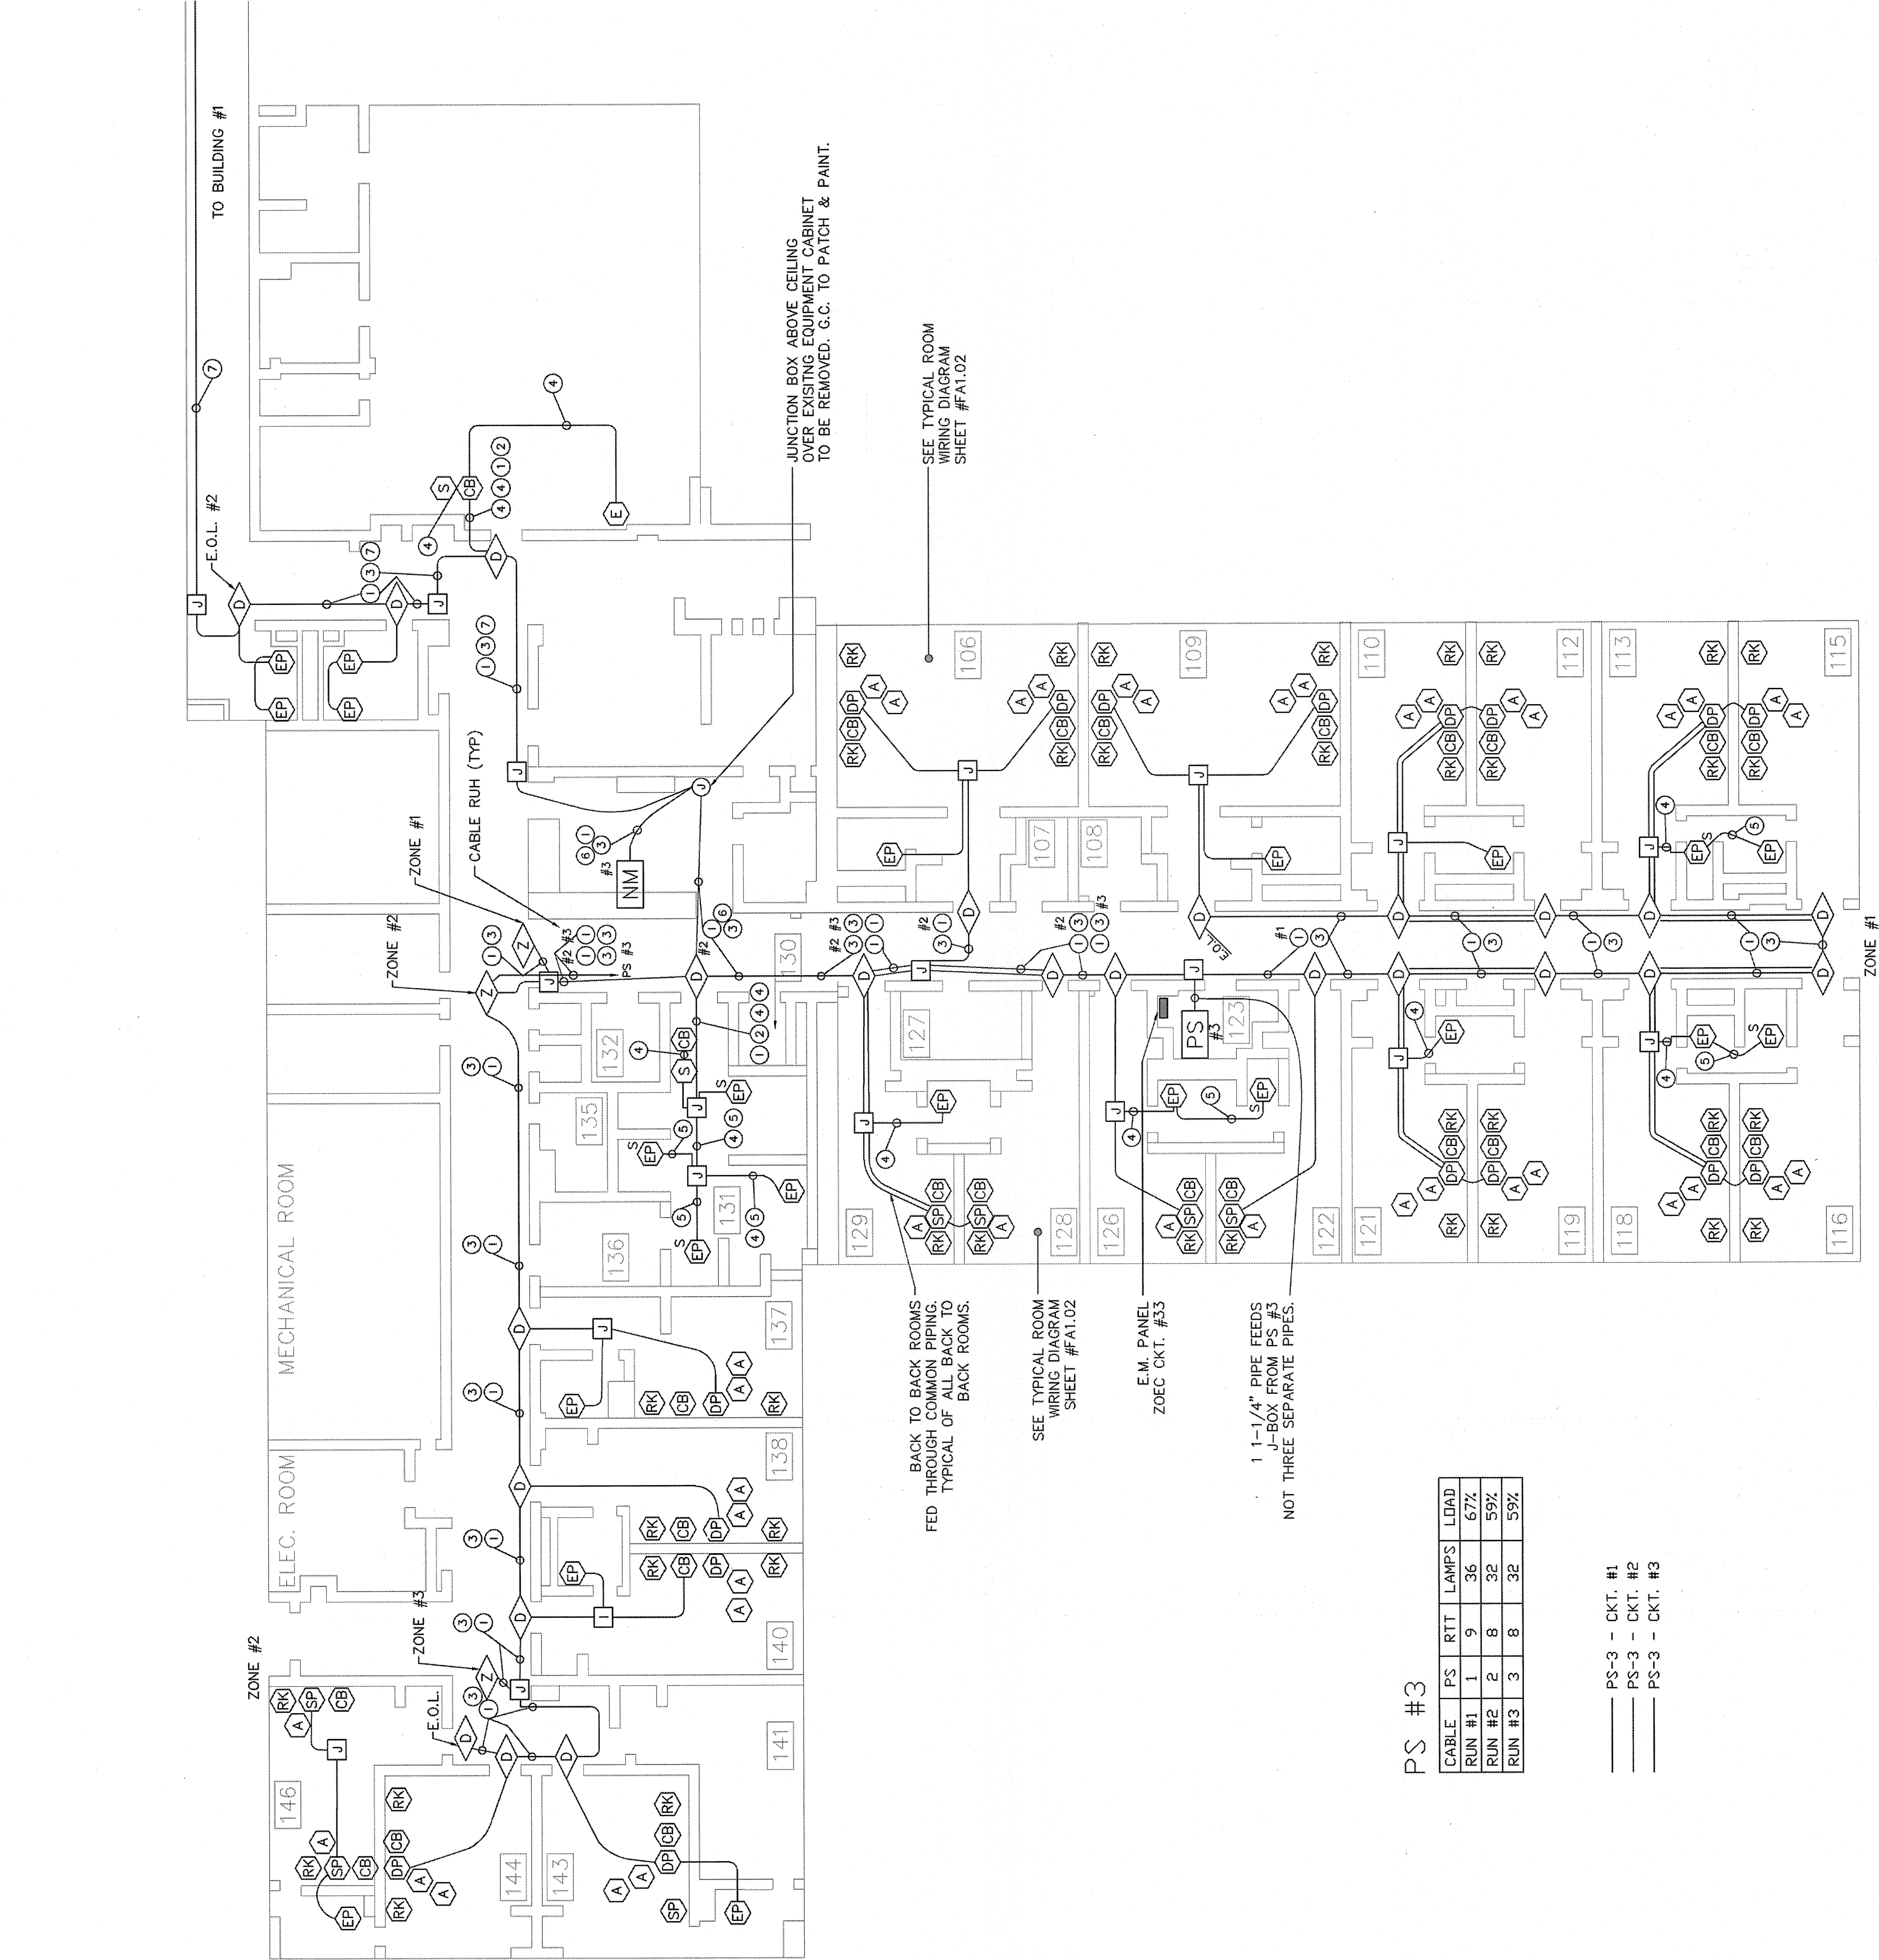

PS #3

CABLE	PS	RTT	LAMPS	LOAD
RUN #1	1	9	36	67%
RUN #2	2	8	32	59%
RUN #3	3	8	32	59%

- PS-3 - CKT. #1
PS-3 - CKT. #2
PS-3 - CKT. #3

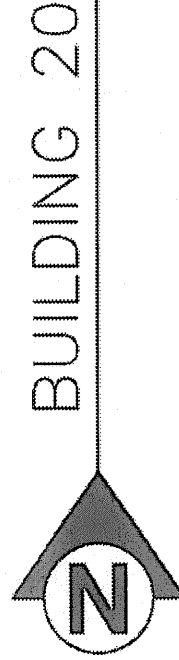

tyco Fire & Security
SimplexGrinnell

6240 SMITH ROAD
DENVER, COLORADO 80216

SALES: (303) 355-0500
SERVICE: (303) 355-0500
FAX: (303) 355-0515

©2001 SIMPLEXGRINNELL, LP
ALL RIGHTS RESERVED

NO.	DATE	REVISION DESCRIPTION
A	02/21/08	RECORD DRAWINGS (BDC)
B	01/26/09	RECORD DRAWINGS (MDP)
C	04/03/09	RENUMBER DRAWINGS AND ADD NCI.08 (MDP)
D	06/05/09	RECORD DRAWINGS (PH)
E	02/10/10	RECORD DRAWING PER FEBRUARY COMMENTS (GLS)

NURSE CALL SYSTEM FOR:
VAMC - GRAND JUNCTION, COLORADO

NURSE CALL REPLACEMENT AND UPGRADES

DATE	04/25/04
DRAWN BY:	KO
DESIGNED BY:	DATE
APPROVED BY:	DATE
PROJECT #	847597001
SCALE	NTS
SHEET TITLE	FIRST FLOOR PLAN
SHEET NUMBER	NC1.01