


REFERENCE NOTES

1. DENOTES DOME LIGHT W/ RTT. ACTUAL LOCATION OF DOME LIGHT WILL BE FIELD DETERMINED & APPROVED BY HOSPITAL.
2. ALL CABLING TO REUSE EXISTING RACEWAYS & SLEEVING WHEREVER POSSIBLE. THIS PLAN DENOTES CABLE ROUTING AND NOT RACEWAY REQUIRED.
3. DENOTES LOCATION OF REMOTE CODE BLUE STATION. ACTUAL SITE TO BE FIELD DETERMINED & APPROVED BY HOSPITAL.

PS #4					
Cable	PS	RTT	Std Lamps	LED Lamps	Load(%)
Run 1-1	1	3	4		10%
Run 1-2	2	9		36	25%
Run 2-1	3	9	32	4	45%
Run 2-2	4	8	32		42%

2ND FLOOR P.S.
SERVING 1ST & 2ND FLOOR.
*120V E.M. POWER
FROM PANEL CCL1
CKT. #22

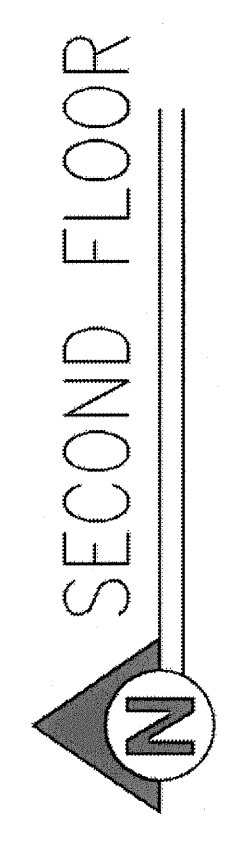

SECOND FLOOR

NO.	DATE	REVISION DESCRIPTION
A	02/21/08	RECORD DRAWINGS (BDC)
B	01/26/09	RECORD DRAWINGS (MCP)
C	04/03/09	RENUMBER DRAWINGS AND ADD NC1.08 (MDP)
D	06/05/09	RECORD DRAWINGS (PH)
E	02/10/10	RECORD DRAWING PER FEBRUARY COMMENTS (ALS)

tyco Fire & Security
8240 SMITH ROAD
DENVER, COLORADO 80216
SALES: (303) 355-0500
SERVICE: (303) 355-0500
FAX: (303) 355-0515

SimplexGrinnell
©2001 SIMPLEXGRINNELL, LP
ALL RIGHTS RESERVED

NURSE CALL SYSTEM FOR:
VAMC - GRAND JUNCTION, COLORADO
NURSE CALL REPLACEMENT AND UPGRADES
2121 NORTH AVE.
GRAND JUNCTION, COLORADO 81501
DRAWN BY: KO
DATE: 04/25/04
DESIGNED BY: DATE:
APPROVED BY: DATE:
PROJECT #: 847597001
SCALE: NTS
SHEET TITLE: CODE BLUE FLOOR PLAN
SHEET NUMBER: NC1.03.2