


BASEMENT COMMUNICATIONS PLAN
1/8" = 1'-0"

1
1-E8

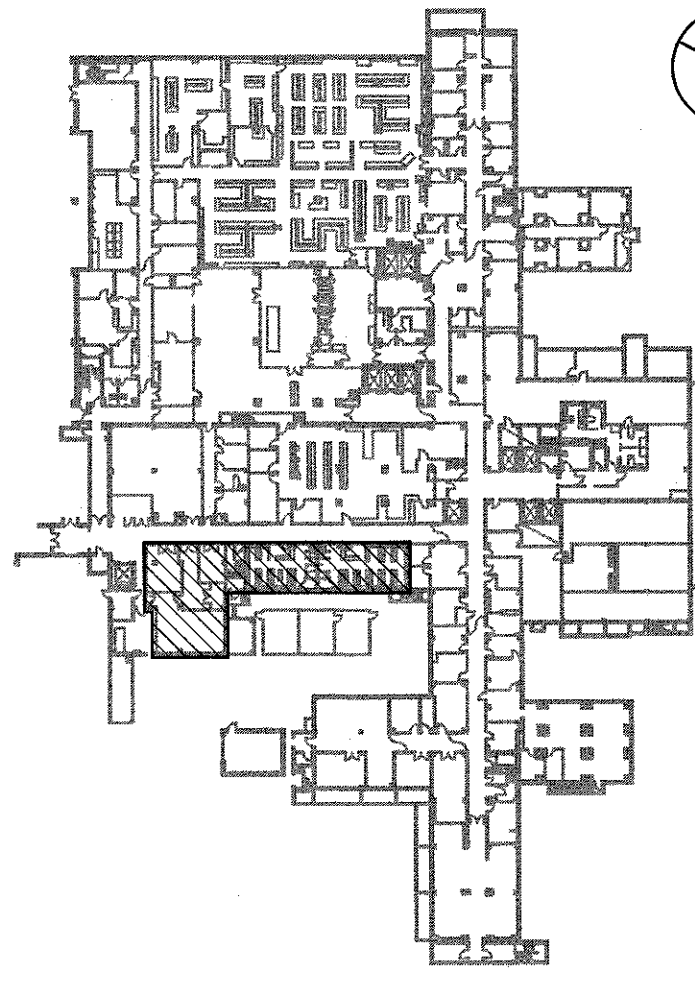

KEY PLAN
NOT TO SCALE
FULLY SPRINKLERED BUILDING
BID DOCUMENTS



- NOTES**
1. REFER TO SHEET 1-E1 FOR LEGEND, ABBREVIATIONS, AND GENERAL NOTES.
 2. ALL DATA OUTLETS ARE TO BE QUAD BOXES, WITH 4 CAT6 CABLES FOR DATA.

KEY NOTES

- ① LOCATION OF RELOCATED DOOR STRIKE AND KEYPAD, REUSE EXISTING CIRCUIT SERVING DOOR STRIKE AND KEYPAD.

CONSULTANTS:		ARCHITECT/ENGINEERS:		2014.2.01.2 STATE OF KENTUCKY JAMES CAMEL JAN GAUSEBKE 24788 LICENSED PROFESSIONAL ENGINEER No. 1000		COMMUNICATIONS PLAN BASEMENT Approved Project Director		Project Title SURGICAL SUPPORT AND LOCKERS		Project Number 636A8-11-011 Building Number 1 Drawing Number 1-E8		Office of Construction and Facilities Management Department of Veterans Affairs	
Date		Date		Date		Date		Date		Date		Date	

