



# LOUIS A. JOHNSON VA MEDICAL CENTER LAJ VA CLARKSBURG - MEDICAL GAS UPGRADE

1 Med Center Drive, Clarksburg,  
WV

100% CONSTRUCTION  
DOCUMENTS  
07/20/2012



## OWNER

DEPARTMENT OF VETERAN AFFAIR

1 MED CENTER DRIVE  
CLARKSBURG, WV 26301  
PHONE: 304.623.3461

## ARCHITECT


ARRAY Healthcare Facilities Solutions

2520 RENAISSANCE BLVD. SUITE 110  
KING OF PRUSSIA, PA 19406  
PHONE: 610.270.0599

## MEP ENGINEER

H.F. LENZ COMPANY

1407 SCALP AVE.  
JOHNSTOWN, PA 15904  
PHONE: 814.269.9300

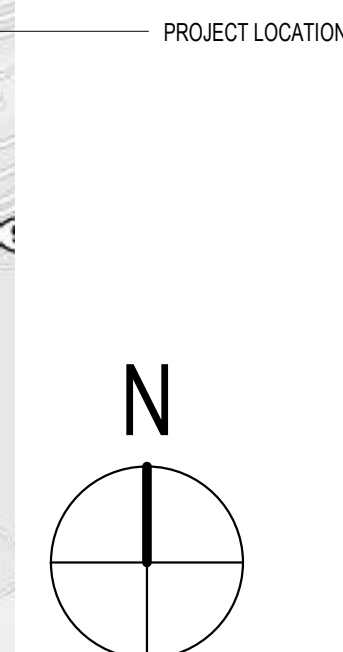

NUMB	DRAWING LIST SHEET NAME
GI001	COVER SHEET
GI002	DOCUMENTATION CONVENTIONS, NOTES AND DETAILS
GI101	ICRA PLANS - BUILDING 01
GI102	ICRA PLANS - BUILDING 01
GI103	ICRA PLANS - CLINICAL ADDITION
AS101A	BASEMENT ARCHITECTURAL & DEMOLITION PLAN
AS101B	BASEMENT ARCHITECTURAL AND DEMO PLAN
AS111A	FIRST FLOOR ARCHITECTURAL & DEMOLITION PLAN
AS111B	FIRST FLOOR ARCHITECTURAL & DEMOLITION PLAN
AS121A	SECOND FLOOR ARCHITECTURAL & DEMOLITION PLAN
AS121B	SECOND FLOOR ARCHITECTURAL & DEMOLITION PLAN
AS131A	THIRD FLOOR ARCHITECTURAL & DEMOLITION PLAN
AS131B	THIRD FLOOR ARCHITECTURAL & DEMOLITION PLAN
AS141A	FOURTH FLOOR ARCHITECTURAL & DEMOLITION PLAN
AS151A	FIFTH FLOOR ARCHITECTURAL & DEMOLITION PLAN
AS161A	SIXTH FLOOR ARCHITECTURAL & DEMOLITION PLAN
AS171A	SEVENTH FLOOR ARCHITECTURAL & DEMOLITION PLAN
AS181A	ROOF PLAN
PL001	SYMBOLS, ABBREVIATIONS, NOTES & DETAILS - MEDICAL GAS
PL101A	BASEMENT FLOOR DEMOLITION PLAN - MEDICAL GAS
PL101B	BASEMENT FLOOR DEMOLITION PLAN - CLINICAL ADDITION - MEDICAL GAS
PL102A	BASEMENT FLOOR PLAN - MEDICAL GAS
PL102B	BASEMENT FLOOR PLAN - CLINICAL ADDITION - MEDICAL GAS
PL111A	FIRST FLOOR DEMOLITION PLAN - MEDICAL GAS
PL111B	FIRST FLOOR DEMOLITION PLAN - CLINICAL ADDITION - MEDICAL GAS
PL112A	FIRST FLOOR PLAN - MEDICAL GAS
PL112B	FIRST FLOOR PLAN - CLINICAL ADDITION - MEDICAL GAS
PL121A	SECOND FLOOR DEMOLITION PLAN - MEDICAL GAS
PL121B	SECOND FLOOR DEMOLITION PLAN - CLINICAL ADDITION - MEDICAL GAS
PL122A	SECOND FLOOR PLAN - MEDICAL GAS
PL122B	SECOND FLOOR PLAN - CLINICAL ADDITION - MEDICAL GAS
PL131A	THIRD FLOOR DEMOLITION PLAN - MEDICAL GAS
PL131B	THIRD FLOOR DEMOLITION PLAN - CLINICAL ADDITION - MEDICAL GAS
PL132A	THIRD FLOOR PLAN - MEDICAL GAS
PL132B	THIRD FLOOR PLAN - CLINICAL ADDITION - MEDICAL GAS
PL141A	FOURTH FLOOR DEMOLITION PLAN - MEDICAL GAS
PL142A	FOURTH FLOOR PLAN - MEDICAL GAS
PL151A	FIFTH FLOOR DEMOLITION PLAN - MEDICAL GAS
PL152A	FIFTH FLOOR PLAN - MEDICAL GAS
PL161A	SIXTH FLOOR DEMOLITION PLAN - MEDICAL GAS
PL162A	SIXTH FLOOR PLAN - MEDICAL GAS
PL172A	SEVENTH FLOOR PLAN - CLINICAL ADDITION - MEDICAL GAS
PL182A	ROOF PLAN - MEDICAL GAS
PL200	MEDICAL GAS RISER DIAGRAM

## SYMBOL LEGEND

<b>ROOM INDICATION</b> ROOM NAME 101 ROOM NUMBER	<b>LINE TYPE SYMBOLS</b> 1 1 EXISTING COLUMN GRID IDENTIFIED WITH AN 'E' PREFIX COLUMN GRID
<b>NORTH ARROW</b> N NORTH	<b>LIMIT OF WORK</b> --- PROPERTY LINE --- CENTER LINE / ELEVATION LINE --- WORK ABOVE, BEYOND OR TO BE REMOVED --- BUMPER GUARD, CHAIR RAIL, HAND RAIL FOR LOCATION SEE PLANS --- BREAK LINE
<b>SITE PLAN NORTH ARROW</b> N NORTH	<b>MATCHLINE</b> AREA A X100 INDICATOR OF AREA SHOWN ON DRAWING SHEET NUMBER OF ADJACENT DRAWING
<b>DOOR SYMBOL</b> 101 DOOR	<b>KEYNOTE SYMBOL</b> 101 KEYNOTE INDICATOR
<b>WINDOW SYMBOL</b> 101 WINDOW TYPE OR VISION PANEL ON ELEVATION 101 IN PLAN	<b>EXISTING DOOR DESIGNATION</b> 101 EXISTING DOOR
<b>BUILDING WALL SECTION INDICATION</b> 101 SECTION NUMBER SHEET WHERE SHOWN	<b>NEW DOOR DESIGNATION</b> 101 NEW DOOR
<b>ELEVATION INDICATION</b> 101 INTERIOR AND/OR EXTERIOR 101 MULTIPLE INTERIOR	<b>EMERGENCY DOOR DESIGNATION</b> 101 NEW DOOR EMERGENCY SWING
<b>FIRE EXTINGUISHER CABINET</b> F.E.C.	<b>DOUBLE EGRESS DOOR DESIGNATION</b> 101 NEW DOOR
<b>DETAIL INDICATION</b> 101 AREA DETAILED SM DETAIL NUMBER SHEET WHERE SHOWN	<b>STARTING POINT</b> + STARTING POINT
<b>REVISION INDICATION</b> 101 REVISION NUMBER	<b>ELEVATION TAG</b> Name Elevation
<b>ALIGN WITH EXISTING CONSTRUCTION</b> 101 ALIGN	<b>GENERAL DIMENSIONING</b> 101 DIMENSION NOTE: DIMENSIONS ARE TAKEN FROM TO FINISH SURFACE, UNLESS OTHERWISE NOTED. NOTE: THE ± INDICATES A DIMENSION THAT CAN VARY. NOTIFY THE ARCHITECT OF ANY CHANGE IN THAT DIMENSION IF IT IS GREATER THAN 1". NOTE: EXISTING DIMENSIONS INDICATED AS 10' 01" OR WITH (W) ARE SUPPLIED TO THE ARCHITECT BY OTHERS AND SHALL BE FIELD VERIFIED BY THE CONTRACTOR. (SEE "GENERAL CONTRACTOR RESPONSIBILITIES WITH RESPECT TO EXISTING CONDITIONS" NOTES)
<b>PARTITION TYPE SYMBOL</b> 101 PARTITION TYPE	
<b>EQUIPMENT DESIGNATION</b> (SEE EQUIPMENT MANUAL) 101 EQUIPMENT TYPE	
<b>CEILING HEIGHT</b> 101 CEILING HEIGHT	
<b>FINISH SYMBOLS</b> ROOM FINISH TAG 101 FINISH CEILING WALL FLOOR BASE	
<b>101</b> DENOTES CORNER GUARD LOCATION	

100% CONSTRUCTION DOCUMENTS

CONSULTANTS: <b>H.F. LENZ COMPANY</b> 1407 Scalp Avenue Johnstown, PA 15904 Phone: 814-269-9300 FAX: 814-269-9301 cadd@hflen.com www.hflen.com		ARCHITECT: <b>ARRAY</b> healthcare facilities solutions 2520 Renaissance Boulevard, Suite 110 King of Prussia, PA 19406 T: 610.270.0599 F: 610.270.0595 www.arrayhfs.com		Project Number 3439.02	Scale As indicated	Drawing Title COVER SHEET	Project Title LAJ VA CLARKSBURG - MEDICAL GAS UPGRADE	VA Project Number VA244-P-1491 Building Number 01/02 Drawing Number GI001 Dwg. 1 of 44	Office of Facilities Management Department of Veterans Affairs		
Revisions		Date		Approved: Project Director		Location 1 Med Center Drive, Clarksburg, WV		Date 07/20/2012		Checked EBC	Drawn EN