


NOTES ELSEWHERE

- 1) EXISTING MEDICAL GAS OUTLETS TO REMAIN.

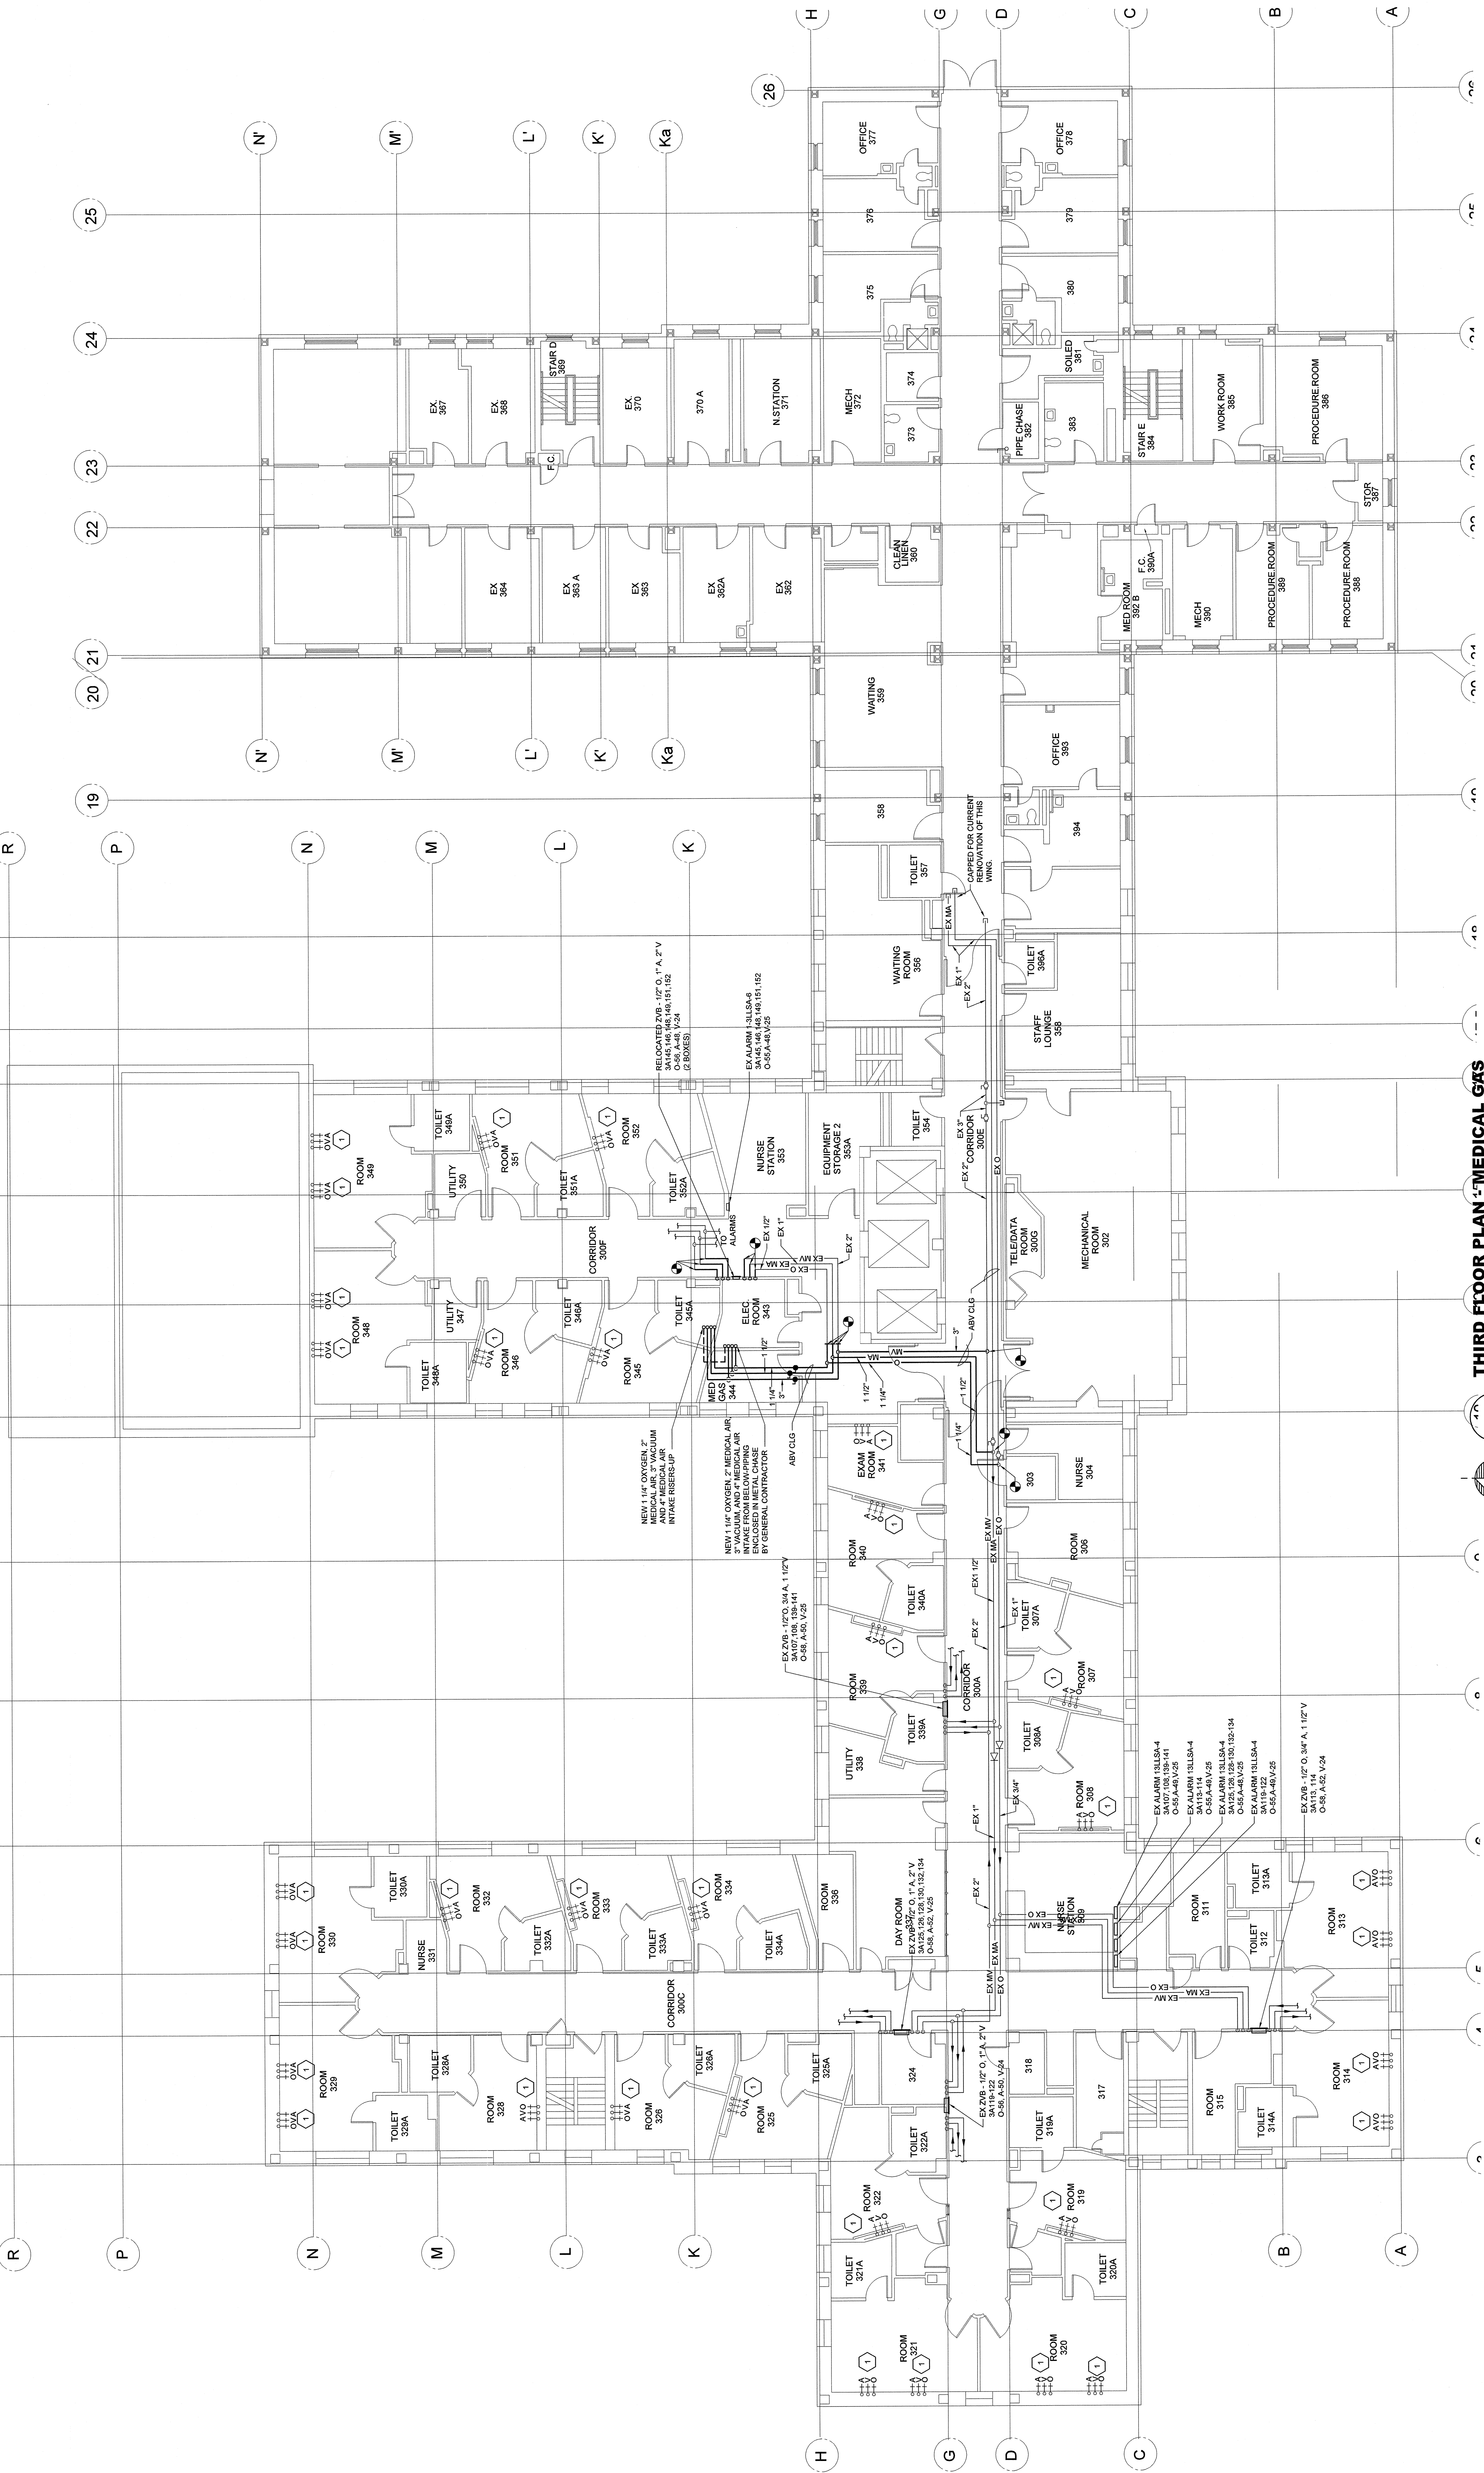

THIRD FLOOR PLAN - MEDICAL GAS

Scale: 1/8" = 1'-0"



A1

CONSULTANTS:

H.F. LENZ COMPANY
Engineers
Planners
Architects
Interior Designers
1401 10th Avenue, Suite 100
Boulder, CO 80501
303.440.1234
www.hflenz.com

ARCHITECT:

A R R A Y
healthcare facilities solutions
2520 Renaissance Boulevard, Suite 110
King of Prussia, PA 19406
1-800-371-5559
1-610-271-0095
www.arraypl.com

Drawing Title

THIRD FLOOR PLAN - BUILDING
1 - MEDICAL GAS

Approved Project Director

Checked
JLJ

Drawn
JLJ

Date
7/20/2012

 
Location
VAMC, CLARKSBURG

Drawing Number
01

Building Number
VA244-P-1491

Project Number
VA Project Number

Office of
Facilities
Management



100% CONSTRUCTION DOCUMENTS