


NOTES ELSEWHERE

1. EXISTING CEILING COLUMN TO REMAIN
2. EXISTING CEILING COLUMN TO REMAIN
3. EXISTING CEILING COLUMN TO REMAIN
4. EXISTING CEILING COLUMN TO REMAIN
5. EXISTING CEILING COLUMN TO REMAIN
6. EXISTING CEILING COLUMN TO REMAIN
7. EXISTING CEILING COLUMN TO REMAIN
8. EXISTING CEILING COLUMN TO REMAIN
9. EXISTING CEILING COLUMN TO REMAIN
10. EXISTING CEILING COLUMN TO REMAIN
11. EXISTING CEILING COLUMN TO REMAIN
12. EXISTING CEILING COLUMN TO REMAIN
13. EXISTING CEILING COLUMN TO REMAIN
14. EXISTING CEILING COLUMN TO REMAIN
15. EXISTING CEILING COLUMN TO REMAIN
16. EXISTING CEILING COLUMN TO REMAIN
17. EXISTING CEILING COLUMN TO REMAIN
18. EXISTING CEILING COLUMN TO REMAIN
19. EXISTING CEILING COLUMN TO REMAIN
20. EXISTING CEILING COLUMN TO REMAIN
21. EXISTING CEILING COLUMN TO REMAIN
22. EXISTING CEILING COLUMN TO REMAIN

THIRD FLOOR PLAN - CLINICAL ADDITION - MEDICAL GAS

Scale: 1/8" = 1'-0"

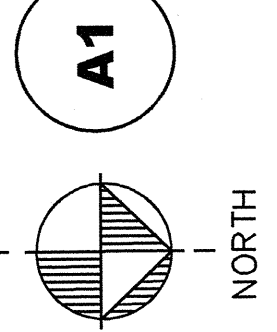

CONSULTANTS:



ARCHITECT:



Drawing Title

THIRD FLOOR PLAN-CLINICAL
ADDITION - MEDICAL GAS

Project Title

MEDICAL GAS SYSTEM
REPLACEMENT PROJECT

Project Number

VA Project Number
VA244-P-1491

Building Number

02

Drawing Number

PL132B

Location

VAMC, CLARKSBURG

Checked

JLJ

Date

7/20/2012

Approved

Project Director


Scale

1/8" = 1'-0"


Project Number

2520 Renaissance Boulevard, Suite 110
King of Prussia, PA 19406
T: 610.370.6099
F: 610.370.6095
www.arrayllc.com

ARCHITECT:

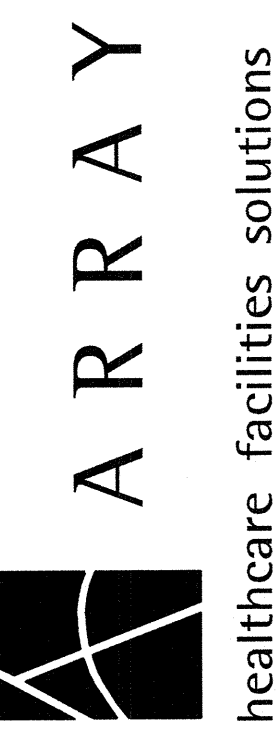

ARCHITECT:

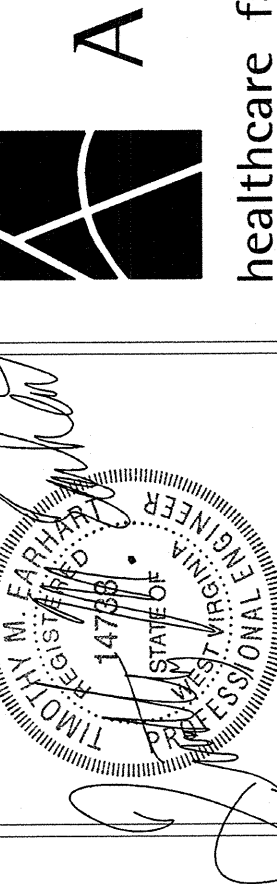

CONSULTANTS:

