


NOTES ELSEWHERE
1 DISCONNECT AND REMOVE EXISTING MEDICAL GAS PIPING AND REMOVE ALL ZONE VALVE BOXES AND AREA ALARMS IN THEIR ENTIRETY.


SIXTH FLOOR PLAN - DEMOLITION - MEDICAL GAS
Scale: 1/8" = 1'-0"

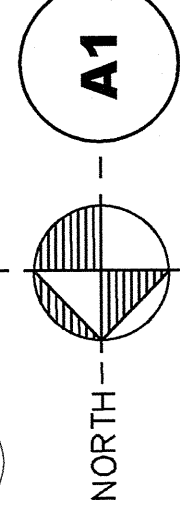

CONSULTANTS:



ARCHITECT:

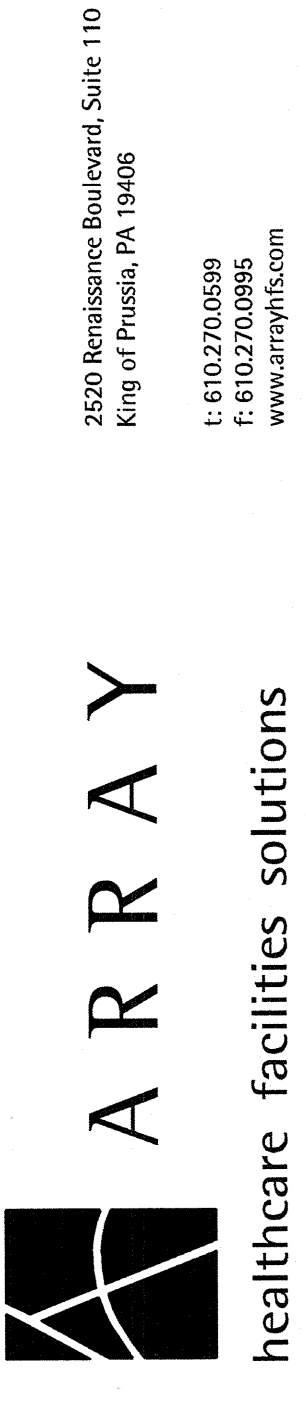

Drawing Title
SIXTH FLOOR DEMOLITION PLAN -
BUILDING 1 - MEDICAL GAS

Approved Project Director

Location
VAMC, CLARKSBURG

Checked
TIME

Drawn
JLJ

Building Number
01

Drawing Number
PL161A

 
Date
7/20/2012

Dwg. of
44

Project Title
MEDICAL GAS SYSTEM
REPLACEMENT PROJECT

VA Project Number
VA244-P-1491

Office of
Facilities
Management



100% CONSTRUCTION DOCUMENTS