



1 SWING SPACE RENOVATION POWER, VOICE/DATA & SIGNAL PLAN - QUAD A - PHASE 1

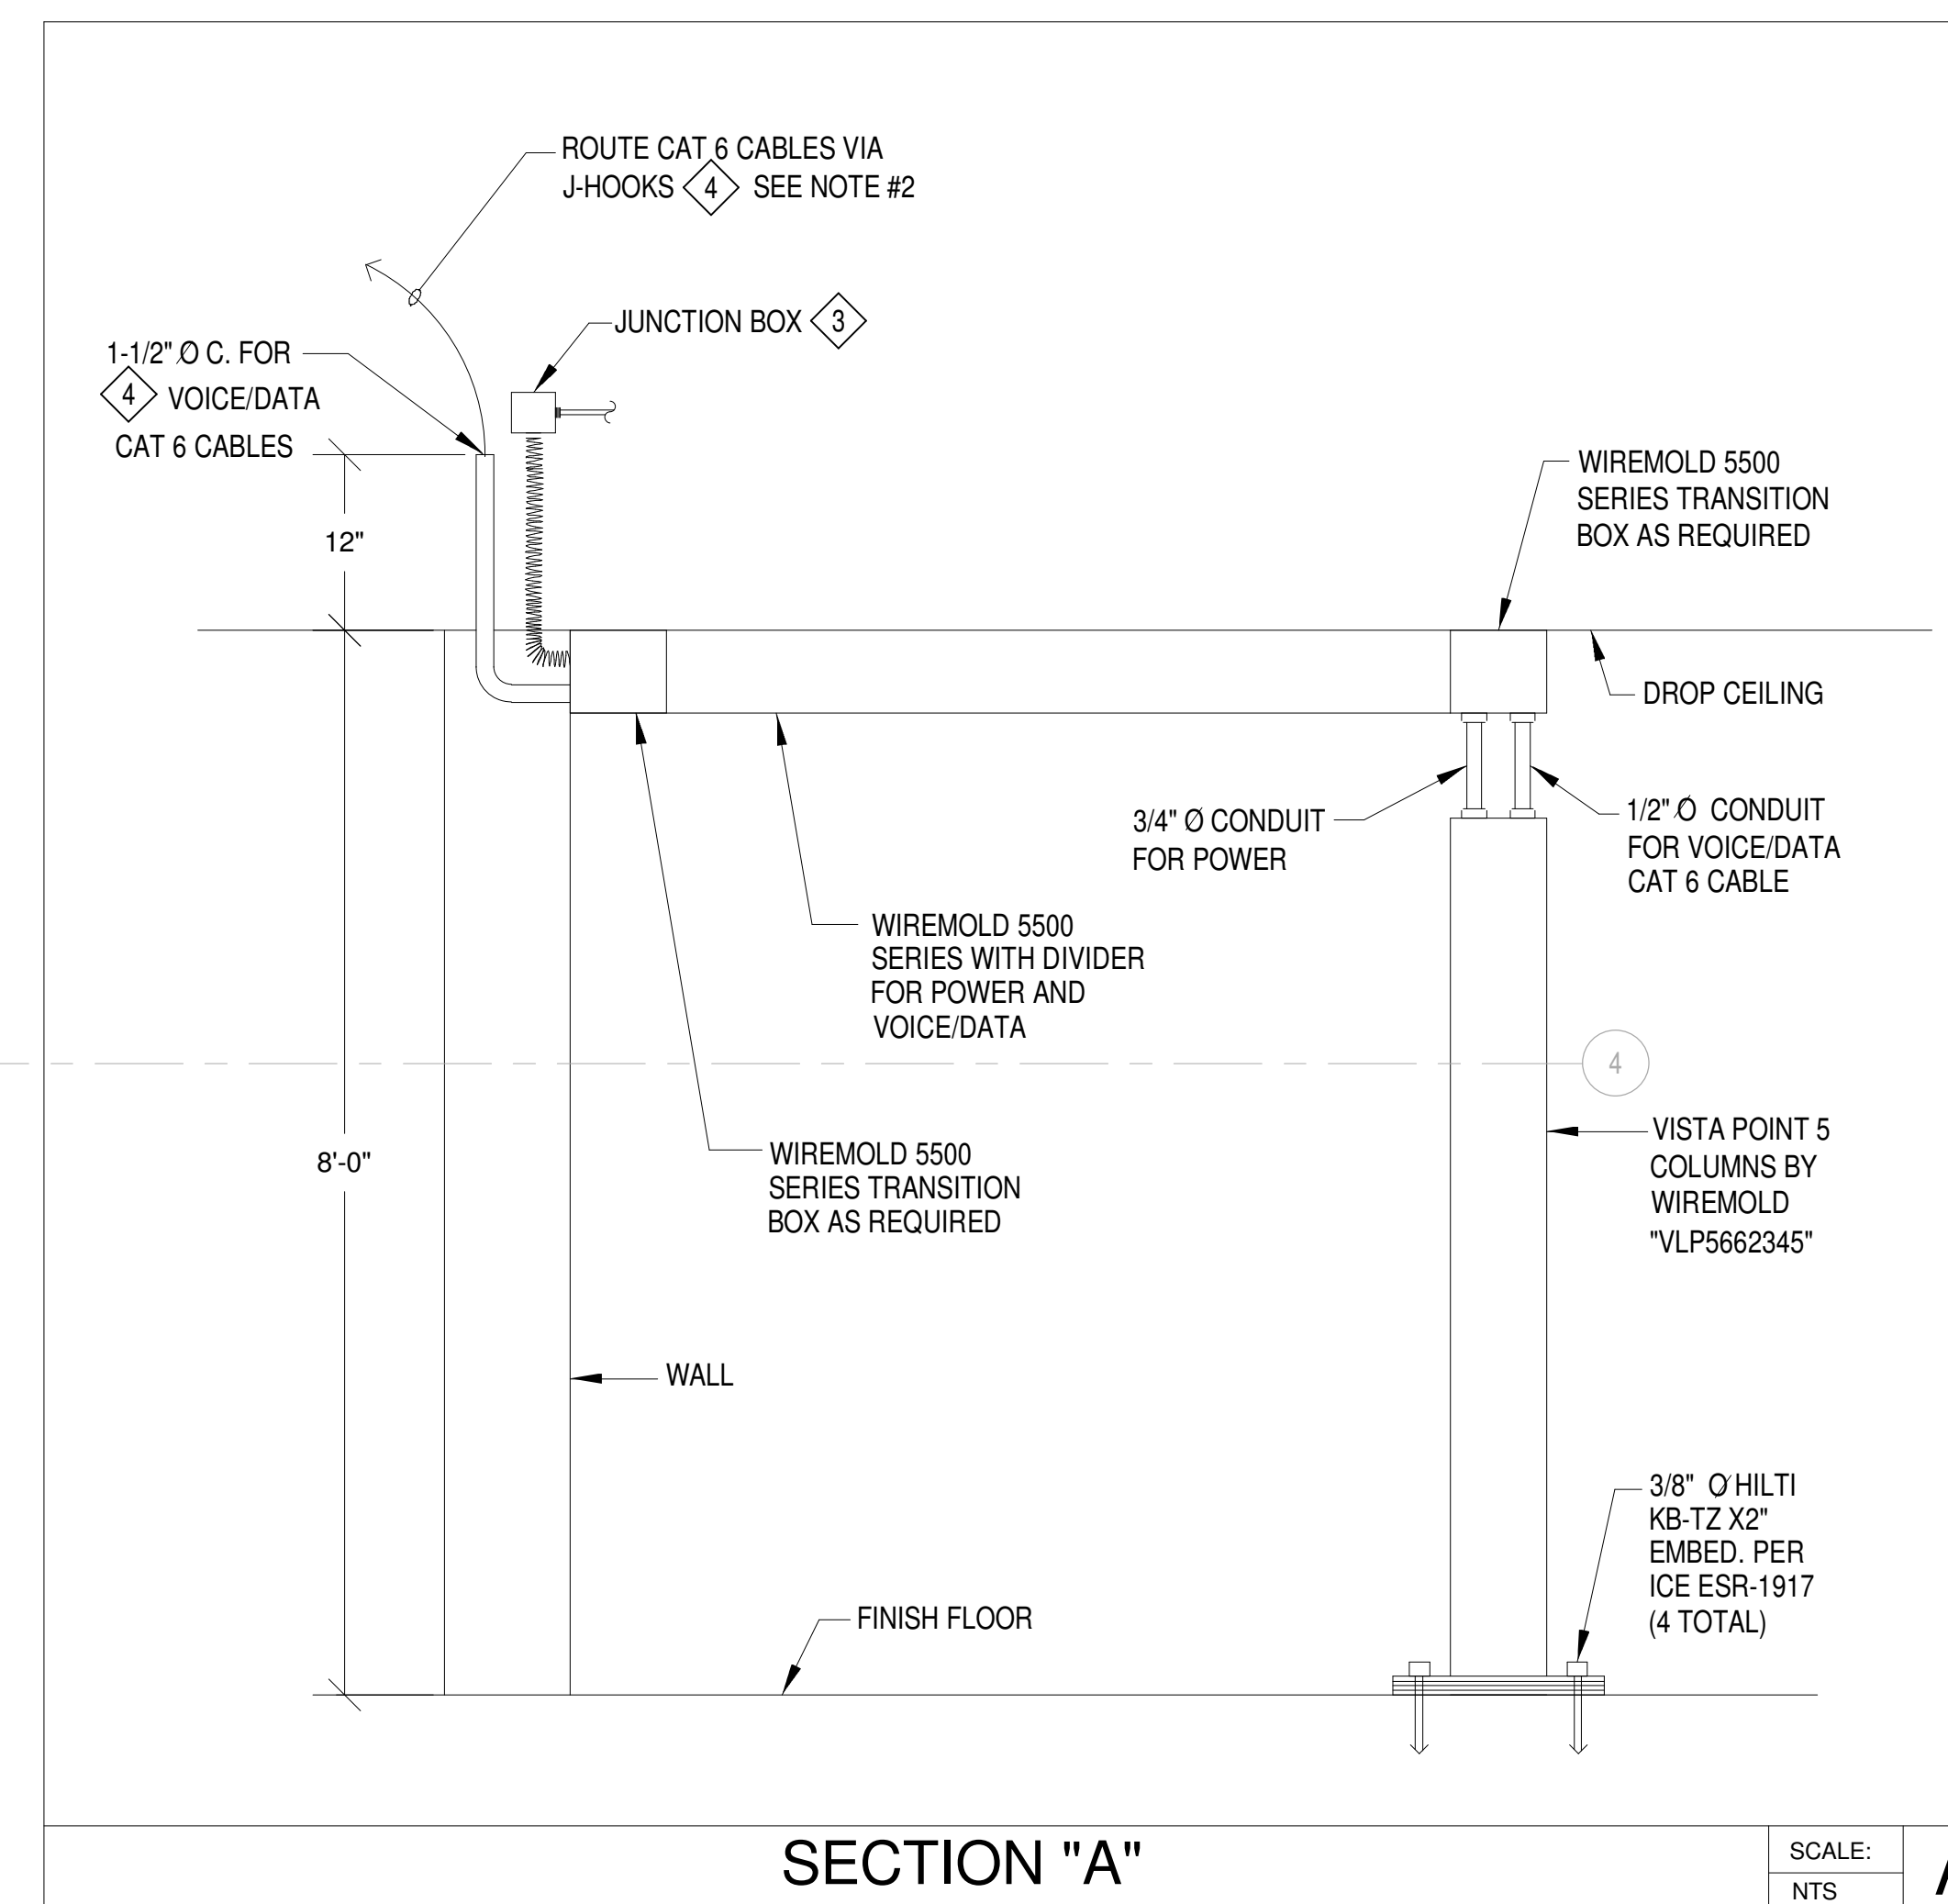

SCALE:	/
NTS	

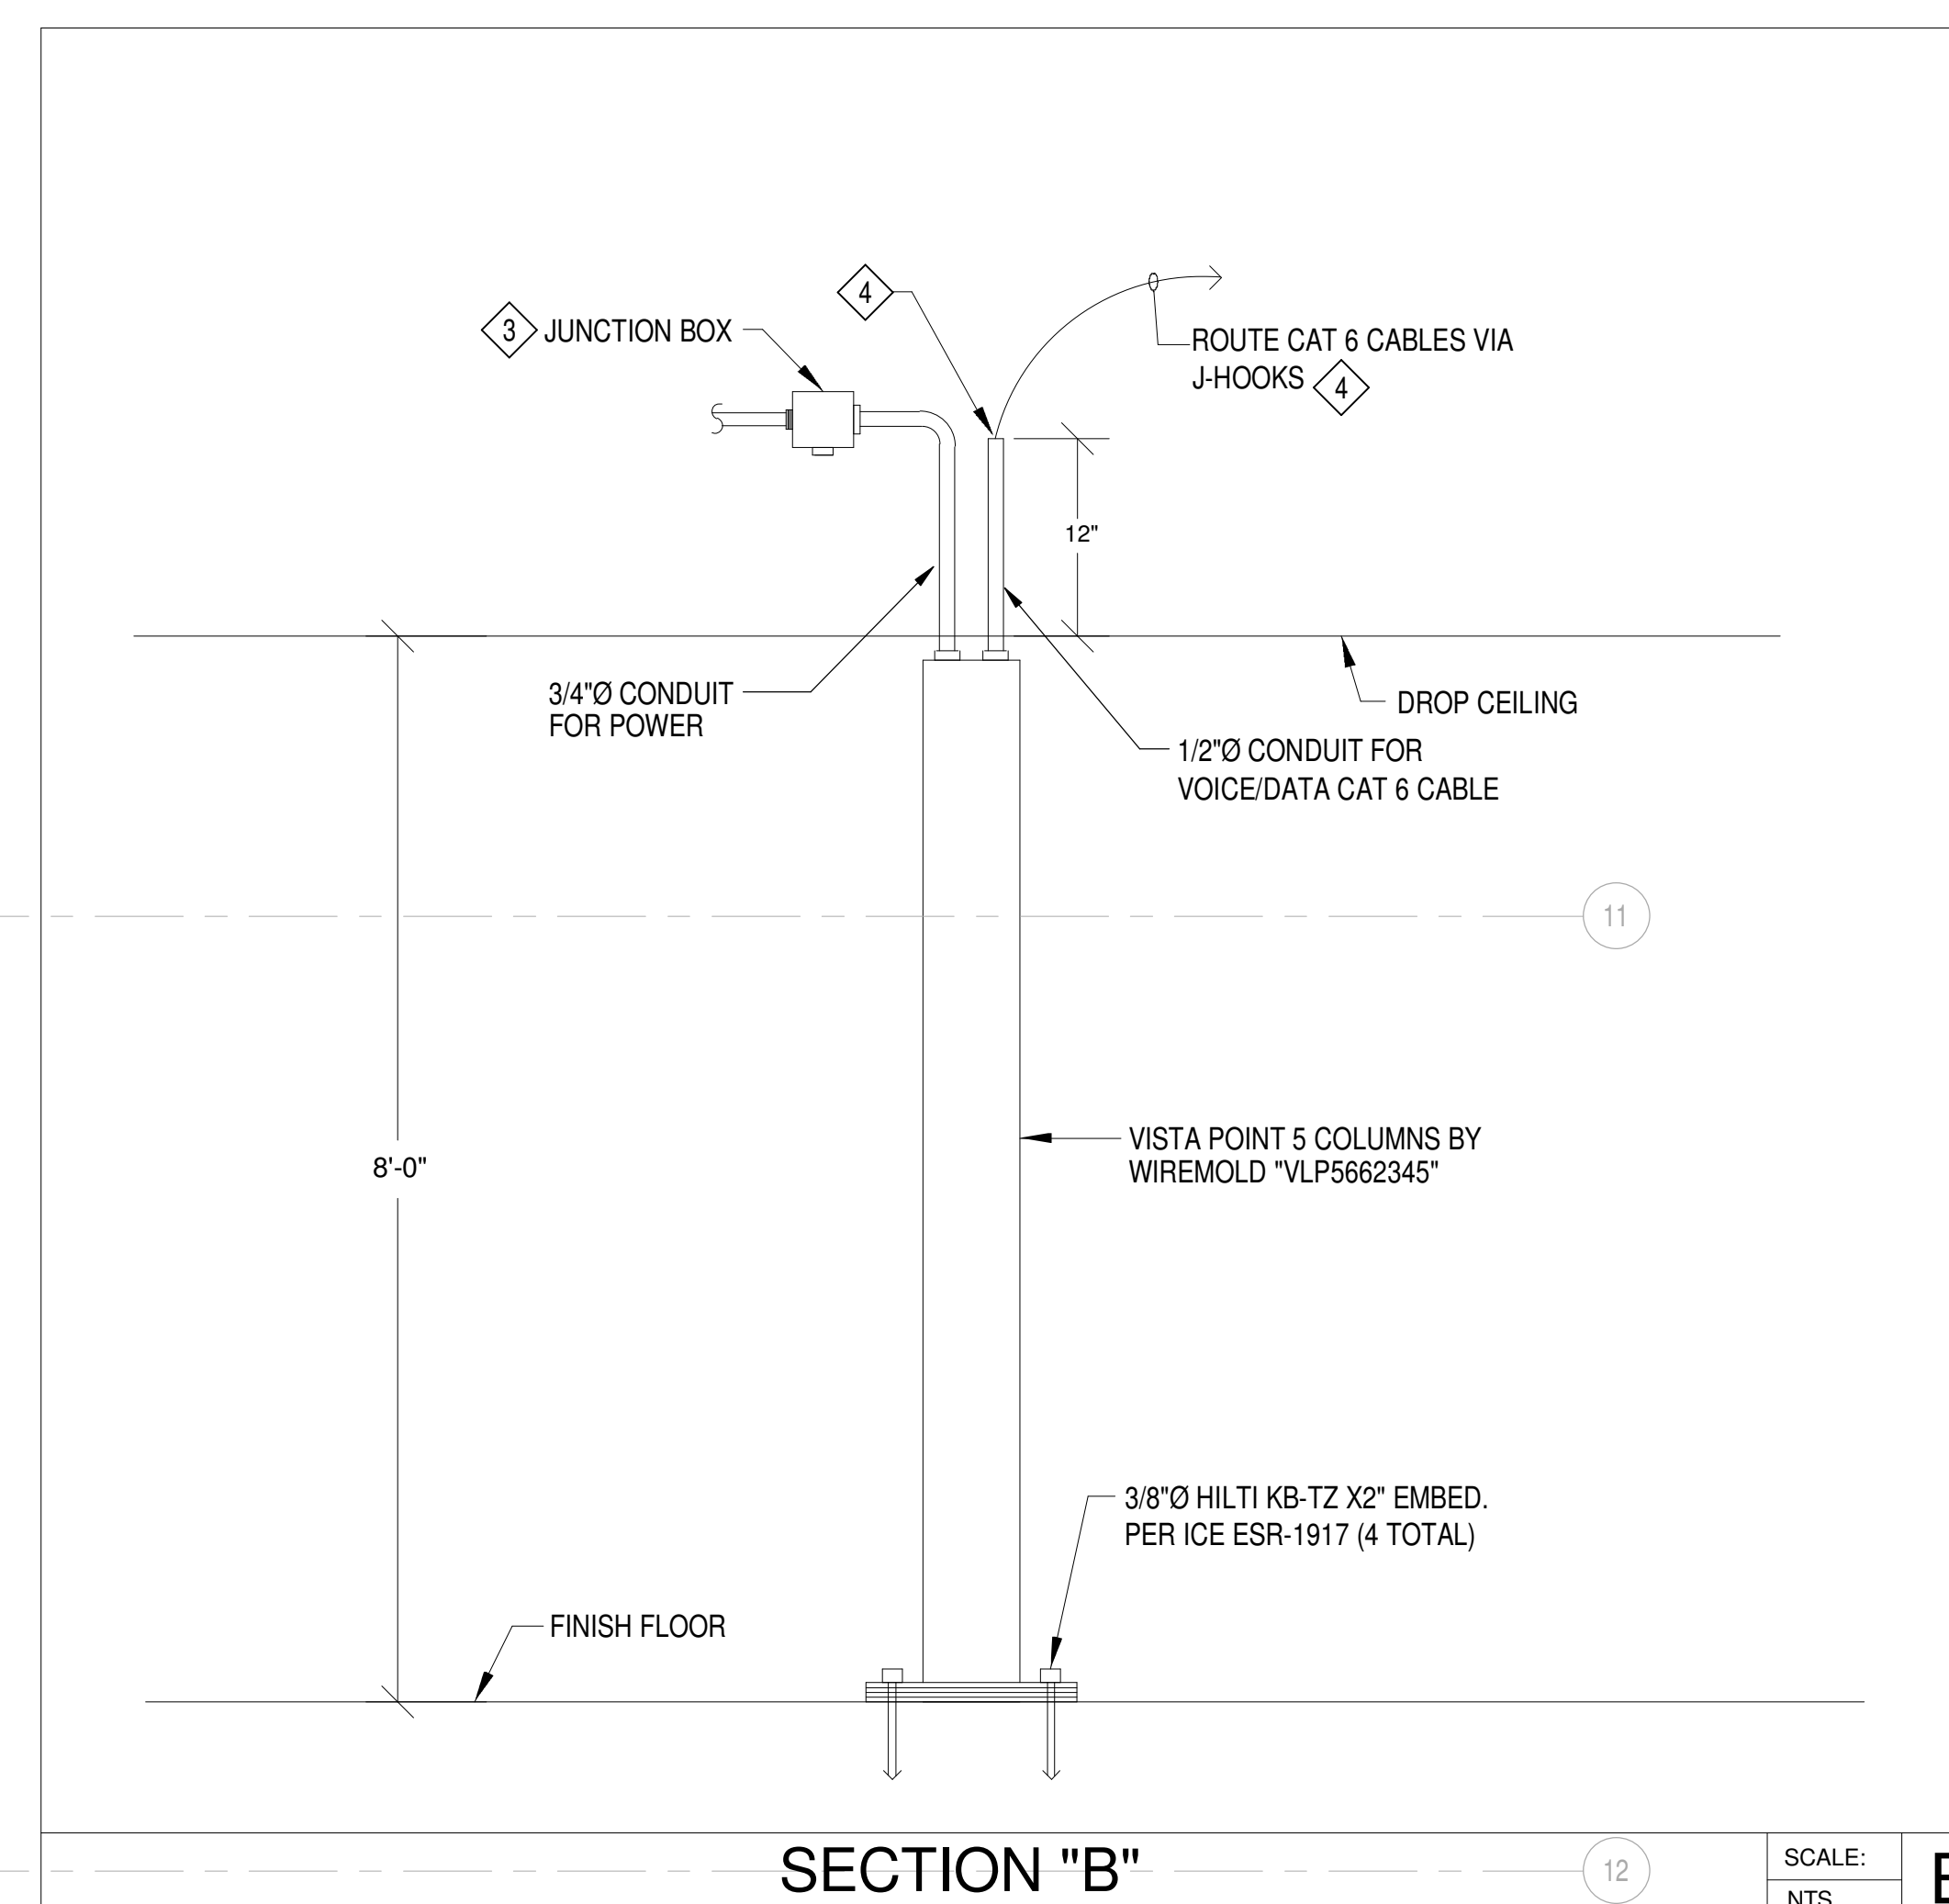

SCALE:	E
NTS	

SHEET KEY NOTES


- 1 PROVIDE 2" C. WITH FIBER OPTIC CABLES TO EXISTING INFORMATION TECHNOLOGY "IT" ROOM. COORDINATE WITH VA LONG BEACH "IT" FOR FIBER OPTIC COMPLETE REQUIREMENTS CONNECTIONS PRIOR TO BID.
- 2 PROVIDE INTERMEDIATE DISTRIBUTION FRAME "IDF" WITH FIBER OPTIC SWITCH, PATCH PANEL AND OTHER ACCESSORIES. COORDINATE WITH VA LONG BEACH "IT" FOR FIBER OPTIC SWITCH, PATCH PANEL PRIOR TO BID.
- 3 STUB-OUT/Locate CONDUIT AND JUNCTION BOX IN ACCESSIBLE CEILING SPACE. CONTRACTOR TO FIELD VERIFY PRIOR TO BID.
- 4 PROVIDE J-HOOKS FOR VOICE/DATA CABLES IN EVERY 4'-0" SPAN. COORDINATE WITH VALB INFORMATION TECHNOLOGY PRIOR TO BID. SEE J-HOOKS PLAN ON SHEET ES-202.
- 5 PROVIDE ENCLOSED CIRCUIT BREAKER, SEE SINGLE LINE DIAGRAMS ON SHEET ES-302 FOR RATING.
- 6 PROVIDE TRANSFORMER, SEE SINGLE LINE DIAGRAMS ON SHEET ES-302 FOR RATING AND REQUIREMENT.
- 7 PATHOLOGY LAB. CONTRACTOR SHALL BE RESPONSIBLE TO REMOVE EQUIPMENT/DEVICES AFTER SWING SPACE MOVED TO PERMANENT AREA, AND REINSTALL EQUIPMENT/DEVICES IN ELECTRICAL ROOM ON PHASE-3 OF RENOVATION. SEE SHEET ES-302 FOR REFERENCE.
- 8 PROVIDE POWER CONNECTION TO UNDER-CABINET LIGHT FIXTURE, TYPICAL WHERE IT OCCURS.

GENERAL SHEET NOTES

LEGEND:



KEY PLAN

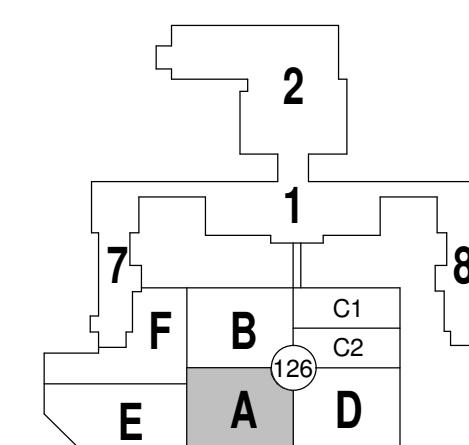

FINAL CONSTRUCTION DOCUMENT SUBMITTAL


ENGINEERS/ CONSULTANTS:



TMD TAYLOR & GAINES
100 South Anaheim Boulevard, Suite 150
Anaheim, California 92805
Phone: 714.490.5555 Fax: 714.490.5560
www.ttgcorp.com Project No. 0311.146.00



ARCHITECT:

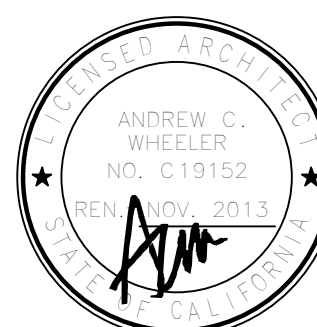

gkkworks

155 South Fair Oaks
Pasadena, CA 91105
626 666 6906 626 666 3940 fax

Drawing Title
**SWING SPACE RENOVATION POWER,
VOICE/DATA & SIGNAL PLAN - QUAD A -
PHASE 1**

CHIEF CONST. MGMT./DESIGN SECTION

PROJECT ENGINEER

Drawn	
-------	--

—	HH
---	----

Project Title
**RENOVATION OF
PATHOLOGY LAB SECOND
FLOOR**

	Building Number
--	-----------------

126	MEDIC
Location 5901 E. SEVENTH STREET LONG BEACH, CALIFORNIA 90822	

VETERANS AFFAIR
MEDICAL CENTER

Date	06/22/12
------	----------

00/22/12

Project Number
600-12-14

Drawing Number

ES 2024

ES-202A

