

Revisions	Date

--

M-K ENGINEERING, INC. CONSULTING ENGINEERS HVAC—PLUMBING—FIRE PROTECTION—ELECTRICAL 4323 Division Street, Suite 211 Metairie, LA 70002 Tel:(504) 887-2376, Fax:(504) 887-2302 M-K Project No.: 0980
--


--

Drawing Title	Project Title
DEMOLITION FLOOR PLAN	RENOVATE LOBBY OF IG
HVAC & SPRINKLER	PARKING GARAGE
Approved Division Chief	Building Number
Approved Service Director	Location
	1601 PERDIDO STREET NEW ORLEANS, LOUISIANA


Date	Project No.
6/19/09	629-09-101 NCM
Sheet No.	ME-2
2 OF 6	

SOUTHEAST LOUISIANA VETERANS HEALTH CARE SYSTEM

1 DEMOLITION FLOOR PLAN - HVAC
SCALE: 1/4" = 1'-0"

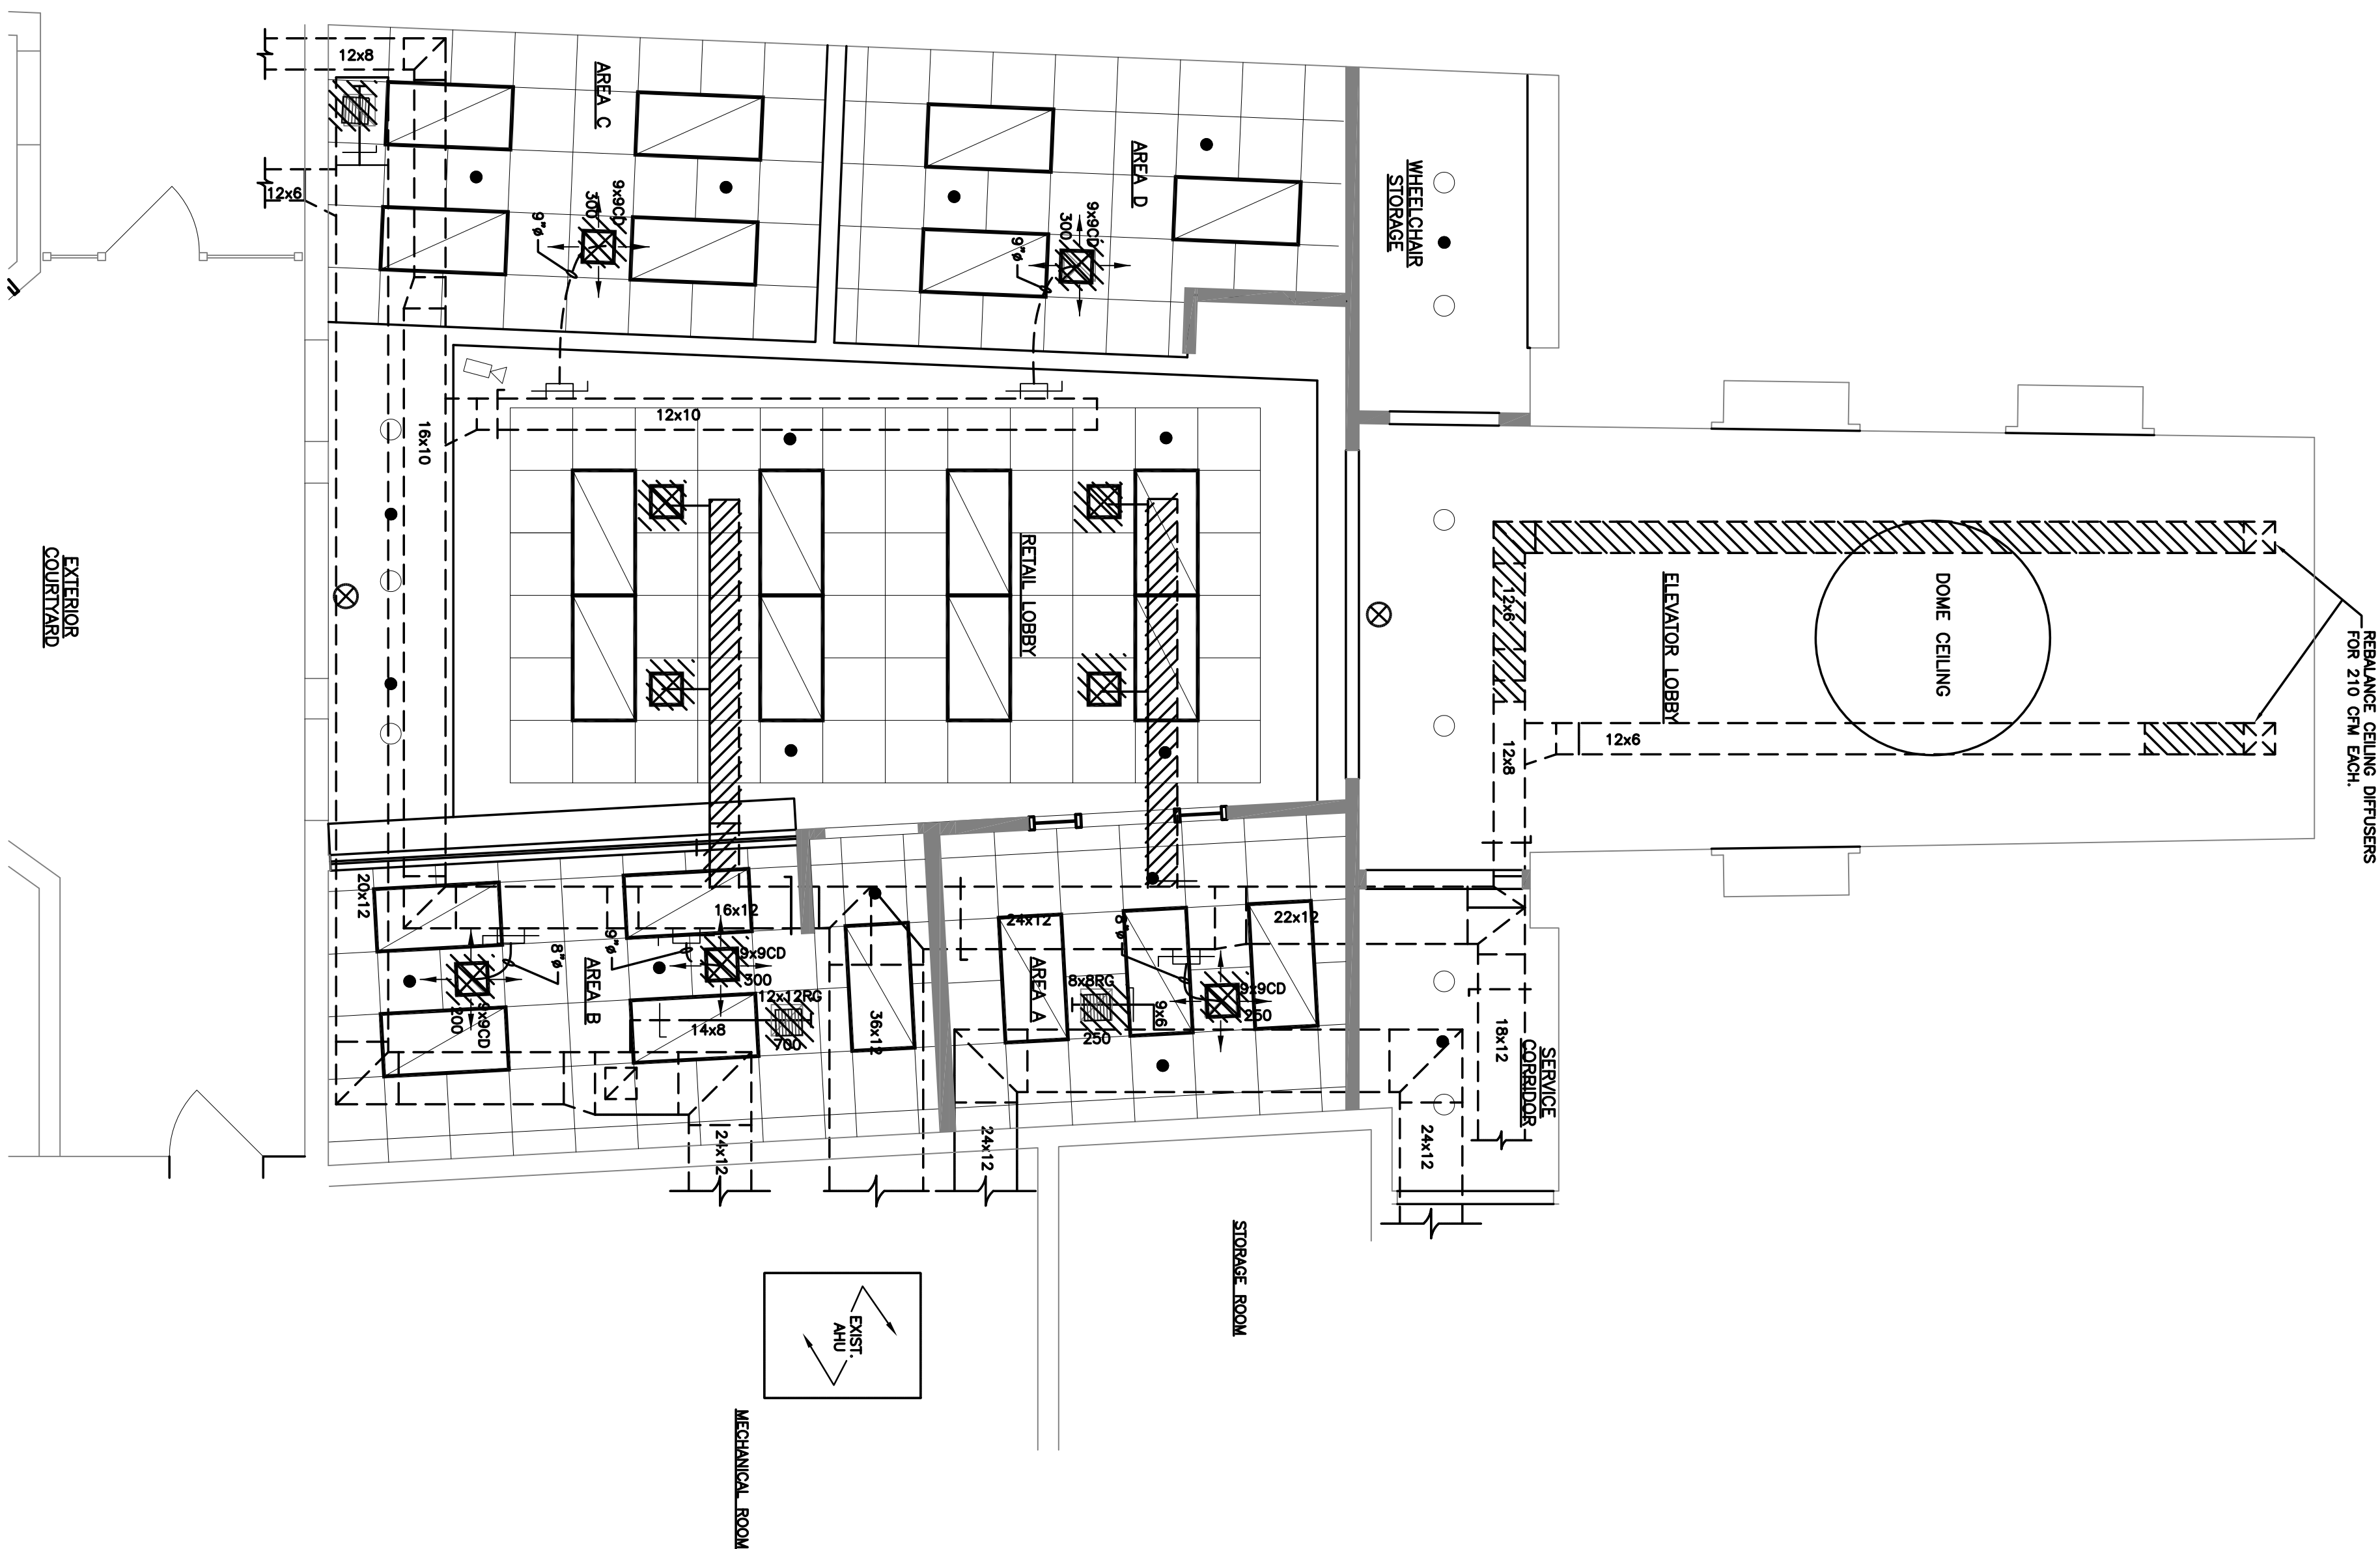

2 DEMOLITION FLOOR PLAN - SPRINKLER
SCALE: 1/4" = 1'-0"

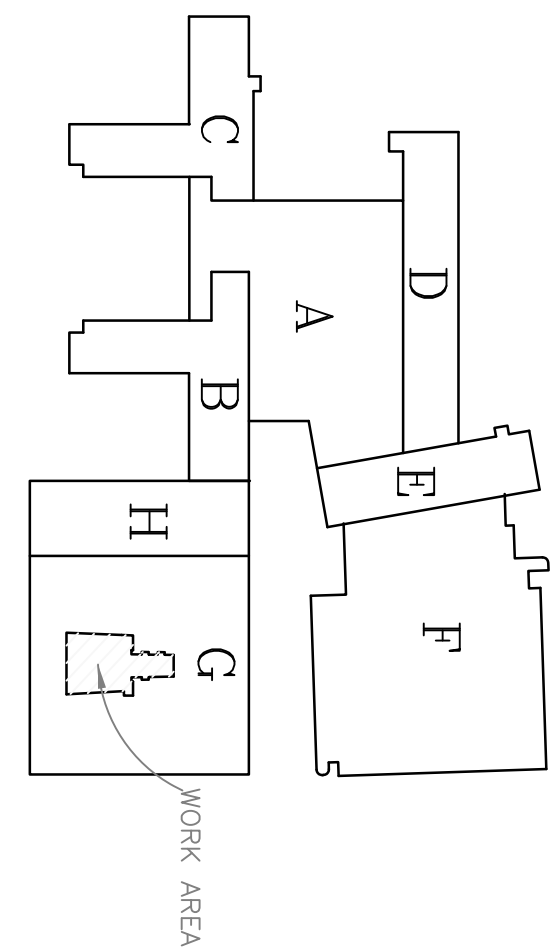

KEY PLAN
NOT TO SCALE

CEILING LEGEND:	
	2x4 LIGHT FIXTURE
	RECESSED LIGHT FIXTURE
	EXIT LIGHT
	REMOVE A/C DIFFUSER AND RELATED BRANCH DUCT
	REMOVE RETURN AIR GRILLE AND RELATED BRANCH DUCT
	REMOVE SPRINKLER HEAD AND BRANCH PIPE AS REQUIRED TO REPLACE NEW HEAD, NEW TYPE IN NEW ARMSTRONG CEILING