

A

B

C

D

E

F

A

B


C

D


E

F


three inches = one foot
one and one half inches = one foot
one inch = one foot
three quarters inch = one foot
one half inch = one foot
three eighths inch = one foot
one quarter inch = one foot
one eighth inch = one foot

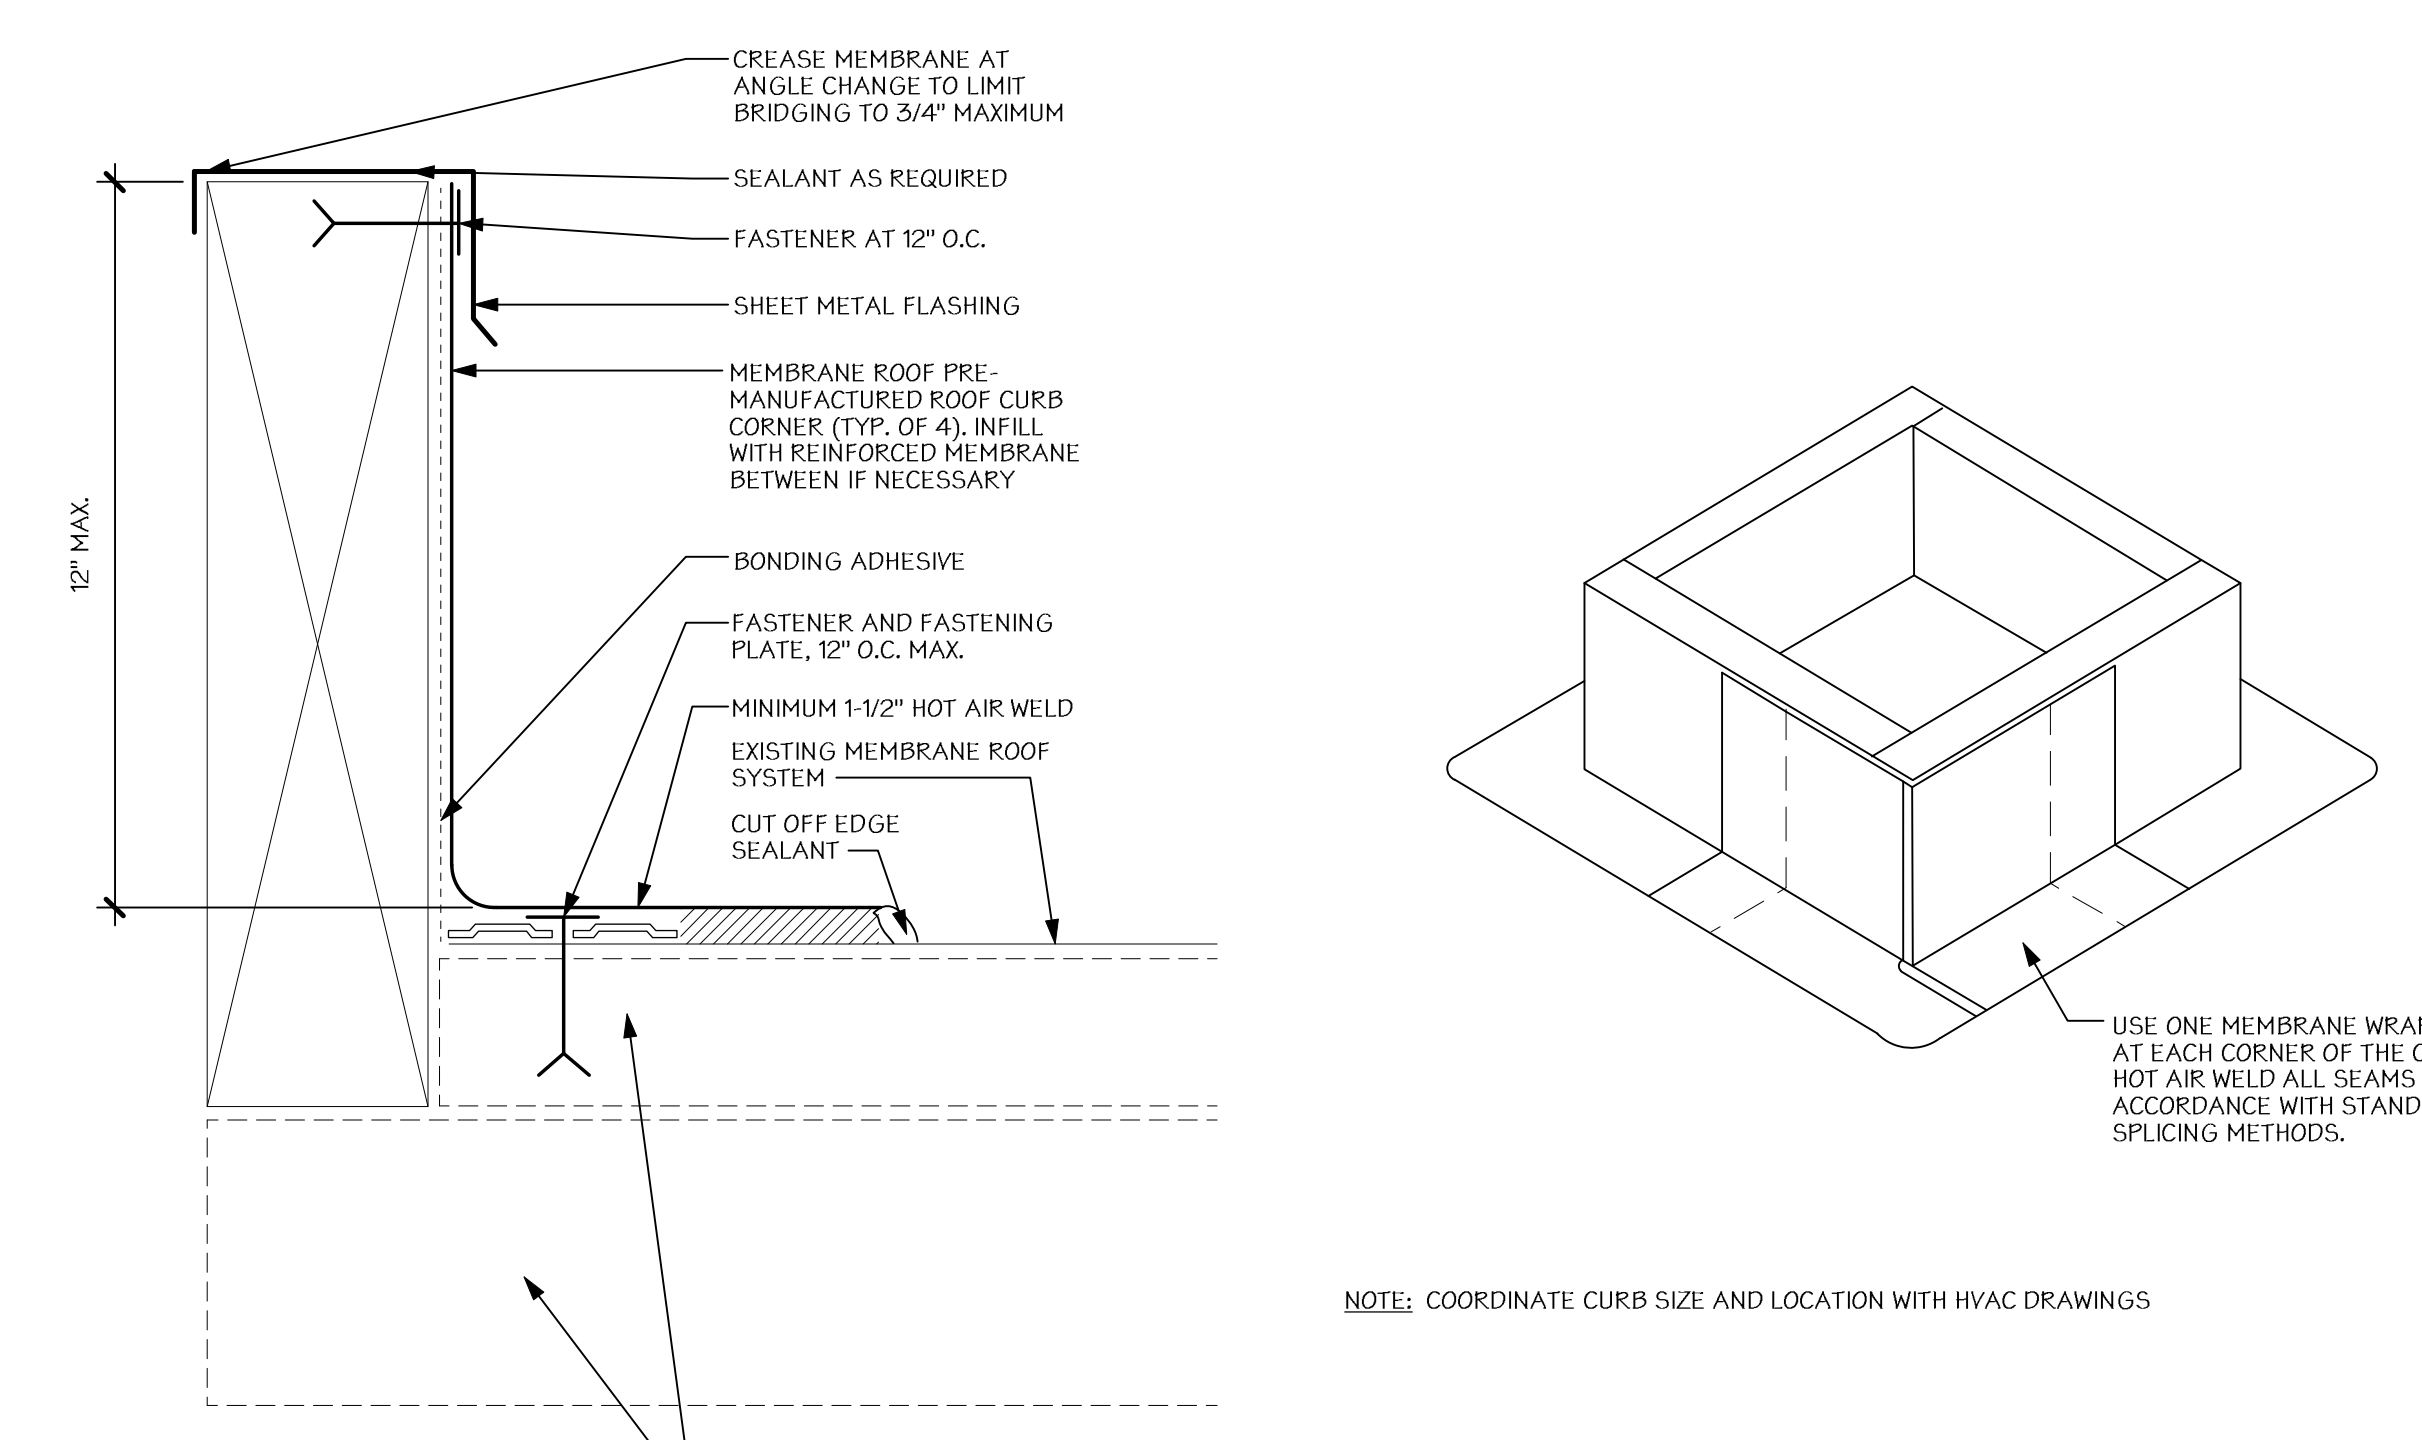

6 ROOF CURB DETAIL
Scale: 3" = 1'-0"

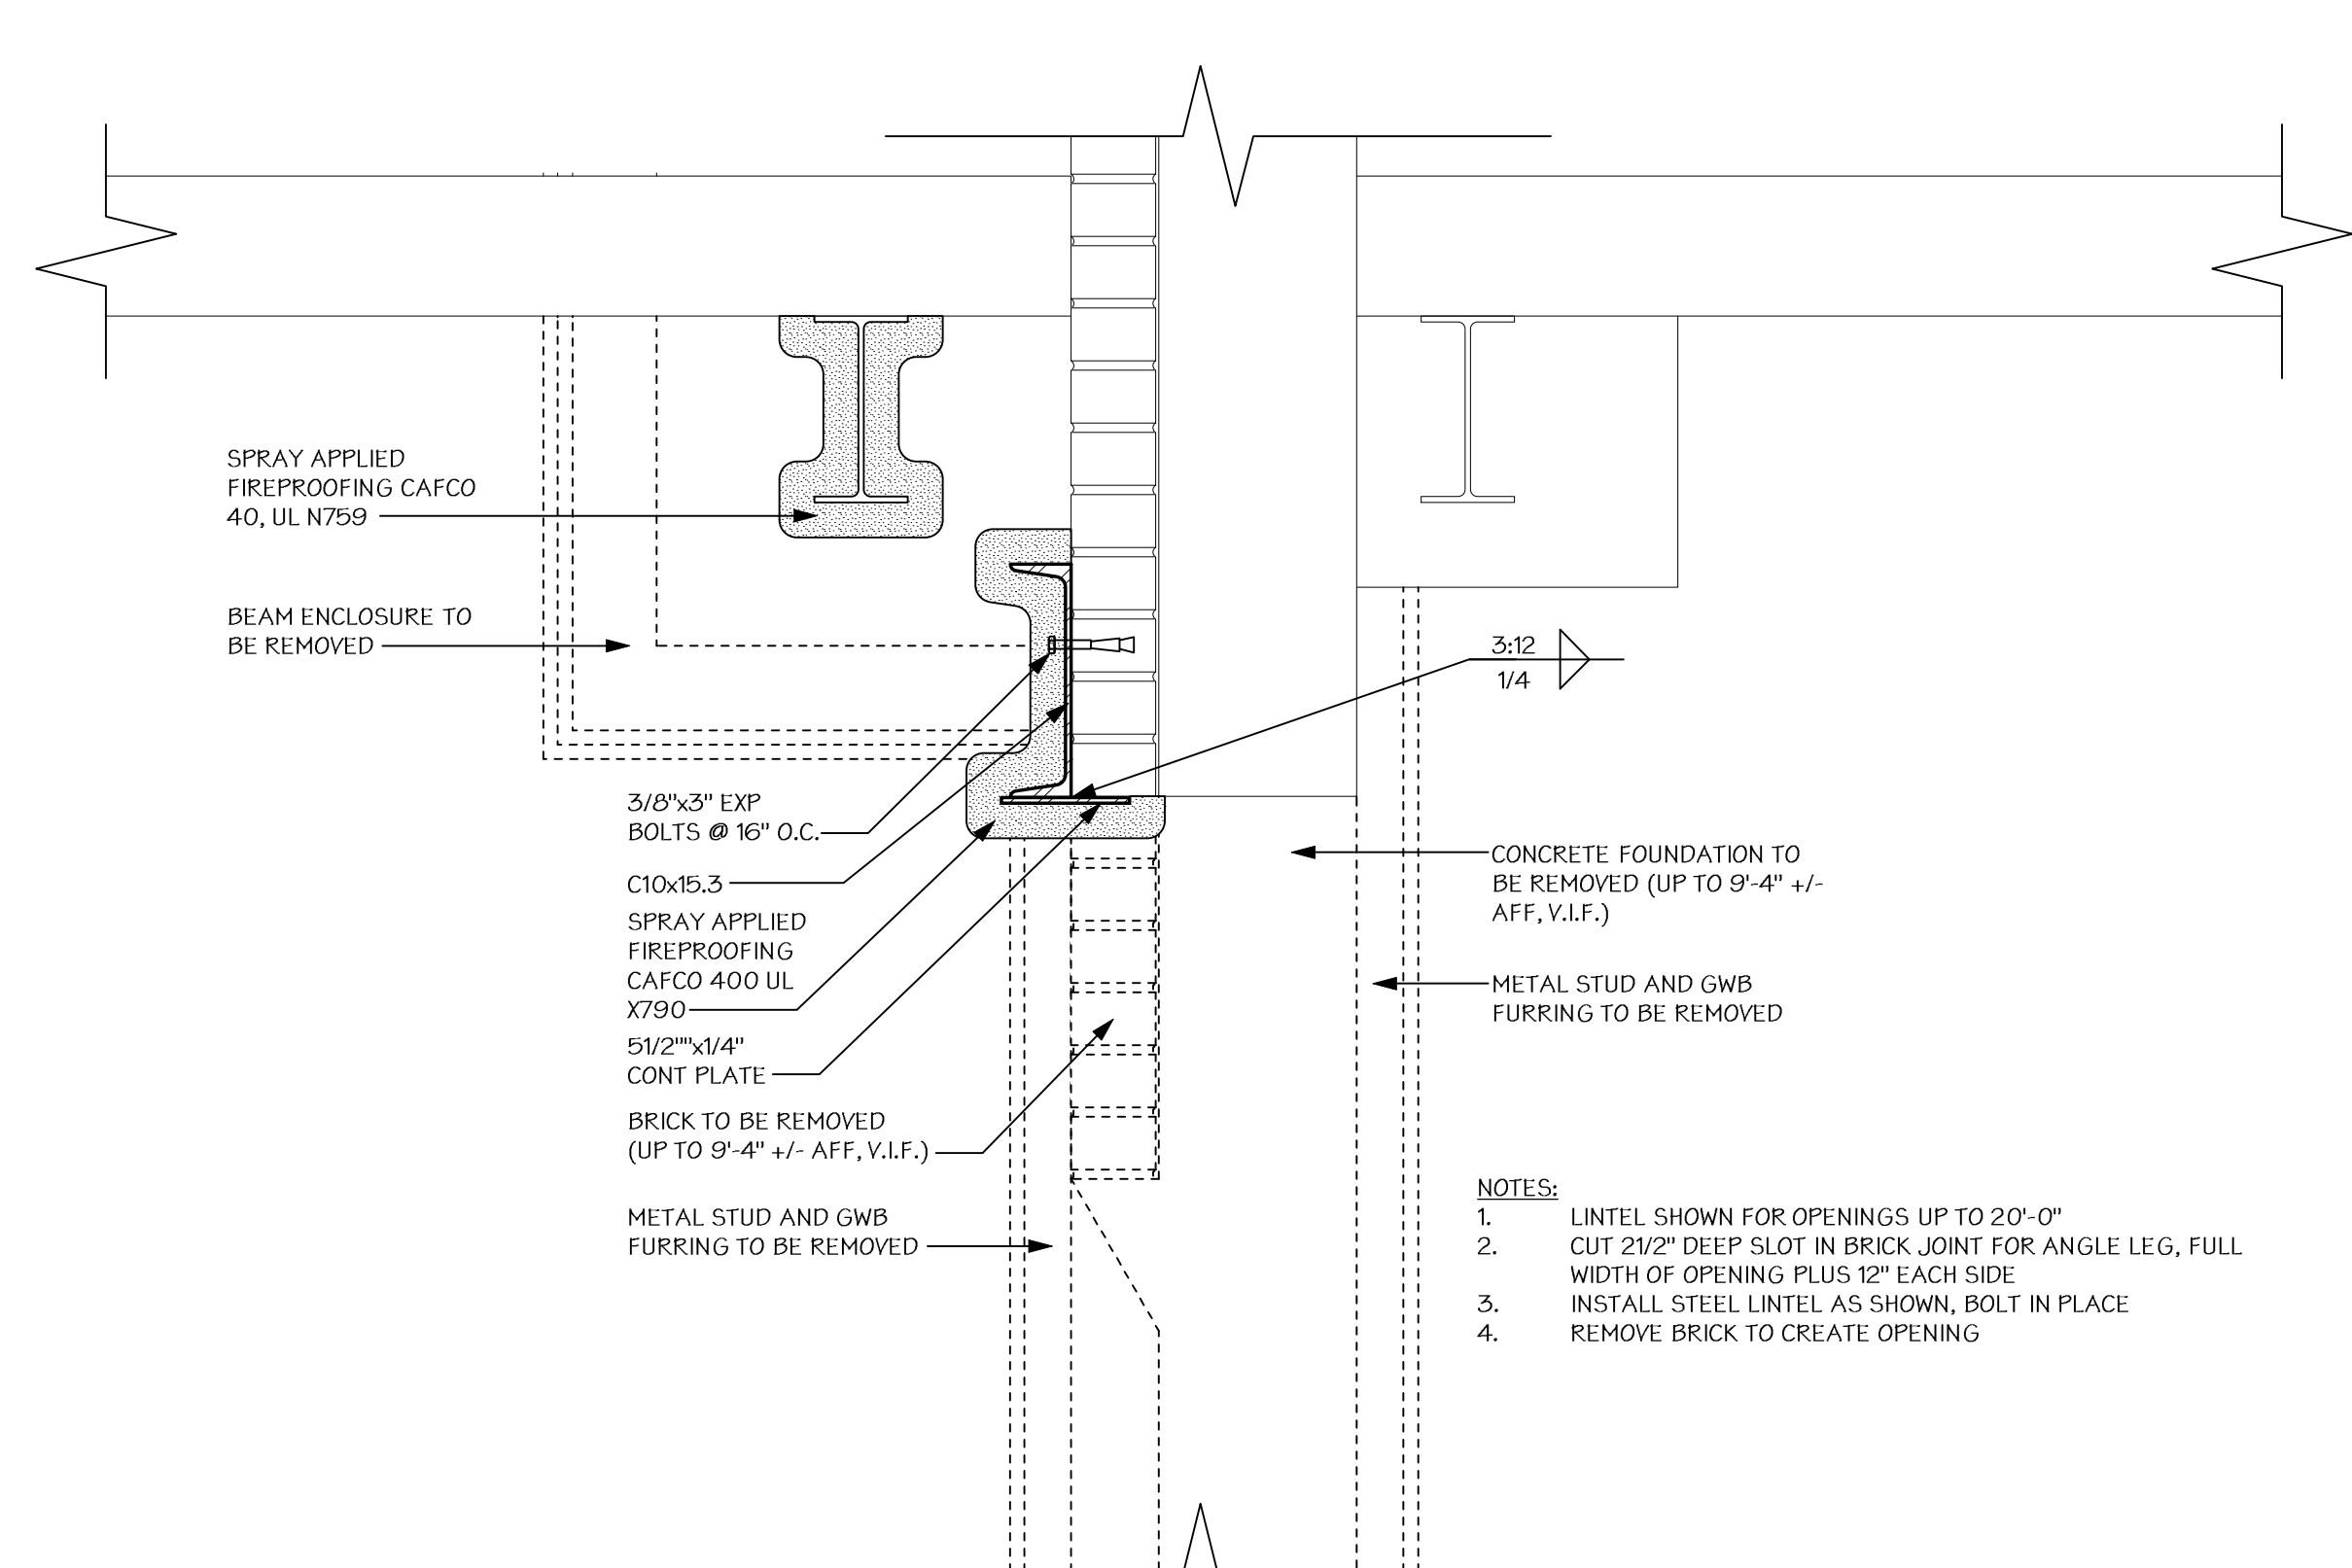

5 LINTEL DETAIL
Scale: 1 1/2" = 1'-0"

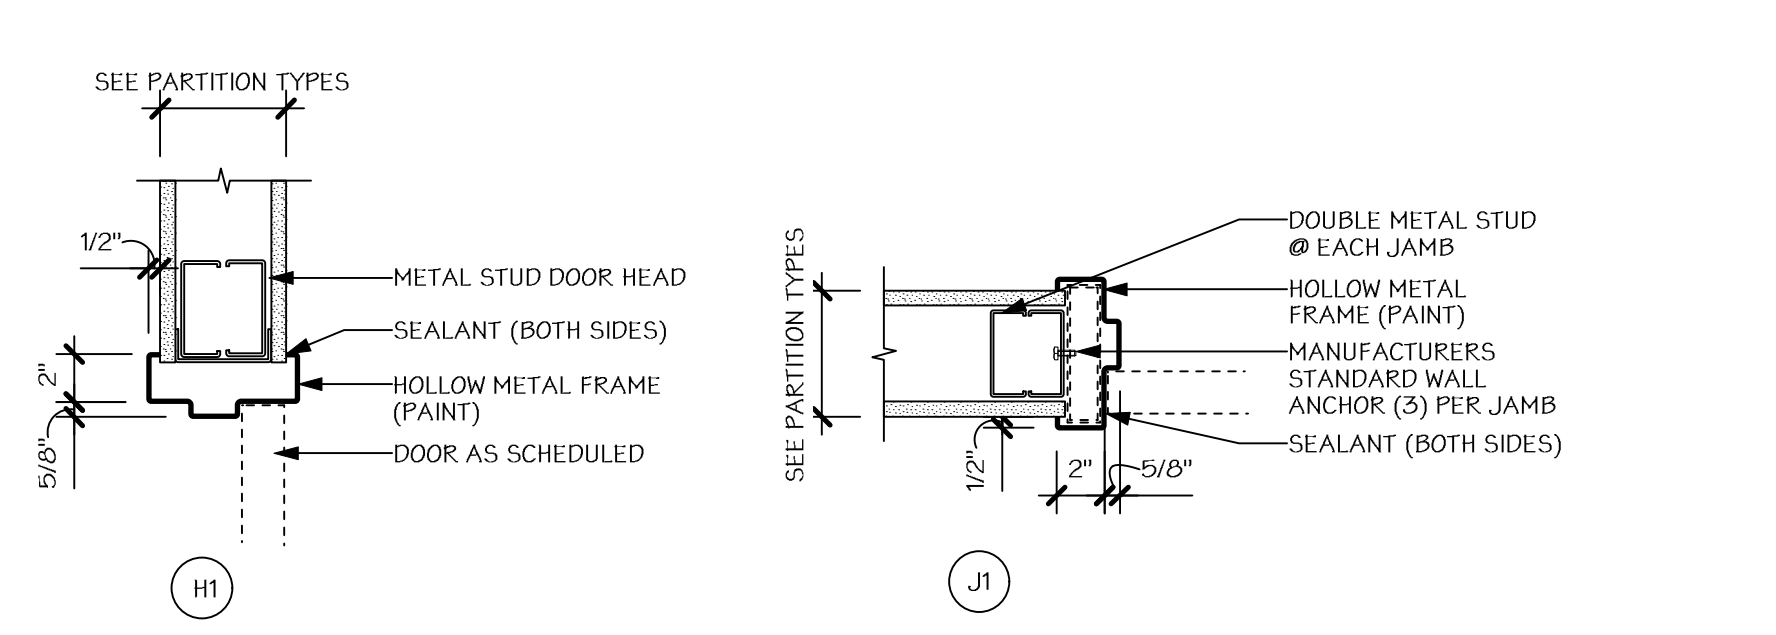

4 HEAD, JAMB AND SILL DETAILS
Scale: 1 1/2" = 1'-0"

HARDWARE SET NUMBER: 1				
QTY	DESCRIPTION	PART #	MANUF.	FINISH
3	HINGES	-	YALE	626
1	ELECTRIC LOCKSET	CCR-0809FL-K660	YALE	626
1	KICK PLATE	J102	DON-JO	626
3	SILENCERS	L03011	TRIMCO	GREY
1	DOOR STOP	L02121	TRIMCO	CONVEX

HARDWARE SET NUMBER: 2				
QTY	DESCRIPTION	PART #	MANUF.	FINISH
3	HINGES	-	YALE	626
1	LOCKSET	CCR-0805FL-K660	YALE	626
1	KICK PLATE	J102	DON-JO	626
3	SILENCERS	L03011	TRIMCO	GREY
1	DOOR STOP	L02121	TRIMCO	CONVEX

HARDWARE SET NUMBER: 3				
QTY	DESCRIPTION	PART #	MANUF.	FINISH
3	HINGES	-	YALE	626
1	LOCKSET	CCR-0805FL-K660	YALE	626
1	KICK PLATE	J102	DON-JO	626
3	SILENCERS	L03011	TRIMCO	GREY
1	DOOR STOP	L02121	TRIMCO	CONVEX

HARDWARE SET NUMBER: 4				
QTY	DESCRIPTION	PART #	MANUF.	FINISH
1	CONTINUOUS HINGE	-	YALE	626
1	LOCKSET	CCR-0809FL-K660	YALE	626
1	KICK PLATE	J102	DON-JO	626
3	SILENCERS	L03011	TRIMCO	GREY
1	DOOR STOP	L02121	TRIMCO	CONVEX


HARDWARE SET NUMBER: 5				
QTY	DESCRIPTION	PART #	MANUF.	FINISH
3	HINGES	-	YALE	626
1	ELECTRIC LOCKSET	CCR-0809FL-K660	YALE	626
1	CLOSER	3611	YALE	609
1	KICK PLATE	J102	DON-JO	626
3	SILENCERS	L03011	TRIMCO	GREY
1	DOOR STOP	L02121	TRIMCO	CONVEX

HARDWARE SET NUMBER: 6				
QTY	DESCRIPTION	PART #	MANUF.	FINISH
3	HINGES	-	YALE	626
1	LOCKSET	CCR-0805FL-K660	YALE	626
1	CLOSER	3611	YALE	609
1	KICK PLATE	J102	DON-JO	626
3	SILENCERS	L03011	TRIMCO	GREY
1	DOOR STOP	L02121	TRIMCO	CONVEX

HARDWARE SET NUMBER: 7				
QTY	DESCRIPTION	PART #	MANUF.	FINISH
3	HINGES	-	YALE	626
1	LOCKSET	CCR-0805FL-K660	YALE	626
1	KICK PLATE	J102	DON-JO	626
3	SILENCERS	L03011	TRIMCO	GREY
1	DOOR STOP	L02121	TRIMCO	CONVEX

1	DOOR STOP	L02121	TRIMCO	CONVEX
1	CLOSER	3611	YALE	609



1 PARTITION TYPES
Scale: 1" = 1'-0"

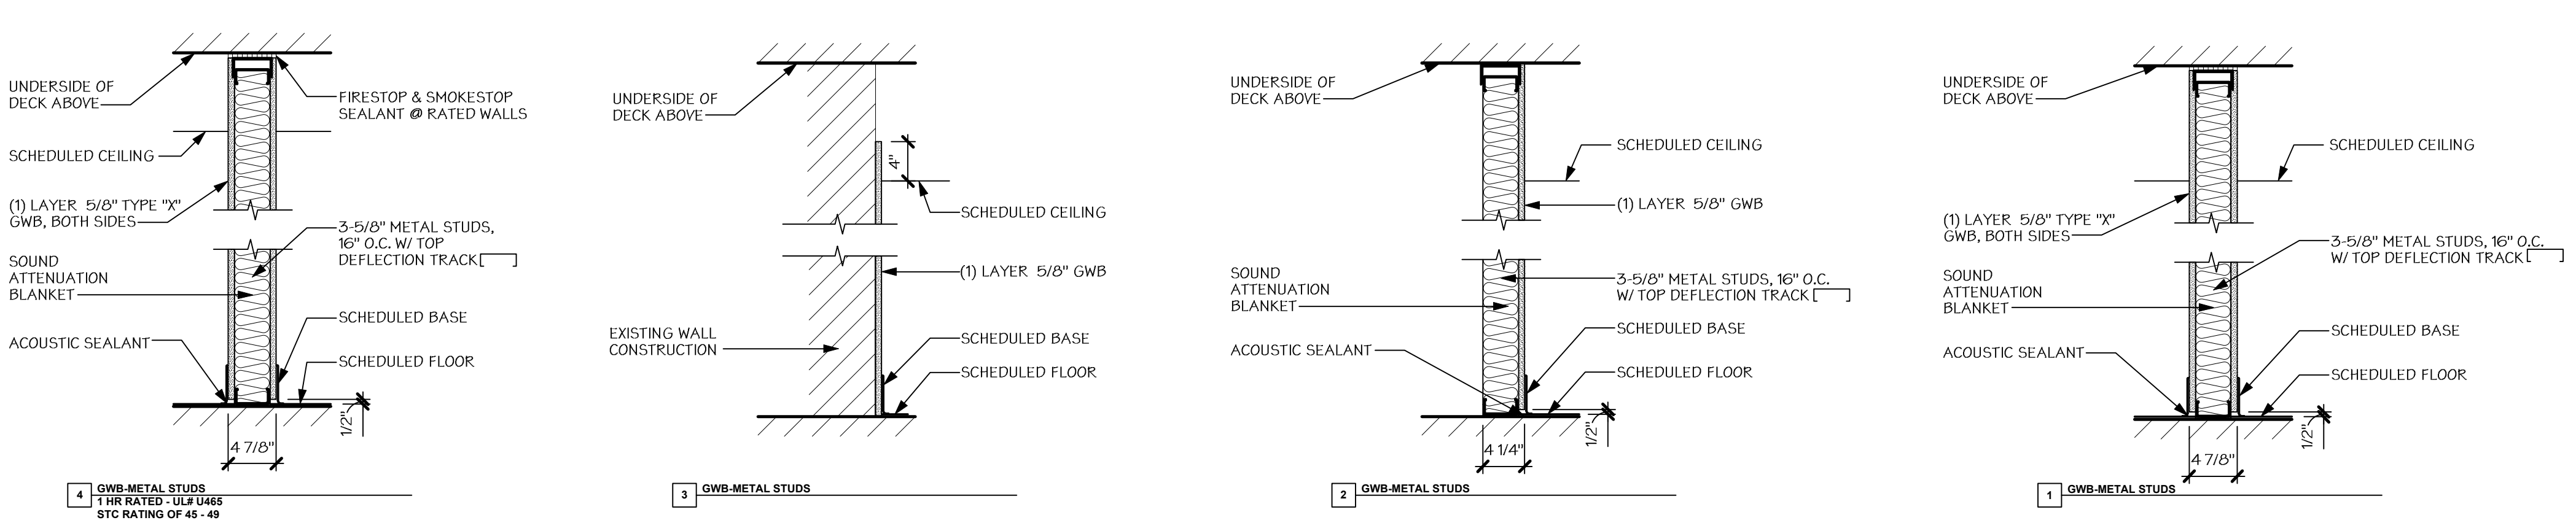

DOOR AND FRAME SCHEDULE														
DOOR				SIZE			FRAME			DETAILS		GENERAL		
DOOR NO.	TYPE	MATERIAL	GLAZING	WIDTH	HEIGHT	THICKNESS	TYPE	MATERIAL	GLAZING	HEAD	JAMB	FIRE LABEL	HARDWARE	REMARKS
100	EXIST.	HM	-	3'-0"	7'-0"	1 3/4"	EXIST.	HM	-	EXIST.	EXIST.	-	7	EXISTING DOOR & FRAME W/NEW HARDWARE
101	B	WD	TEMP.	3'-0"	7'-0"	1 3/4"	1	HM	-	H1	J1	-	2	
102	B	WD	TEMP.	3'-0"	7'-0"	1 3/4"	1	HM	-	H1	J1	-	2	
103	A	WD	-	3'-0"	7'-0"	1 3/4"	1	HM	-	H1	J1	-	4	
104	B	WD	TEMP.	3'-0"	7'-0"	1 3/4"	1	HM	-	H1	J1	-	4	
105	A	WD	-	3'-0"	7'-0"	1 3/4"	1	HM	-	H1	J1	-	4	
106	A	WD	-	3'-0"	7'-0"	1 3/4"	1	HM	-	H1	J1	-	4	
107	A	WD	-	3'-0"	7'-0"	1 3/4"	1	HM	-	H1	J1	-	4	
108	A	WD	-	3'-0"	7'-0"	1 3/4"	1	HM	-	H1	J1	-	4	
109	A	WD	-	3'-0"	7'-0"	1 3/4"	1	HM	-	H1	J1	-	4	
110	A	WD	-	3'-0"	7'-0"	1 3/4"	1	HM	-	H1	J1	-	4	
111	A	WD	-	3'-0"	7'-0"	1 3/4"	1	HM	-	H1	J1	-	4	
112	A	WD	-	3'-0"	7'-0"	1 3/4"	1	HM	-	H1	J1	-	4	
113	B	WD	TEMP.	3'-0"	7'-0"	1 3/4"	1	HM	-	H1	J1	-	1	CARD READER REQ.
114	A	WD	-	3'-0"	7'-0"	1 3/4"	1	HM	-	H1	J1	-	4	
115	A	WD	FIRE	3'-0"	7'-0"	1 3/4"	1	HM	-	H1	J1	20 MIN.	5	CARD READER REQ.
116	B	WD	FIRE	3'-0"	7'-0"	1 3/4"	1	HM	-	H1	J1	20 MIN.	6	
117	EXIST.	WD	-	3'-0"	7'-0"	1 3/4"	EXIST.	HM	-	EXIST.	EXIST.	-	2	EXISTING DOOR & FRAME W/NEW HARDWARE

3 DOOR TYPES
Scale: 1/4" = 1'-0"

2 FRAME TYPES
Scale: 1/4" = 1'-0"

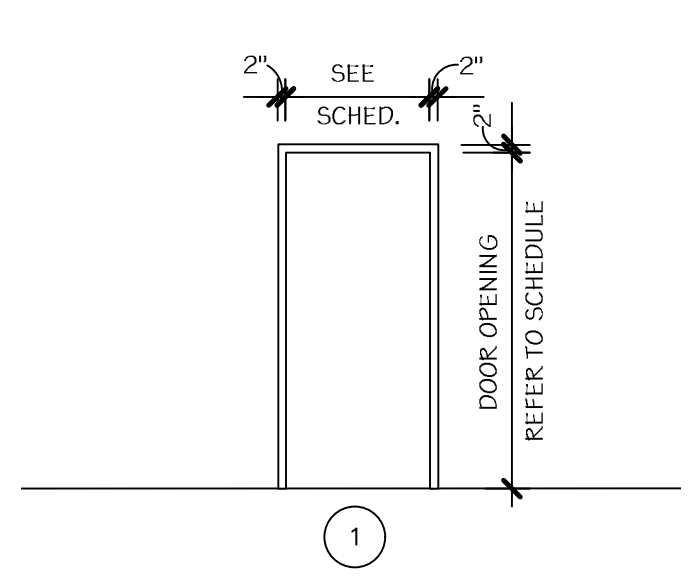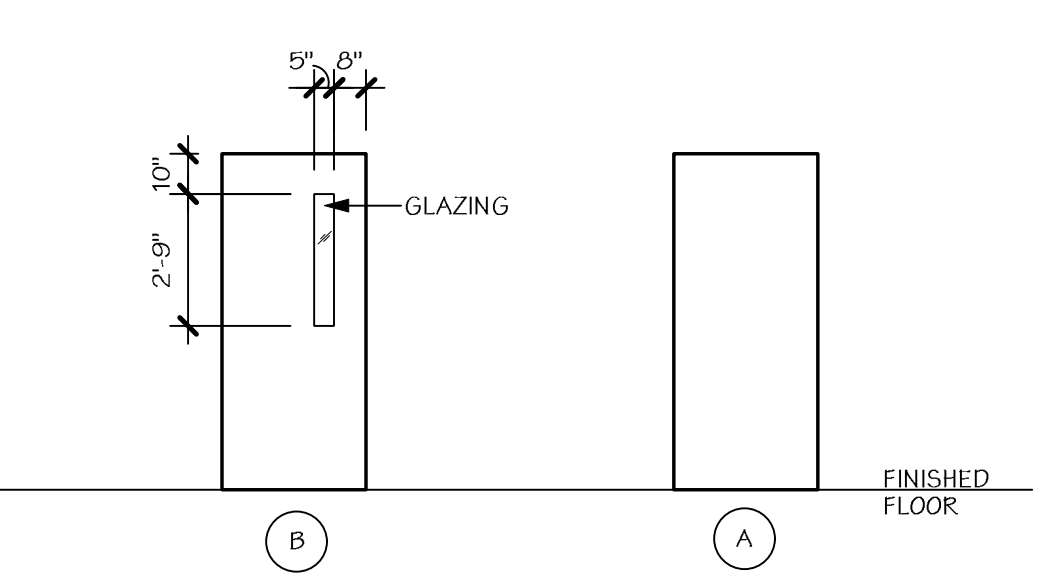

Revisions:

Date

CONSULTANTS:

AMENDMENT #1
01.17.13

ARCHITECT/ENGINEERS:

dwor
ARCHITECTURAL

SYRACUSE
313 East Willow Street
Suite 107
Syracuse, NY 13203
ph: 315.473.1800

ROCHESTER
1344 University Avenue
Suite 140
Rochester, NY 14607
ph: 585.461.4771

IPD: Engineering

INTEGRATED PROJECT DELIVERY
ONE WEBSTER'S LANDING
SYRACUSE, NEW YORK 13202
315.423.0185

Drawing Title
DOOR SCHEDULE, PARTITION TYPES,
AND DETAILS

Approved: Project Director

Project Title
SYRACUSE VA MEDICAL CENTER
RENOVATE FOR COMPENSATION & PENSION CLINIC

Location
800 IRVING AVENUE, SYRACUSE NY 13210

Date
01.17.13

Project Number
VA# 528A7-13-702
DWYER# 12-001.1
Building Number

Drawing Number
AS601
Dwg. 10 of 33

Scale: As Noted

VA HEALTHCARE NETWORK
UPSTATE NEW YORK