




Department of Veterans Affairs
Louis A. Johnson Medical Center
Clarksburg, WV 26301-4199

Interior Finishes Building One

VA Project Number: 540-11-102
IKM Project Number: 11-186

DRAWING INDEX

ISSUES / REVISIONS		
29 AUGUST 2012	100% CONSTRUCTION DOCUMENT SUBMISSION	ARCHITECTURAL
	SHEET NUMBER	
		SHEET NAME
	• A000	GENERAL NOTES, PARTITION TYPES, SCHEDULES AND LIFE SAFETY PLANS
	• A101a	LEVEL 1 EAST PHASE 1 FLOOR PLAN
	• A101b	LEVEL 1 WEST PHASE 1 FLOOR PLAN
	• A102a	LEVEL 2 NORTH FLOOR PLAN PHASE 2
	• A102b	LEVEL 2 SOUTH FLOOR PLAN PHASE 2
	• A102c	LEVEL 2 NORTH FLOOR PLAN PHASE 3
	• A102d	LEVEL 2 NORTH FLOOR PLAN PHASE 4
	• A103	LEVEL 3 FLOOR PLAN PHASE 5
	• AF100	FINISH MATERIALS LIST
	• AF101	INTERIOR FINISH SCHEDULE

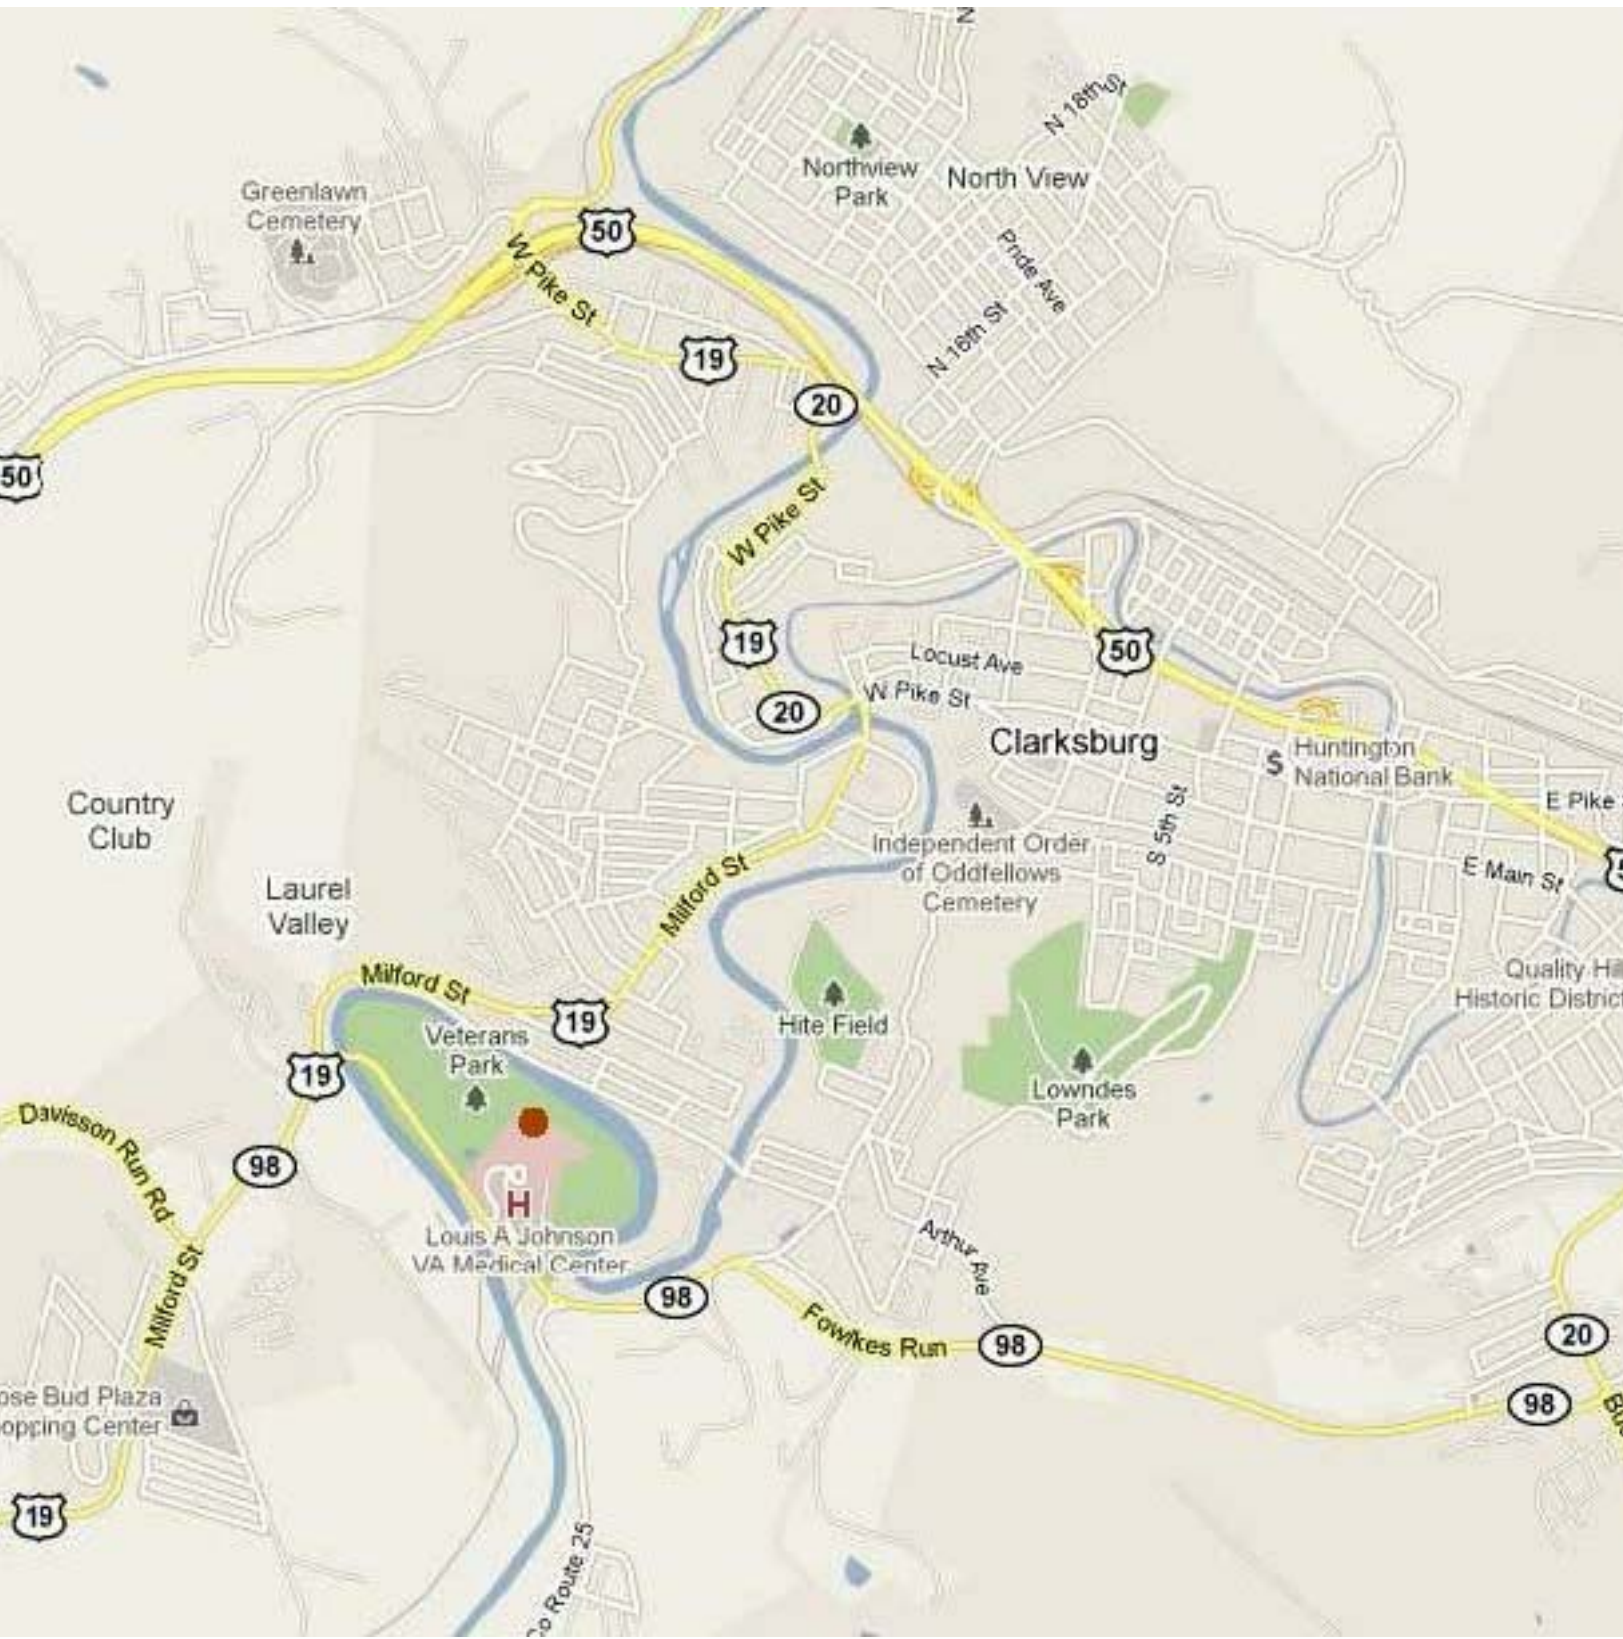

CAMPUS LOCATION PLAN

100% CONSTRUCTION DOCUMENT SUBMISSION

		CONSULTANTS:		ARCHITECT/ENGINEERS:		Drawing Title		Project Title		VA Project Number 540-11-102 IKM Project Number 11-186		Office of Construction and Facilities Management	
						Cover		Interior Finishes Building One		Building Number			
						Approved: Project Director		Location VAMC Clarksburg West Virginia		Drawing Number		Department of Veterans Affairs	
Revisions:		Date						Date 31 AUGUST 2012	Checked	Drawn	A0		
											Dwg. of		