


**FRONT ELEVATION DETAIL**  
**NEW CHILLED WATER PUMP**  
SCALE: 1/4" = 1'-0"

2  
ME-2

**LEGEND**

- |      |   |
|------|---|
| BFV  | BUTTERFLY VALVE                           |
| CW   | CHILLED WATER SUPPLY                      |
| CWR  | CHILLED WATER RETURN                      |
| CWTT | CONDENSER WATER TO COOLING TOWER          |
| CWFT | CONDENSER WATER FROM COOLING TOWER        |
| D    | DRAIN LINE                                |
| LPS  | LOW PRESSURE STEAM                        |
| DCW  | DOMESTIC COLD WATER                       |
| 1    | DEMOLITION SHEET NOTE NO. 1               |
| 2    | NEW WORK SHEET NOTE NO. 1                 |
| 3    | INDICATES NEW CONN. TO EXISTING ELEVATION |
| 4    | PRESSURE GAUGE                            |
| 5    | THERMOMETER                               |
| 6    | INDICATES DIRECTION OF FLOW               |
| 7    | INDICATES DIRECTION OF PITCH              |
| 8    | GATE VALVE                                |
| 9    | SOLENOID VALVE                            |
| 10   | AUTOMATIC STEAM VALVE                     |
| 11   | UNION                                     |
| 12   | STRAINER                                  |
| 13   | FLEX CONDUIT                              |
| 14   | MOTOR CONTROL CENTER NO. 1                |
| 15   | FLOW MEASURING DEVICE                     |
| 16   | WEATHER PROOF                             |
| WP   |   |

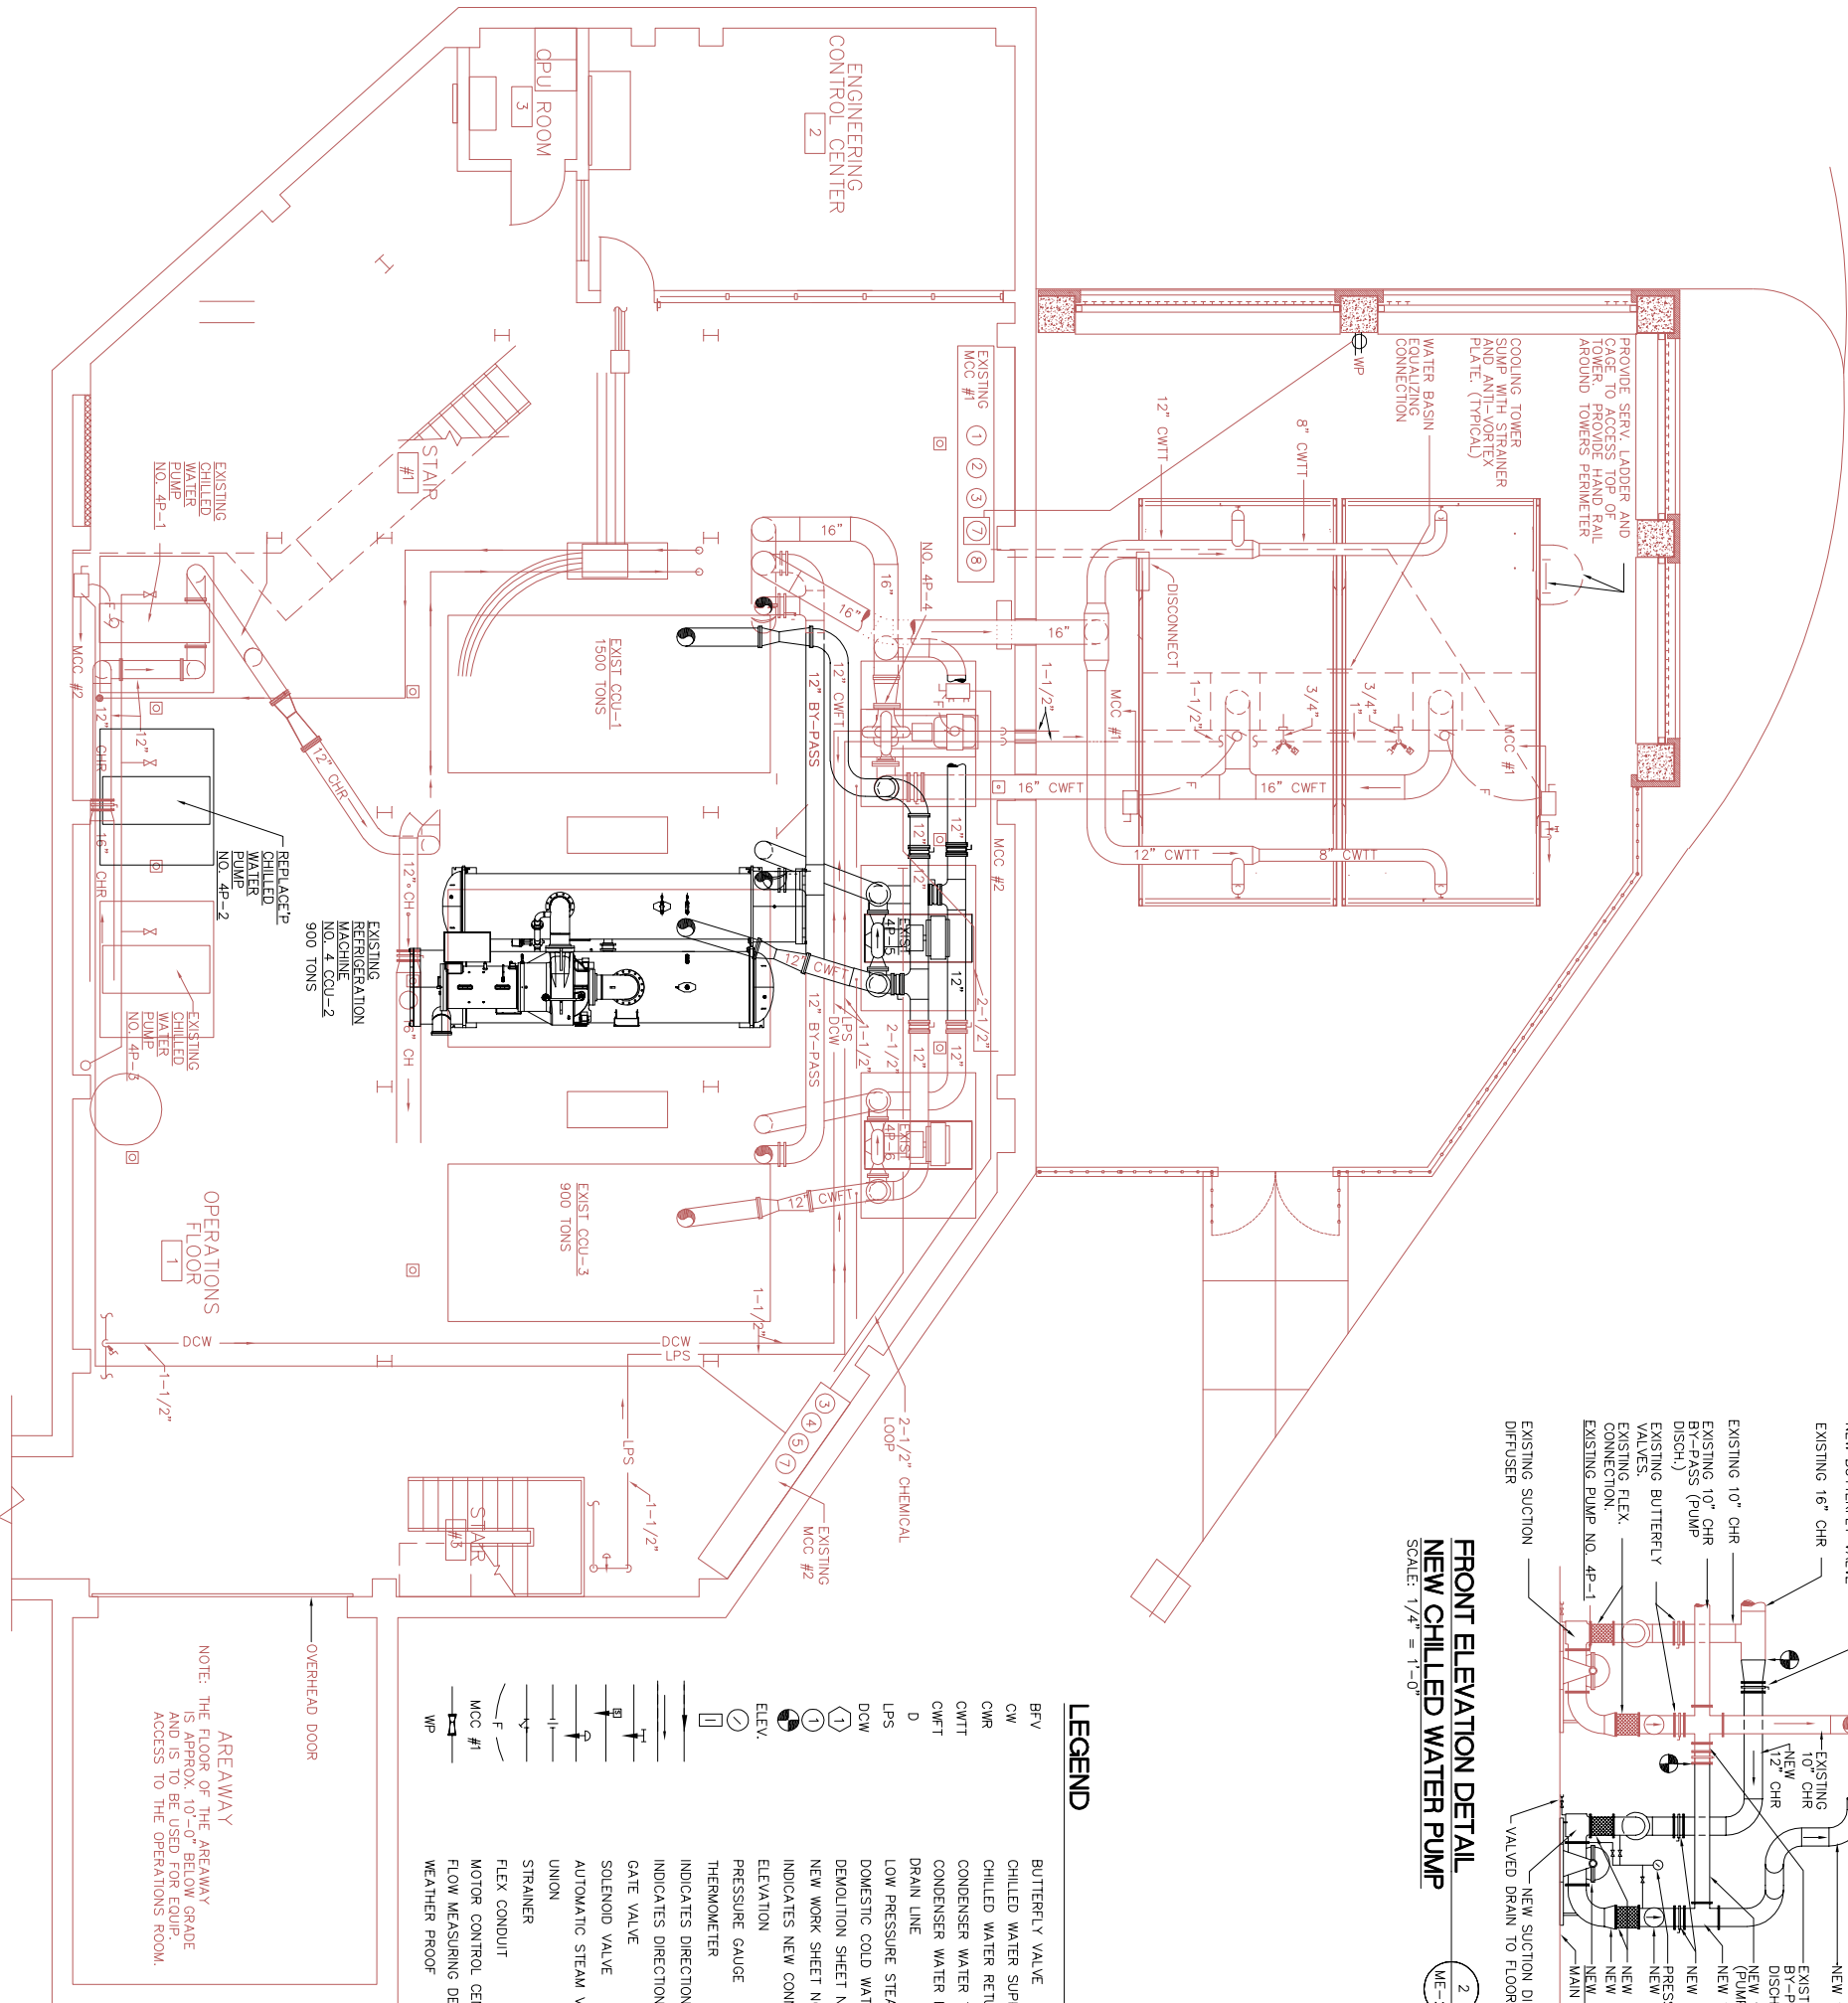

**BUILDING 4 - FLOOR PLAN - NEW WORK**  
SCALE: 1/4" = 1'-0"

