




1
1-PT
TYPE 'C' FLOOR DRAIN DETAIL
NTS

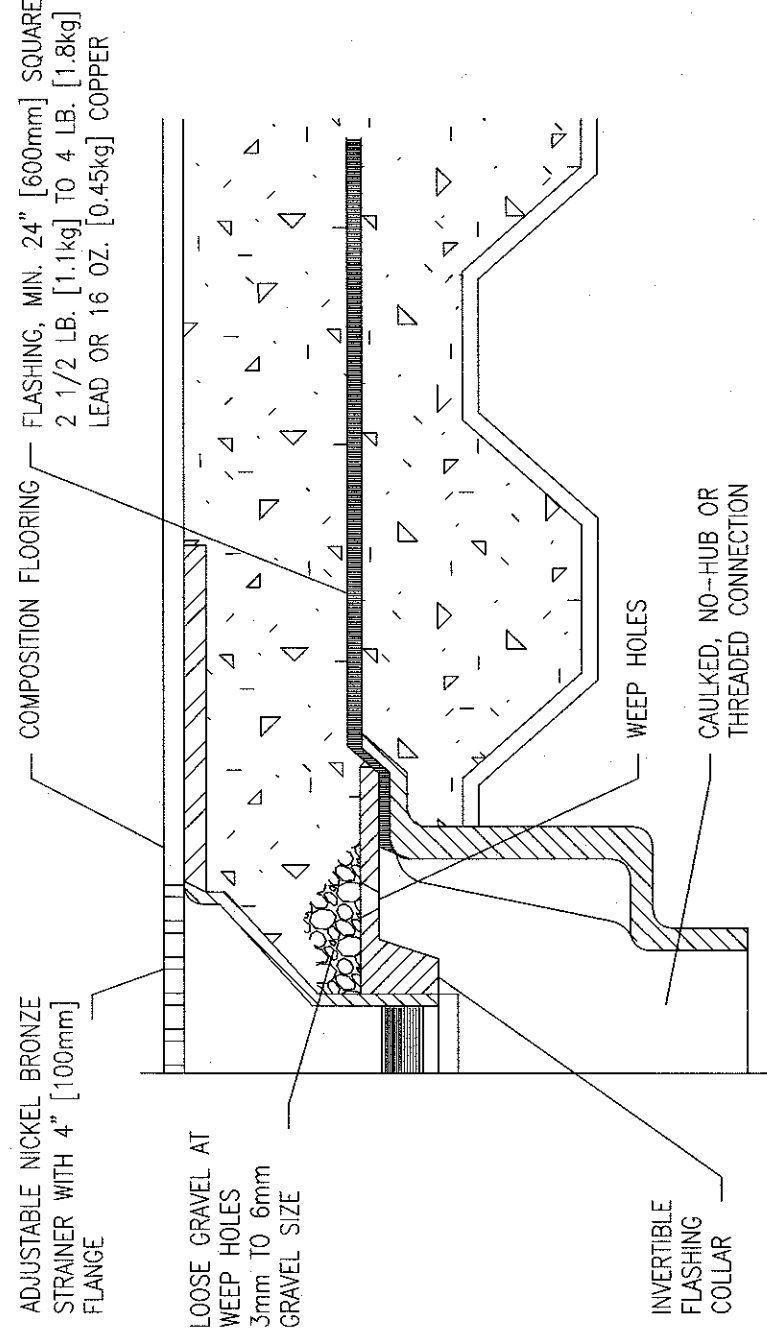


2
1-PT
TYPE 'D' FLOOR DRAIN DETAIL
NTS

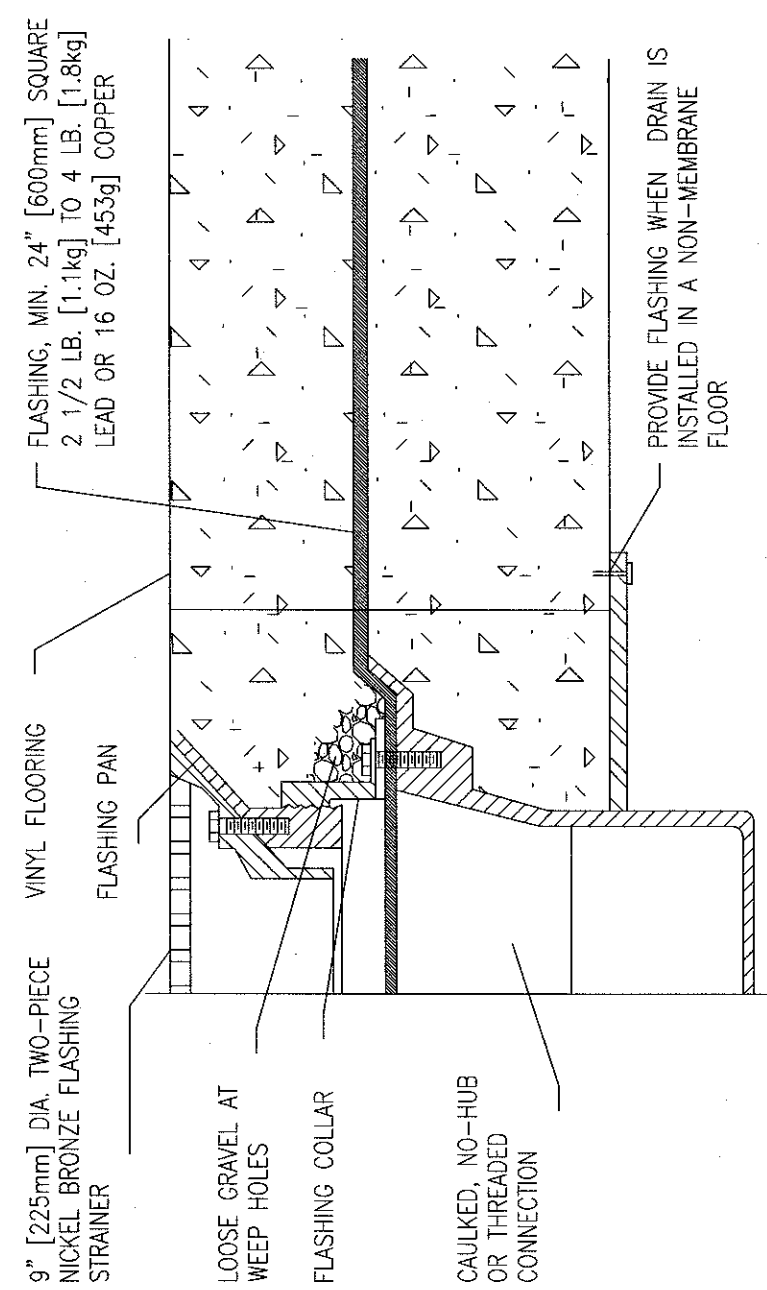


3
1-PT
TYPE 'F' FLOOR DRAIN DETAIL
NTS

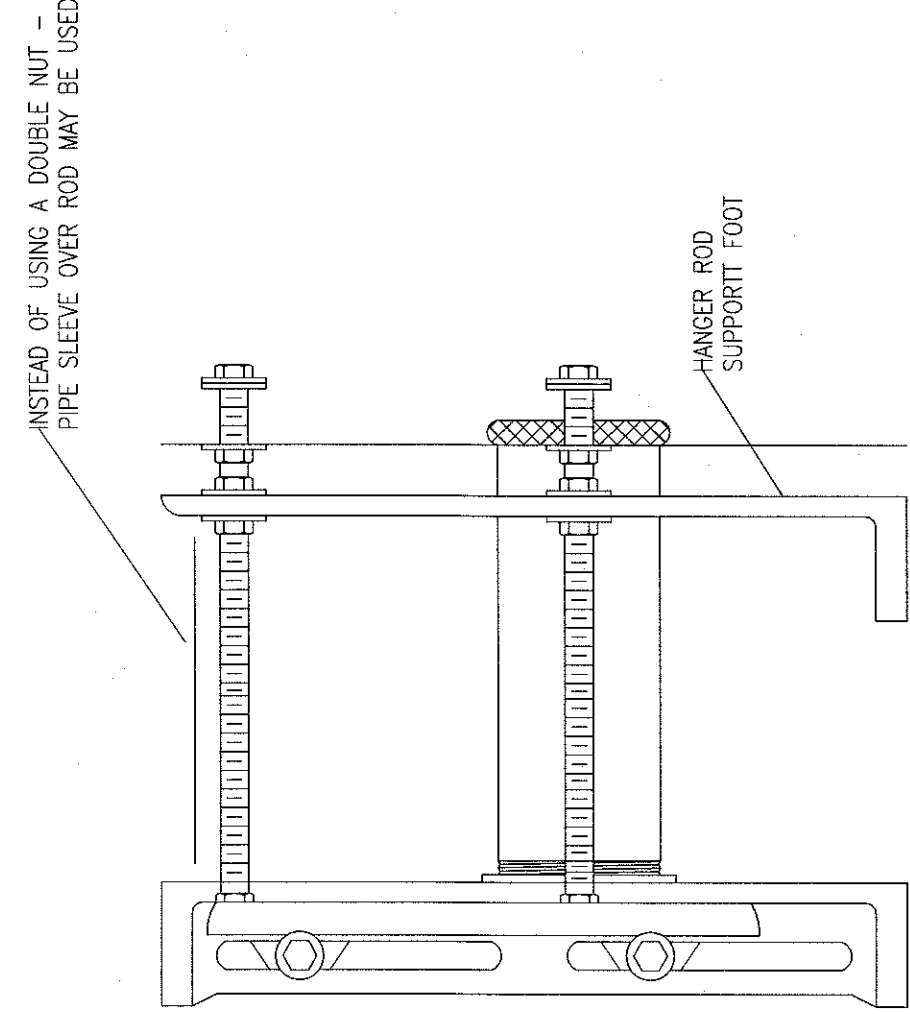


4
1-PT
INSTALLATION OF HANGER
SUPPORT FOOT
NTS

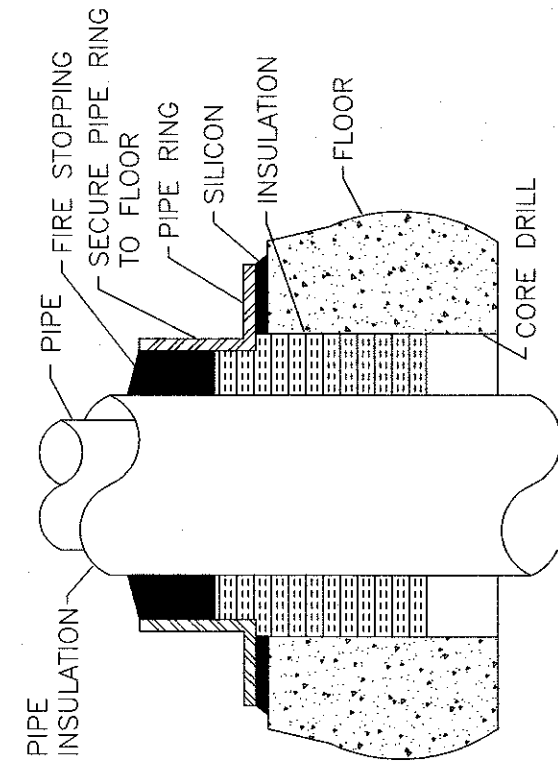



5
1-PT
FLOOR PIPE SLEEVE DETAIL
NTS

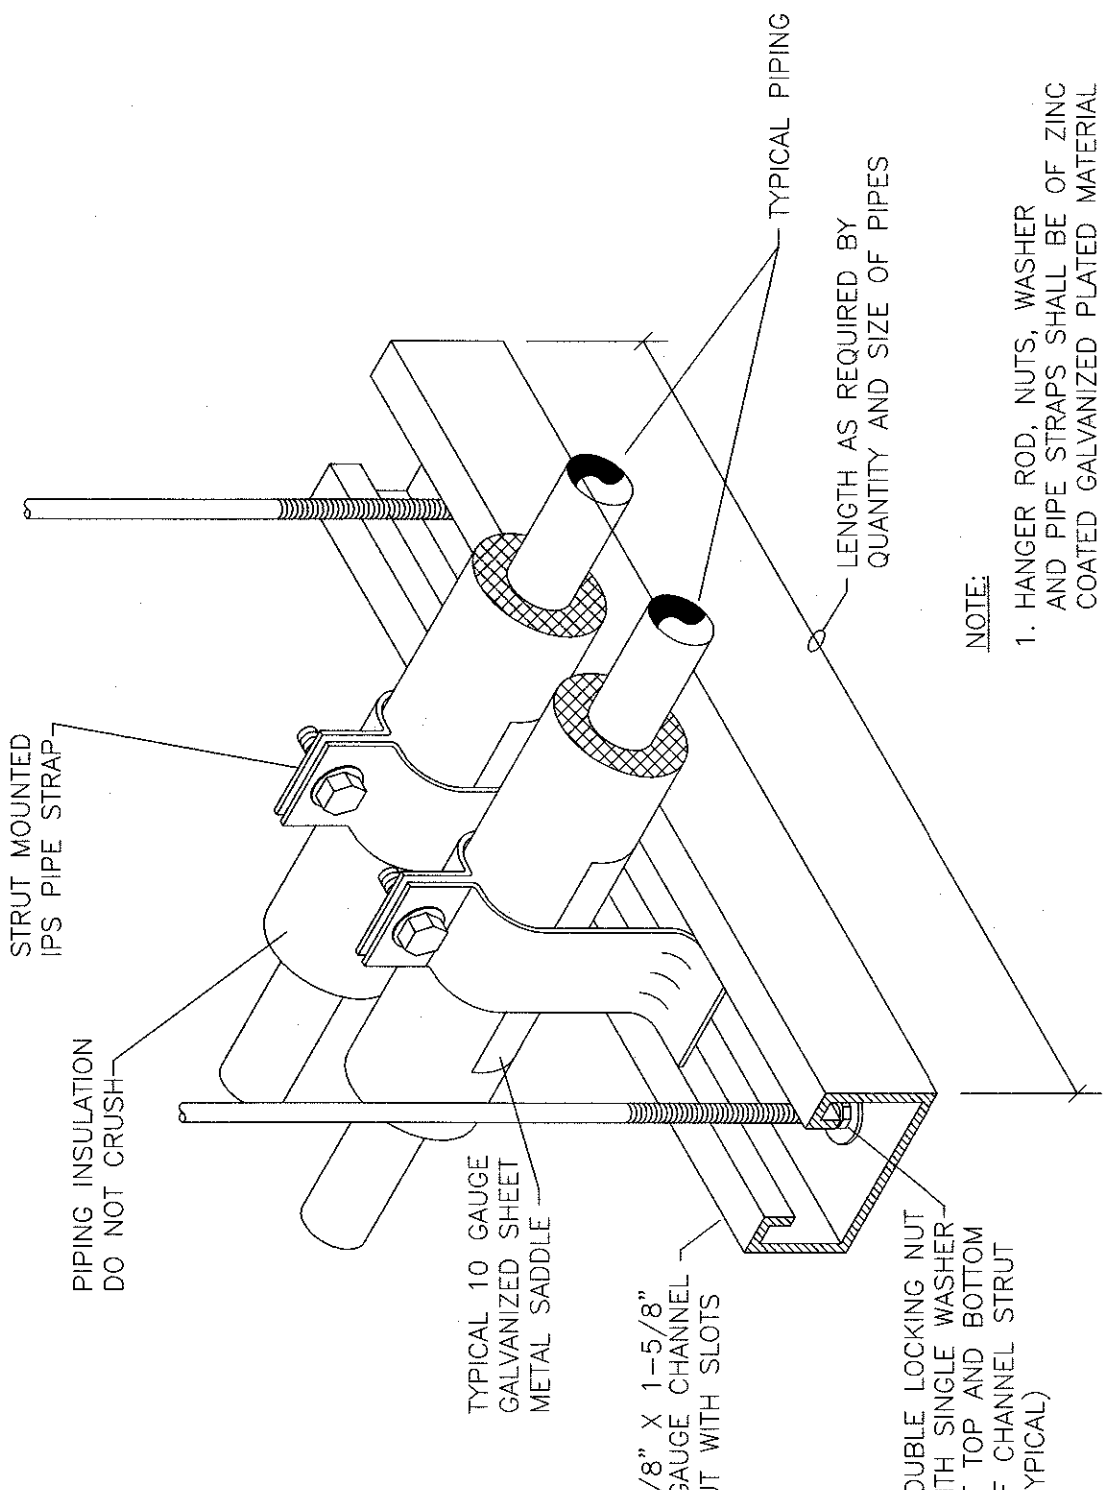

6
1-PT
TRAPEZE INSULATED PIPE HANGER DETAIL
NTS

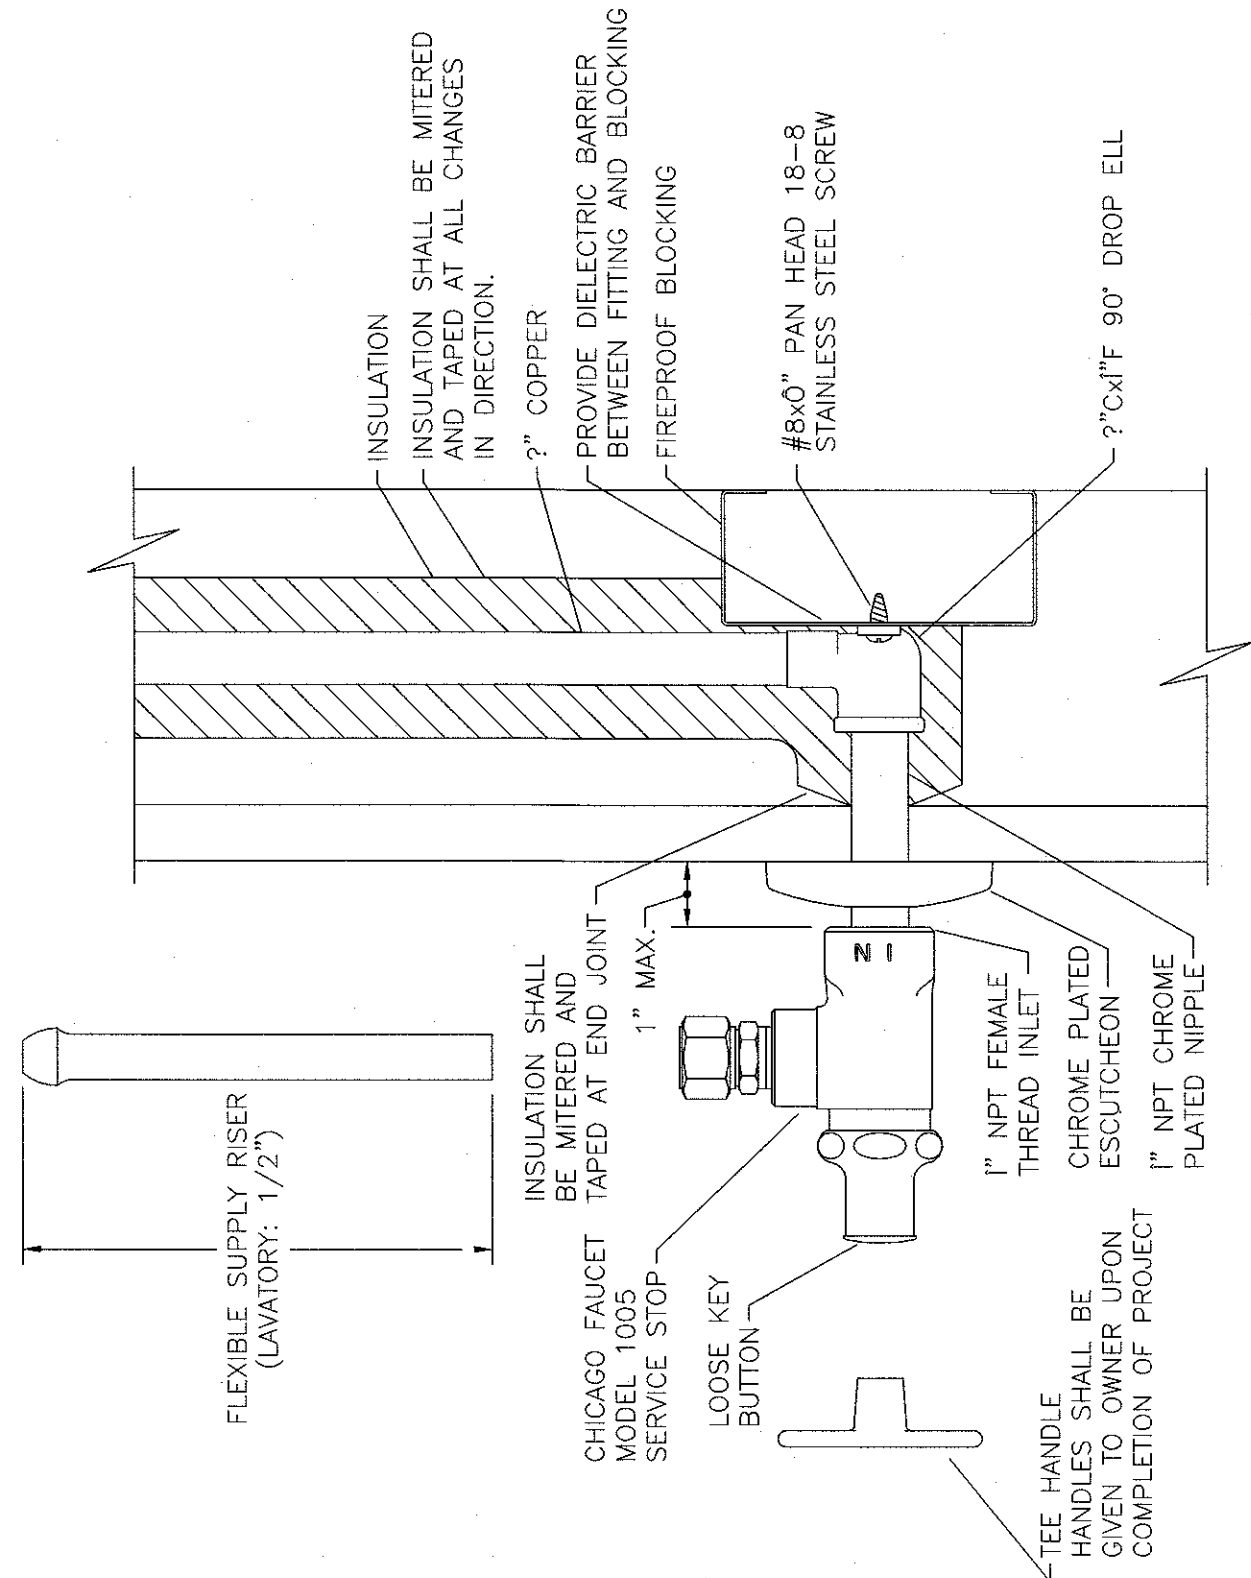

7
1-PT
SERVICE STOP DETAIL
NTS

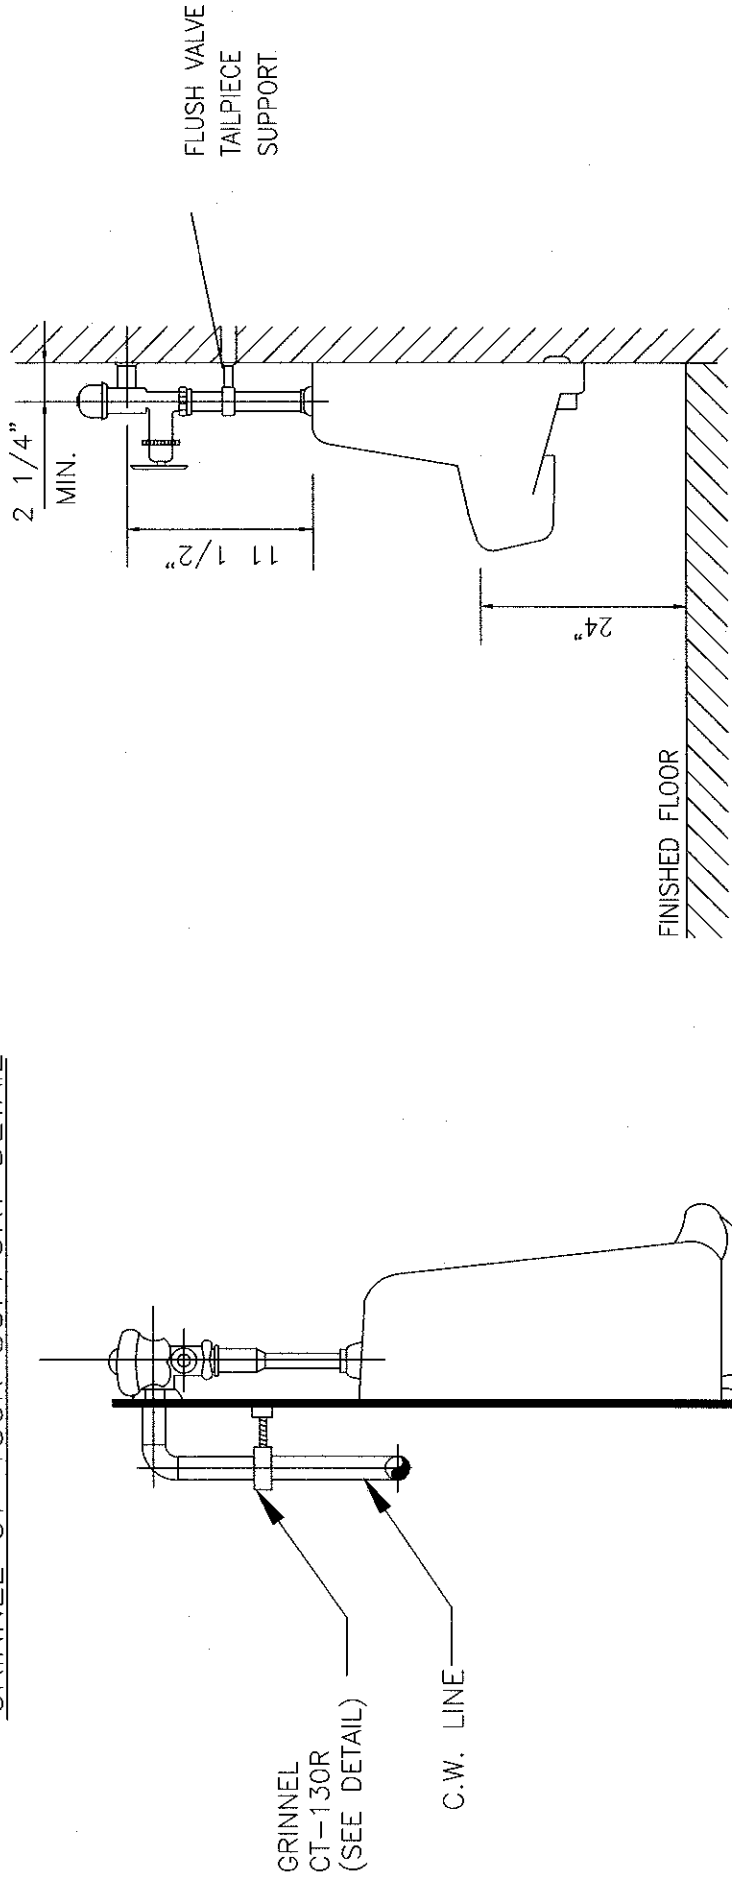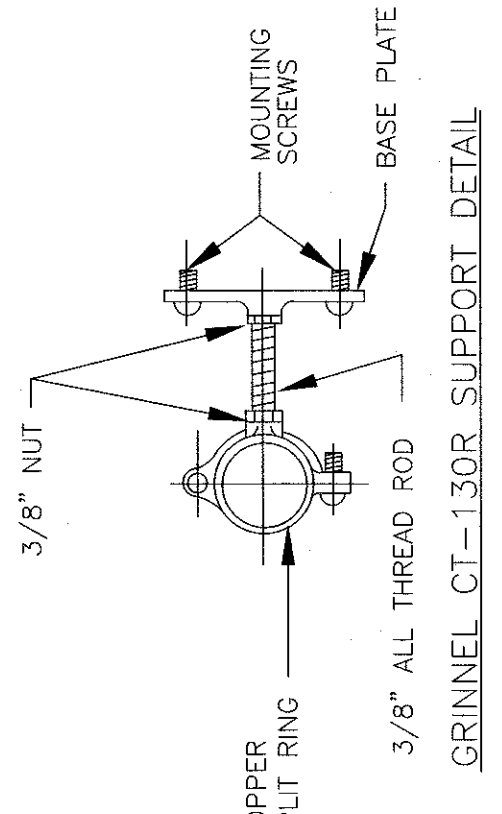

8
1-PT
URINAL INSTALLATION DETAIL
NTS

FULLY SPRINKLERED BUILDING
BID DOCUMENTS

Office of
Construction
and Facilities
Management
Department of
Veterans Affairs

Project Number:
636A8-11-011

Building Number:
1

Drawing Number:
P-7

Drawing Title:
PLUMBING DETAILS 2


Approved Project Director

Location: IOWA CITY VAMC
601 HENRY 6 WEST, IOWA CITY, IOWA 52246-2248

Date: 07-19-12


Checked: KLP

Drawn: JEM

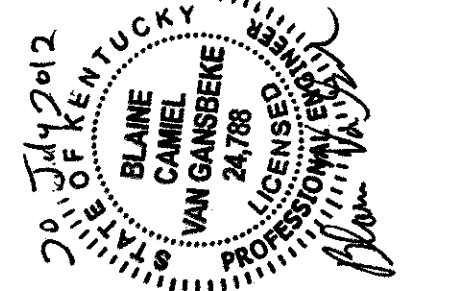

ARCHITECT/ENGINEERS:

PARADYGM
ENGINEERS AND CONSTRUCTORS
PO BOX 438223 Louisville, Kentucky 40253 - PH: 502.339.8511 - www.paradygmusa.com

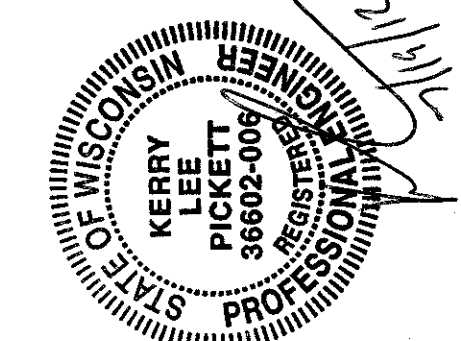

CONSULTANTS: