


4.2 SUPPLY FAN SHALL RESTART AND SMOKE DAMPERS SHALL OPEN WHEN FIRE ALARM CIRCUIT IS RESET.

### POINTS LIST FOR VAV AIR HANDLING UNIT WITH MINIMUM OUTSIDE AIR

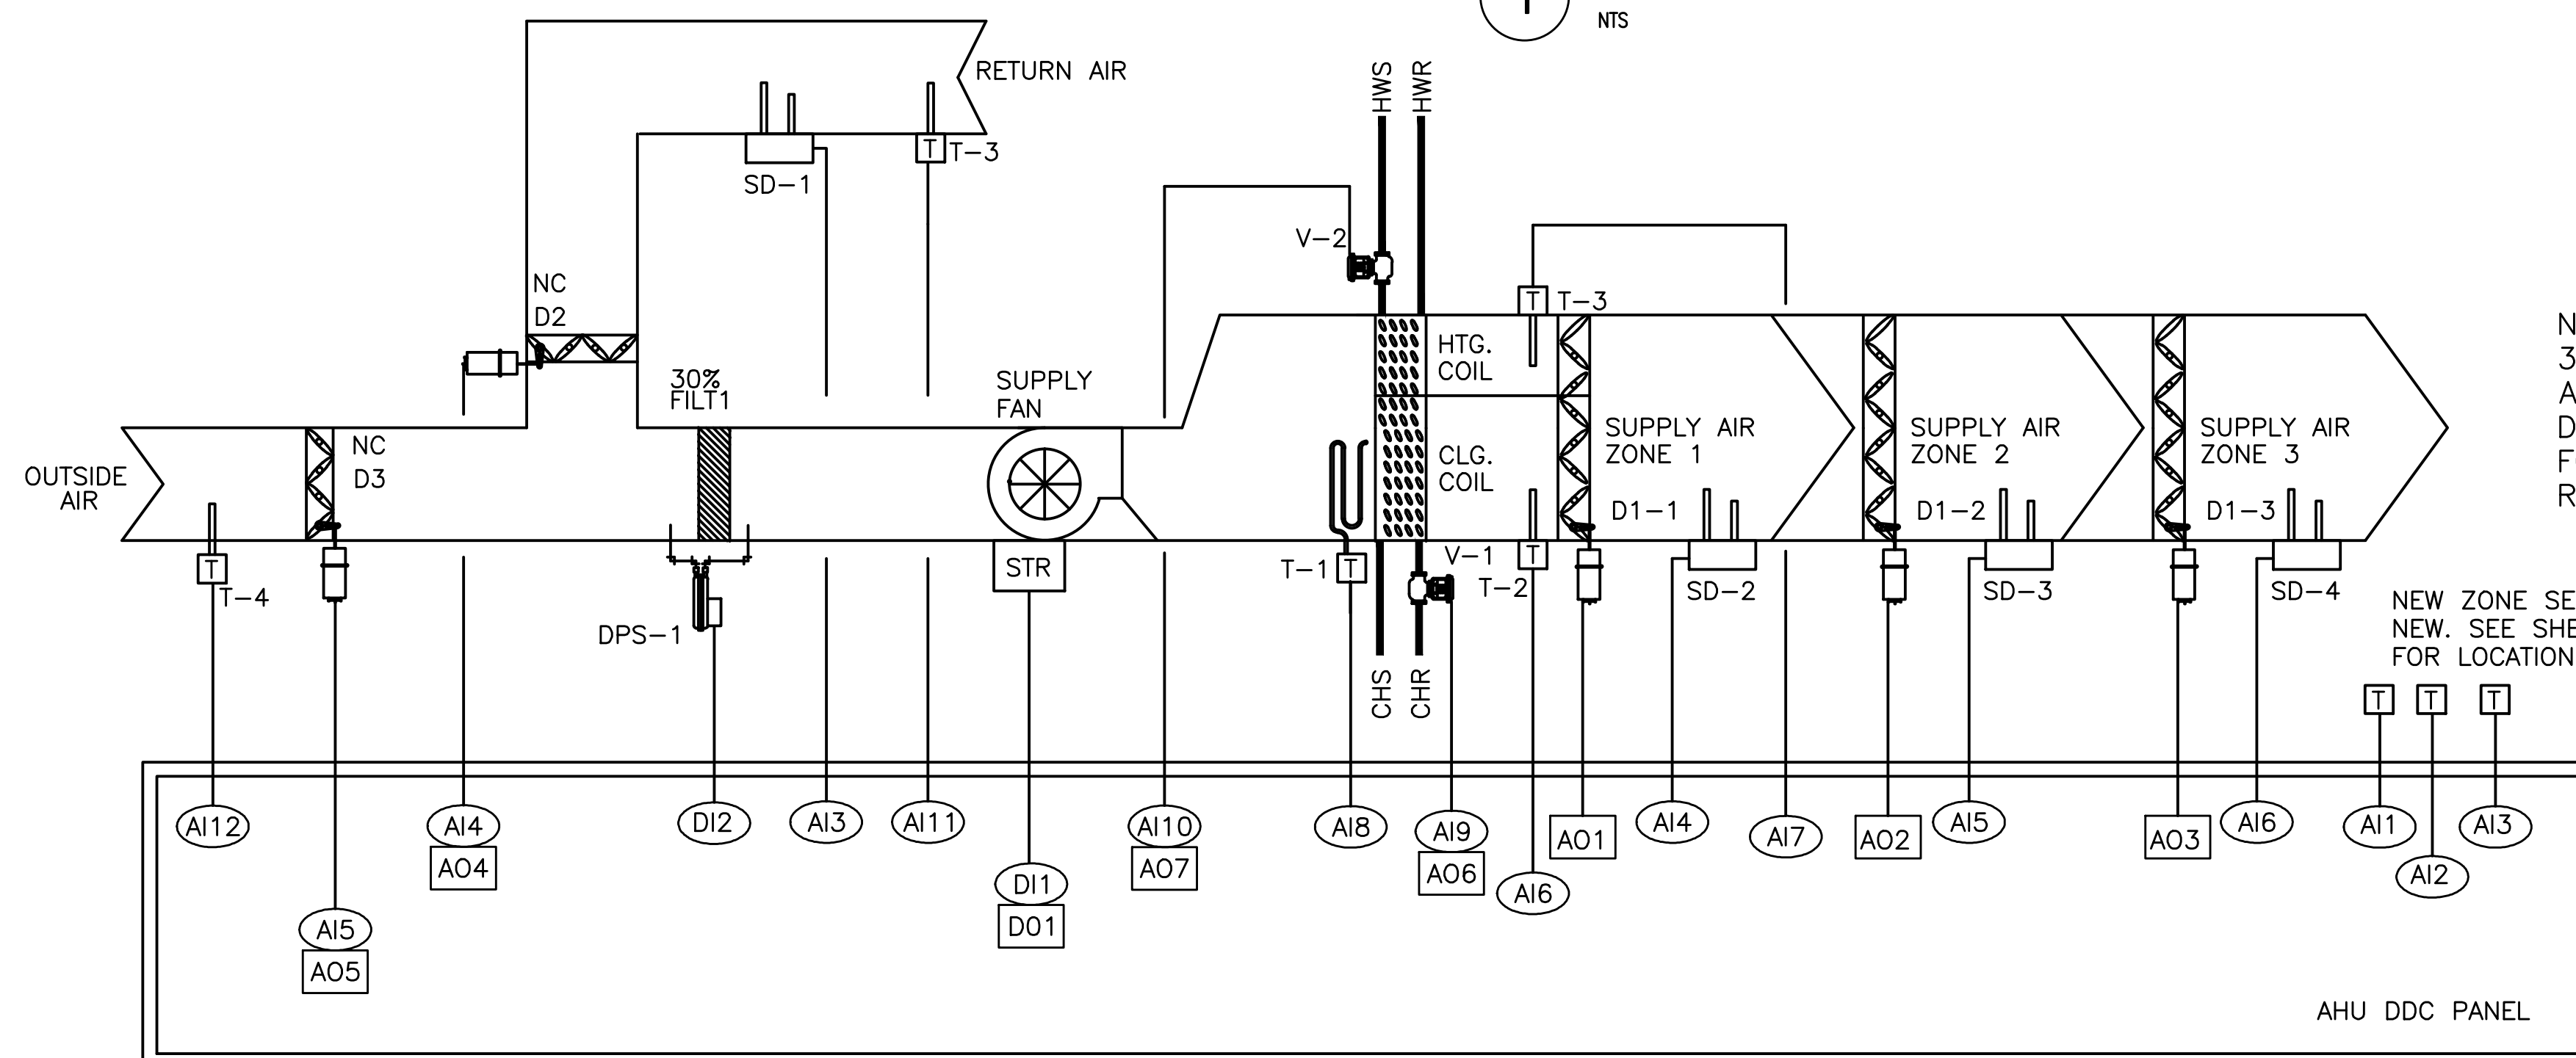

NOTE:  
3 ZONES SHOWN.  
ADJUST QUANTITIES FOR  
DAMPERS, THERMOSTATS, ETC.  
FOR NUMBER OF ZONES AS  
REQUIRED.

NEW ZONE SENSORS  
NEW. SEE SHEET M101  
FOR LOCATIONS.

## 2 MULTIZONE AIR HANDLING UNIT CONTROL DIAGRAM

Revisions			  		Approved: _____ Title _____ Signature _____		Drawing Title <b>MECHANICAL – CONTROLS</b>		Project Title Southeast VA Health Care System (SLVHCS) A&E Design Urgent Care		Date January 18, 2013			Department of Veterans Affairs
No.	Date	Remarks					Project No. VA256-C-0231		Drawing No. M501		Page 1 of 1			