


1 BLDG 05 - PARTIAL BASEMENT FLOOR PLAN
SCALE: 3/16"=1'-0"

- LEGEND:**
- EXISTING CONSTRUCTION
 - NEW CONSTRUCTION
 - TELEPHONE LINE
 - INTRANET COMM. LINE
 - CAT-5 ETHERNET LINE

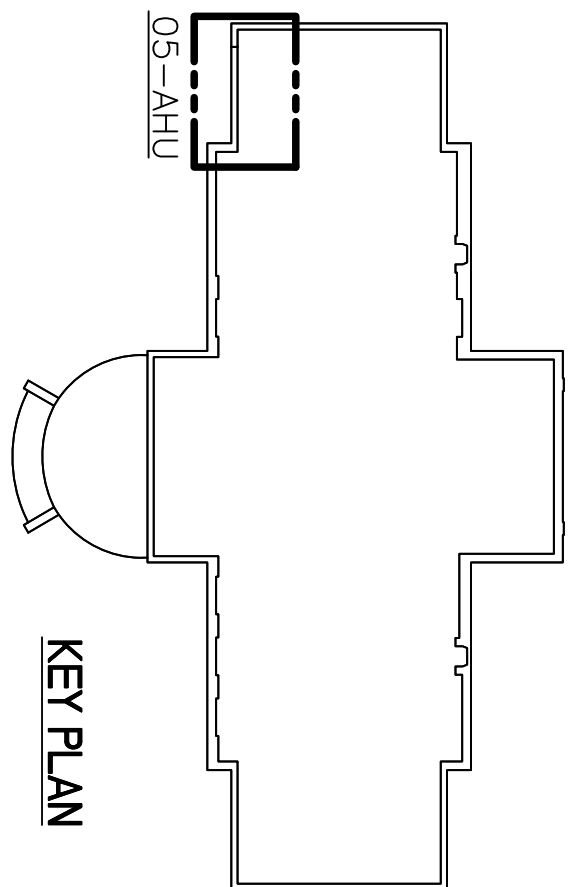

Revisions	Date

A/E SEAL

A/E ADDRESS

CHU and GASSMAN, INC.
1828 WALNUT ST., SUITE 625, PHILADELPHIA, PA 19102
P: (215) 586-6872 F: (215) 586-4549
T: (215) 586-4550 F: (215) 586-4549

Drawing Title	DISCIPLINE	Project Title	Date
BLDG 05 EQUIPMENT LOCATION PLAN MODIFICATIONS	INSTRUMENTATION	VAMC WEB BASED DIRECT DIGITAL CONTROL SYSTEM	6/7/2012
Approved: Chief Engineering Service	Drawn	Building Number	Project No.
Michael Corcoran	T. CHU	05	542-07-109
Approved: Medical Center Director	Checked	Location	DRAWING No.
Gary W. Dvorsky	W. KETH	COATESVILLE, PENNSYLVANIA	05M101
			Dwg 7 of 17