



1
M101

BLDG 138 - PARTIAL SECOND FLOOR PLAN

SCALE: 3/16" = 1'-0"

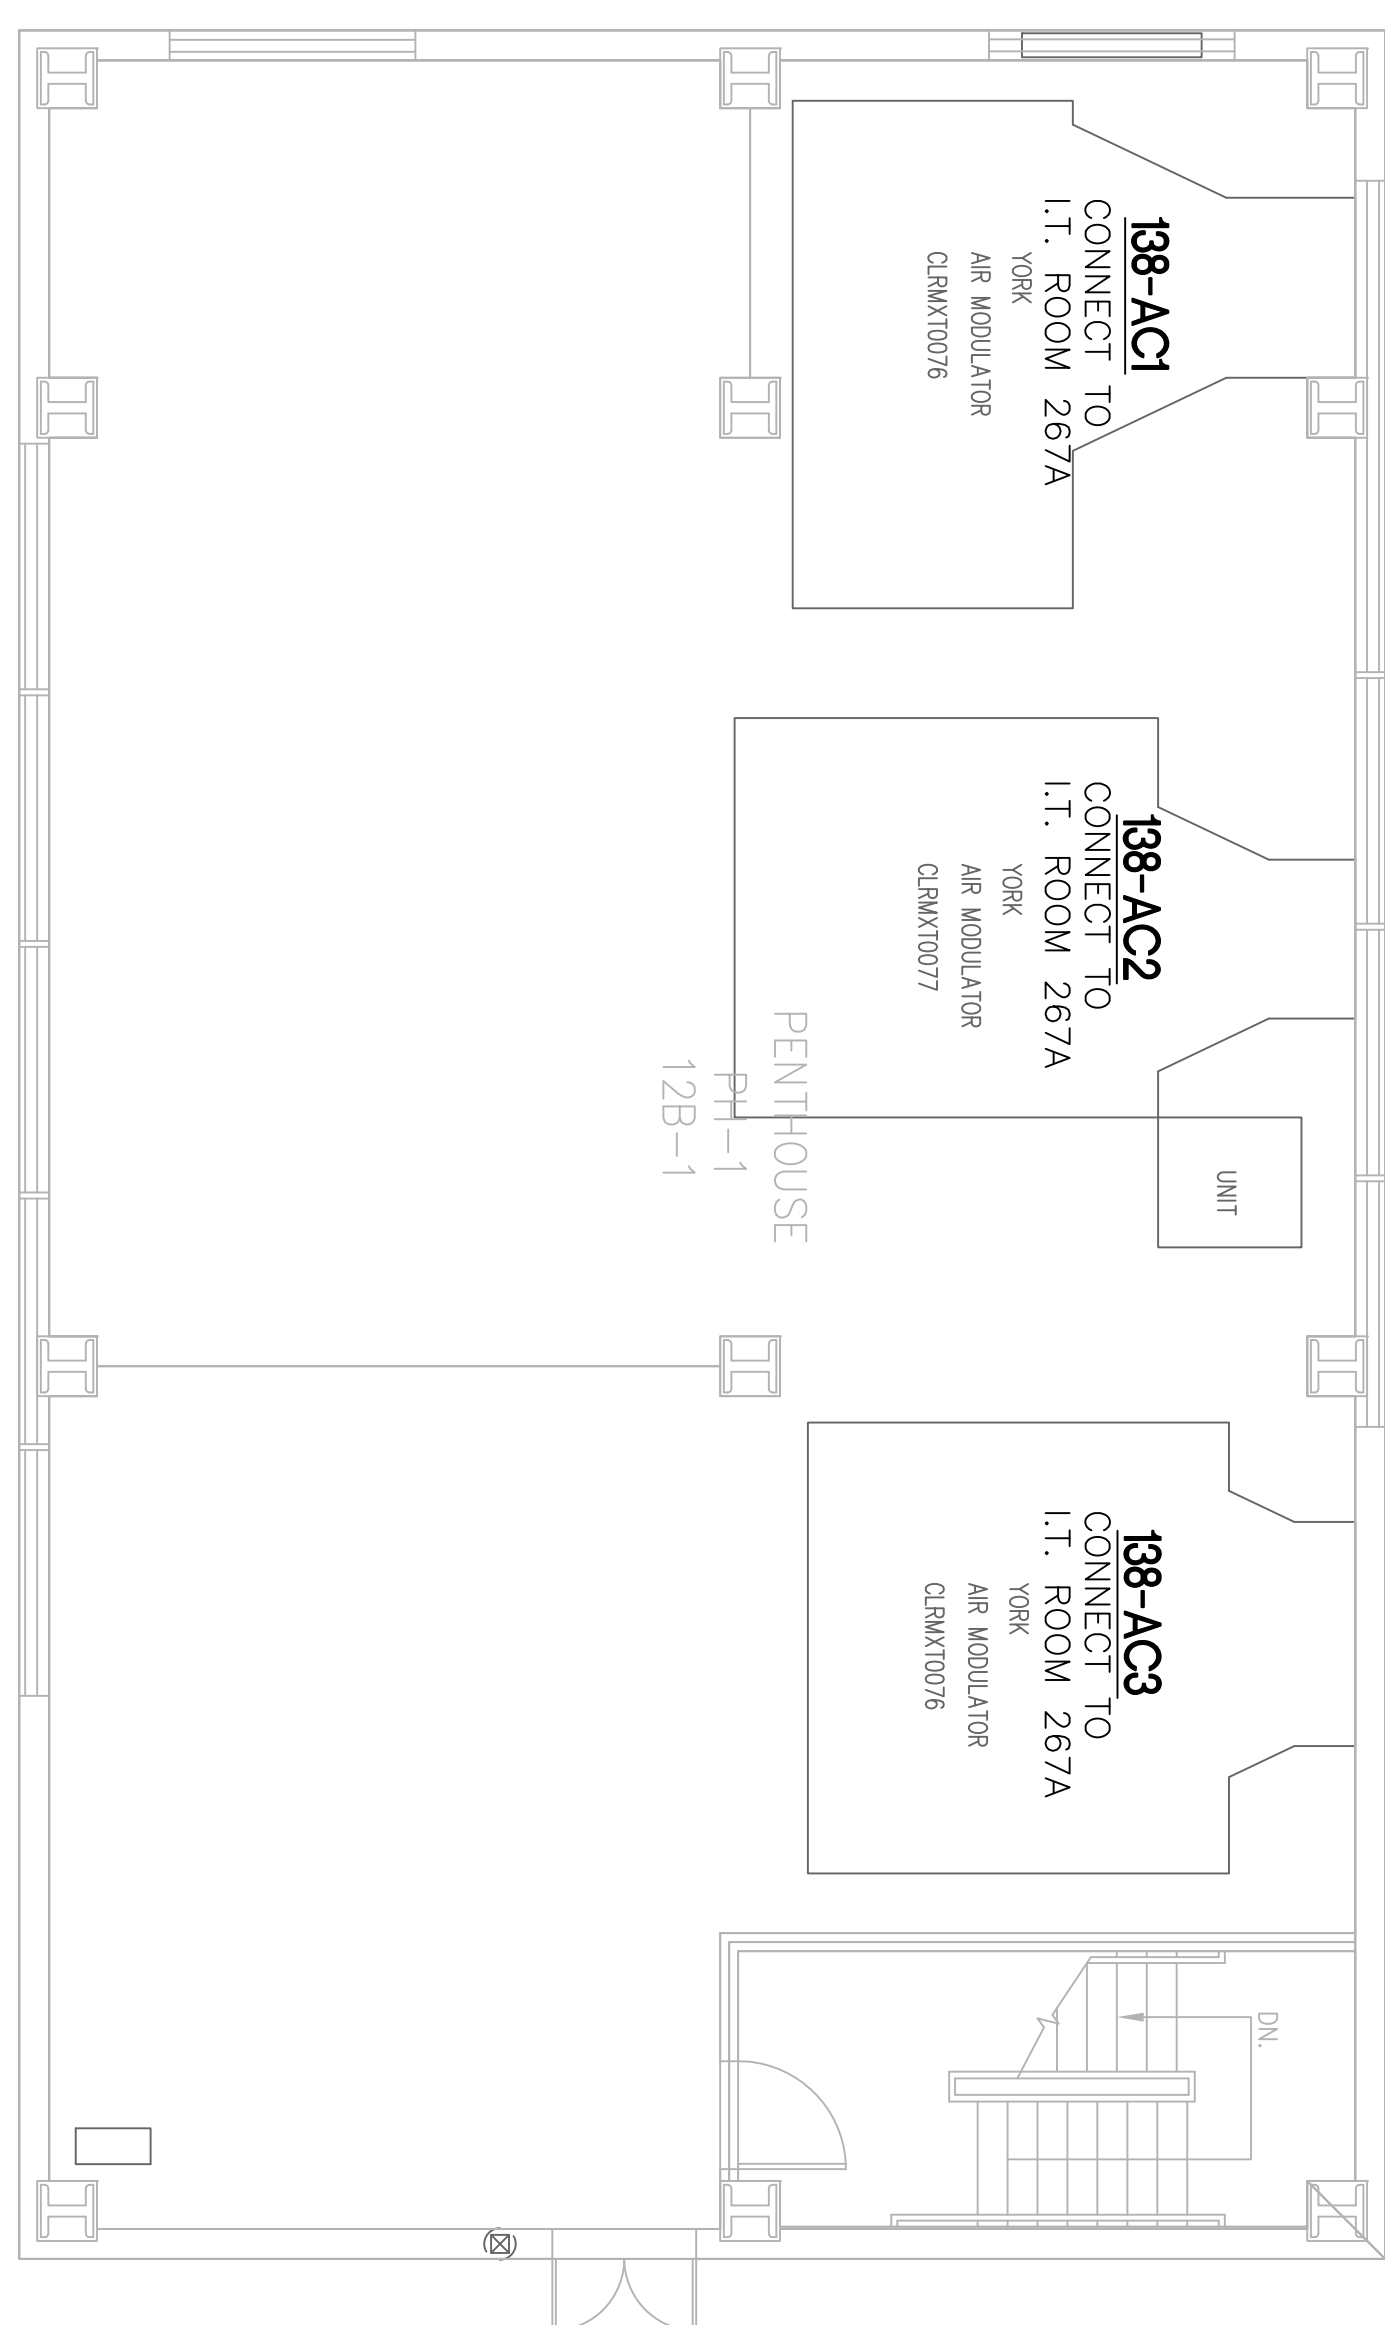

2 BLDG 138 -PARTIAL PENTHOUSE FLOOR PLAN
MM101
SCALE: 3/16" = 1' -0"

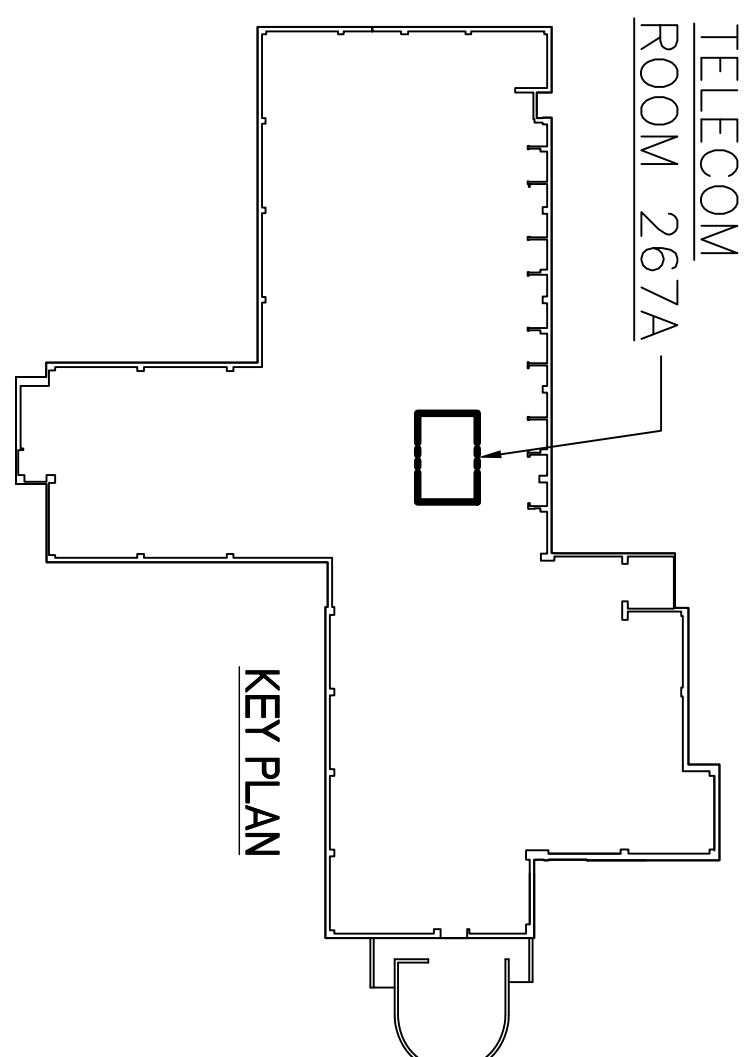[illegible]

LEGENDS:

_____ EXISTING CONSTRUCTION
_____ NEW CONSTRUCTION
_____ TELEPHONE LINE
_____ T _____
_____ IC _____
_____ CAT5 _____
_____ CAT-5 ETHERNET LINE

Drawing Title INSTRUMENTATION BLDG 138 EQUIPMENT LOCATION PLAN MODIFICATIONS		Project Title VAMC WEB BASED DIRECT DIGITAL CONTROL SYSTEM		Date 6/7/2012	
Approved: Chief Engineering Services Michael Ceroncagne		Drawn T. CHU		Project No. 542-07-109	
Approved: Medical Center Director Gary M. Debernardi		Checked W KEITH		DRAWING No. 138/M101	
		Building Number 138		Dwg. 150/17	
		Location COATESVILLE, PENNSYLVANIA		