

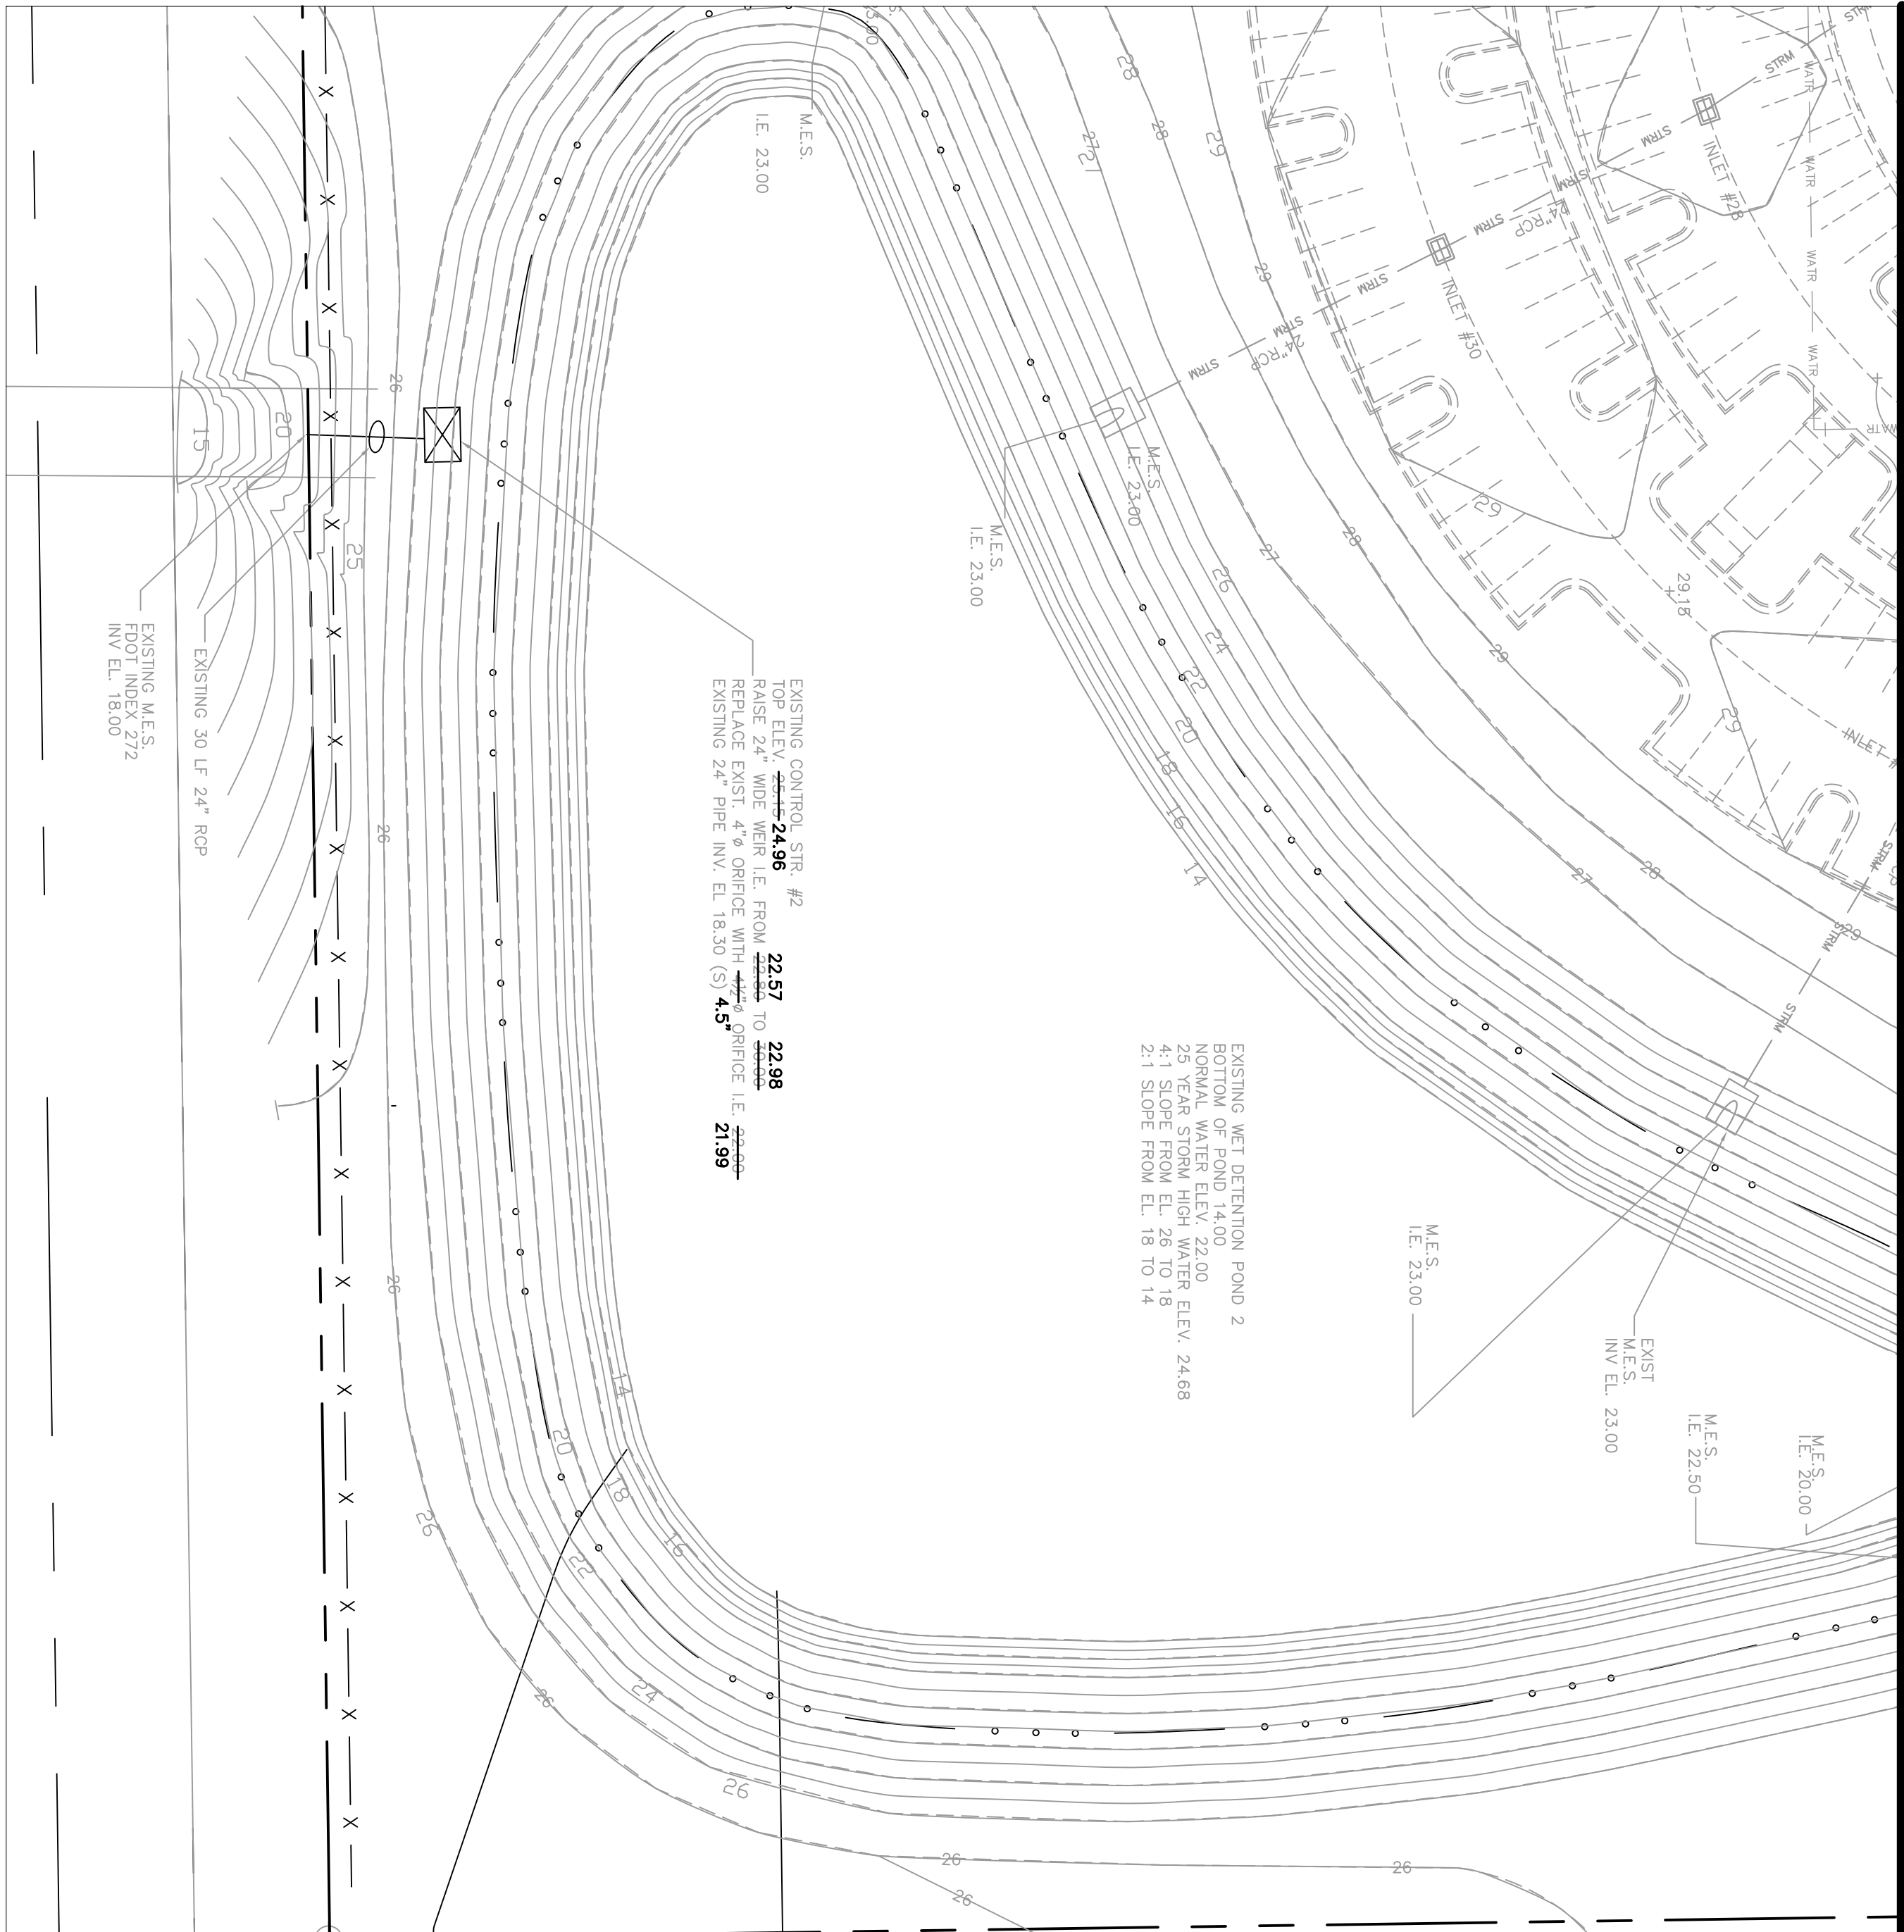


MATCH LINE A-A

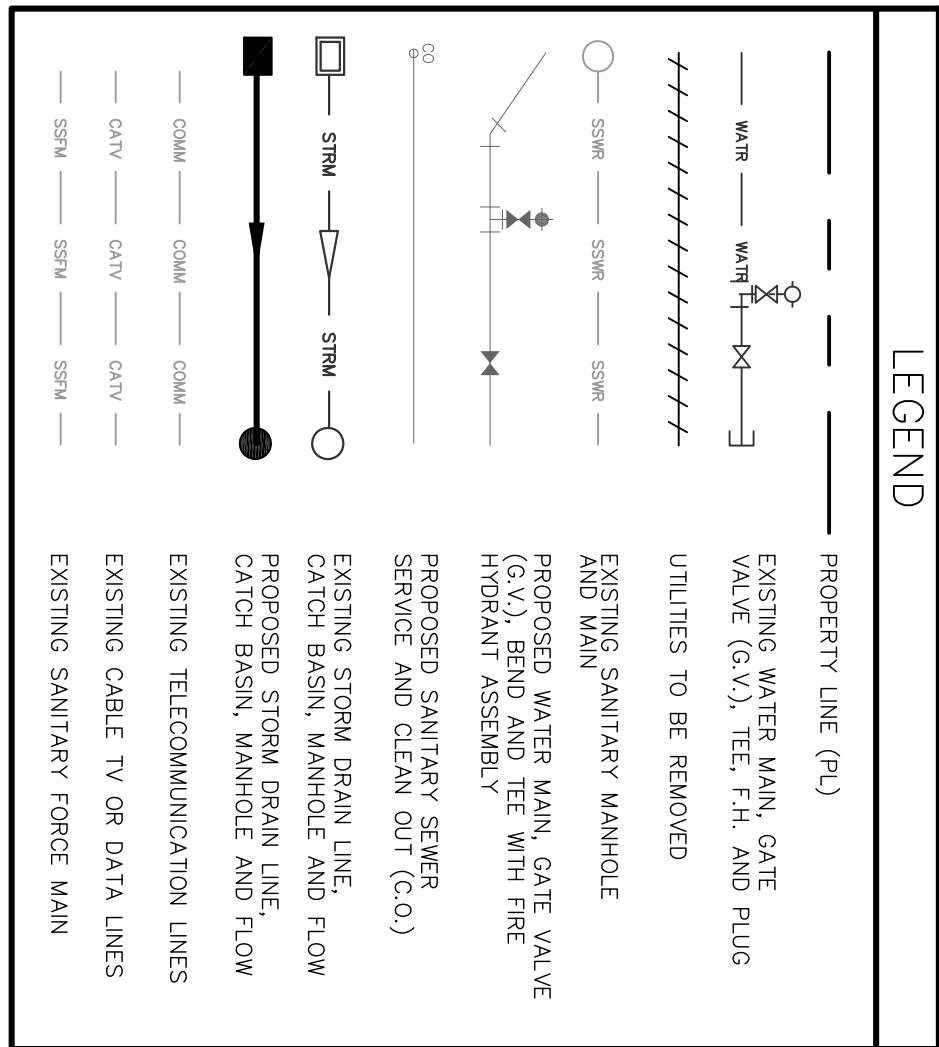

MATCH LINE A-A

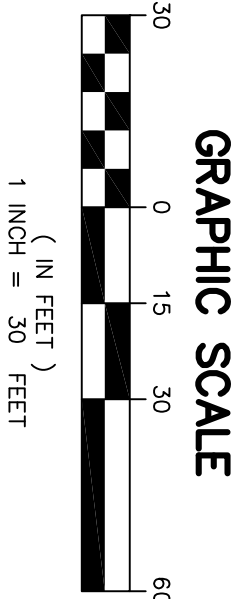

# RECORD DOCUMENTS

## FULLY SPRINKLERED

Project Number 675-08-700		Building Number -		Office of Facilities Management	
Drawing Number CP-101		Date December 16, 2011		Department of Veterans Affairs	
Project Title BREVARD OFC CLINICAL ADDITION		Location Viera, Florida		Approved Project Director	
Drawing Title PAVING, GRADING, AND DRAINAGE PLAN		Project Title BREVARD OFC CLINICAL ADDITION		Approved Project Director	
Design Partners, Inc. Gainesville, FL 32607		Miller Legg Palm Beach Office: 2005 Viera Parkway, Suite 100 West Palm Beach, Florida 33411 Tel: 561.833.4444 Fax: 561.833.4100 www.millerlegg.com		Flood Architects Flood Structural Engineers Affiliated Engineers, Inc. 2500 West Broward Blvd., Suite 200 Gainesville, Florida 32608 Tel: 352.376.5500 Fax: 352.376.3479 Tel: 800-603-1140	
VA FORM 08-6231, OCT 1978		1		2	
3		4		5	
6		7		8	
9		10		11	