




1 SIXTH FLOOR PLAN – PROPOSED
AS403 SCALE: 1/4" = 1'-0"

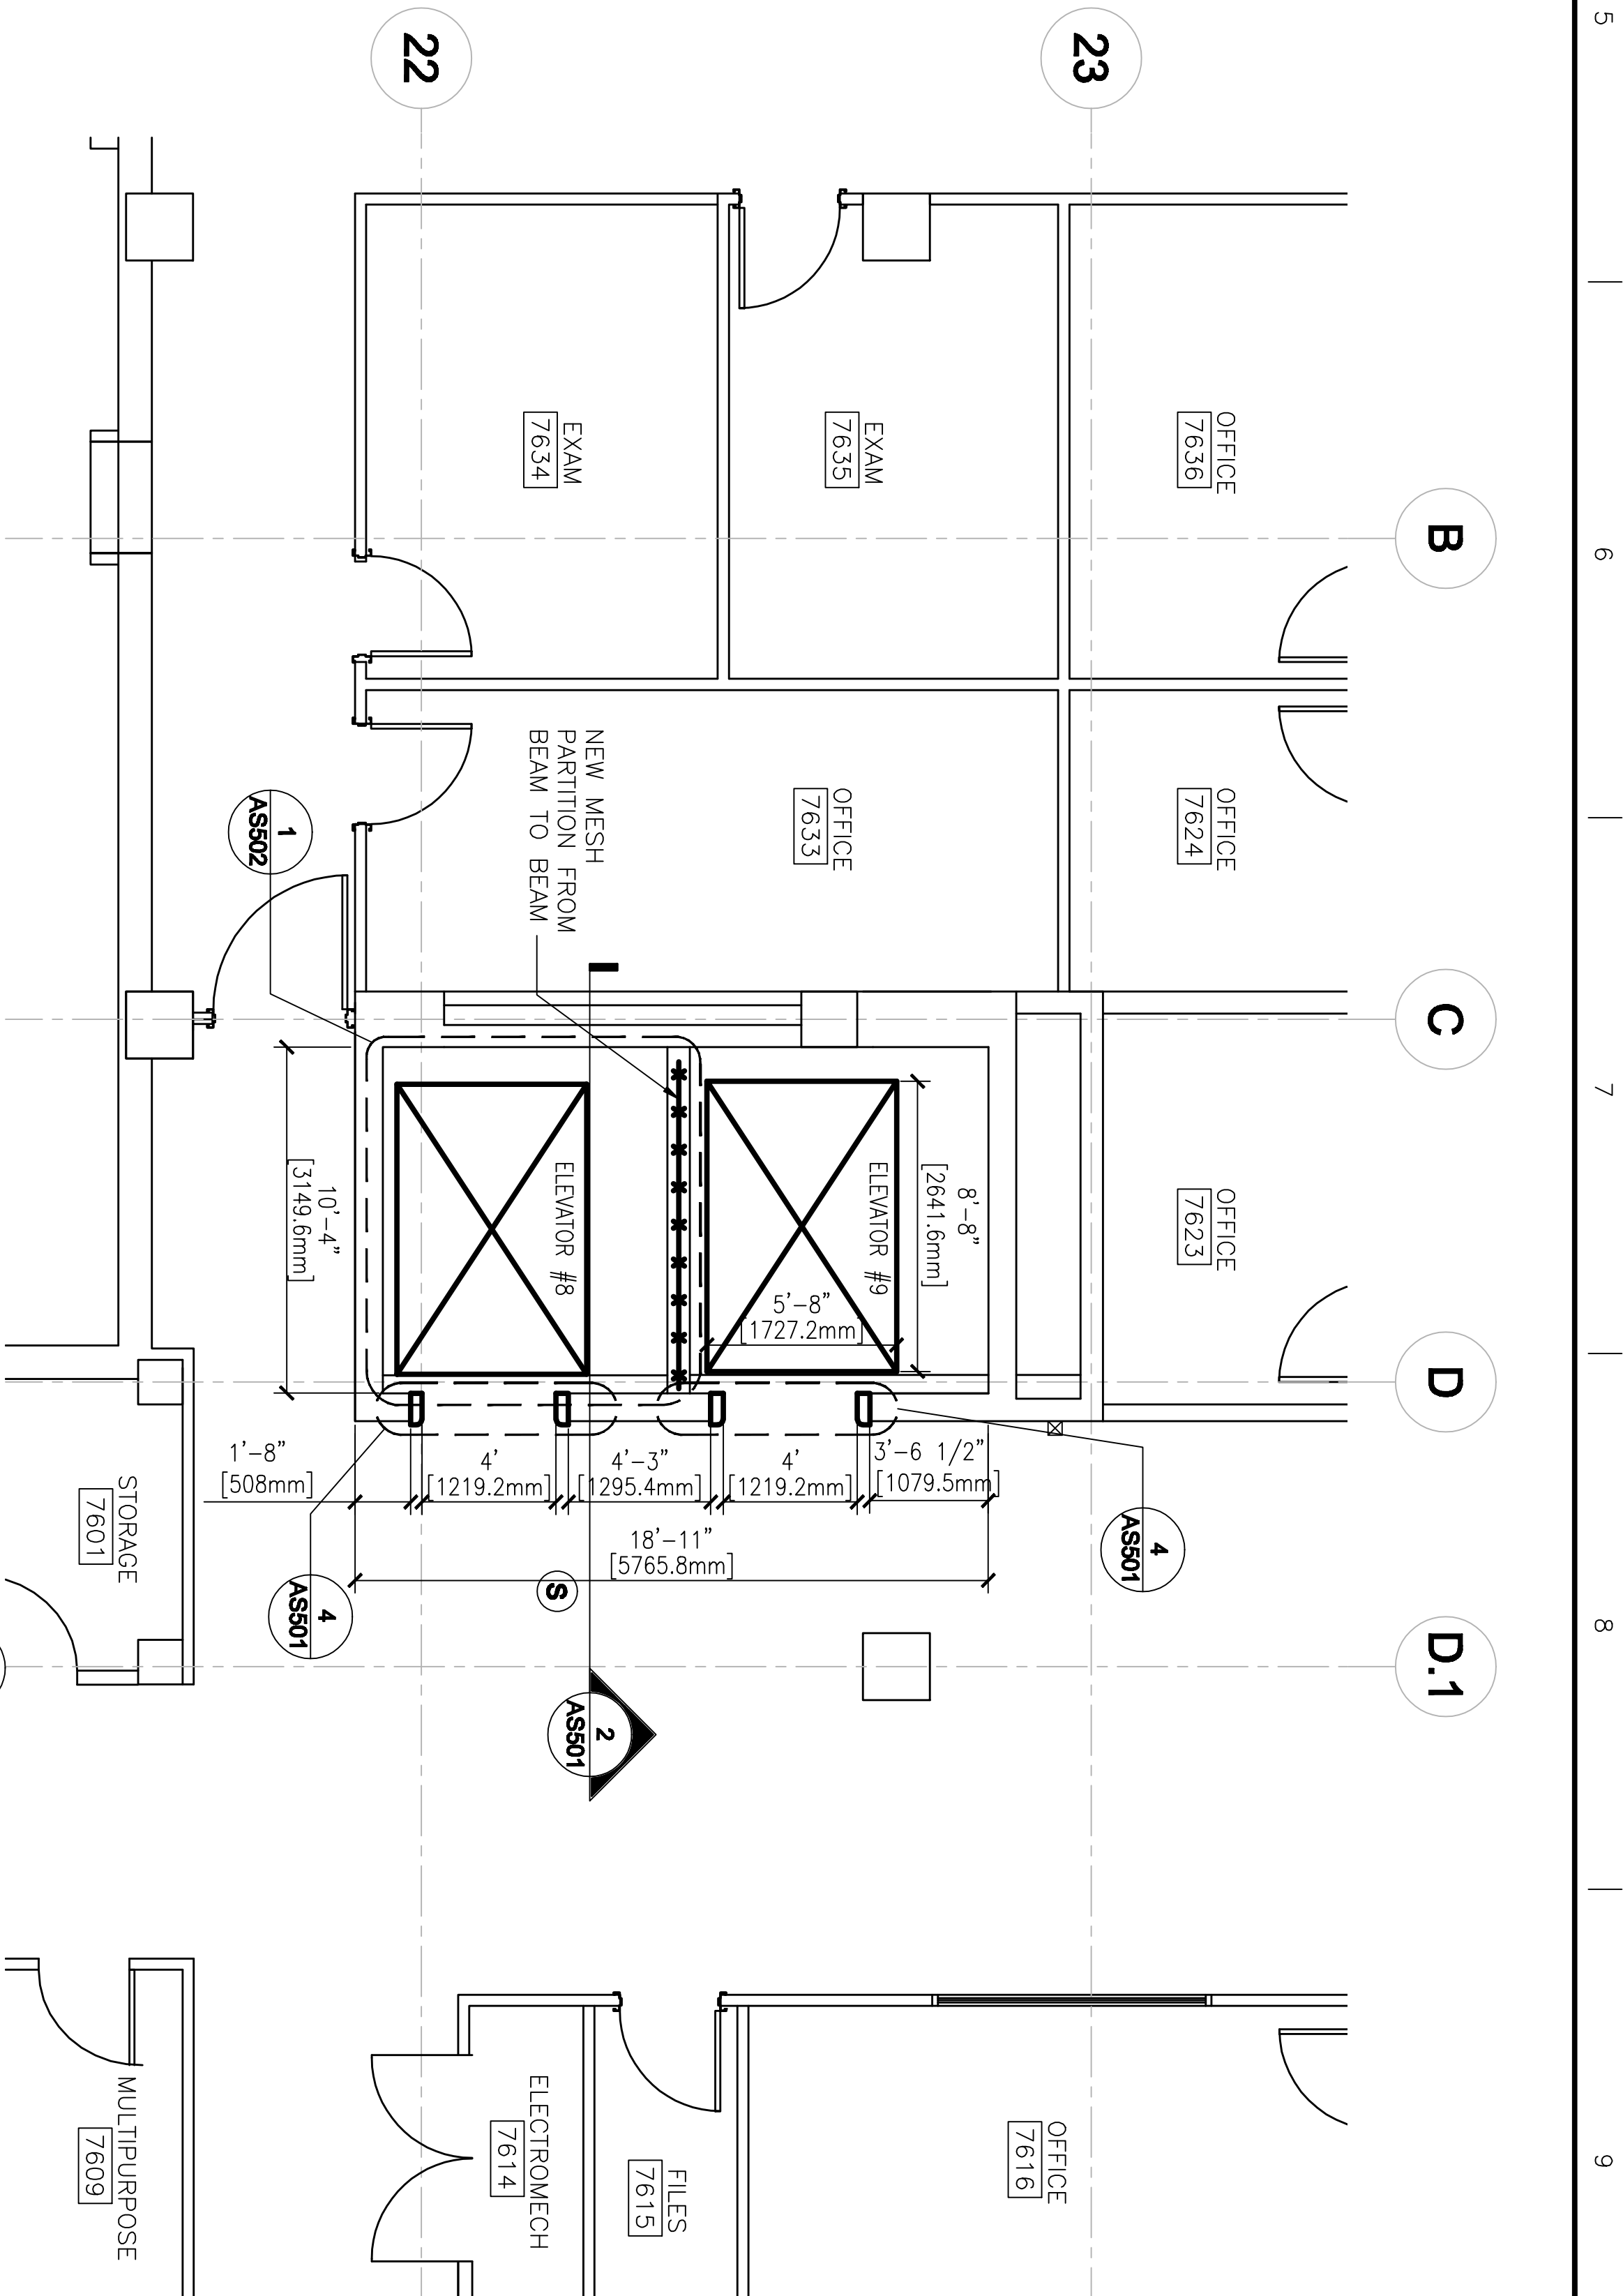

2 SEVENTH FLOOR PLAN – PROPOSED
AS403 SCALE: 1/4" = 1'-0"

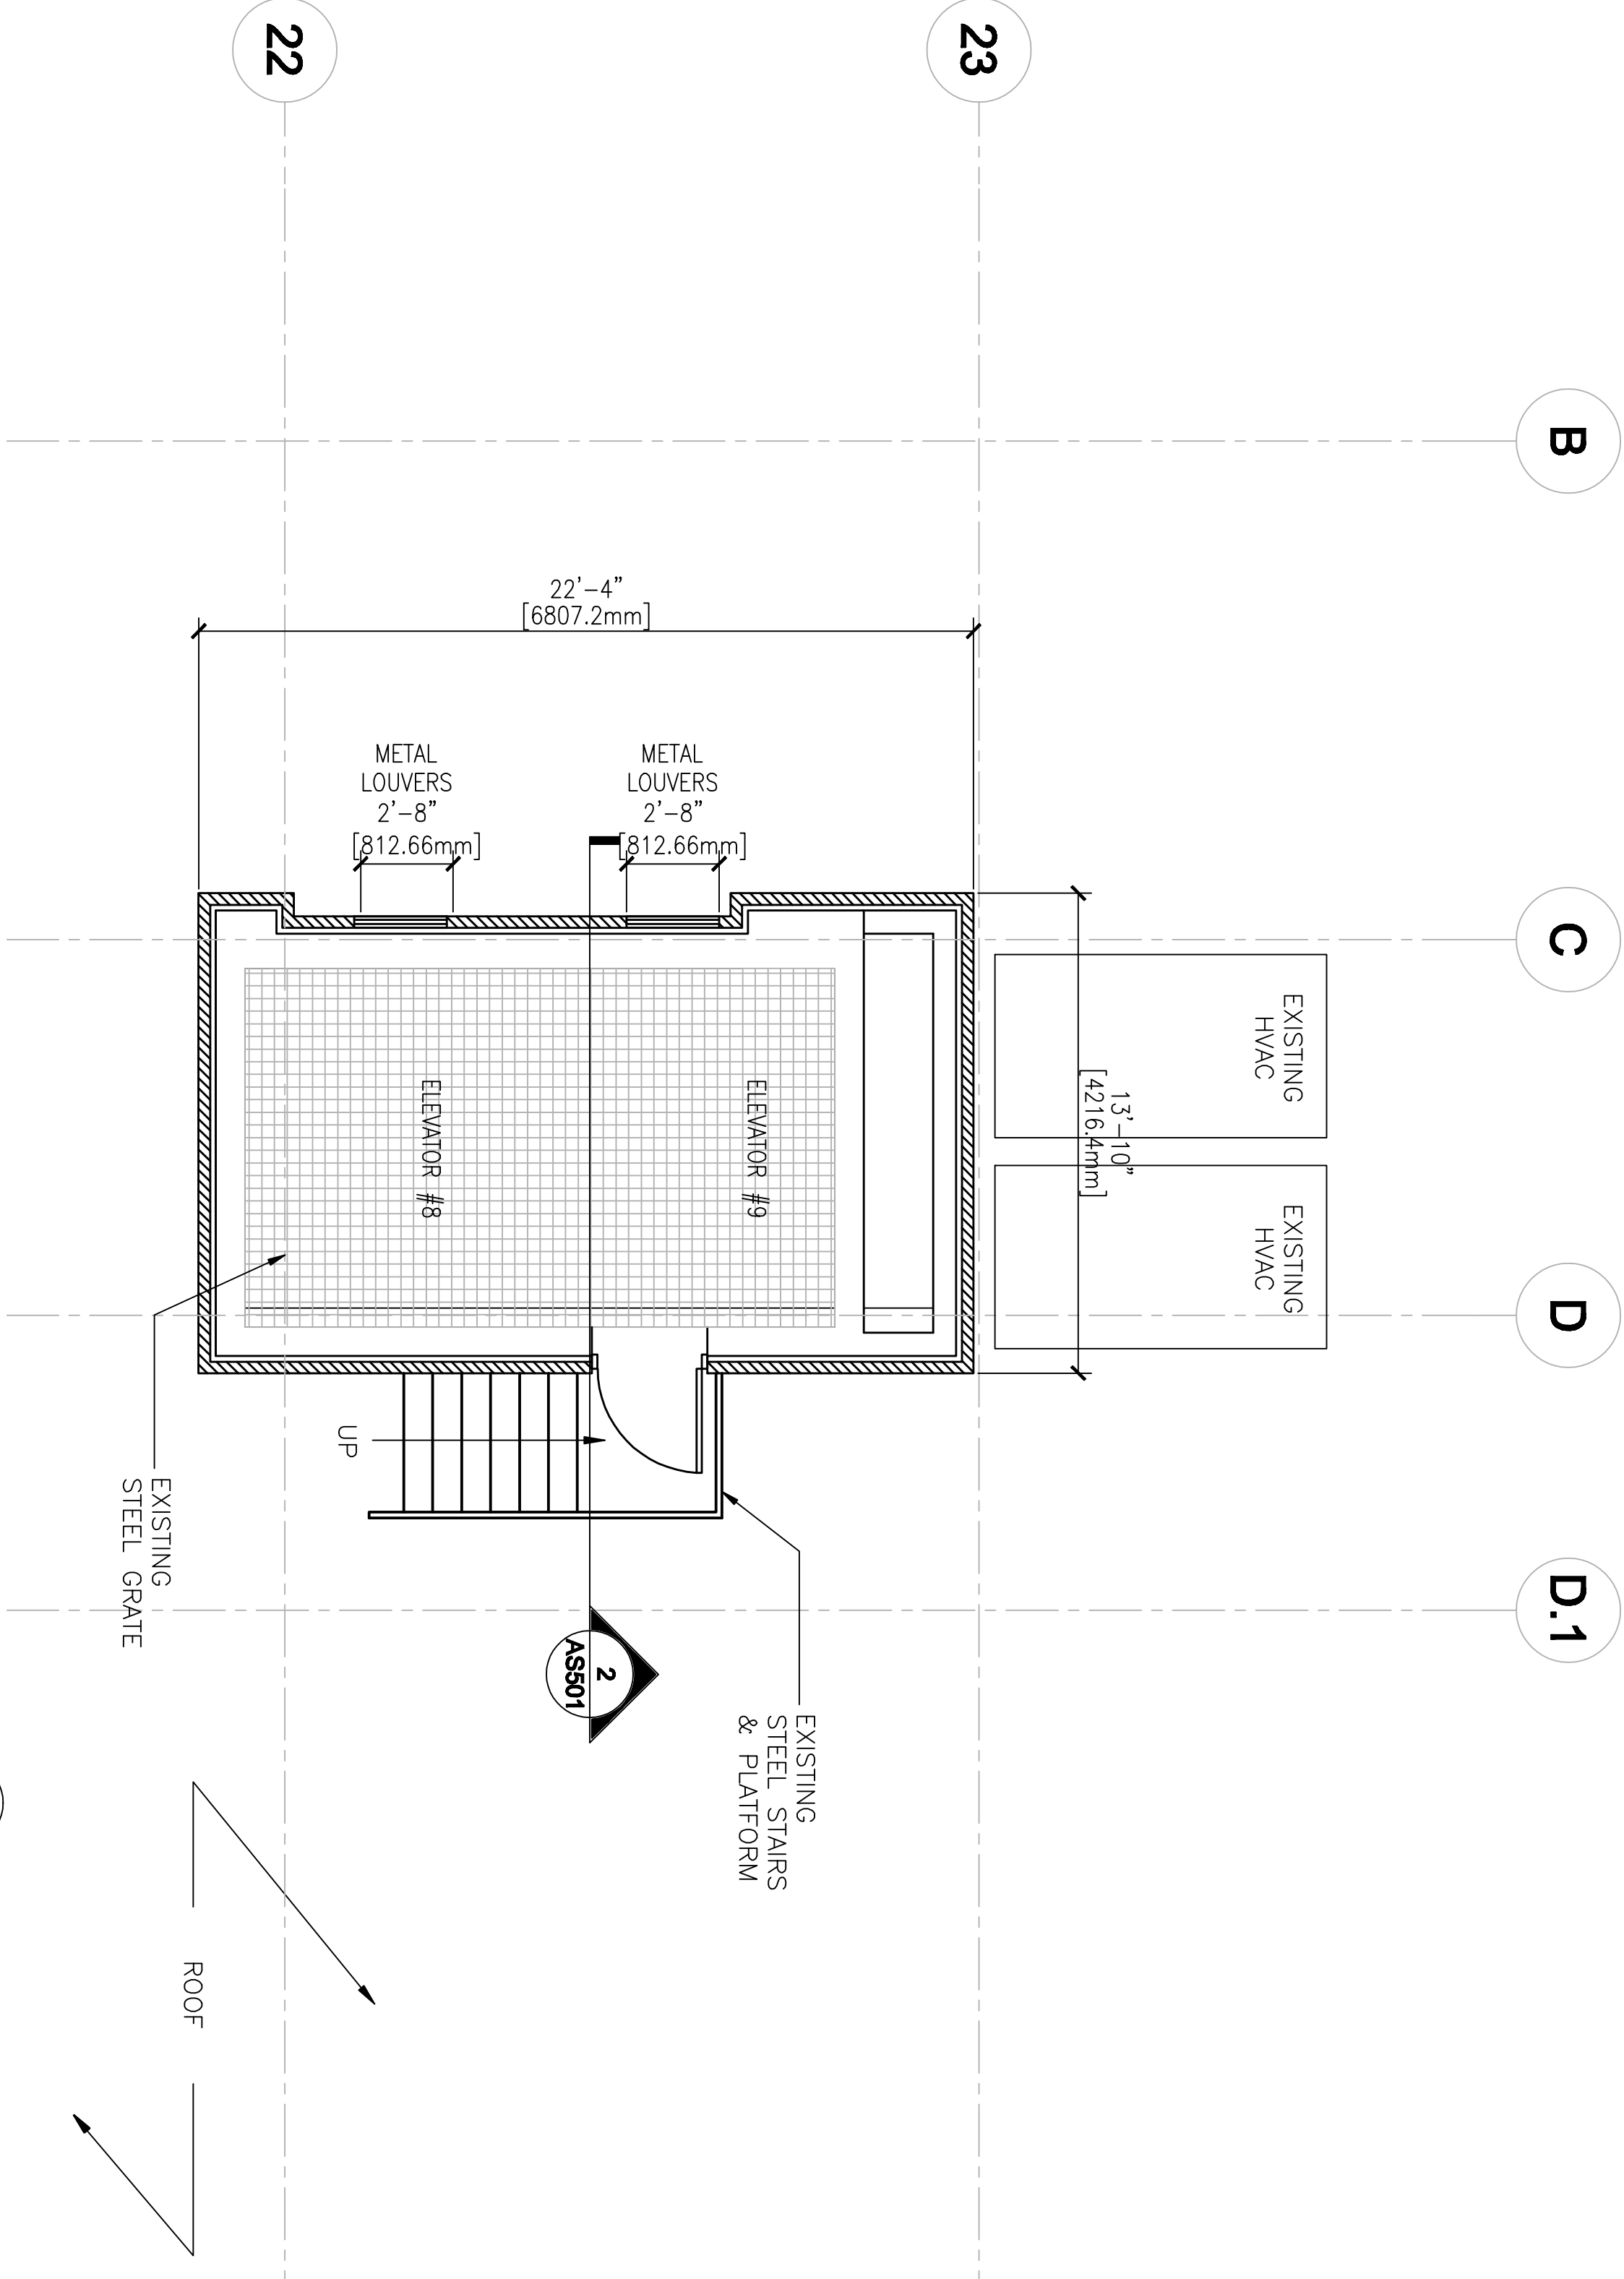

3 ROOF PLAN – PROPOSED
AS403 SCALE: 1/4" = 1'-0"

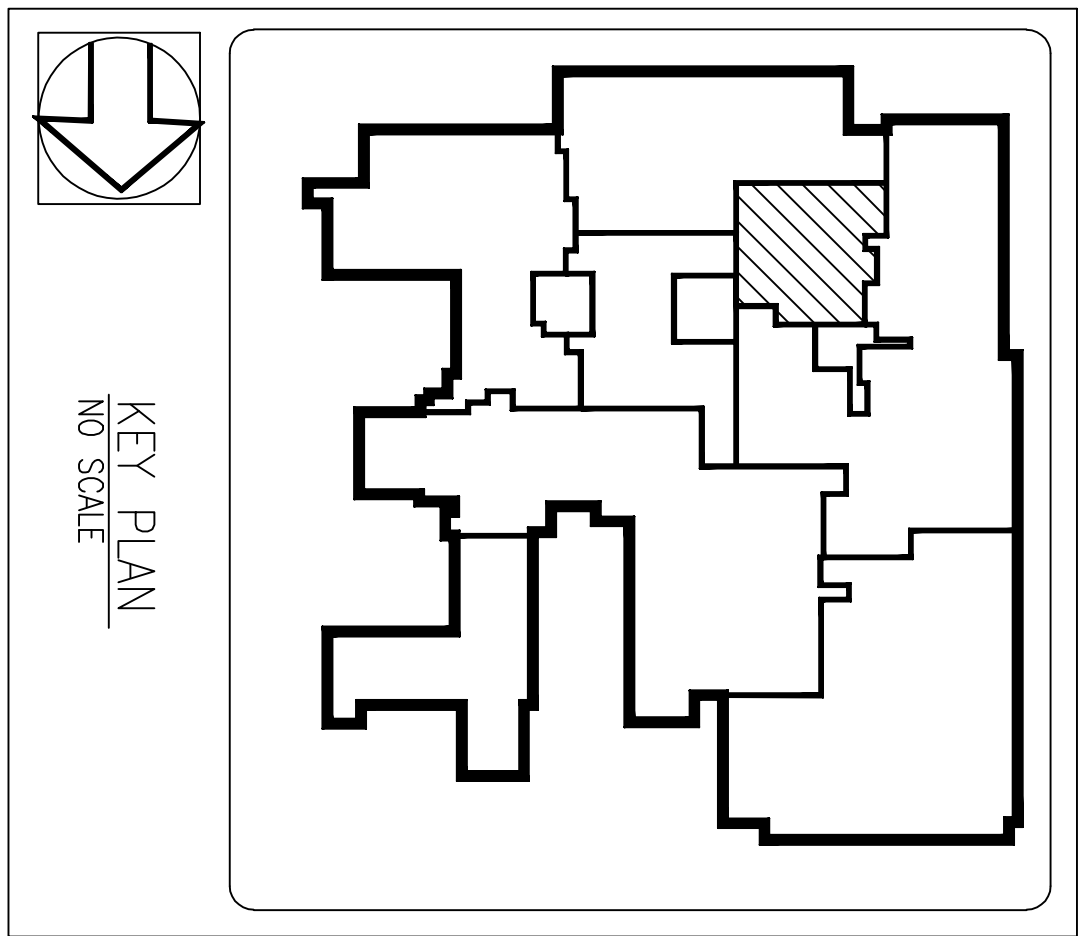

CONSULTANTS:

ARCHITECT/ENGINEERS:

POND
POND ARCHITECTS
3000 Highway 400
Suite 600
Macon, GA 30092
Phone: 706.336-7744
Web: www.pondco.com

Copyright © 2011 by Pond & Company. All rights reserved. No copying or distribution of this drawing is permitted without the express written agreement of Pond & Company.

Drawing Title
ENLARGED ELEVATOR CORE PLANS –
6TH, 7TH AND ROOF

Project Title
Birmingham VA
Replacement of Elevators
Eight and Nine

Project Number
521-10-114
Building Number
1A

Office of
Construction
and Facilities
Management

Department of
Veterans Affairs

Revisions:

Date

READY TO ADVERTISE SUBMITTAL