

0

3

Three inches = one foot

A

0

1

one and one-half inches = one foot

B

0

2

one inch = one foot

C

0

2

three-quarters inch = one foot

D

0

4

one-half inch = one foot

E

0

4

three-eighths inch = one foot

F

0


8

one-quarter inch = one foot

0

16

one-eighth inch = one foot

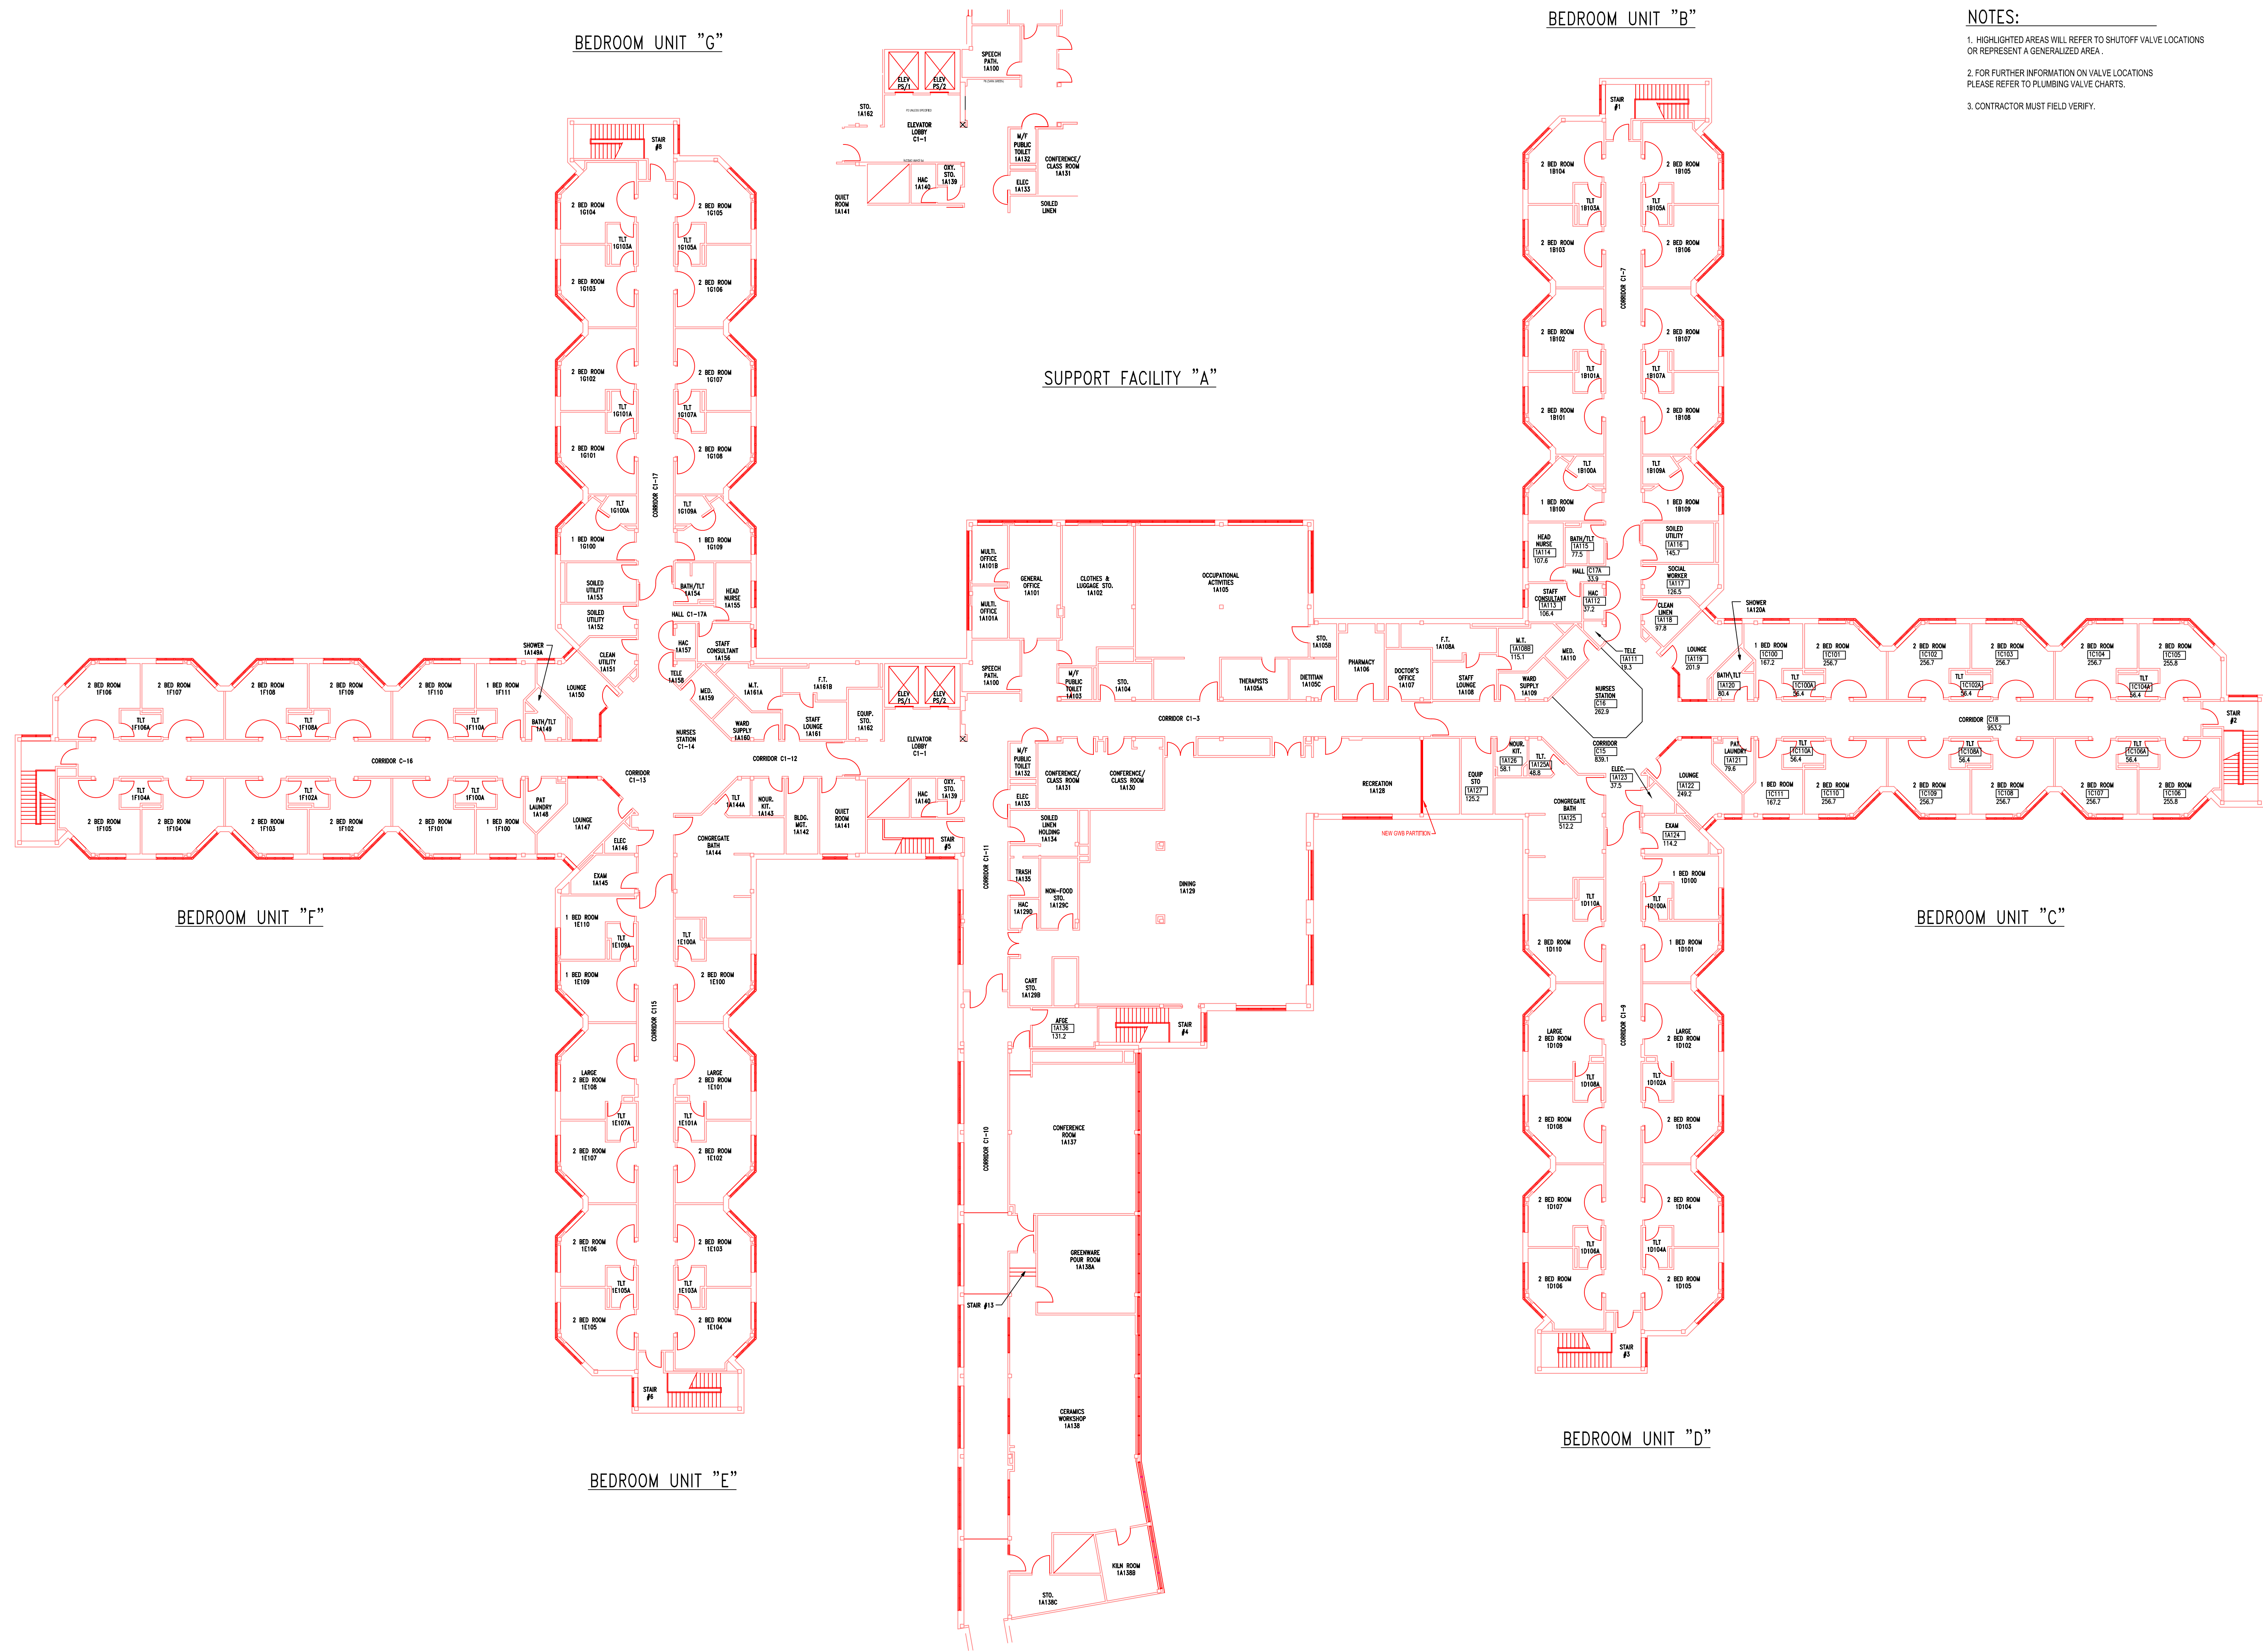

- NOTES:
1. HIGHLIGHTED AREAS WILL REFER TO SHUTOFF VALVE LOCATIONS OR REPRESENT A GENERALIZED AREA.
 2. FOR FURTHER INFORMATION ON VALVE LOCATIONS PLEASE REFER TO PLUMBING VALVE CHARTS.
 3. CONTRACTOR MUST FIELD VERIFY.

SHUTOFF VALVE LOCATIONS

REFERENCE ONLY
(NOT TO BE USED FOR CONSTRUCTION)

GROUND FLOOR PLAN
1/16" = 1'-0"

				GROUND FLOOR PLAN		Project Title		Date		Veterans Affairs
				$\frac{1}{16}" = 1'-0"$		FIRST FLOOR PLAN		1998		
						CLINICAL SUPPORT SERVICE LINE		Project No.		
						NO SCALE				
						Approved: Division Chief		Building Number		
						FIFTY (50)		Checked		
						WDJ		DRAWING NO.		
						Approved: Service Director		Location		Dwg. 2 of 2
								VA PITTSBURGH HEALTHCARE SYSTEM PITTSBURGH, PA. 15240		