


0
three inches = one foot
A
one and one-half inches = one foot
B
one inch = one foot
C
three-quarters inch = one foot
D
one-half inch = one foot
E
three-eighths inch = one foot
F
one-quarter inch = one foot
0
one-eighth inch = one foot
1
2
3
4
5
6
7
8
9

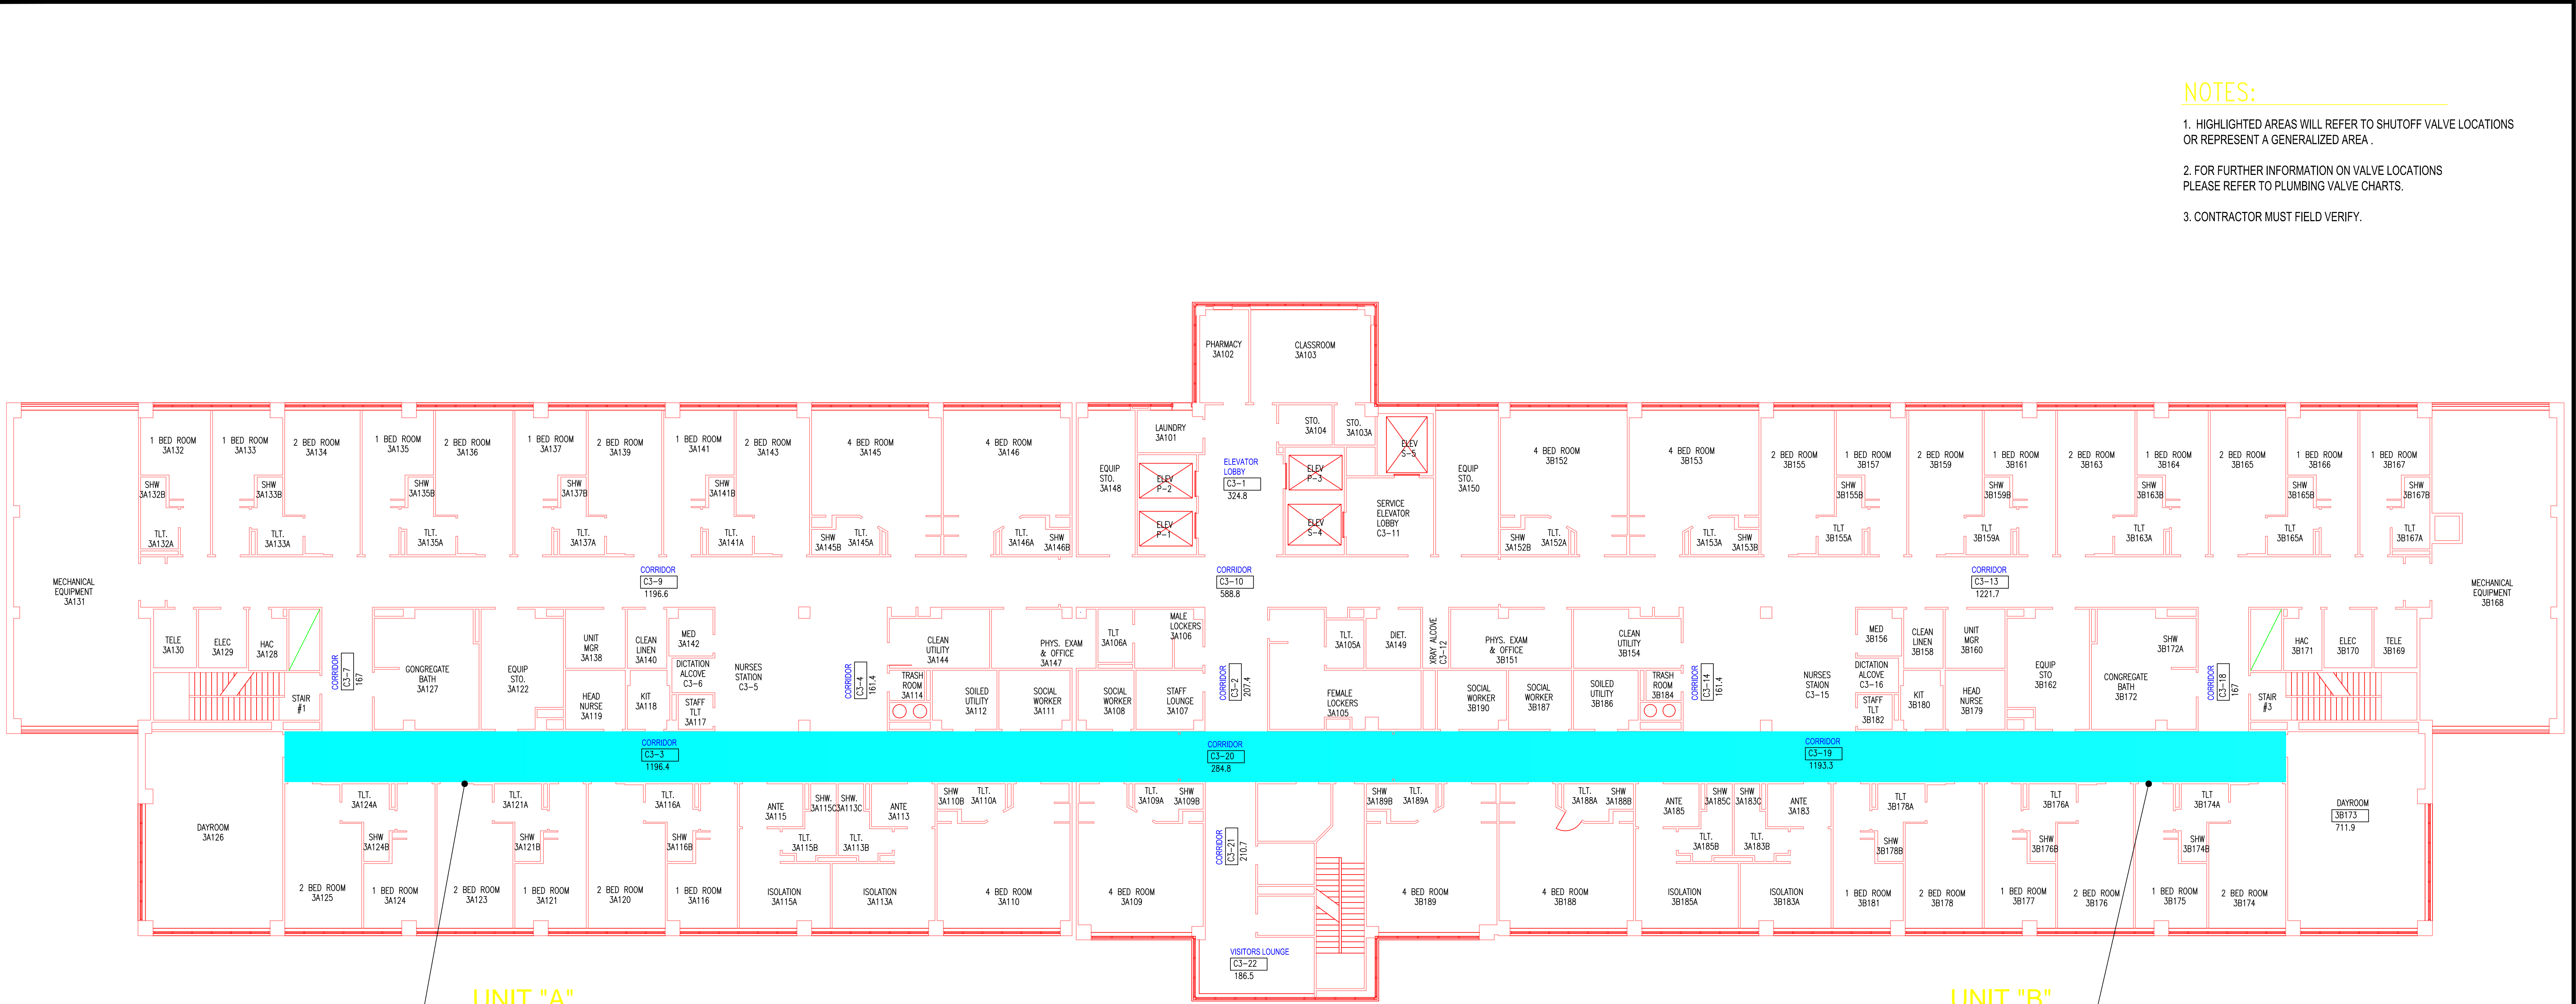

- NOTES:
- HIGHLIGHTED AREAS WILL REFER TO SHUTOFF VALVE LOCATIONS OR REPRESENT A GENERALIZED AREA.
 - FOR FURTHER INFORMATION ON VALVE LOCATIONS PLEASE REFER TO PLUMBING VALVE CHARTS.
 - CONTRACTOR MUST FIELD VERIFY.

CW - 212, HW - 155, & HWRC - 72 THIRD FLOOR NORTH SHAFT MAIN SHUTOFF
SHUTOFF LOCATION: THIRD FLOOR INTERSTITIAL AT NORTH SHAFT

CW - 221, HW - 163, & HWRC - 78 THIRD FLOOR SOUTH SHAFT MAIN SHUTOFF
SHUTOFF LOCATION: THIRD FLOOR INTERSTITIAL NEAR COLUMN 25J

THIRD FLOOR PLAN
NO SCALE
SHUTOFF VALVE LOCATIONS

REFERENCE ONLY
(NOT TO BE USED FOR CONSTRUCTION)

Revisions		Date	Drawing Title			Project Title			Date	Veterans Affairs
			THIRD FLOOR PLAN						2002	
			NO SCALE						Project No.	
			Approved: Division Chief			Building Number	Checked	Drawn	DRAWING NO.	
			Approved: Service Director			FIFTY-ONE (51)		WDJ	Dwg. 4 of 5	
						Location			VA PITTSBURGH HEALTHCARE SYSTEM PITTSBURGH, PA 15240	