


0
A
three inches = one foot
1
B
one and one-half inches = one foot
2
C
one inch = one foot
3
D
three-quarters inch = one foot
4
E
one-half inch = one foot
5
F
three-eighths inch = one foot
6
one-quarter inch = one foot
7
one-eighth inch = one foot
8
9
0

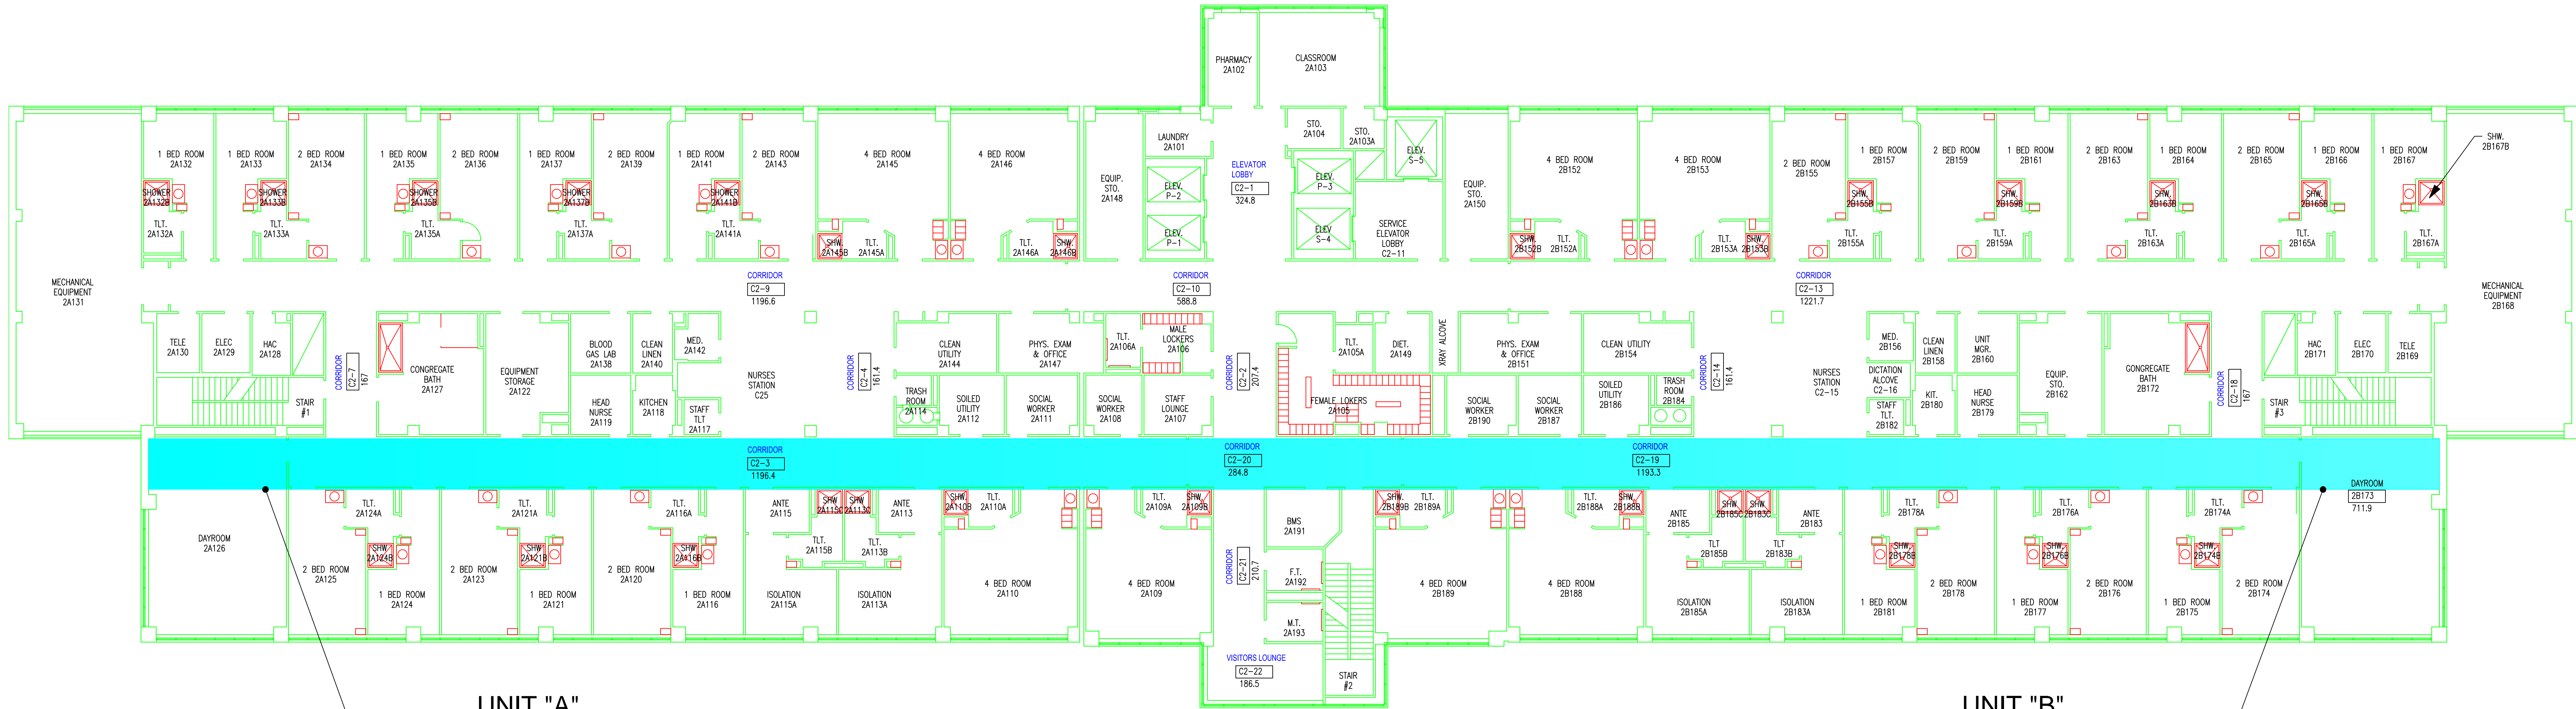

- NOTES:
- HIGHLIGHTED AREAS WILL REFER TO SHUTOFF VALVE LOCATIONS OR REPRESENT A GENERALIZED AREA.
 - FOR FURTHER INFORMATION ON VALVE LOCATIONS PLEASE REFER TO PLUMBING VALVE CHARTS.
 - CONTRACTOR MUST FIELD VERIFY.

CW - 192 & HW - 137 SECOND FLOOR NORTH SHAFT MAIN SHUTOFF
HWRC - 58 SECOND FLOOR NORTH SHAFT MAIN SHUTOFF
SHUTOFF LOCATION: SECOND FLOOR INTERSTITIAL AT NORTH SHAFT

CW - 202 & HW - 147 SECOND FLOOR SOUTH SHAFT MAIN SHUTOFF
HWRC - 66 SECOND FLOOR SOUTH SHAFT MAIN SHUTOFF
SHUTOFF LOCATION: SECOND FLOOR INTERSTITIAL AT SOUTH SHAFT

SECOND FLOOR PLAN
NO SCALE

SHUTOFF VALVE LOCATIONS

REFERENCE ONLY

(NOT TO BE USED FOR CONSTRUCTION)

Revisions	Date

Drawing Title		Project Title			Date	Veterans Affairs
SECOND FLOOR PLAN		CLINICAL SUPPORT SERVICE LINE			2002	
NO SCALE					Project No.	
Approved: Division Chief		Building Number	Checked	Drawn	DRAWING NO.	
		FIFTY-ONE (51)		WDJ		
Approved: Service Director		Location				
		VA PITTSBURGH HEALTHCARE SYSTEM PITTSBURGH, PA. 15240			Dwg. 3 of 5	