


three inches = one foot  
one and one-half inches = one foot  
one inch = one foot  
three-quarters inch = one foot  
one-half inch = one foot  
three-eighths inch = one foot  
one-quarter inch = one foot  
one-eighth inch = one foot

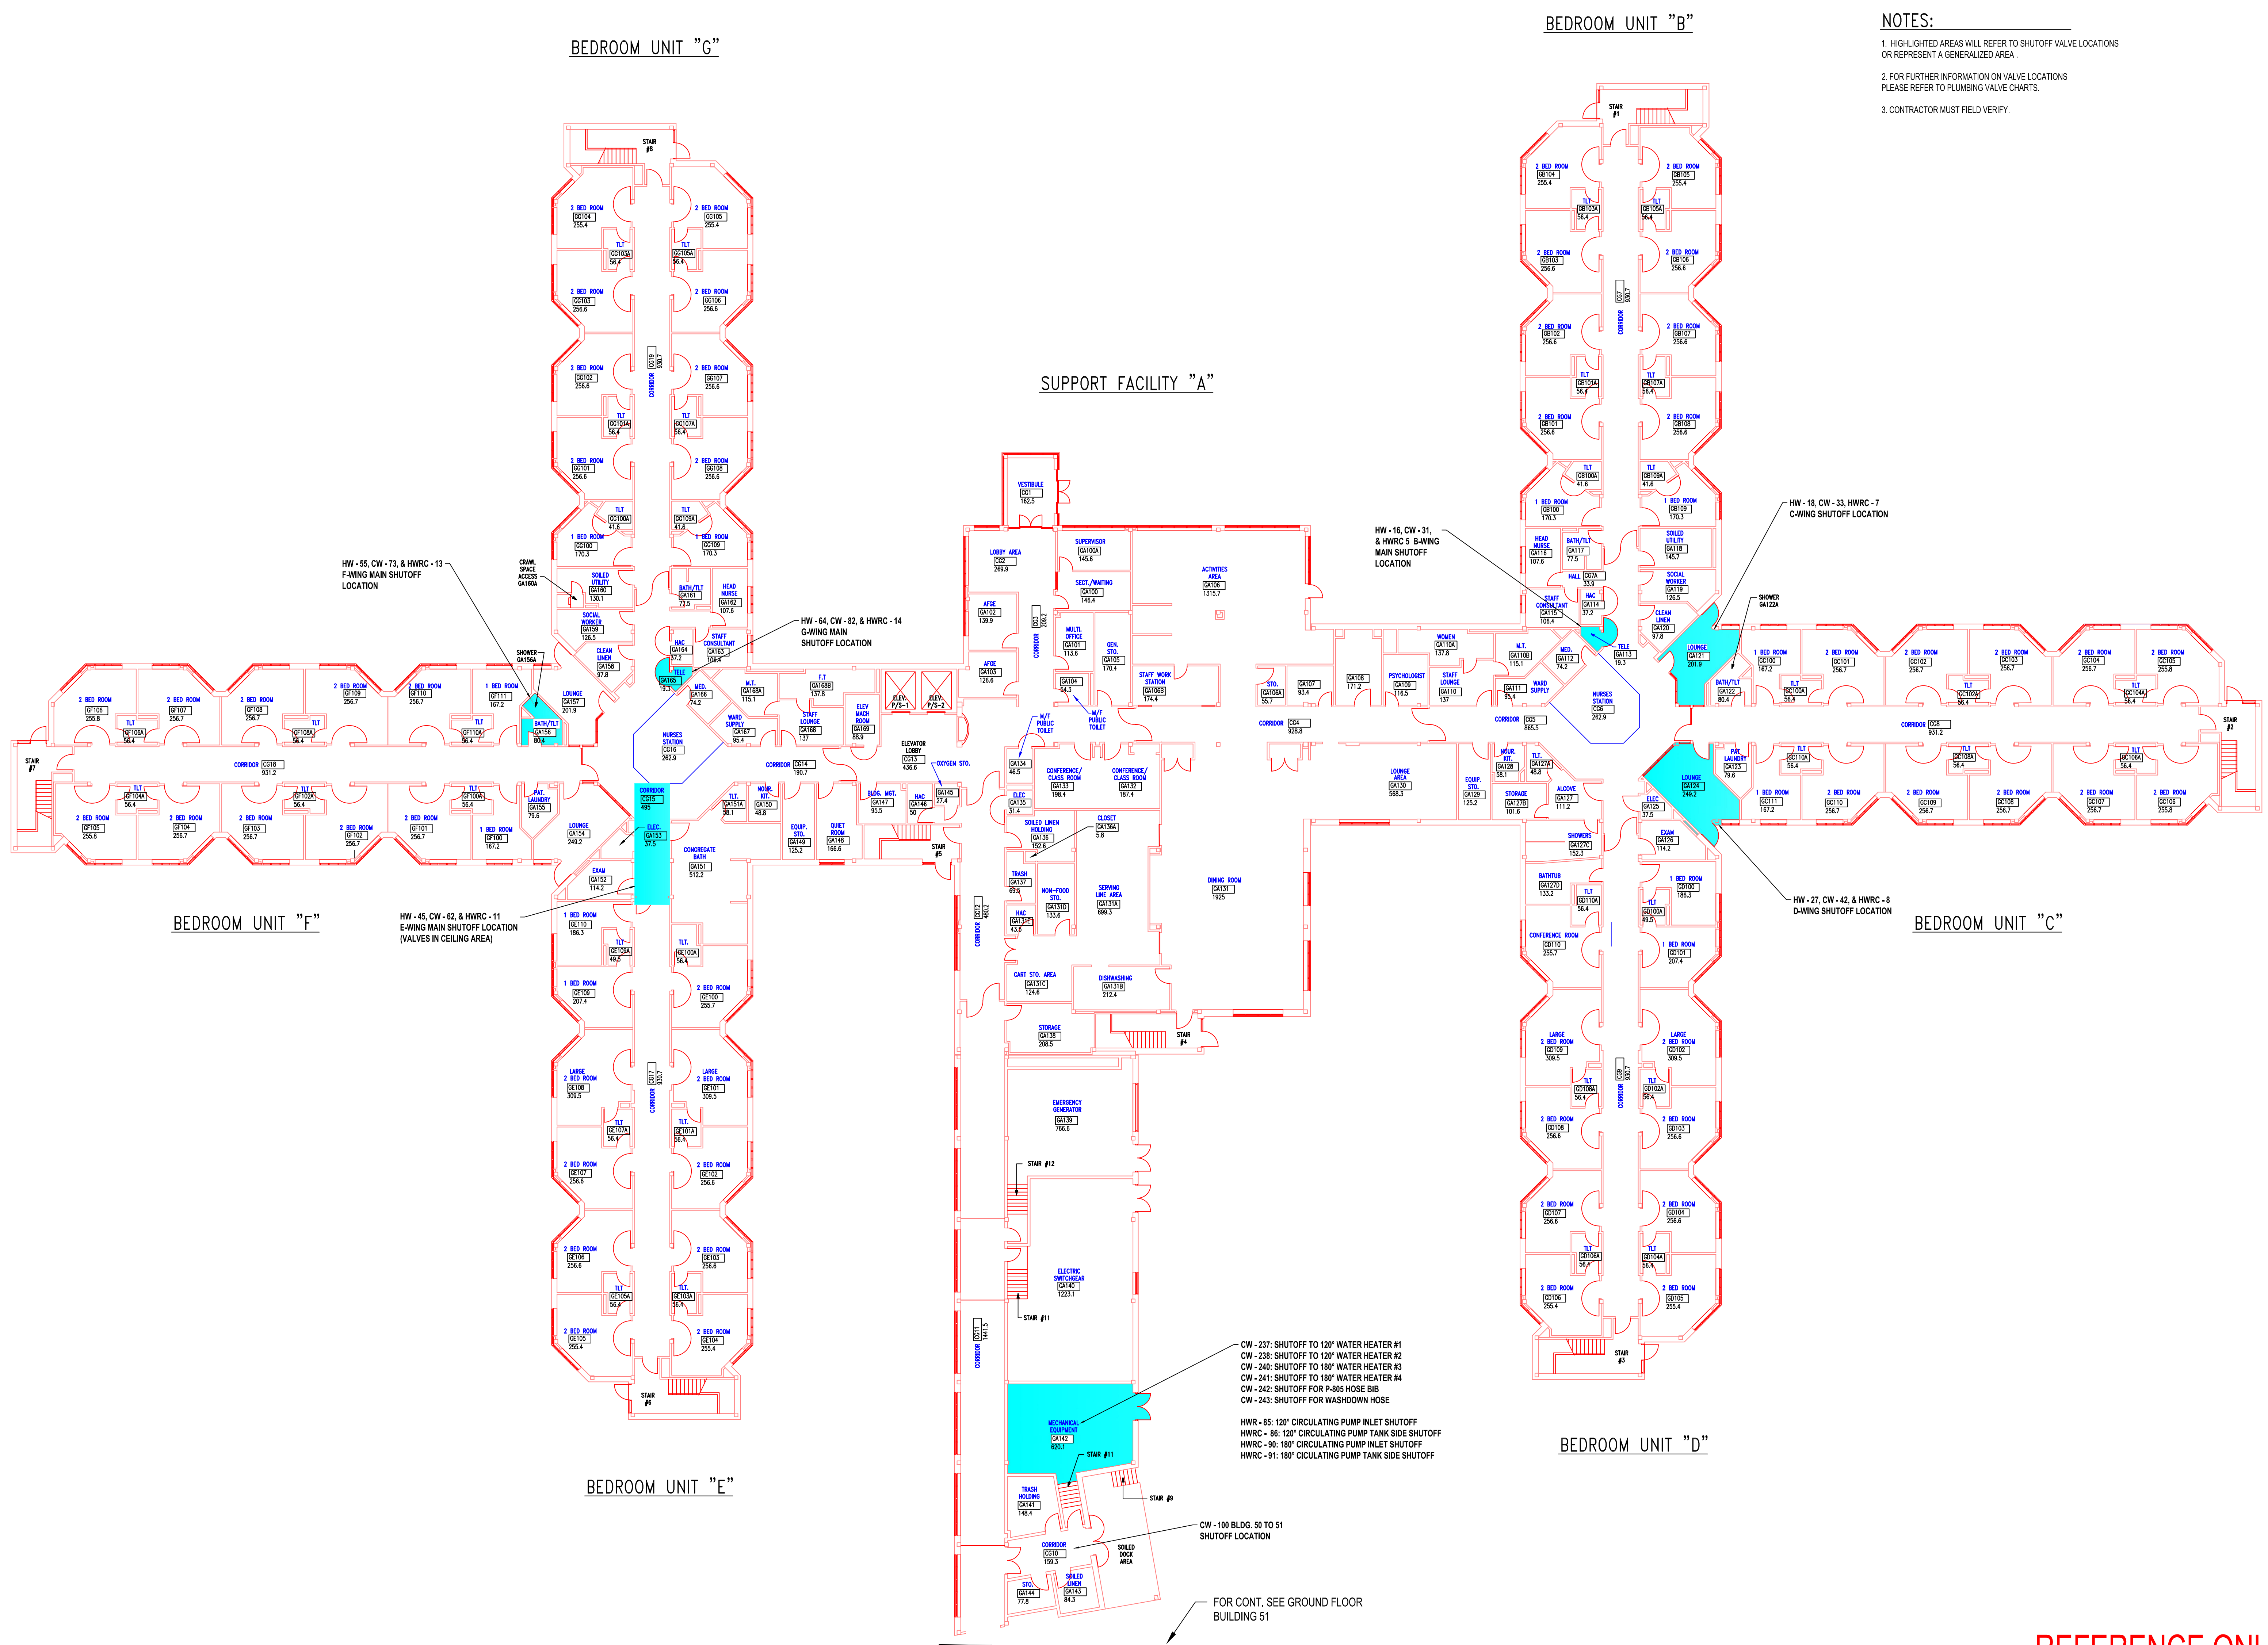

- NOTES:
1. HIGHLIGHTED AREAS WILL REFER TO SHUTOFF VALVE LOCATIONS OR REPRESENT A GENERALIZED AREA.
  2. FOR FURTHER INFORMATION ON VALVE LOCATIONS PLEASE REFER TO PLUMBING VALVE CHARTS.
  3. CONTRACTOR MUST FIELD VERIFY.

SHUTOFF VALVE LOCATIONS

REFERENCE ONLY

(NOT TO BE USED FOR CONSTRUCTION)

GROUND FLOOR PLAN

1" = 1'-0"

CG4, GA130, GA131, GA127, GA127A, GA127B, GA127C, GA127D - DEMENTIA WARD RENOVATIONS		May 2005	Project Title		Date		1998	
Revisions		Date	Approved: Division Chief		Building Number		FIFTY (50)	
			Approved: Service Director		Checked		Drawn	
					Location		VA PITTSBURGH HEALTHCARE SYSTEM PITTSBURGH, PA. 15240	
					DRAFTING NO.		Dwg. 1 of 2	

Veterans Affairs