

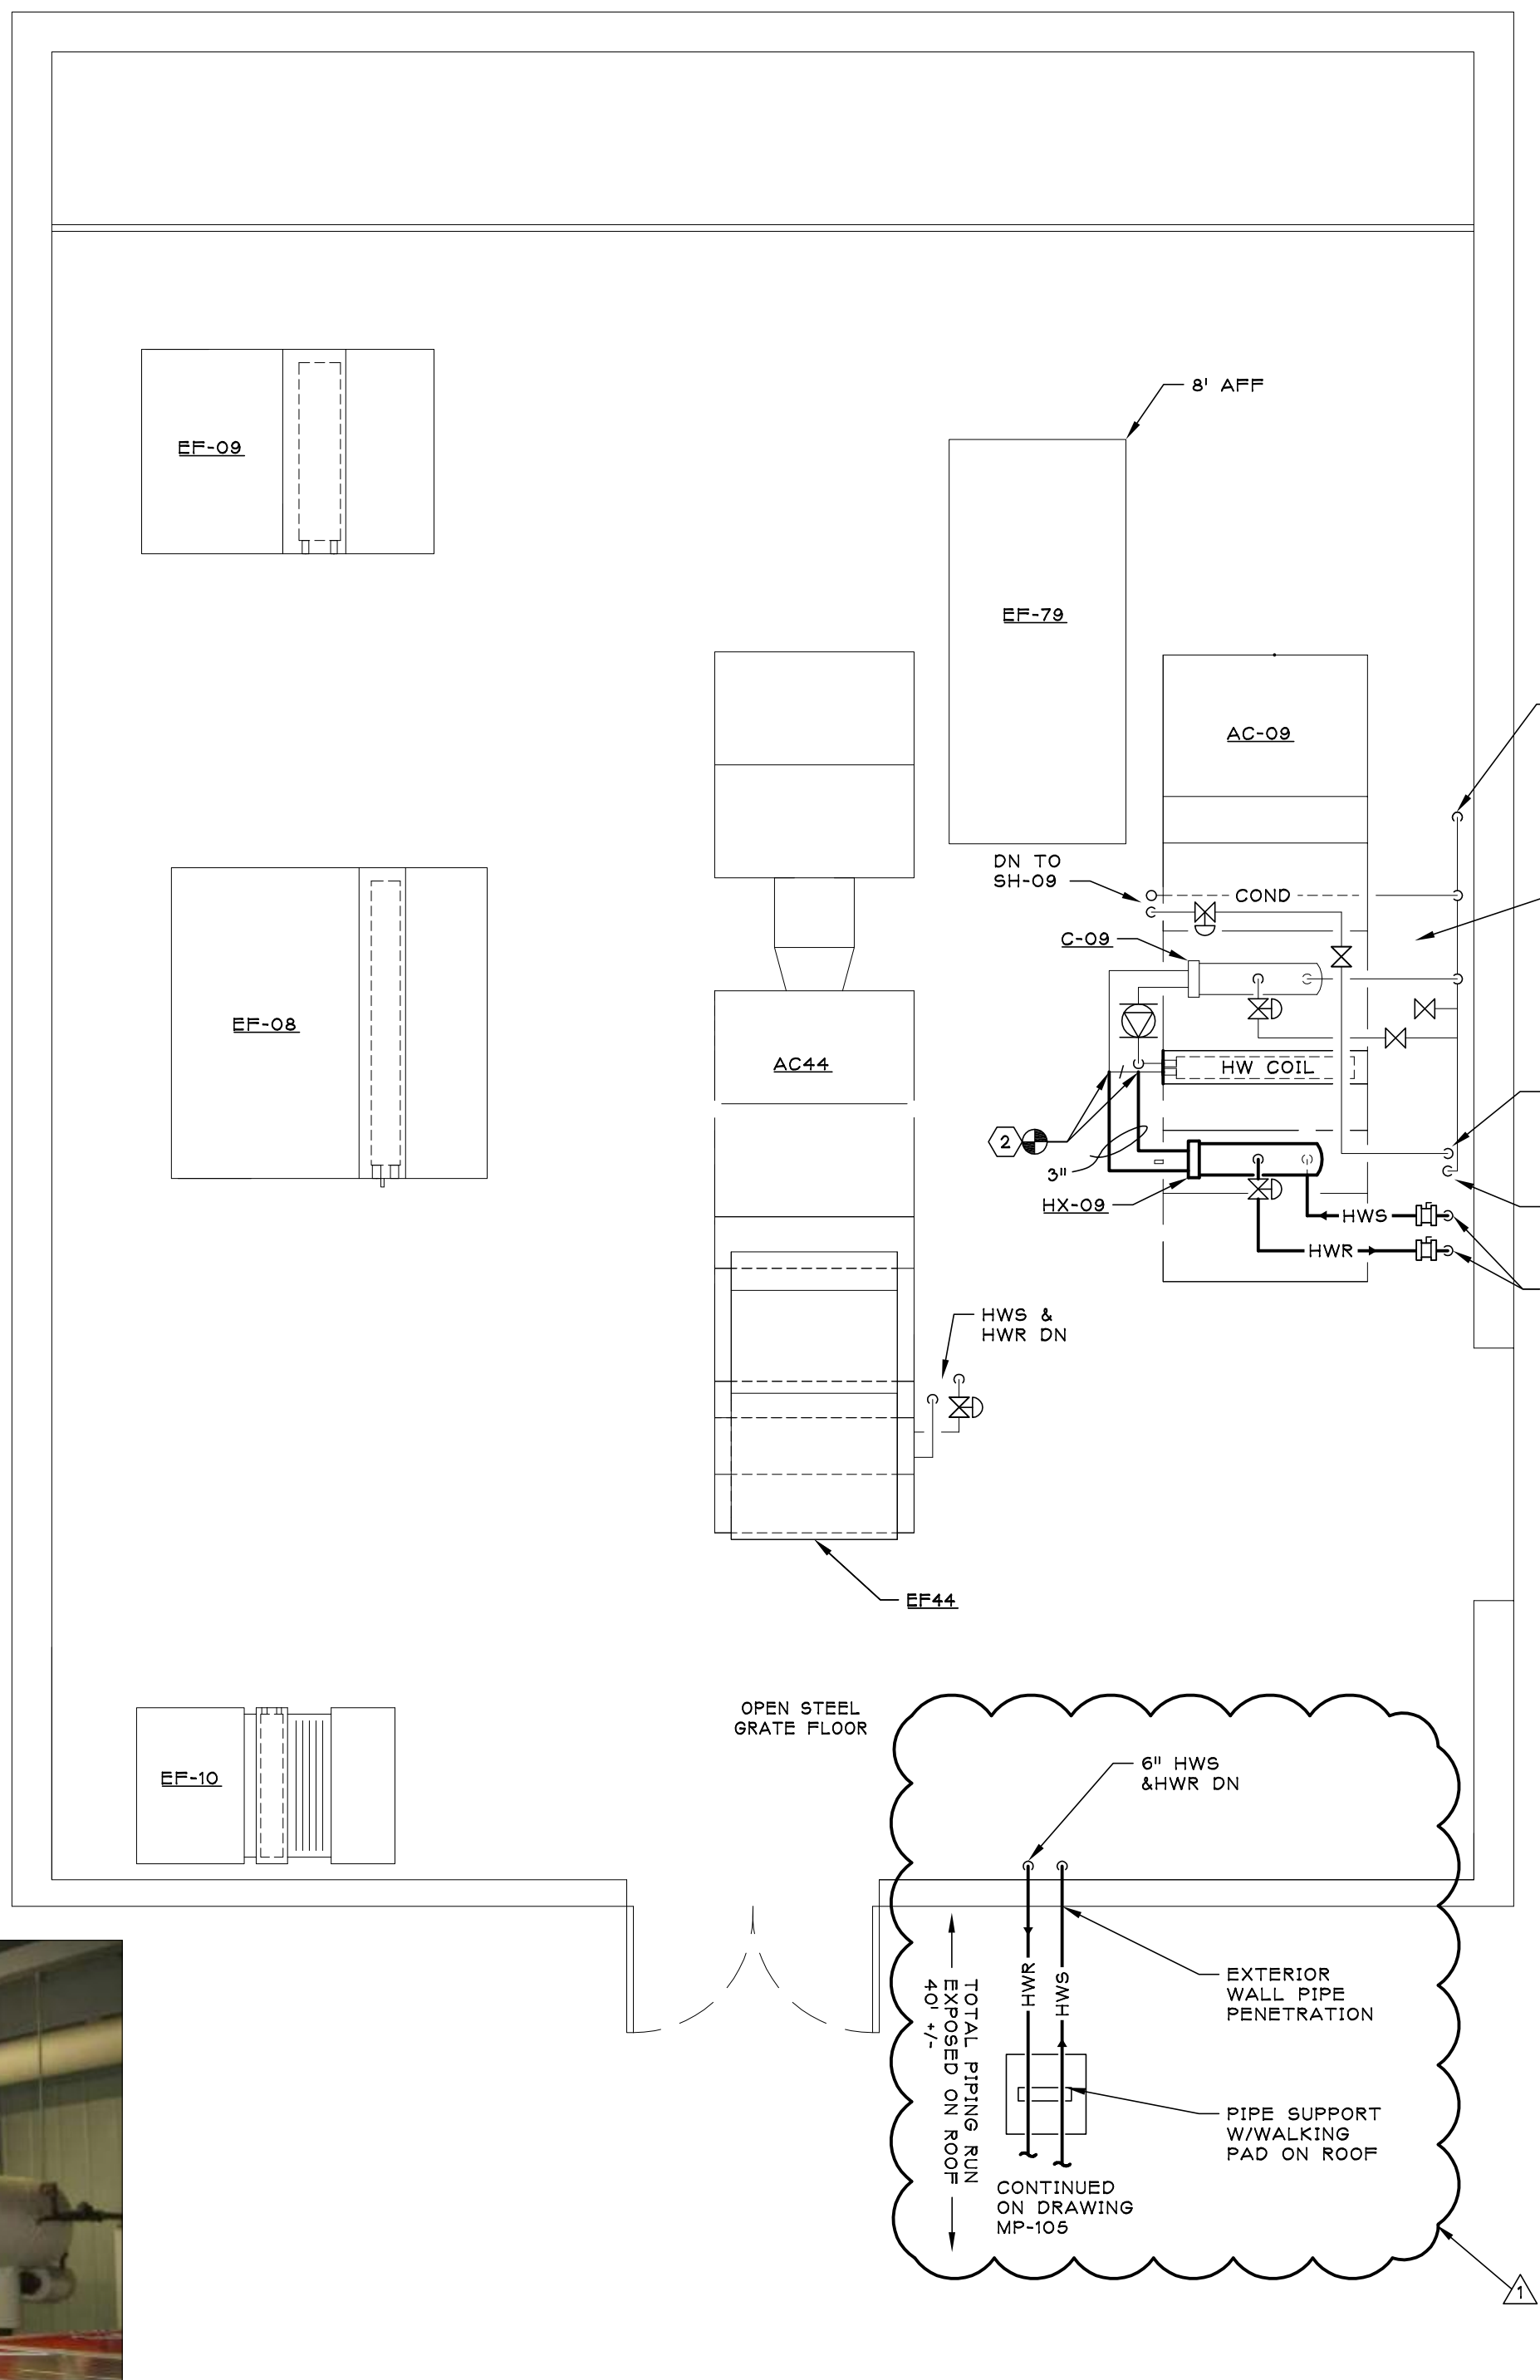


SHAFT 4 8TH FLOOR PLAN
SCALE: 1/4" = 1'-0"

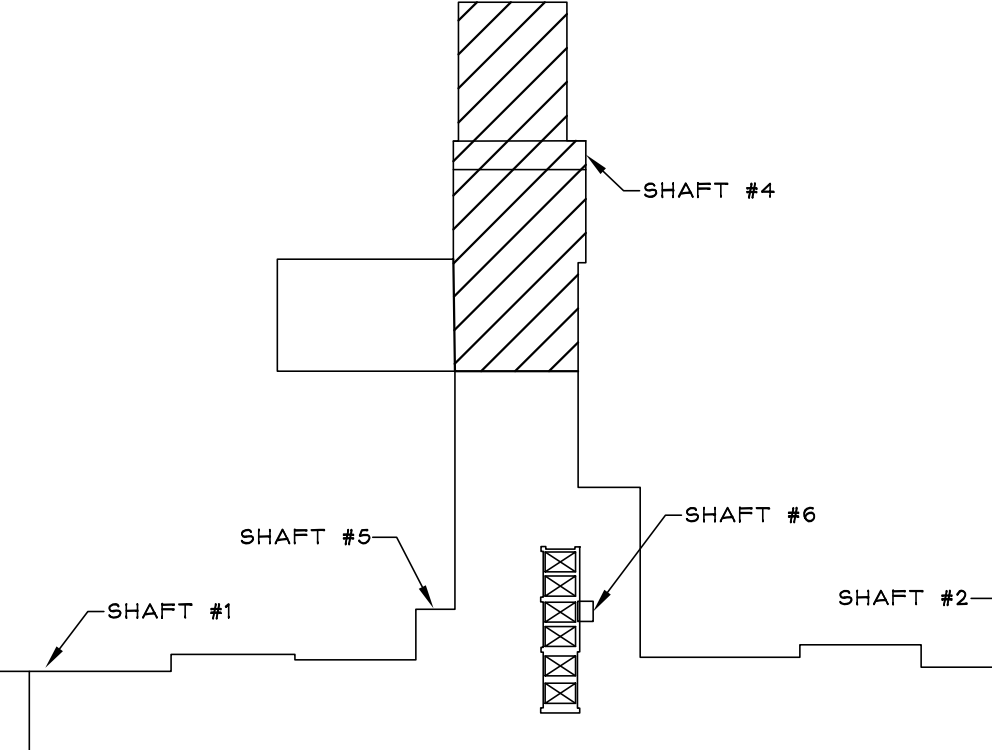

SHAFT 4 9TH FLOOR PLAN
SCALE: 1/4" = 1'-0"

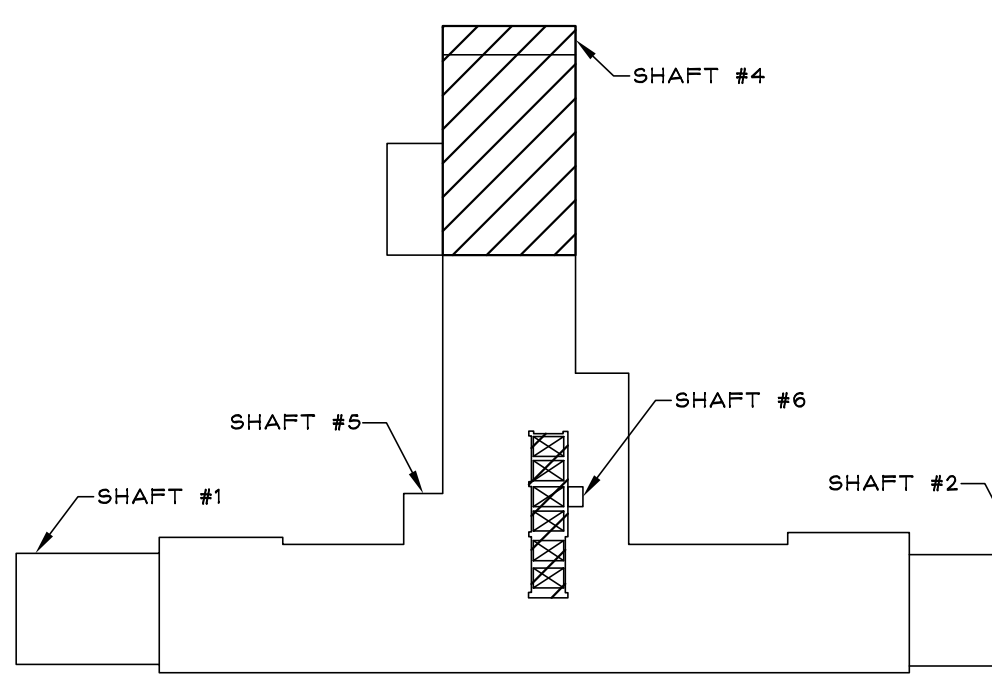


KEY PLAN
NORTH

GENERAL DRAWING NOTES:
1. MAINTAIN CLEAR SERVICE ACCESS TO EXISTING EQUIPMENT WHEN LOCATING NEW PIPING AND HEAT EXCHANGERS.

KEYED NOTES:
① REFER TO MP-401 HOT WATER STATION PIPING AND CONTROL SCHEMATIC. PROVIDE ALL REQUIRED FITTINGS, VALVES, CONTROL DEVICES, INSULATION AND APPURTENANCES TO CONNECT HWS & HWR PIPING TO EXISTING HOT WATER STATION SUPPLY PIPING.
② REFER TO MP-401 HOT WATER HEATING COIL CONTROL SCHEMATIC AND HEAT EXCHANGER DETAIL. PROVIDE ALL REQUIRED FITTINGS, VALVES, CONTROL DEVICES, INSULATION, HEAT EXCHANGER, GLYCOL AND APPURTENANCES TO CONNECT HWS & HWR TO EXISTING HOT GLYCOL HEATING COIL LOOP.

Revisions		
RF1 #001 ADDENDUM	03-05-15	Date

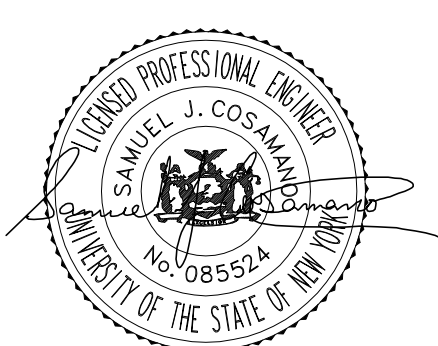

IPD: Engineering
INTEGRATED PROJECT DELIVERY
ONE WEBSTER'S LANDING
SYRACUSE, NEW YORK 13202
315.423.0185
IPD PROJECT # 11-7061-8

Drawing Title	SHAFT #4 - 8TH AND 9TH FLOOR BOILER PIPING PLANS
Project Title	ADD HEATING HOT WATER TO SHAFTS #3 & #4
Building Number	1
Location	SYRACUSE

Date	11-16-12
Project No.	528A7-11-711
Drawing No.	MP-103
Dwg.	4 of 9

