


9TH FLOOR PARTIAL PLAN - HVAC PIPING PLAN  
SCALE: 1/4" = 1'-0"

- KEYED NOTES:
- 1. PROVIDE ALL EXTERIOR PIPE WITH 3" URETHANE INSULATED WITH ALUMINUM JACKET. COORDINATE HEAT TRACE WITH ELECTRICAL TRADE.
  - 2. REMOVE AND REINSTALL ACOUSTIC CEILING TILES.
  - 3. PROVIDE SELF REGULATING HEAT TRACE FREEZE PROTECTION SYSTEM. INCLUDE 120V/1P POWER TO NEAREST AVAILABLE SOURCE.

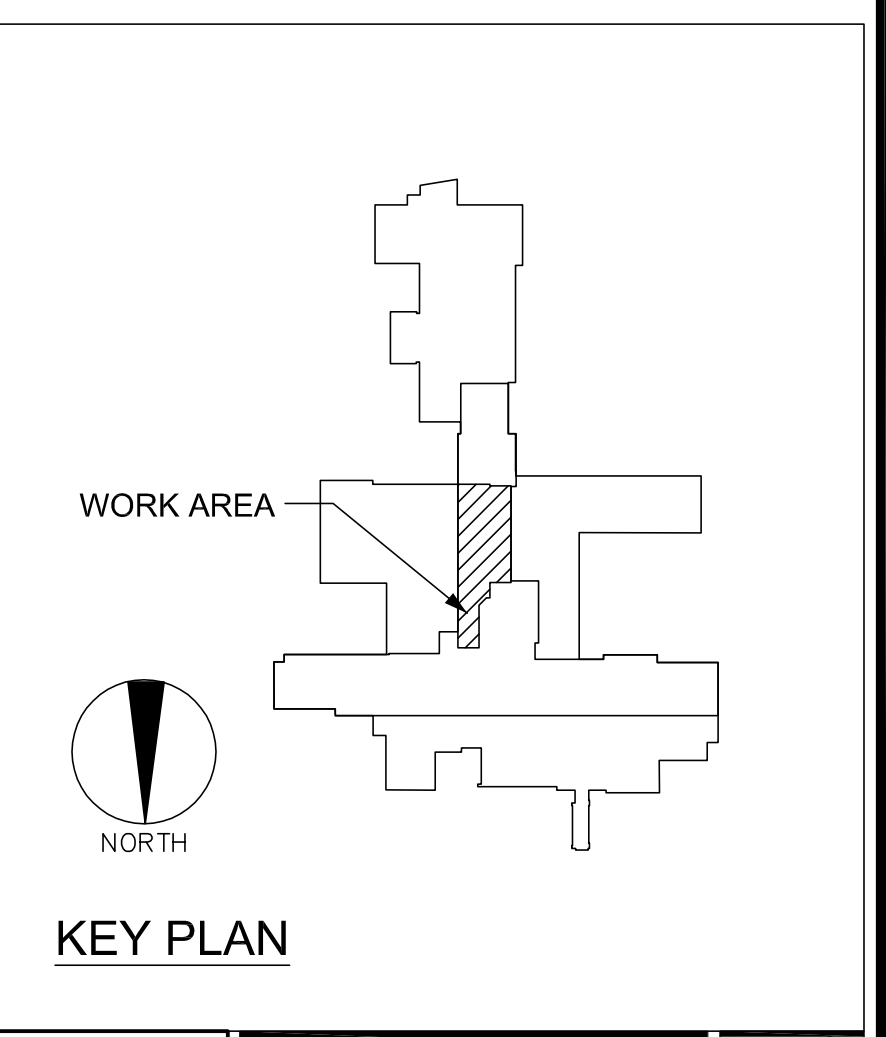

RF1 #001 ADDENDUM	03-09-13
Revisions	Date



**IPD: Engineering**  
INTEGRATED PROJECT DELIVERY  
ONE WEBSTER'S LANDING  
SYRACUSE, NEW YORK 13202  
315.423.0185  
IPD PROJECT # 11-7061-8

Drawing Title 9TH FLOOR HVAC PIPING PLAN	Project Title ADD HEATING HOT WATER TO SHAFTS #3 & #4	Date 11-16-12
Building Number 1	Checked SBG	Drawn NCB
Location SYRACUSE	Drawing No. MP-105	Dwg. 6 of 9

VA HEALTHCARE NETWORK  
UPSTATE NEW YORK

Department of Veterans Affairs