



DEPARTMENT OF VETERANS AFFAIRS

MINNEAPOLIS, MN. MEDICAL CENTER


STUDY OF EMERGENCY POWER

BUILDING 49

GENERATOR REPLACEMENT

DRAWING INDEX

SHEET NUMBER	SHEET TITLE
GENERAL SHEETS	
1263-G001	COVER SHEET
MECHANICAL SHEETS	
1263-M201	BLDG 49 GENERATOR DEMOLITION PLAN
1263-M202	BLDG 49 GENERATOR INSTALLATION PLAN
1263-M601	BLDG 49 MISCELLANEOUS DETAILS
ELECTRICAL SHEETS	
1263-E201	BLDG 49 GENERATOR DEMOLITION PLAN
1263-E202	BLDG 49 GENERATOR INSTALLATION PLAN
1263-E601	BLDG 49 ELECTRICAL RISER AND ONE-LINE DIAGRAM

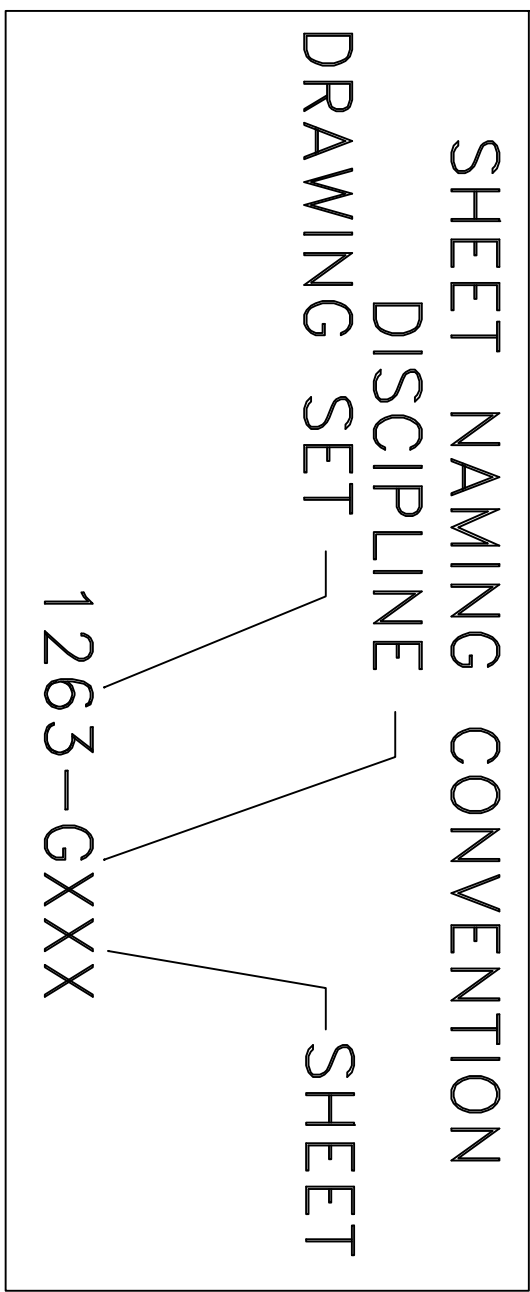


APPROVED BY:

DATE

ENGINEERING PROJECT SECTION CHIEF CYNDI DOOLITTLE
ENGINEERING CHIEF STEVE CHALLENGER
MAINTENANCE CHIEF TED STEIDL
SAFETY MANAGER PAM RUSSELL-DeMASTER
VA POLICE
PATIENT SAFETY
INFECTION CONTROL
UNION 1969
UNION 3669

GENERAL NOTE:

ALL CONTRACTORS AND SUBCONTRACTORS SHALL VERIFY ALL DIMENSIONS BY MEASUREMENT AT THE BUILDING AND/OR SITE.

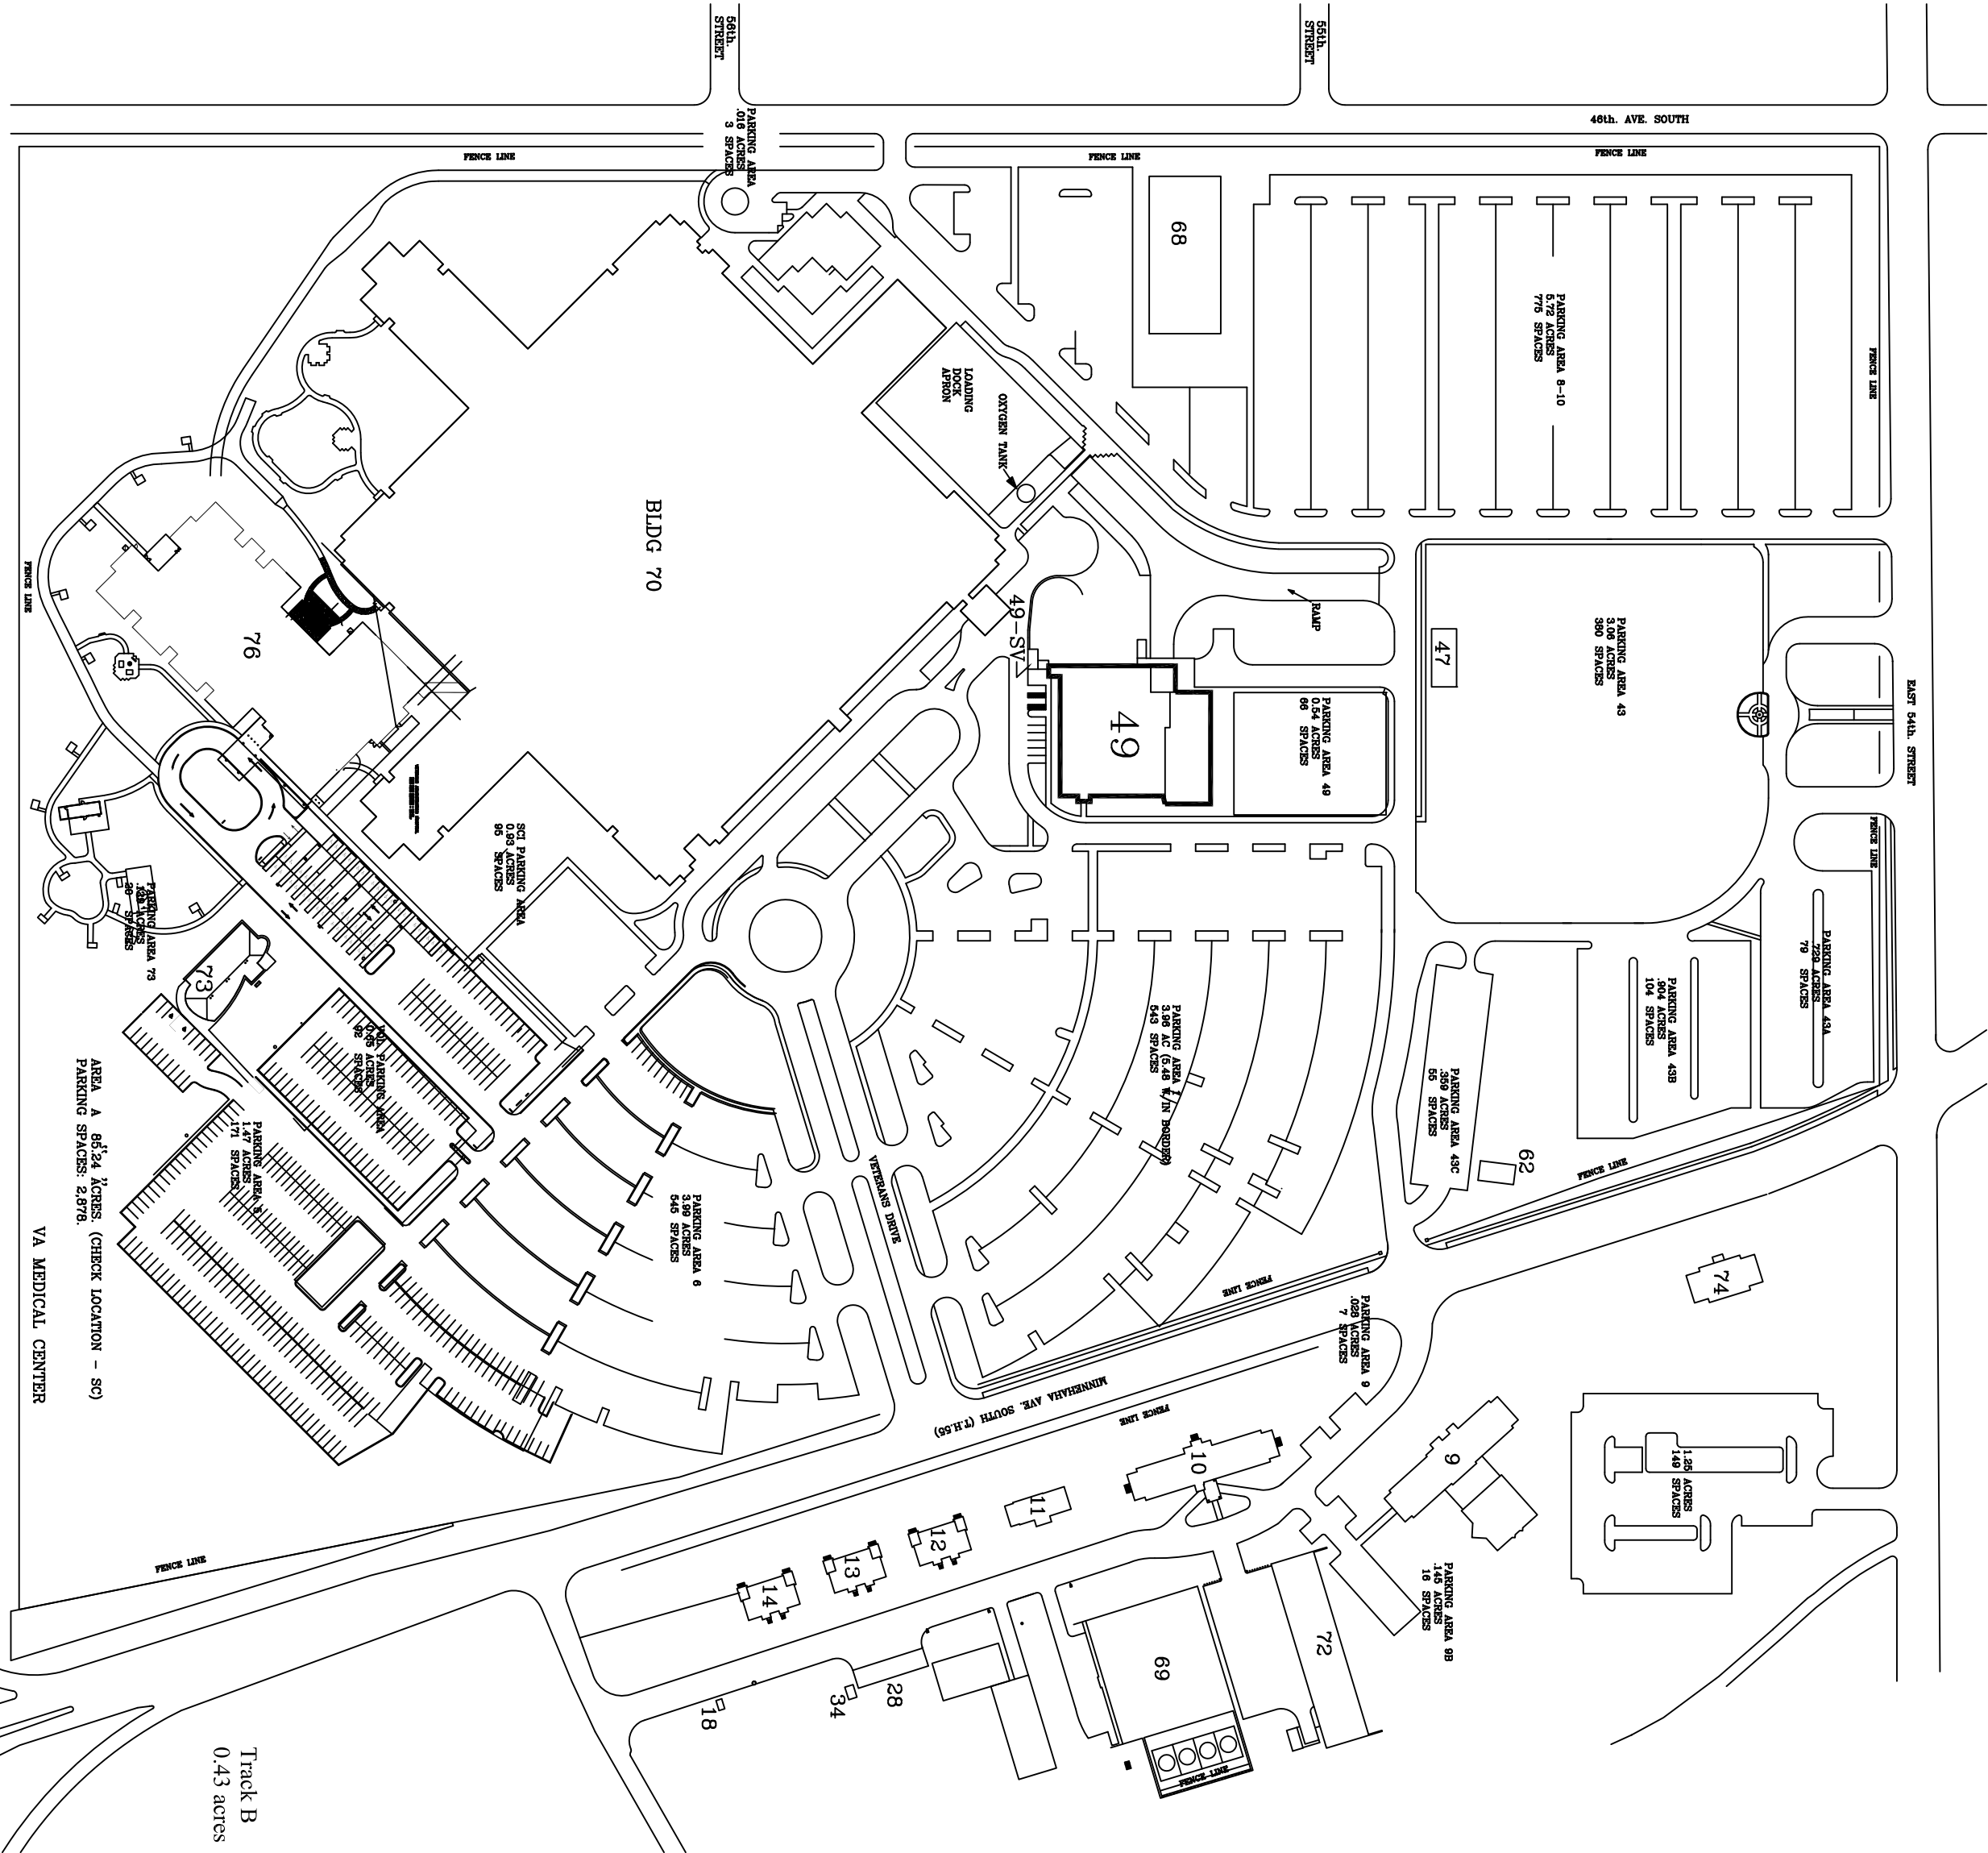

LOCATION MAP: MPLS. VAMC

CONSTRUCTION DOCUMENT SUBMISSION

Revisions		Date	
<div>GENERAL NOTE: ALL CONTRACTORS AND SUBCONTRACTORS SHALL VERIFY ALL DIMENSIONS BY MEASUREMENT AT THE BUILDING AND/OR SITE.</div>			
<div><div><div>N</div><div></div></div></div>		<div><div>PROJECT TITLE</div><div>STUDY OF EMERGENCY POWER</div></div>	
<div><div>APPROVED: Division Chief</div><div></div></div>		<div><div>PROJECT NO.</div><div>618-12-104</div></div>	
<div><div>APPROVED: Service Director</div><div></div></div>		<div><div>DWG NO.</div><div>1263-G001</div></div>	
<div><div>LOCATION</div><div>VA MEDICAL CENTER ONE VETERANS DRIVE MINNEAPOLIS, MN 55417</div></div>		<div><div>DWG 1 of 7</div></div>	
Veterans Administration			