

A

B

C

D

E

F

A

B


C

D


E

F

three inches = one foot
one and one half inches = one foot
one inch = one foot
three quarters inch = one foot
one half inch = one foot
three eighths inch = one foot
one quarter inch = one foot
one eighth inch = one foot

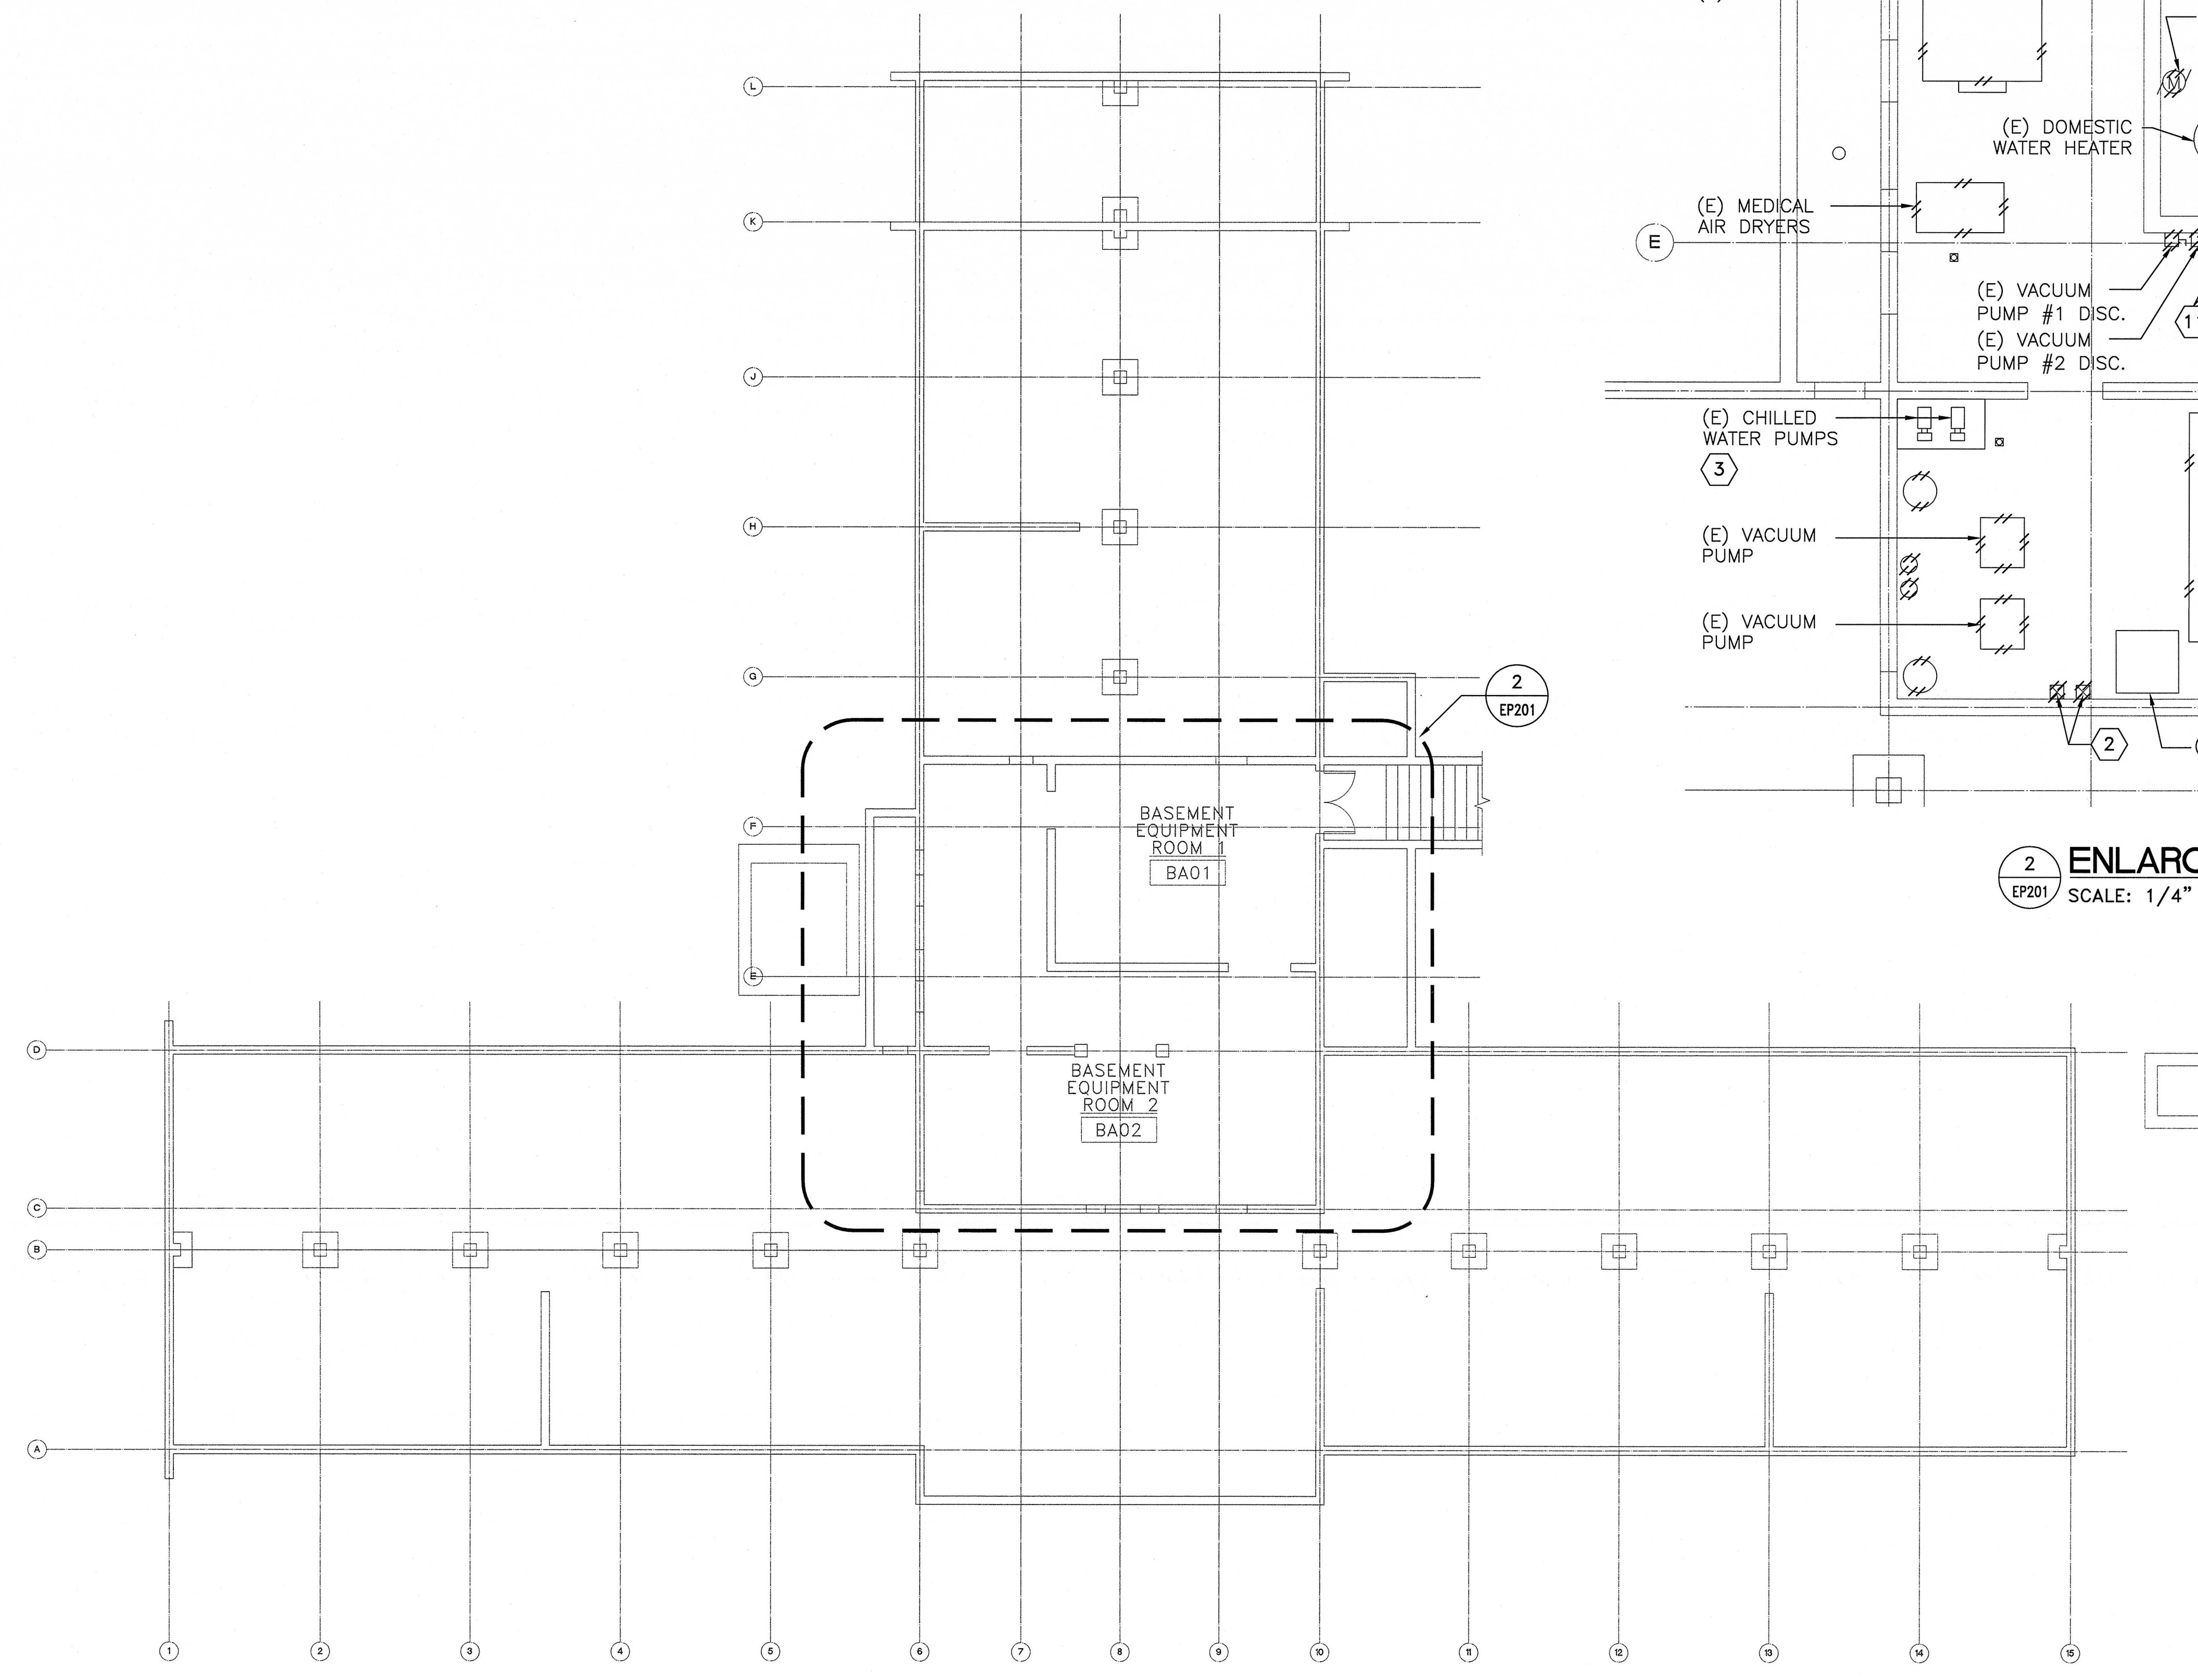

1 BASEMENT MECHANICAL ELECTRICAL DEMOLITION PLAN
EP201 SCALE: 1/8" = 1'-0"

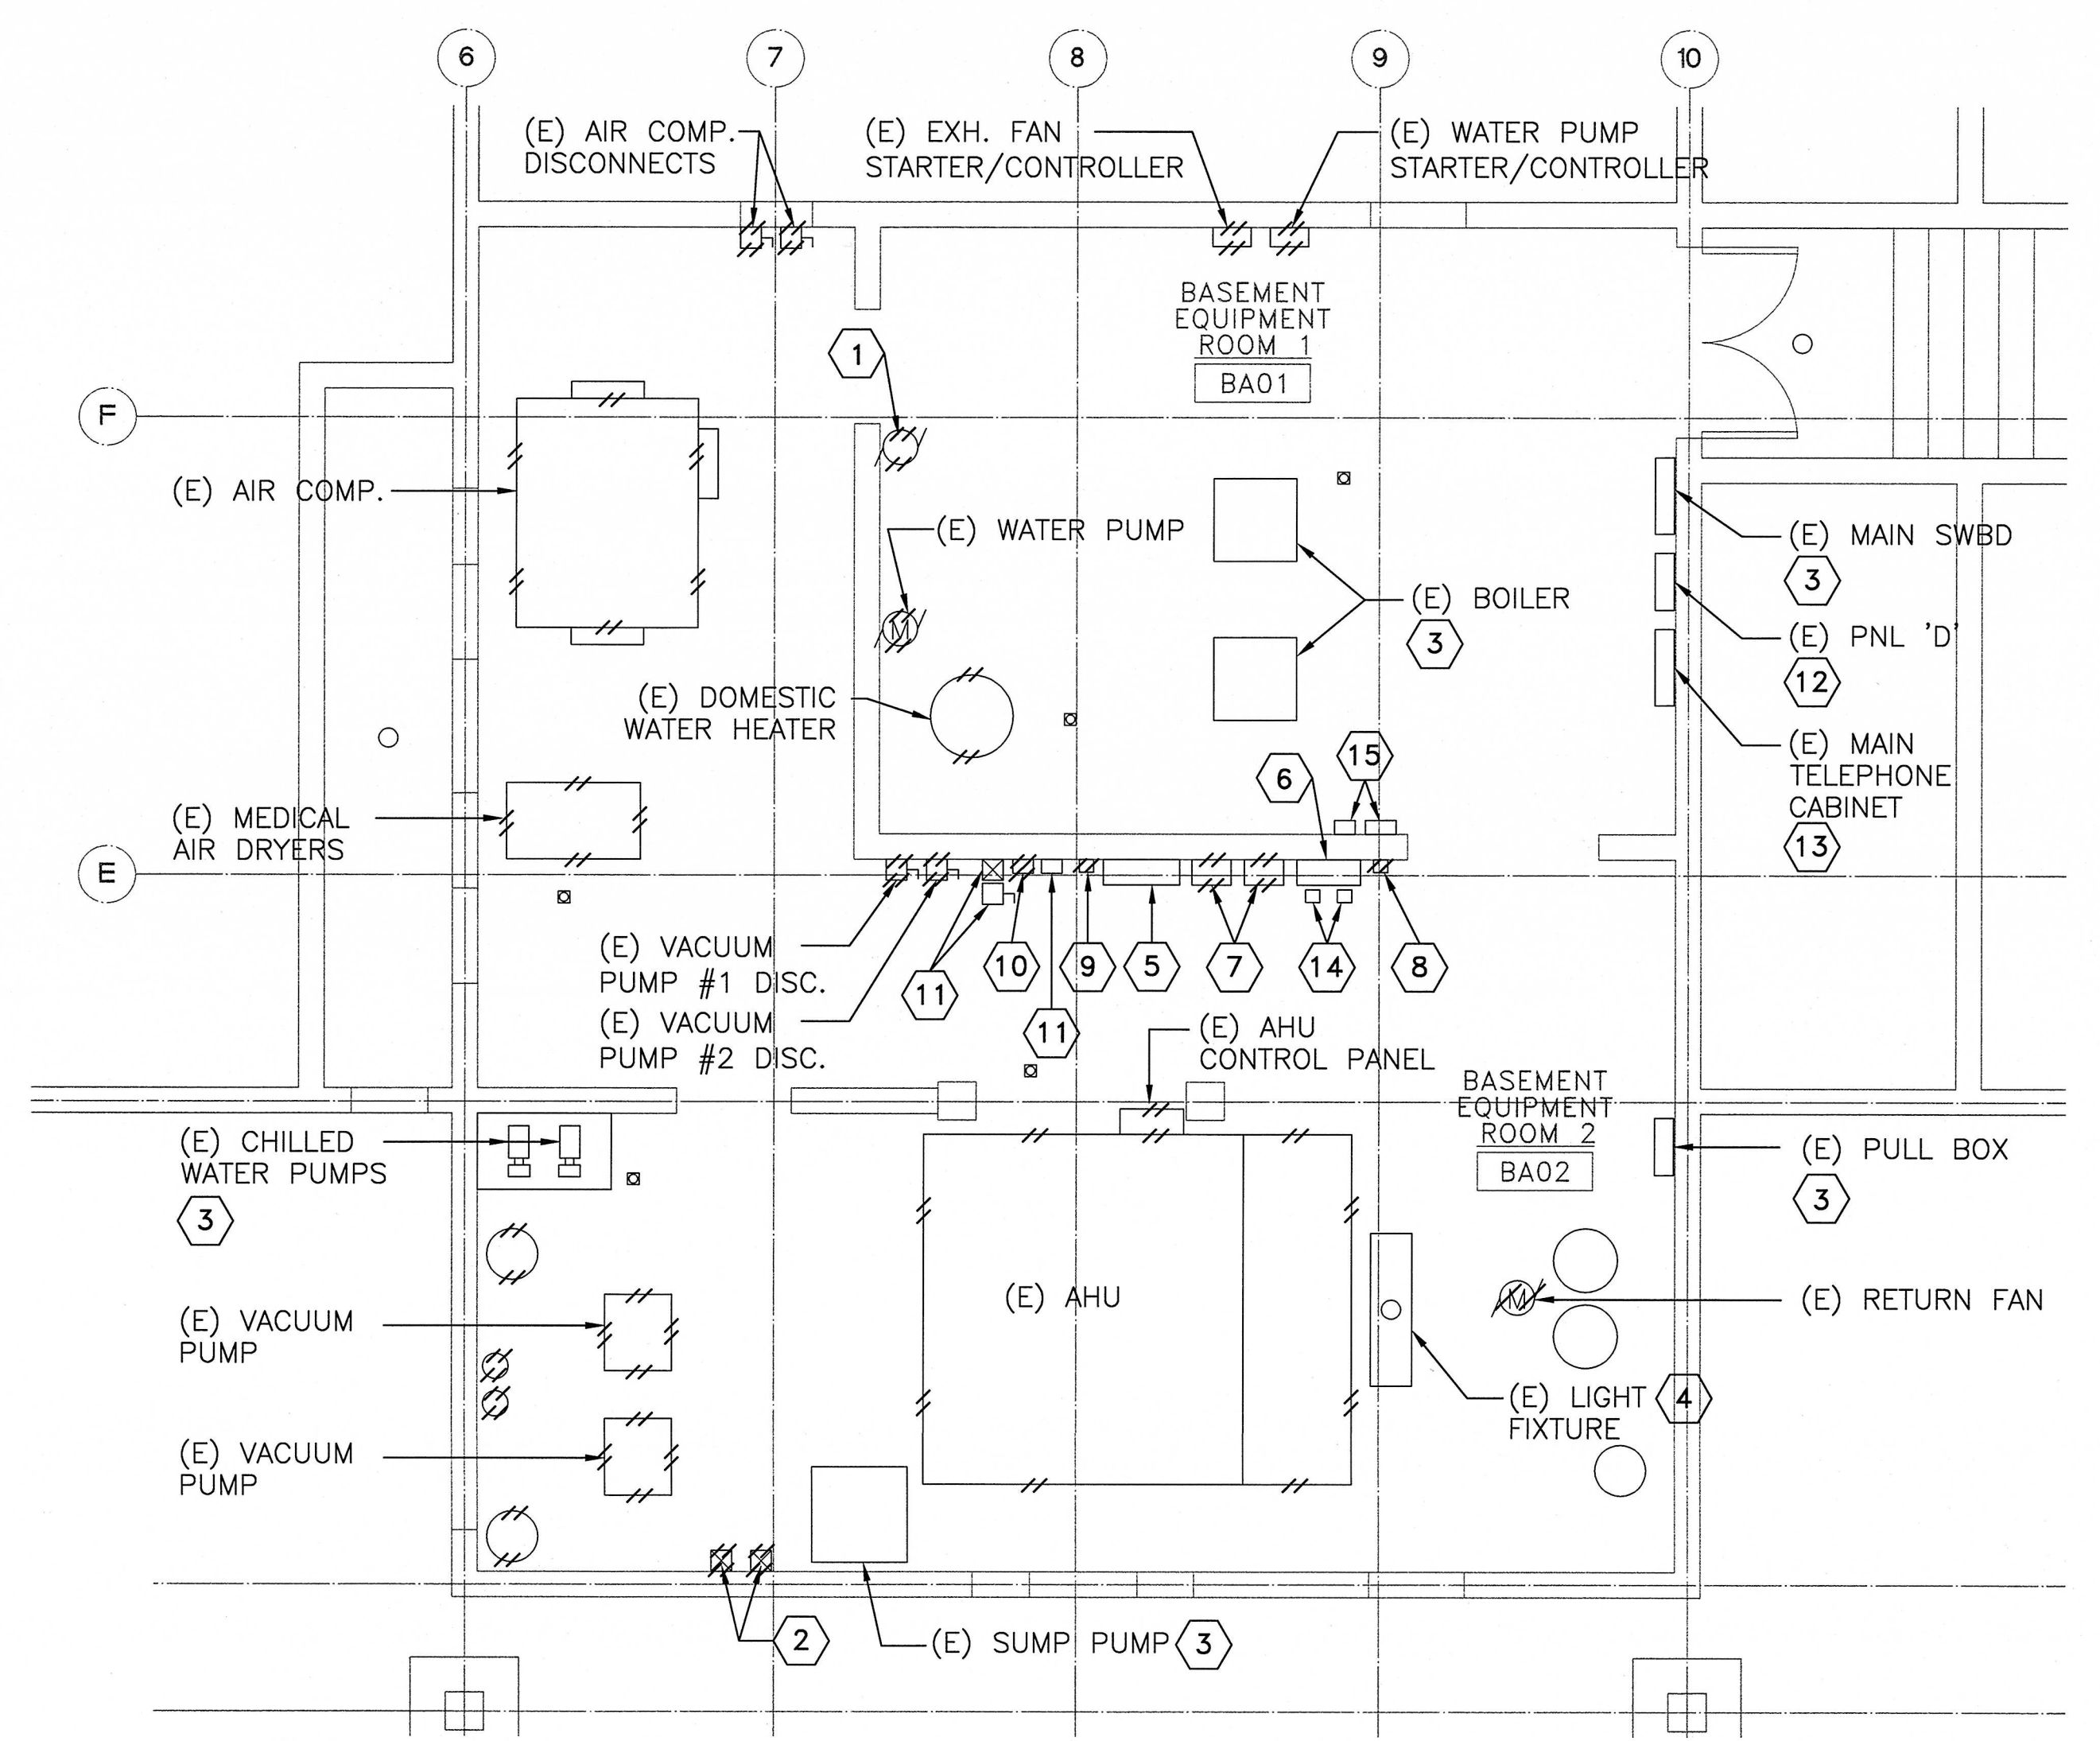

2 ENLARGED BASEMENT PLAN
EP201 SCALE: 1/4" = 1'-0"

GENERAL NOTES

- EQUIPMENT SHOWN IS FOR REFERENCE ONLY AND IN NO WAY REPRESENTS ALL EQUIPMENT AND THEIR EXACT LOCATION. CONTRACTOR IS TO DISCONNECT AND REMOVE ALL ELECTRICAL DEVICES ASSOCIATED WITH EQUIPMENT TO BE DEMOLISHED INCLUDING WIRES, DEVICES, DISCONNECT SWITCHES, STARTERS, J-BOXES, CONDUITS, WIRES ETC. BACK TO THE SOURCE, UNLESS OTHERWISE NOTED. REFER TO MECHANICAL AND PLUMBING DRAWINGS FOR EQUIPMENT DEMOLITION.
- ON WALLS, FLOORS AND CEILINGS, REMOVE EXISTING JUNCTION BOXES AND WIREWAYS THAT ARE NO LONGER IN USE. FOR CONDUITS IN WALLS THAT ARE NO LONGER IN USE, CUT CONDUIT FLUSH WITH SURFACE, CAP AND SEAL. REPAIR SURFACE TO MATCH EXISTING.
- CONTRACTOR IS TO FIELD VERIFY THE EQUIPMENT SOURCE PANELBOARD AND CIRCUIT BEFORE DEMOLITION.

SHEET NOTES

- (E) EXH. FAN DISCONNECT
- (E) STARTER FOR (E) VACUUM PUMP
- EXISTING EQUIPMENT TO REMAIN
- DISCONNECT, REMOVE AND STORE (E) FLUORESCENT LIGHT FIXTURE. FIXTURE TO BE REINSTALLED
- (E) TEMPERATURE CONTROL PANEL TO REMAIN
- (E) JOHNSON CONTROLS METASYS PANEL AND CHILLED WATER HOA SWITCHES TO REMAIN
- (E) AHU HOA SWITCH/STARTER PANEL AND ABANDONED HOA BOX
- (E) EVAPORATOR CONDENSER FAN DISCONNECT SWITCH
- (E) RETURN FAN STARTER/CONTROLLER
- (E) AIR COMPRESSOR SELECTOR SWITCH
- UNKNOWN EQUIPMENT TO REMAIN
- DISCONNECT AND REMOVE (E) PANEL. PANEL TO BE REPLACED WITH NEW. SEE PANEL SCHEDULE DWGS. FOR ADDITIONAL DETAILS
- DISCONNECT & REPLACE (E) MAIN TELEPHONE CABINET AND TELECOMMUNICATION CABLE. (E) CONDUITS TO REMAIN AND TO BE RECONNECTED TO (N) TELECOMMUNICATION CABINET. REMOVE ABANDONED WIRES THAT ARE NO LONGER IN USE
- (E) STARTER/CONTROLLER FOR CHILLED WATER PUMP TO REMAIN
- ABANDONED F/A CONTROL PANEL AND DEVICES, SEE F/A DWG FOR DEMOLITION

Revisions	Date	CONSULTANTS:		ARCHITECT/ENGINEERS:		Drawing Title	Project Title	Project Number	Office of Facilities Management
						BASEMENT MECHANICAL ELECTRICAL DEMOLITION PLAN	DESIGN OF BUILD BACK BLDG 88 McCLELLAN	612-12-288	
						Approved: Project Director	Location	Building Number	
							McCLELLAN, CA	MCC-88	
				Date	Checked	Drawn	Drawing Number		
				09/12/2012	PCM	RMK/MSA	EP201		
							Dwg. 58 of 73		