


GENERAL NOTES


SHEET NOTES

- EQUIPMENT SHOWN WITHIN BOUNDARY SHALL BE PROVIDED BY EQUIPMENT MANUFACTURER

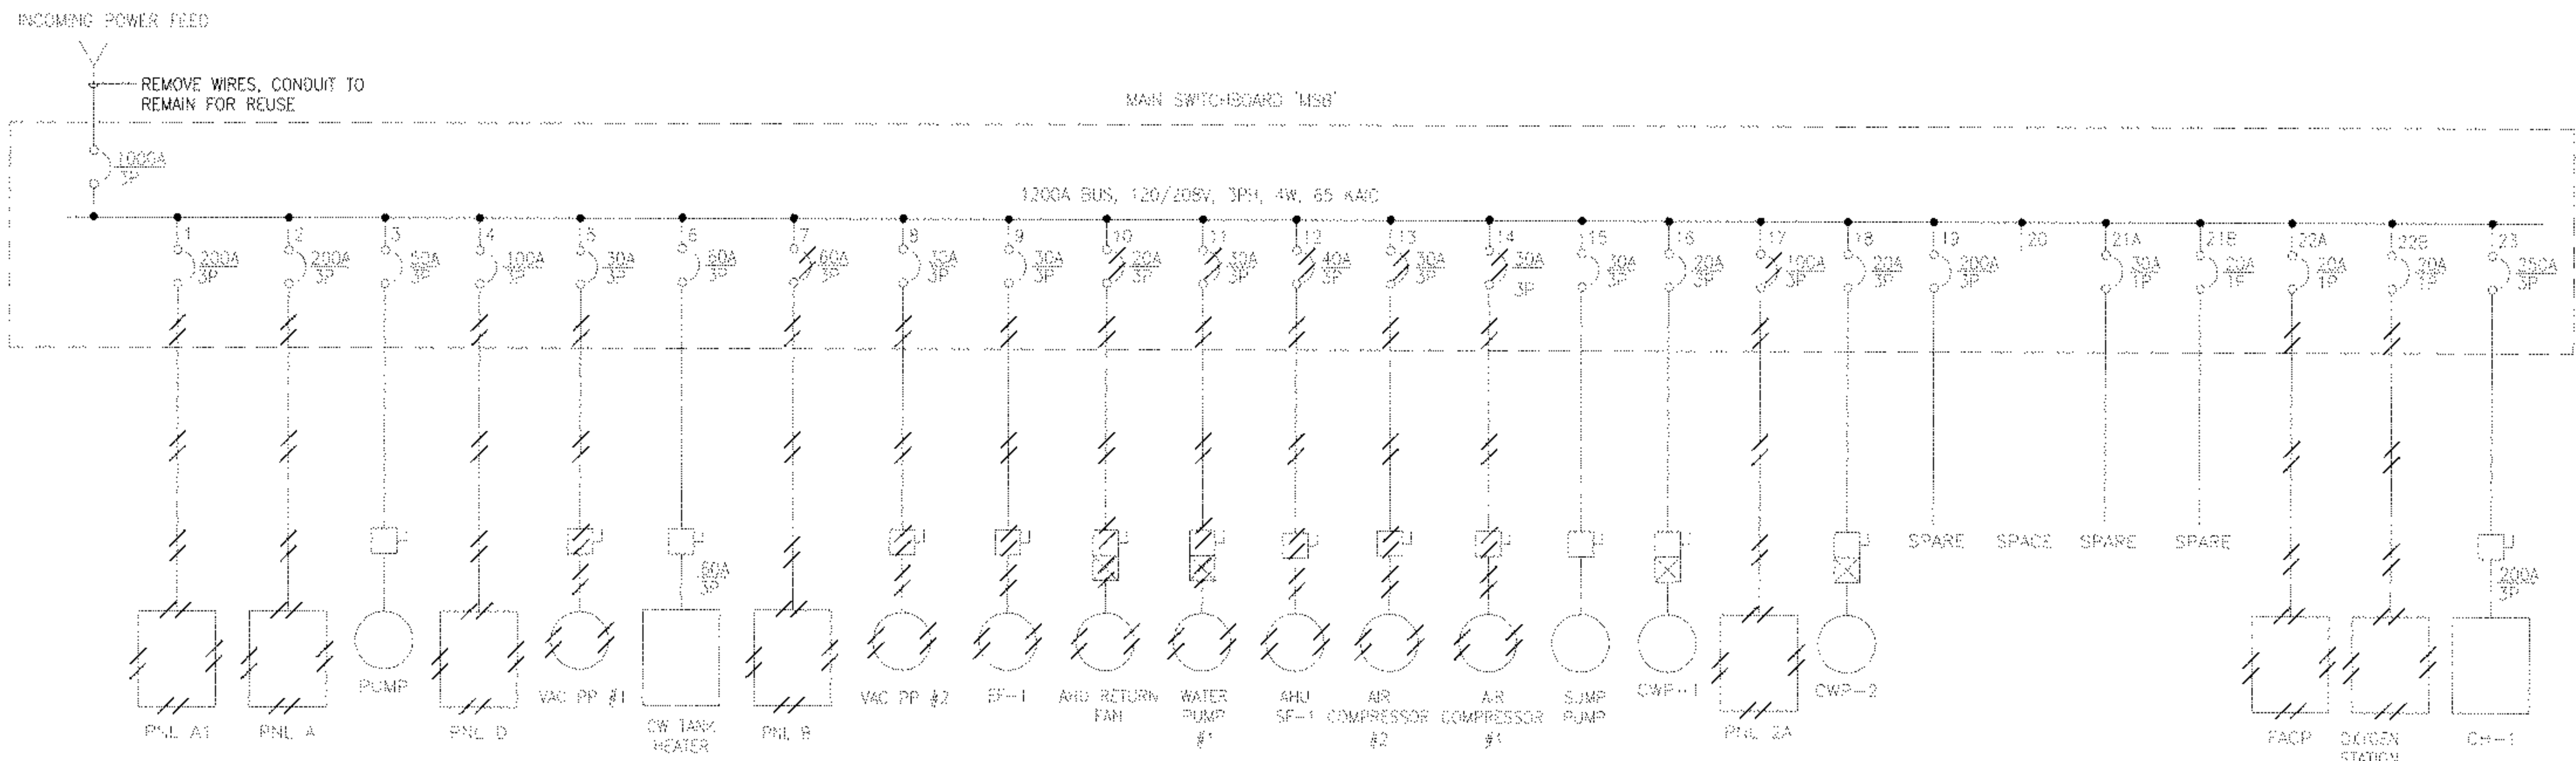

EXISTING MAIN SWITCHBOARD - SINGLE LINE DIAGRAM

SCALE: NONE

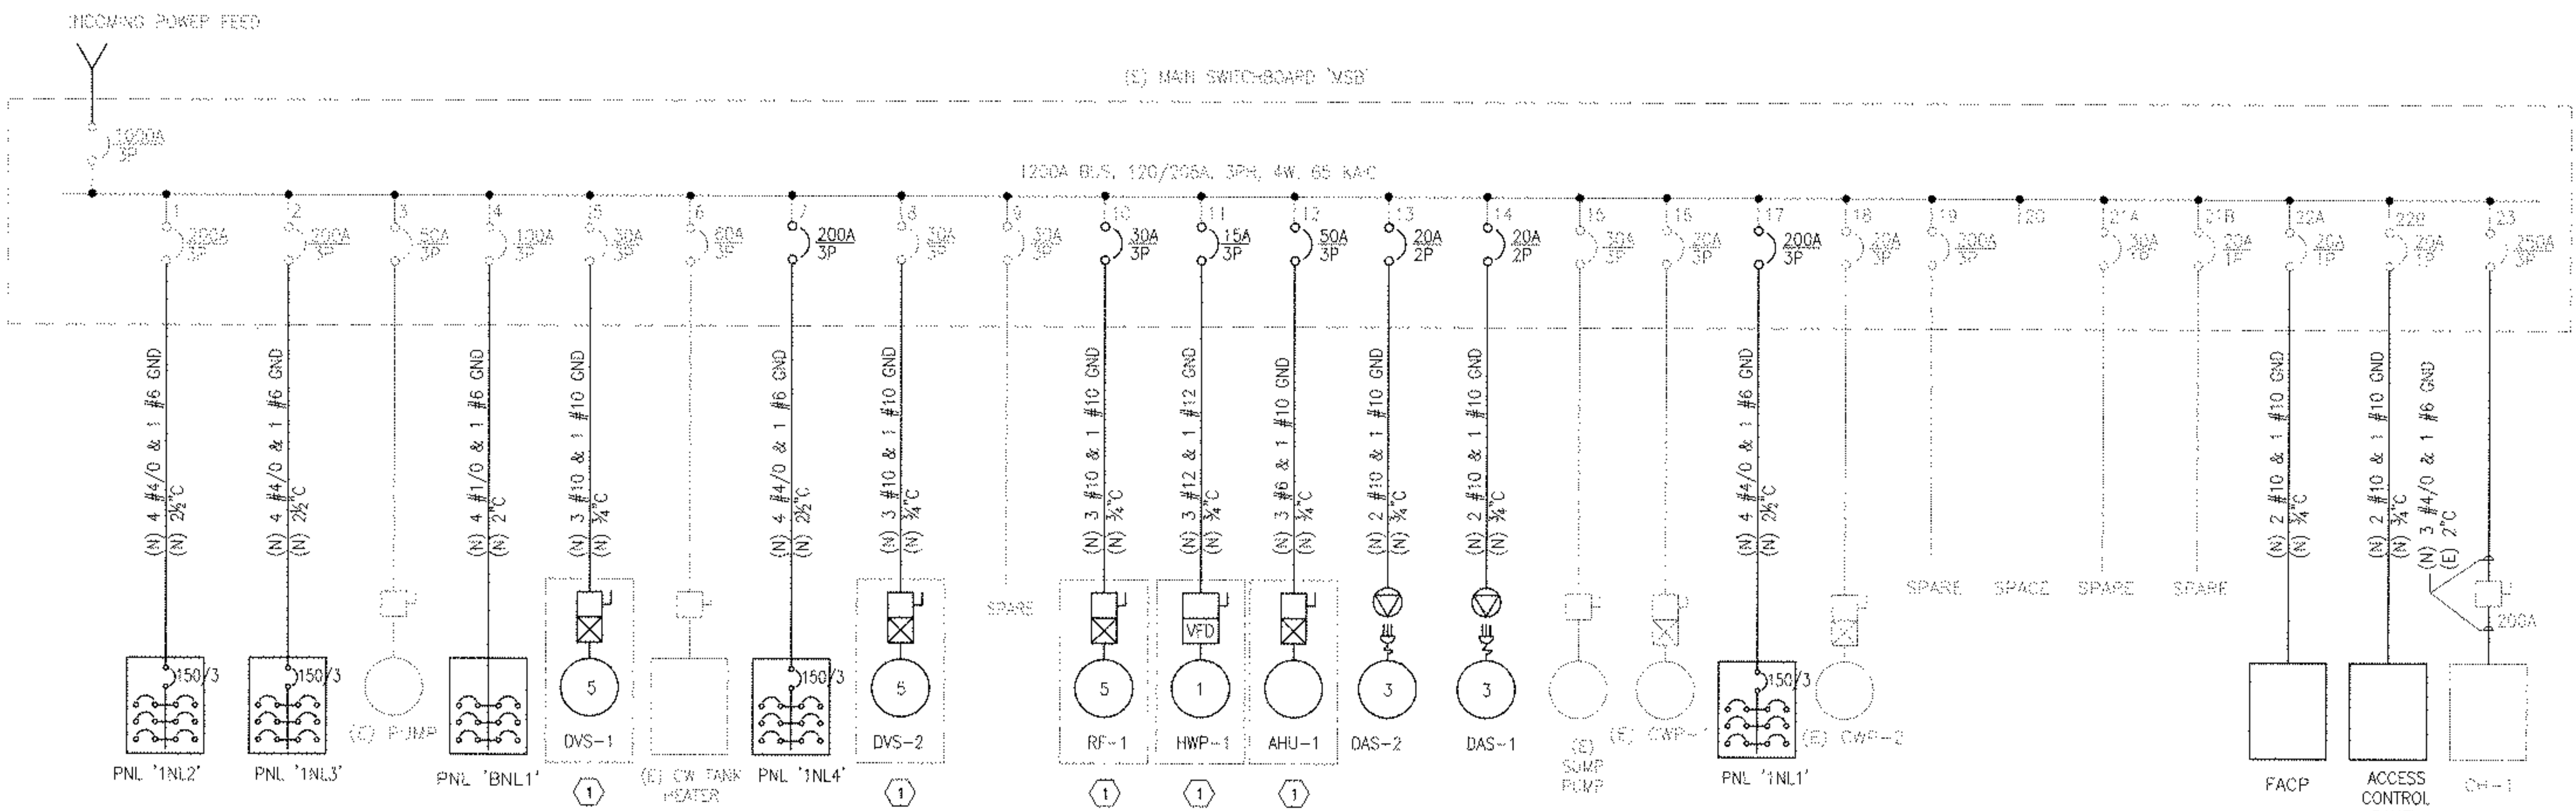

NEW WORK- SINGLE LINE DIAGRAM

SCALE: NONE

CONSULTANTS:

ARCHITECT/ENGINEERS:

Drawing Title

SINGLE LINE DIAGRAM

Approved Project Director

Project Title

DESIGN OF BUILD BACK
BLDG 88 McCLELLAN

Location

McCLELLAN, CA

Date

09/12/2012

Checked

PCM

Drawn

MSA

Project Number

612-12-288

Building Number

MCC-88

Drawing Number

EP801

Dwg 68 of 73

Office of
Facilities
Management

Department of
Veterans Affairs

