



one-eighth inch = one foot  
one-quarter inch = one foot  
one-half inch = one foot  
three-eighths inch = one foot  
one inch = one foot  
one and one-half inch = one foot  
three inches = one foot

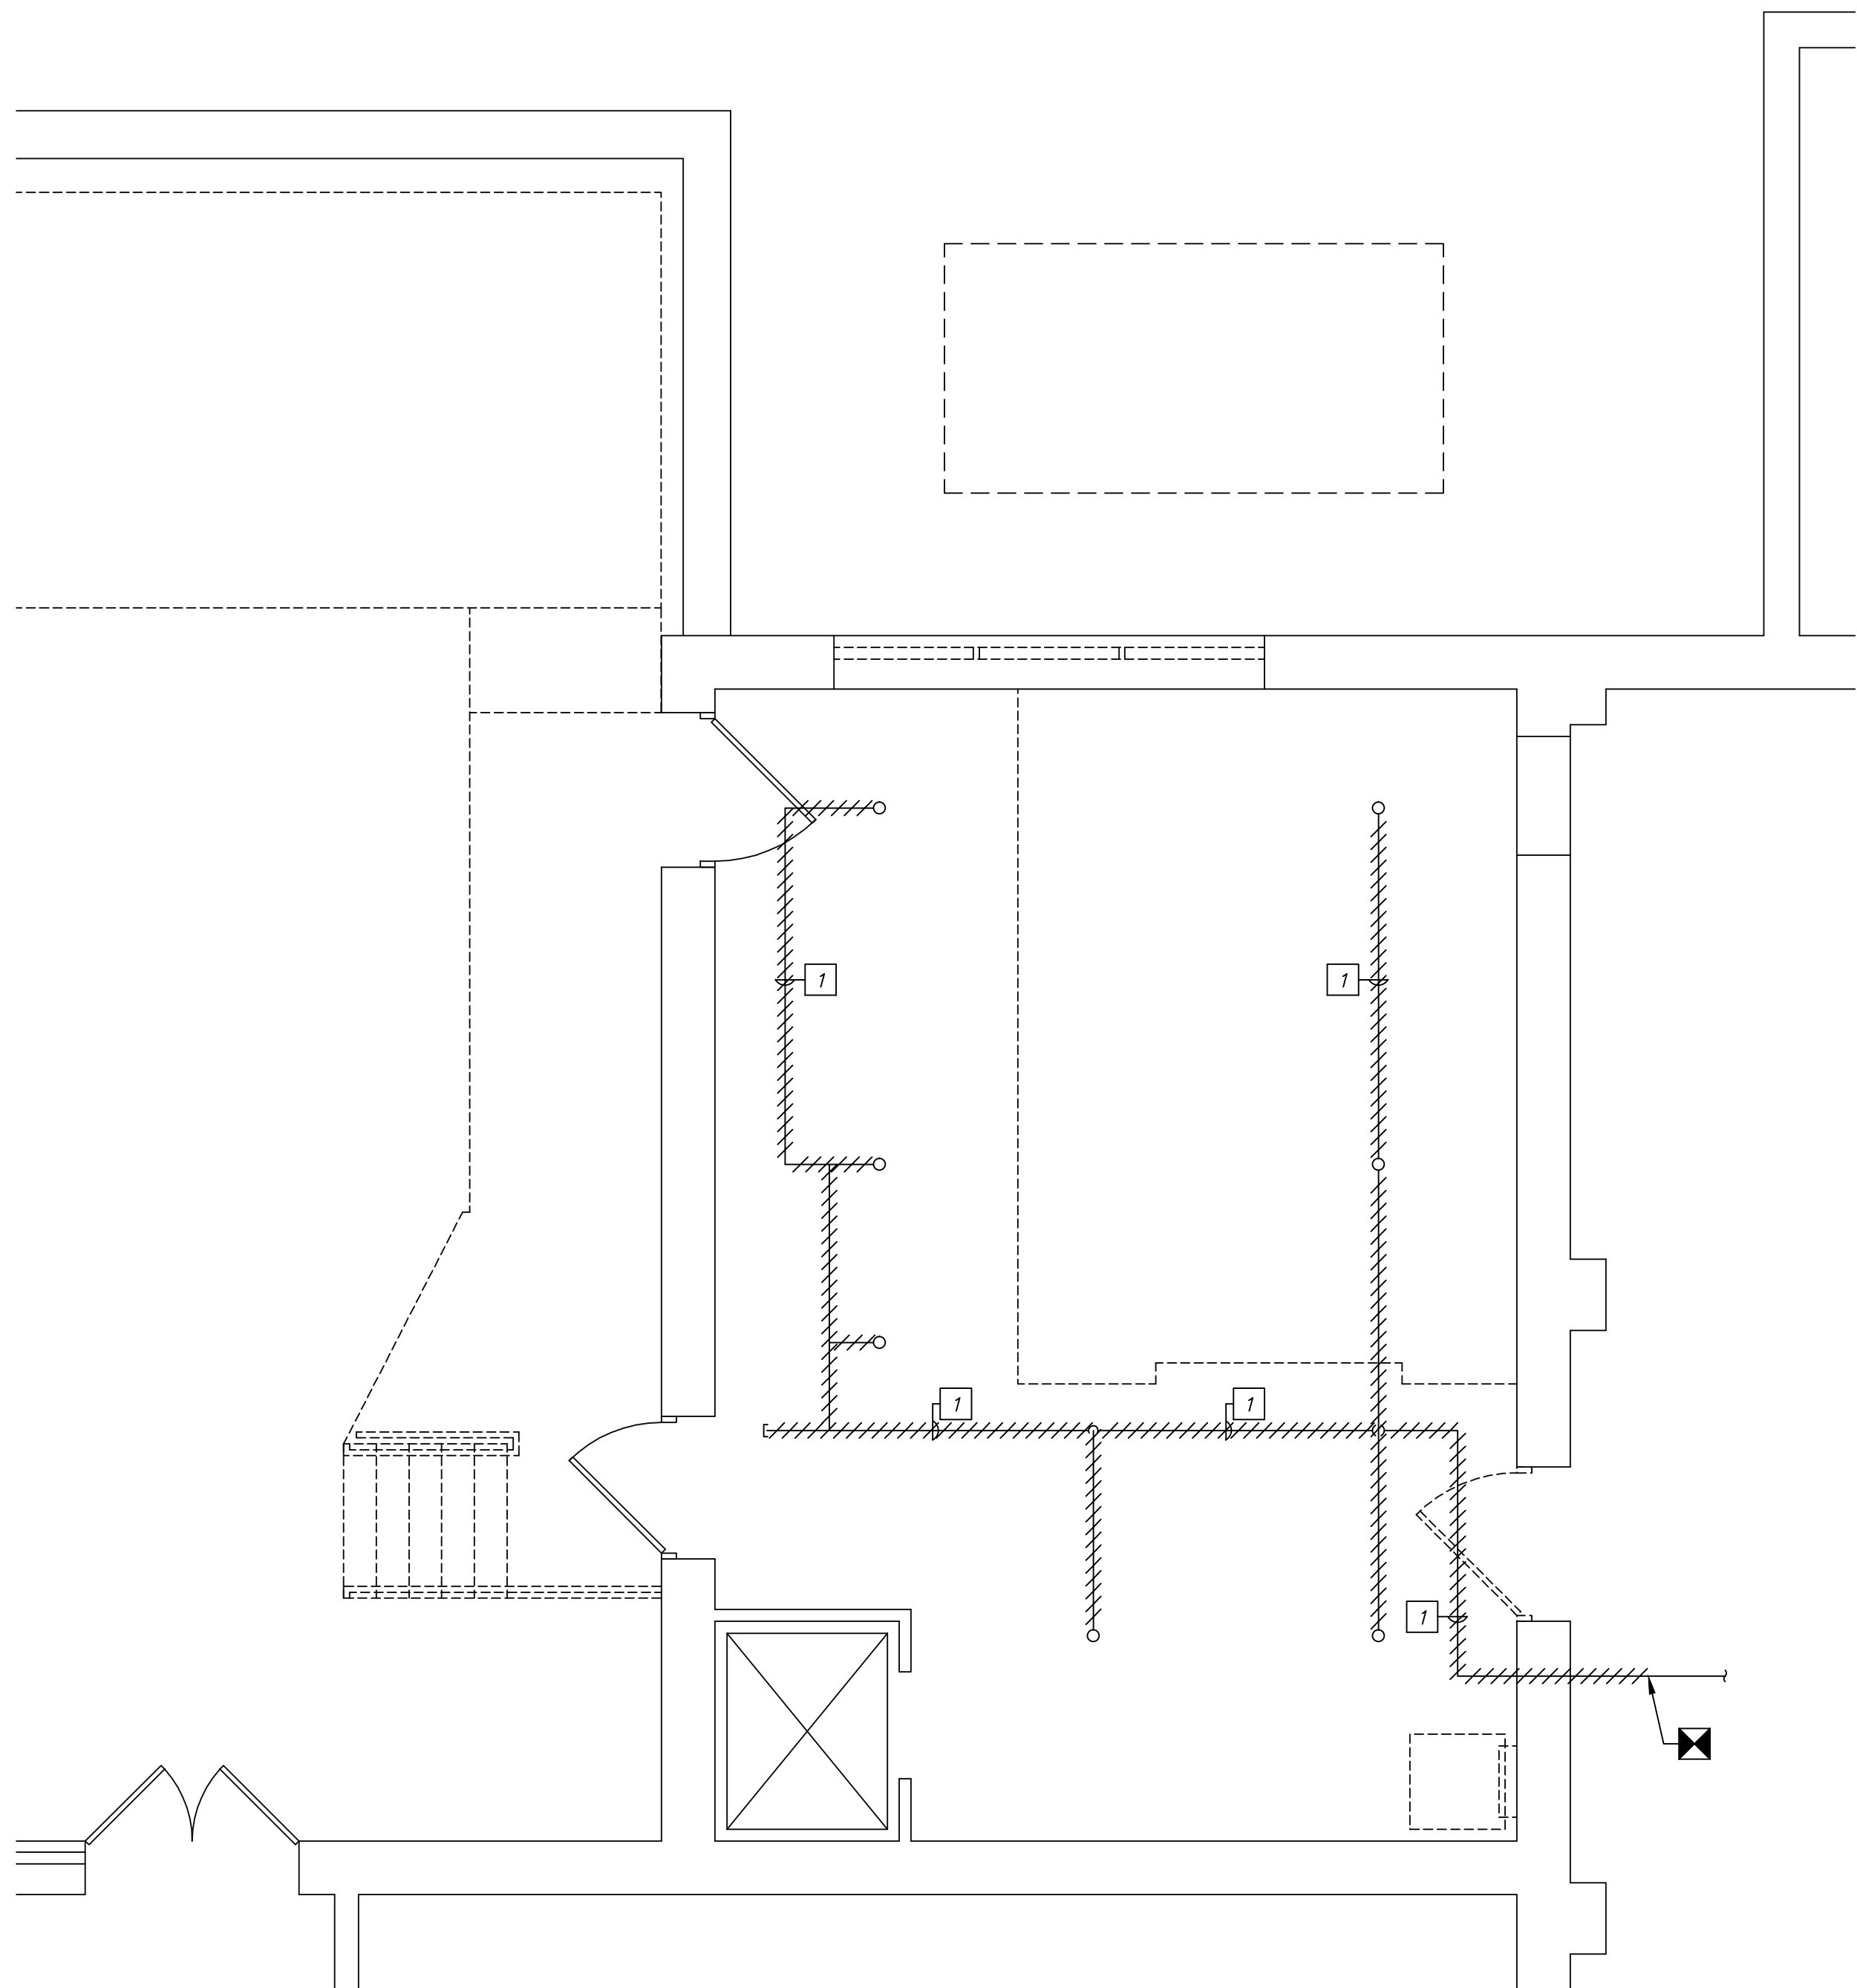

1  
FP101


BASEMENT FLOOR PLAN - FIRE PROTECTION REMOVALS

SCALE: 1/4" = 1'-0"

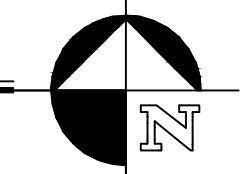


REMOVAL NOTES:

1 REMOVE SPRINKLER PIPING AND SPRINKLERS TO THE ACTIVE MAIN AND CAP.

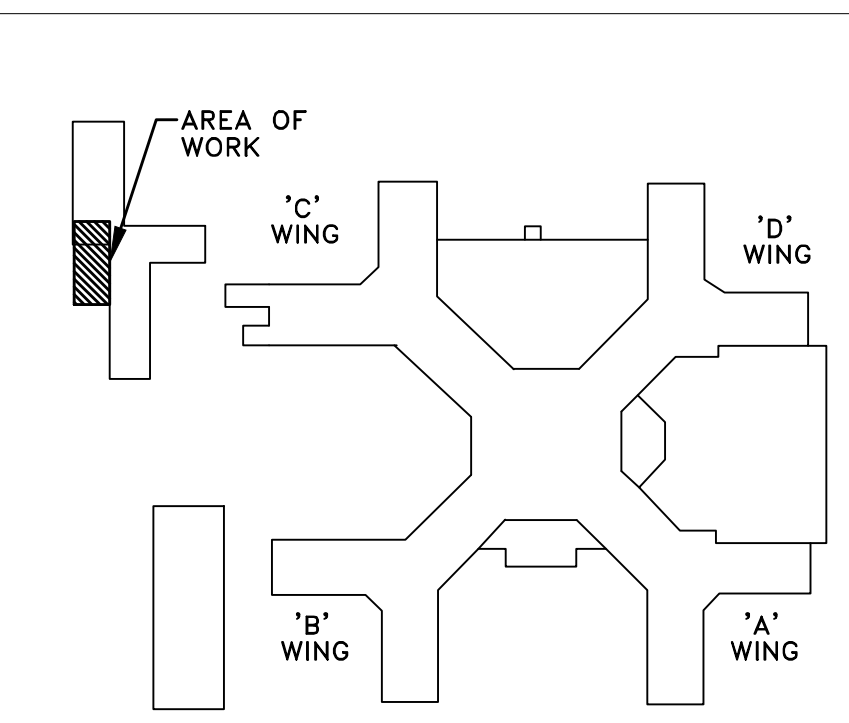


KEY PLAN

SCALE: NONE

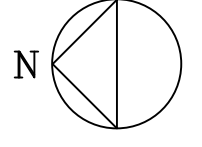

<div>ISSUED FOR BID</div> <div>Revisions</div>		<div>02-15-13</div> <div>Date</div>	<div>VA WESTERN NEW YORK HEALTHCARE SYSTEM</div> <div>3495 BAILEY AVENUE</div> <div>BUFFALO, NEW YORK 14215</div>	<div><b>EC4B</b></div> <div>Engineering, P.C.</div> <div>15 Schoen Place</div> <div>Suite 300</div> <div>Buffalo, NY 14204</div> <div>Phone: (585) 641-7121</div> <div>Fax: (585) 362-4175</div> <div>www.ec4b.com</div>	<div>Consultant</div>	<div>stamp</div>	<div><b>Altamira</b></div> <div>Altamira Architectural Consulting</div> <div>1260 Scottsville Road, Suite 202</div> <div>Rochester, New York 14624</div> <div>585-473-0659</div> <div>fax: 585-271-2679</div> <div>email: Altamira@frontiernet.net</div>	<div>Architect / Engineer</div>	<div>CARDIOLOGY MANAGER</div> <div>INFECTION CONTROL</div> <div>SAFETY OFFICER</div>	<div>DATE</div> <div>DATE</div> <div>DATE</div>	<div>ENGINEERING MANAGER</div> <div>CARELINE MANAGER</div> <div>CHIEF OF STAFF</div>	<div>DATE</div> <div>DATE</div> <div>DATE</div>	<div>Drawing Title</div> <div>BASEMENT FLOOR PLAN -</div> <div>FIRE PROTECTION REMOVALS</div>	<div>Project Title</div> <div>MEDICAL WASTE TRAILER</div>	<div>Building Number</div> <div>6</div>	<div>Checked</div> <div>AJW</div>	<div>Drawn</div> <div>WAB</div>	<div>Date</div> <div>February 15, 2013</div>	<div>Station No.</div> <div>528-12-102</div>	<div>09-372-FP101</div>	<div>Office of Facilities</div>	<div>Department of Veterans Affairs</div>
--	--	-------------------------------------	---	--	-----------------------	------------------	--	---------------------------------	--	---	--	---	---	---	---	-----------------------------------	---------------------------------	--	--	-------------------------	---------------------------------	---


one-eighth inch = one foot  
one-quarter inch = one foot  
three-eighths inch = one foot  
one-half inch = one foot  
three-quarters inch = one foot  
one inch = one foot  
one and one-half inch = one foot  
three inches = one foot  
A  
B  
C  
D  
E  
F

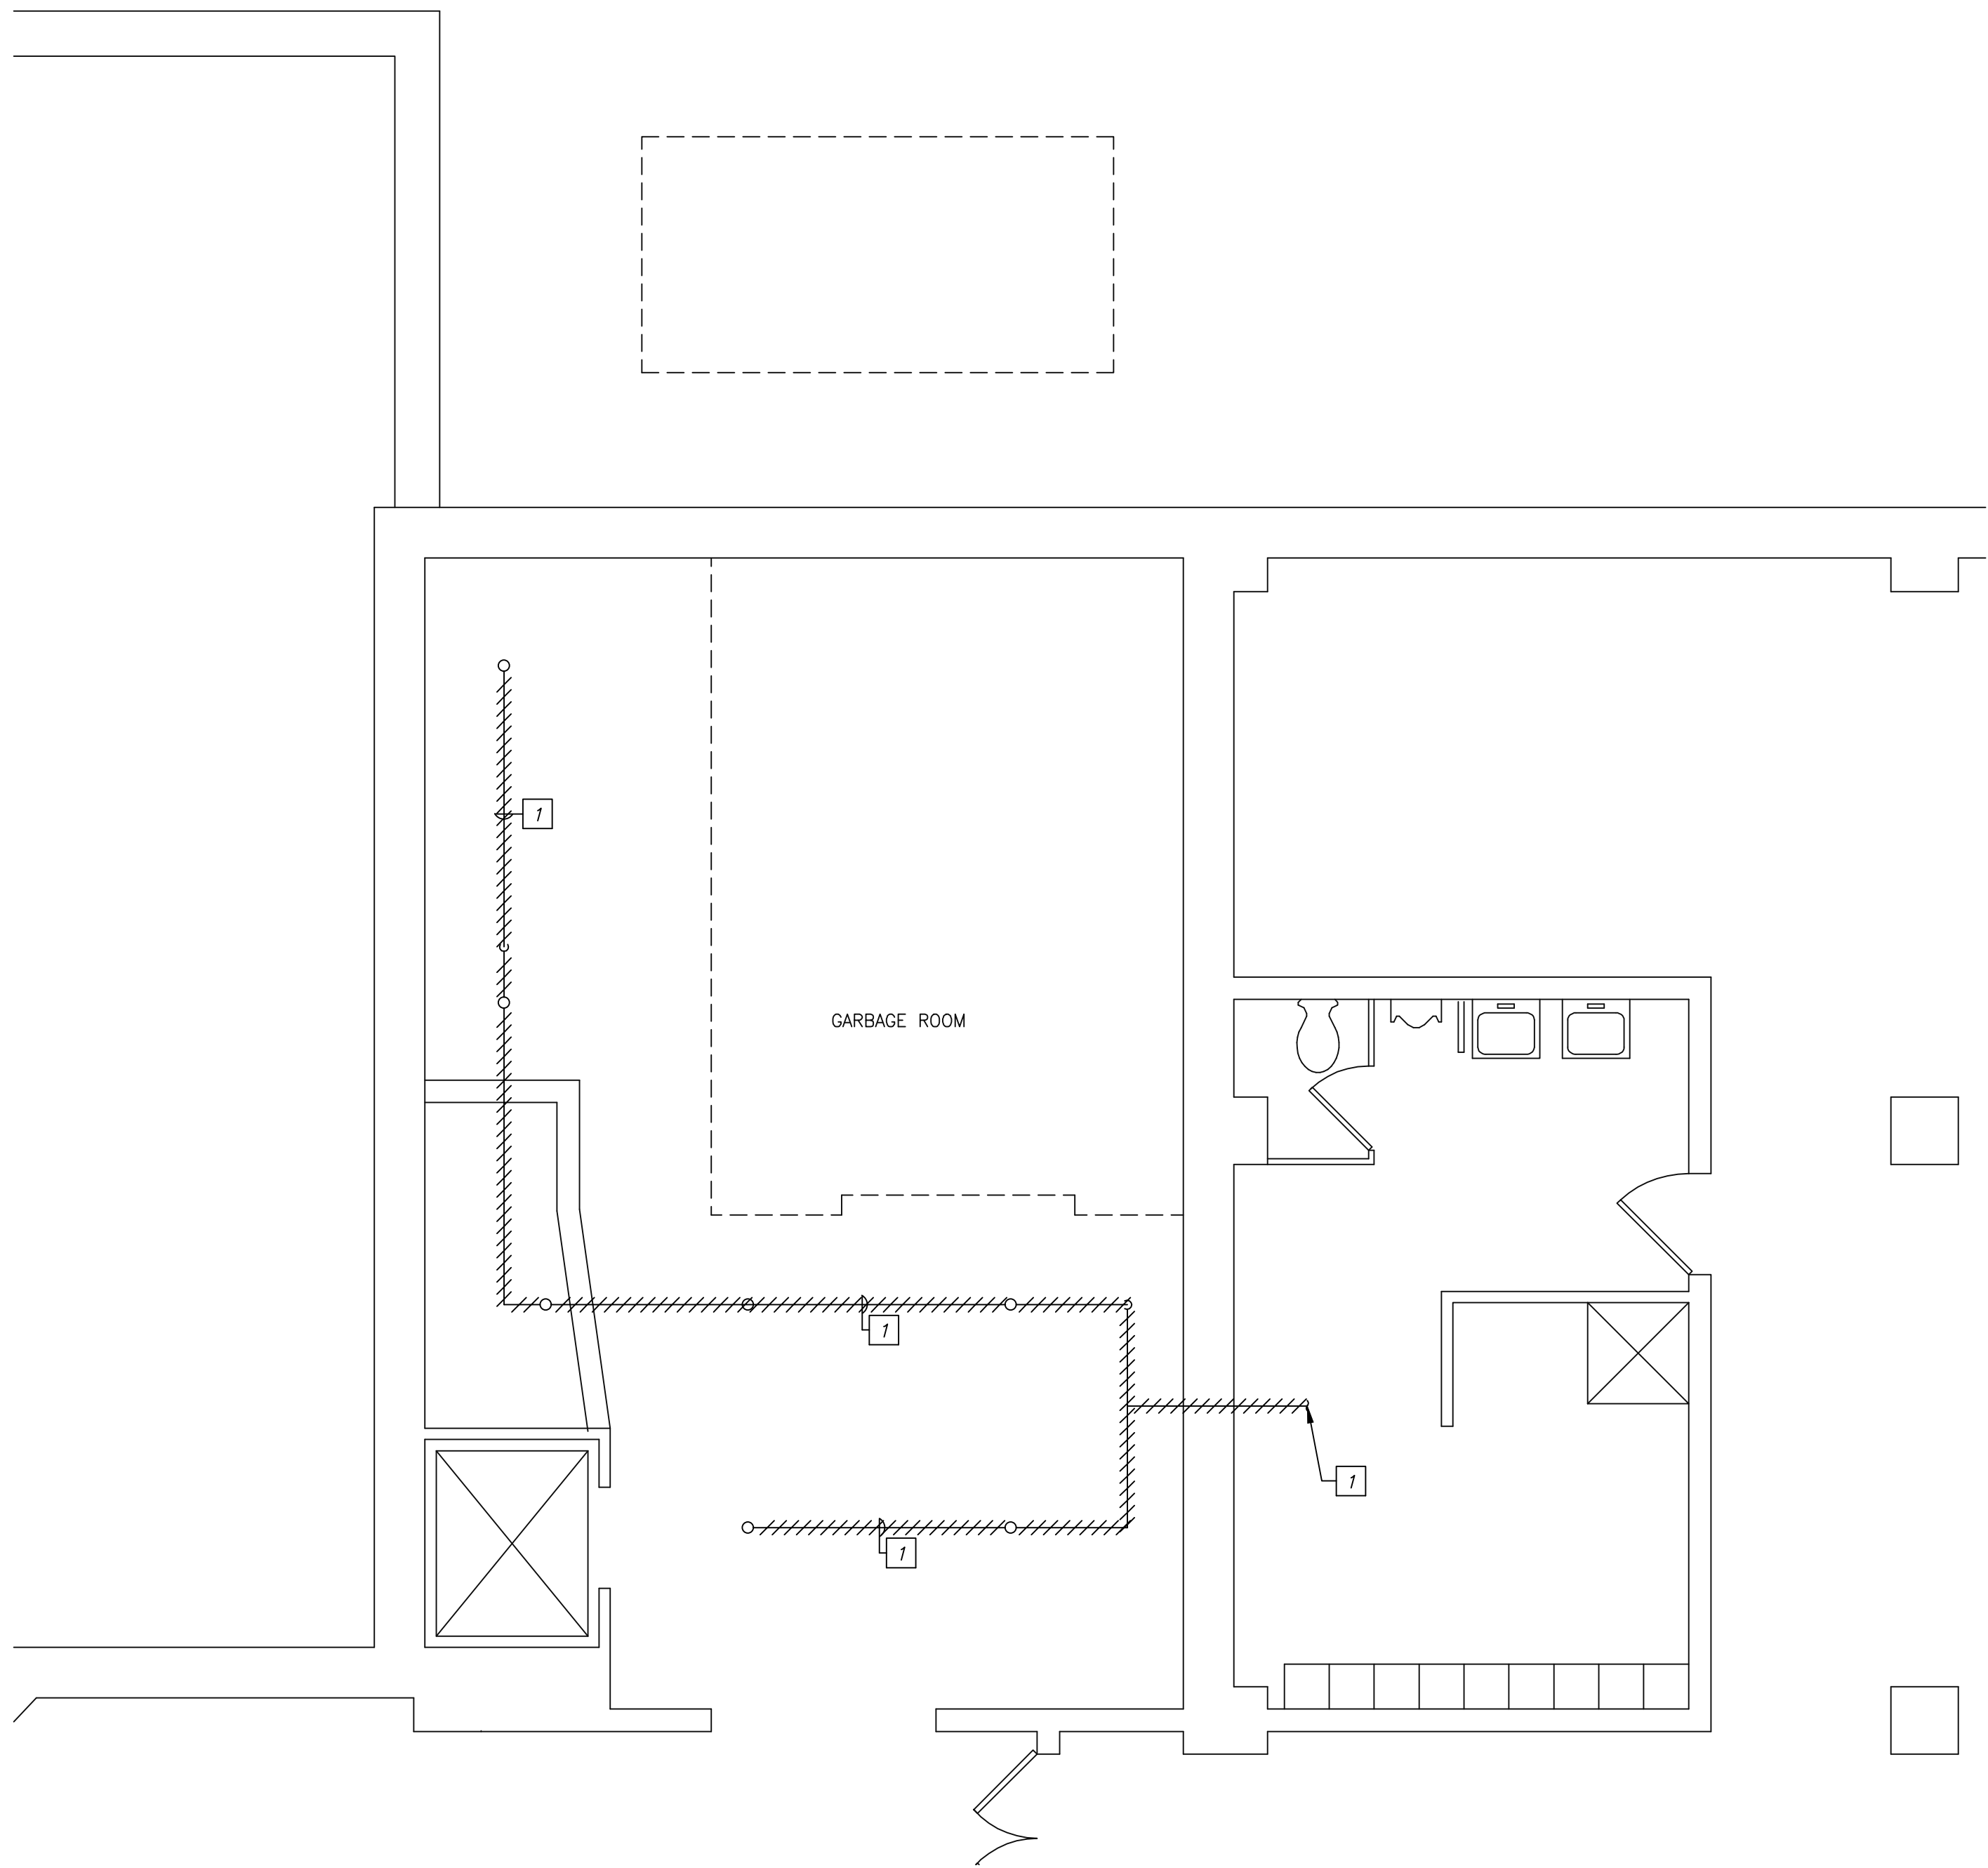

1  
FP102


SUB-BASEMENT FLOOR PLAN - FIRE PROTECTION REMOVALS

SCALE: 1/4" = 1'-0"

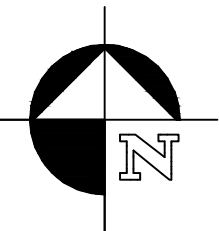


REMOVAL NOTES:

1 REMOVE SPRINKLER PIPING AND SPRINKLERS TO THE ACTIVE MAIN AND CAP.

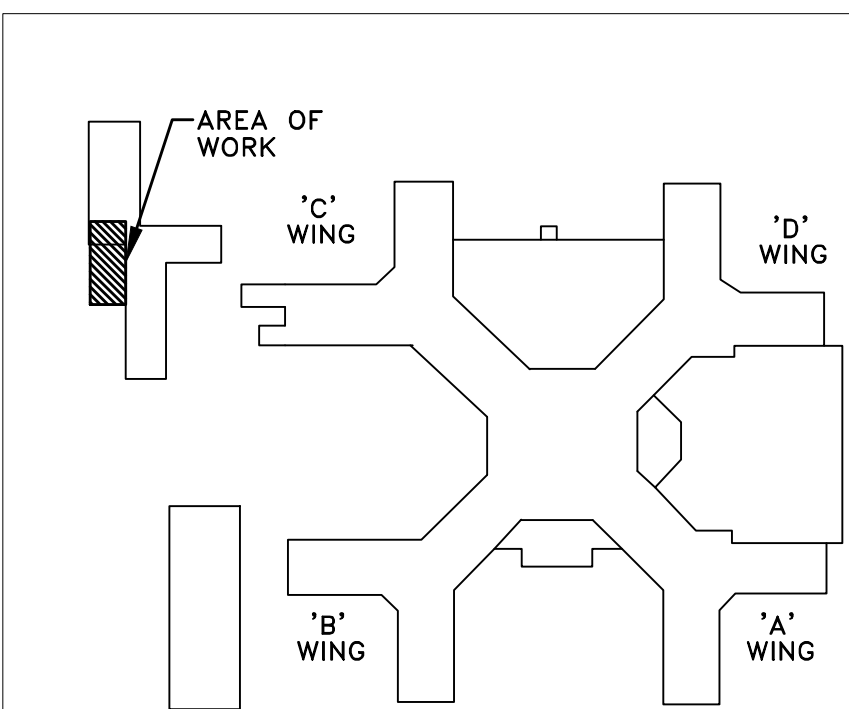

KEY PLAN  
SCALE: NONE

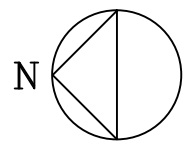

ISSUED FOR BID	02-15-13
Revisions	Date

VA WESTERN NEW YORK HEALTHCARE SYSTEM  
3495 BAILEY AVENUE  
BUFFALO, NEW YORK 14215



Consultant

stamp



Architect / Engineer

CARDIOLOGY MANAGER

DATE

ENGINEERING MANAGER

DATE

INFECTION CONTROL

DATE

CARELINE MANAGER

DATE

SAFETY OFFICER

DATE

CHIEF OF STAFF

DATE

Drawing Title

SUB-BASEMENT FLOOR PLAN -  
FIRE PROTECTION REMOVALS

Project Title

MEDICAL WASTE TRAILER

Building Number

6

Checked

AJW

Drawn

WAB

Location

V.A.M.C. BUFFALO, NEW YORK

Date

February 15, 2013


Station No.

52B-12-102


09-372-FP102



one-eighth inch = one foot  
one-quarter inch = one foot  
three-eighths inch = one foot  
one-half inch = one foot  
three-quarters inch = one foot  
one inch = one foot  
one and one-half inch = one foot  
three inches = one foot  
A  
B  
C  
D  
E  
F

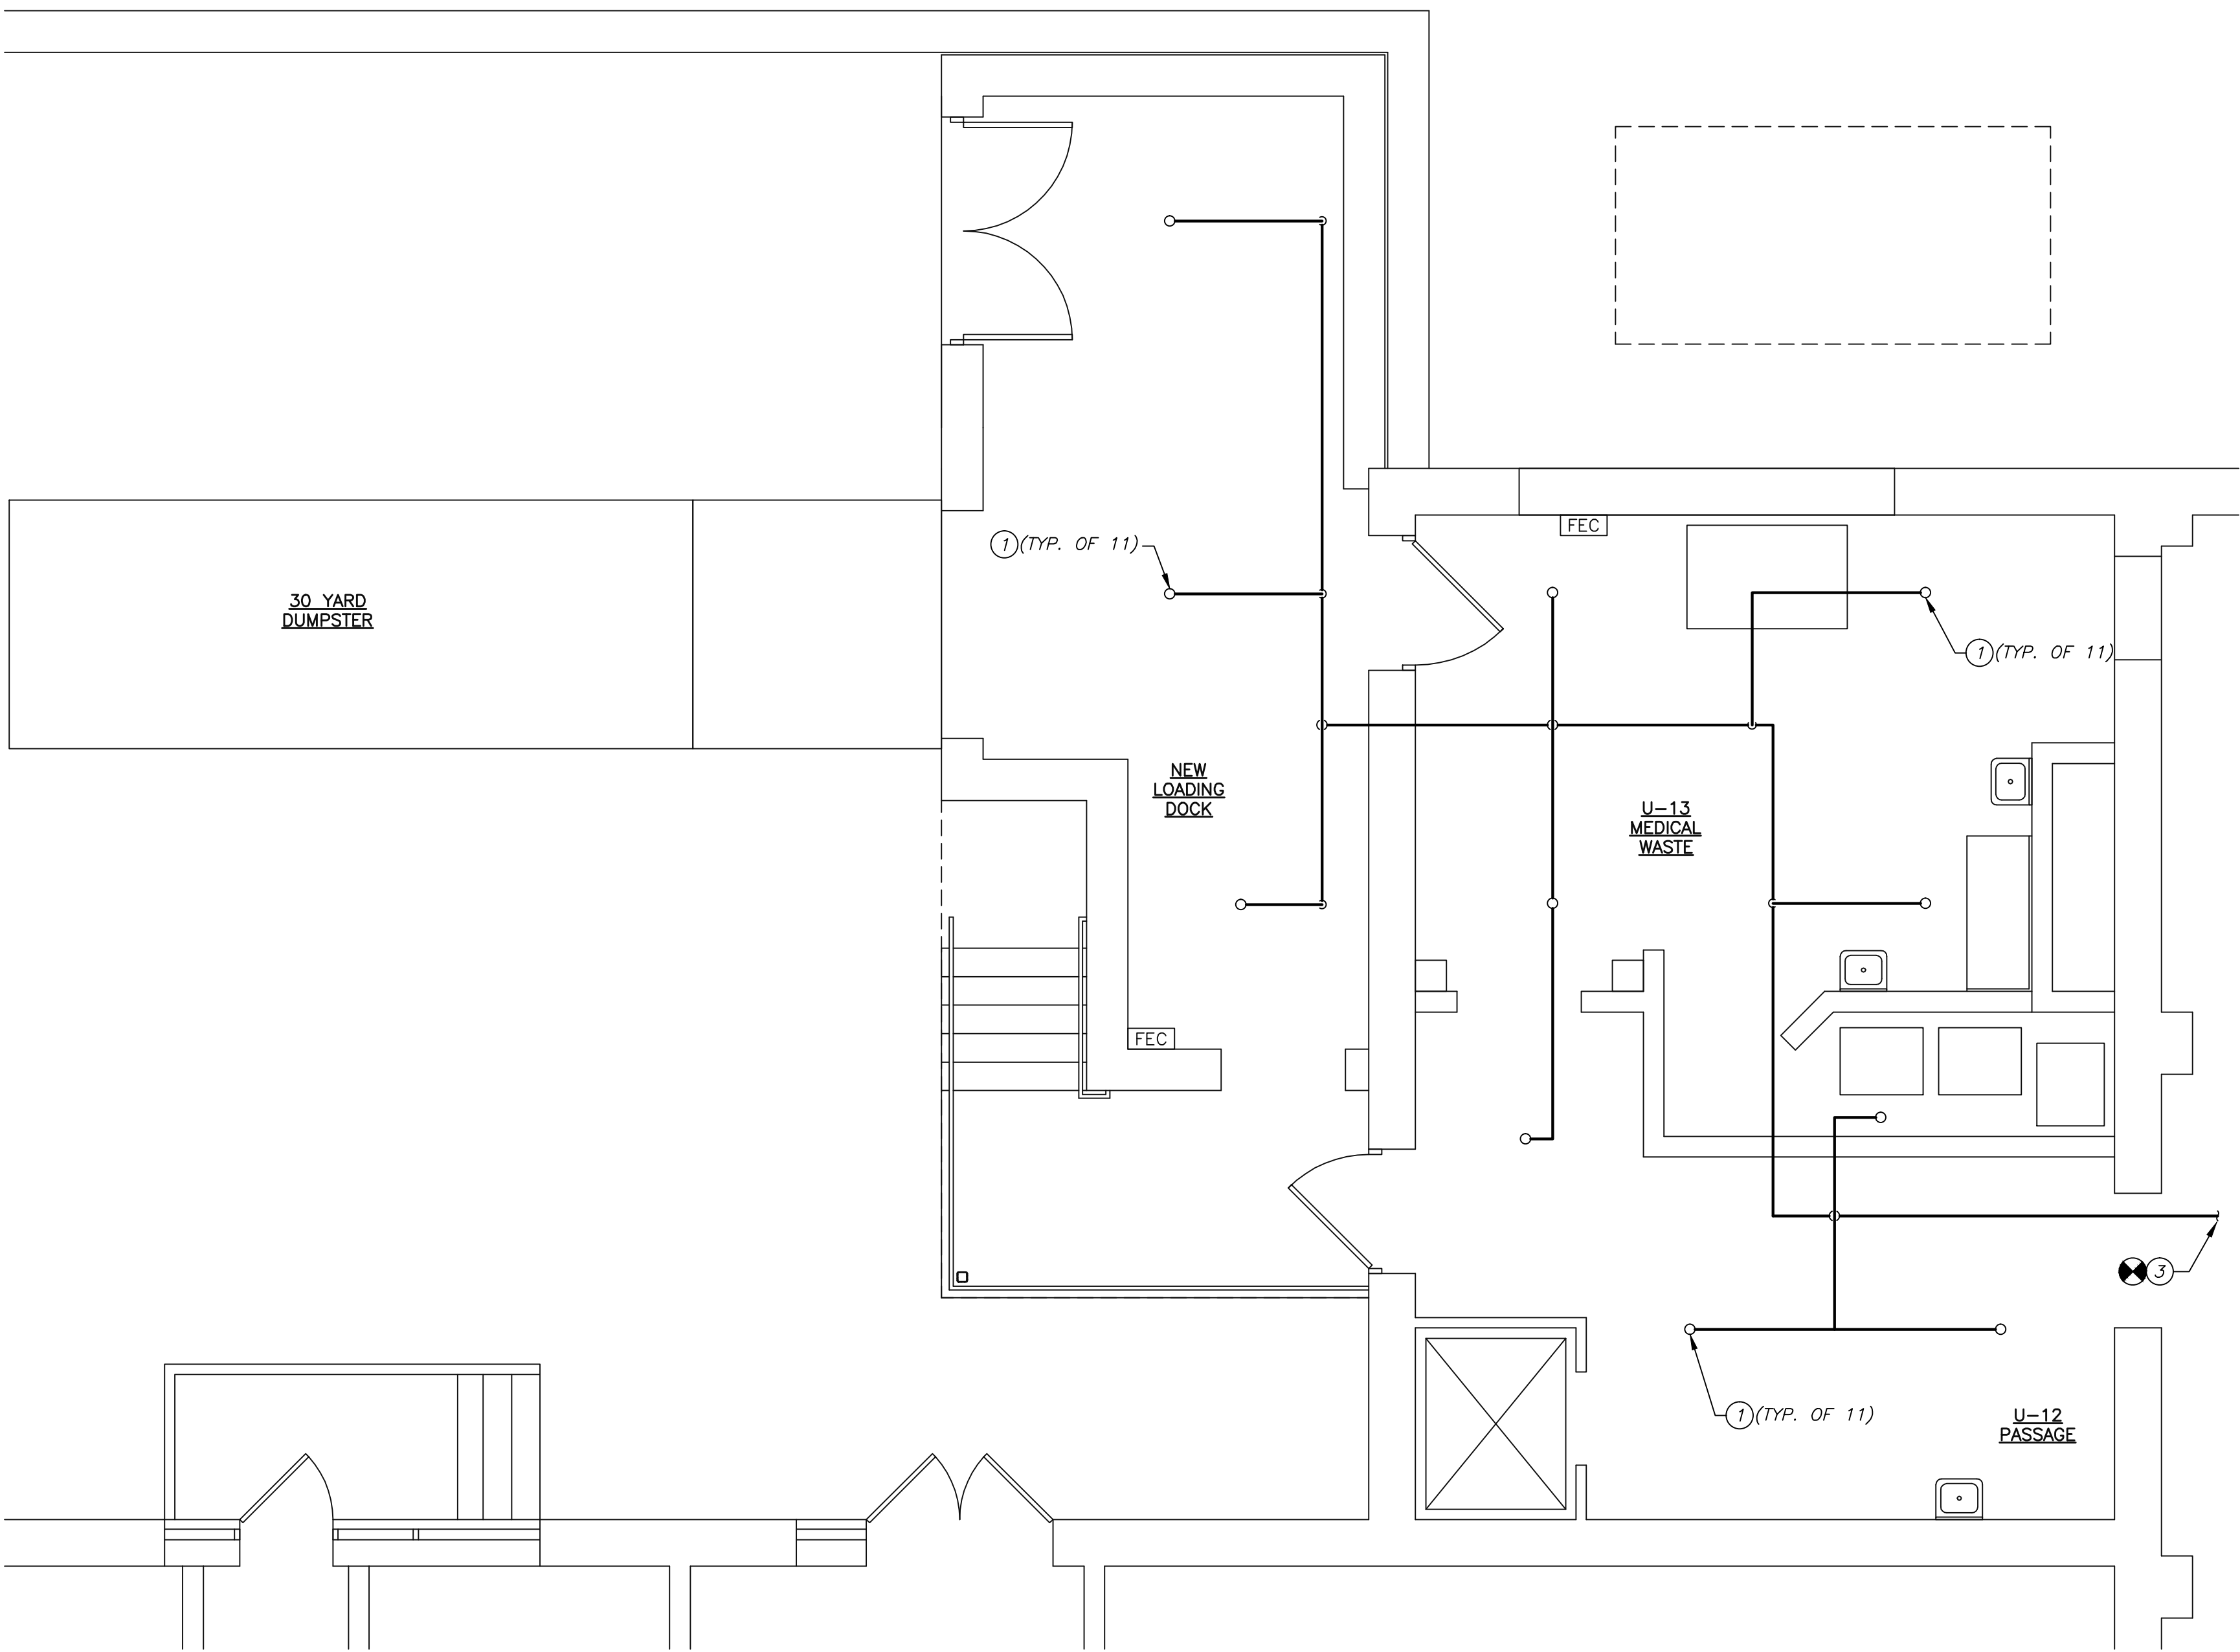


1  
FP201  
BASEMENT FLOOR PLAN - FIRE PROTECTION  
NEW WORK - BASE BID  
SCALE: 1/4" = 1'-0"

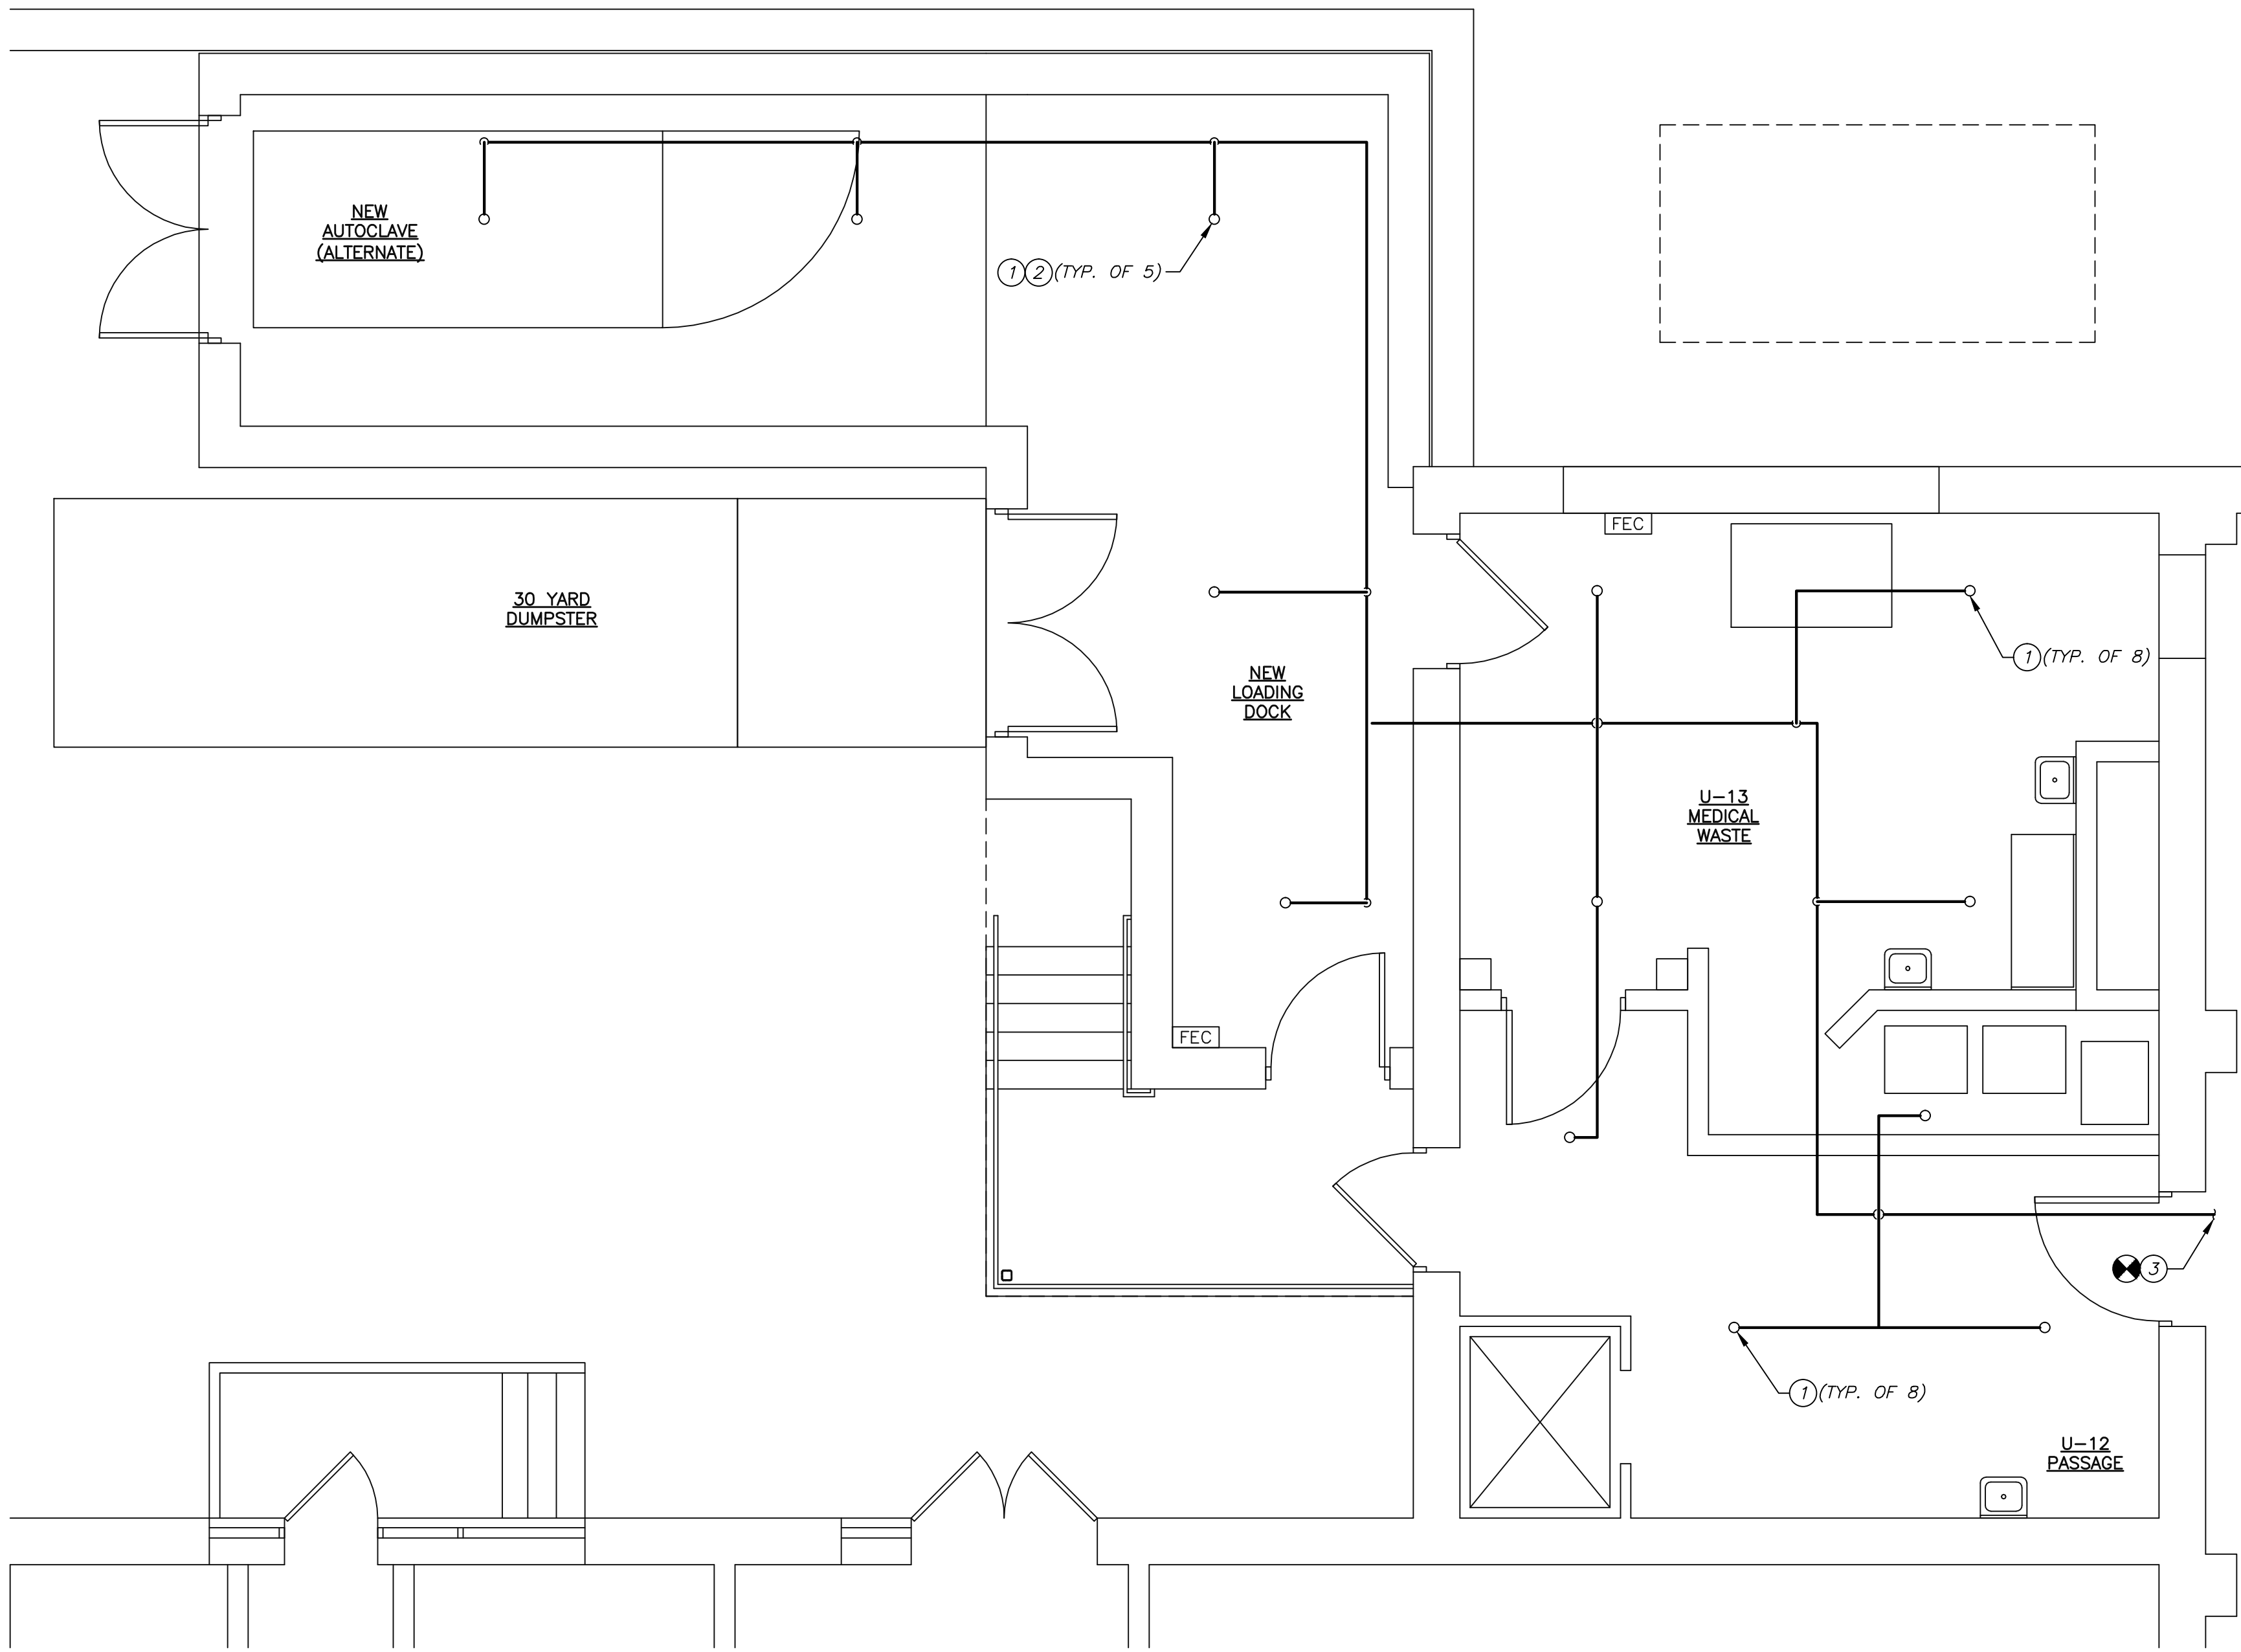

2  
FP201  
BASEMENT FLOOR PLAN - FIRE PROTECTION  
NEW WORK - ALTERNATE  
SCALE: 1/4" = 1'-0"

**DRAWING NOTES:**

- 1 PROVIDE HEAD LAYOUT AS INDICATED. PROVIDE ALL PIPING AS REQUIRED FROM EXISTING SYSTEM TO ADEQUATELY SUPPLY NEW HEADS.
- 2 PROVIDE HIGH TEMPERATURE HEADS IN SPACE WITH AUTOCLAVE/LOADING DOCK FOR ALTERNATE
- 3 TIE INTO PIPING AT LOCATION SUITABLE TO PROVIDE ADEQUATE WATER TO SERVE WORK AREA. REVISE PIPING AS REQUIRED TO MAKE TIE-IN.

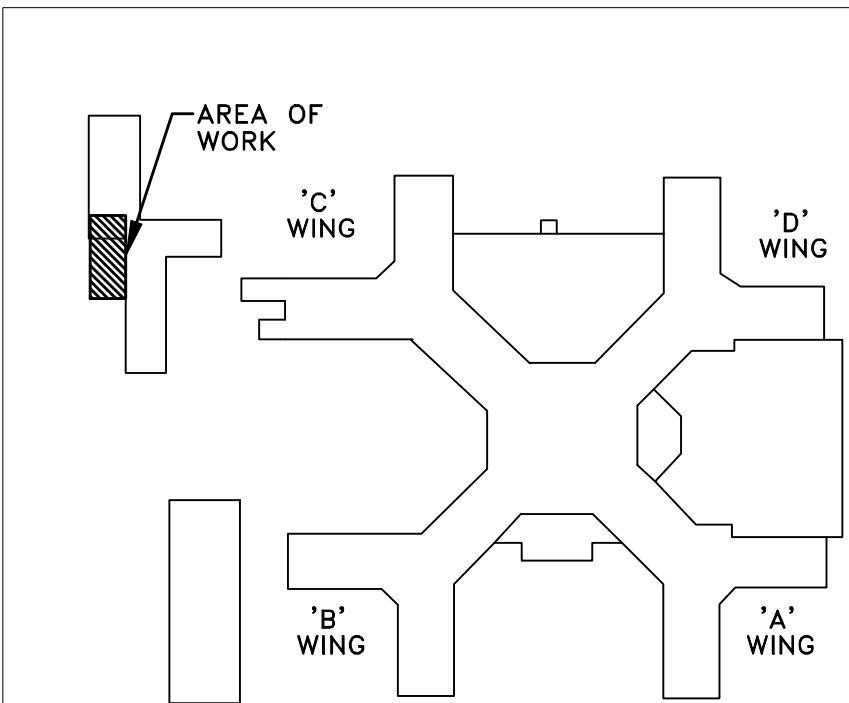

KEY PLAN  
SCALE: NONE

ISSUED FOR BID	02-15-13
Revisions	Date

VA WESTERN NEW YORK HEALTHCARE SYSTEM  
3495 BAILEY AVENUE  
BUFFALO, NEW YORK 14215

**EC4B**  
Engineering, P.C.  
15 Schoen Place  
Suite 300  
Pittsford, NY 14534  
Phone: (585) 641-7121  
Fax: (585) 362-4175  
www.ec4b.com

Consultant

**ALFAMURA**  
Alfamura Architectural Consulting  
1260 Scottsville Road, Suite 202  
Rochester, New York 14624  
585-473-0659  
fax: 585-271-2679  
email: Alfamura@frontiernet.net

Architect / Engineer

CARDIOLOGY MANAGER

DATE

ENGINEERING MANAGER

DATE

INFECTION CONTROL

DATE

CARELINE MANAGER

DATE

SAFETY OFFICER

DATE

CHIEF OF STAFF

DATE

Drawing Title

FLOOR PLANS -  
FIRE PROTECTION NEW WORK -  
BASE BID & ALTERNATE

Project Title

MEDICAL WASTE TRAILER

Building Number  
6

Checked  
AJW

Drawn  
WAB

Location  
V.A.M.C. BUFFALO, NEW YORK


Date  
February 15, 2013

Station No.  
528-12-102

09-372-FP201




one-eighth inch = one foot  
one-quarter inch = one foot  
one-half inch = one foot  
three-quarters inch = one foot  
one inch = one foot  
one and one-half inch = one foot  
three inches = one foot  
A  
B  
C  
D  
E  
F

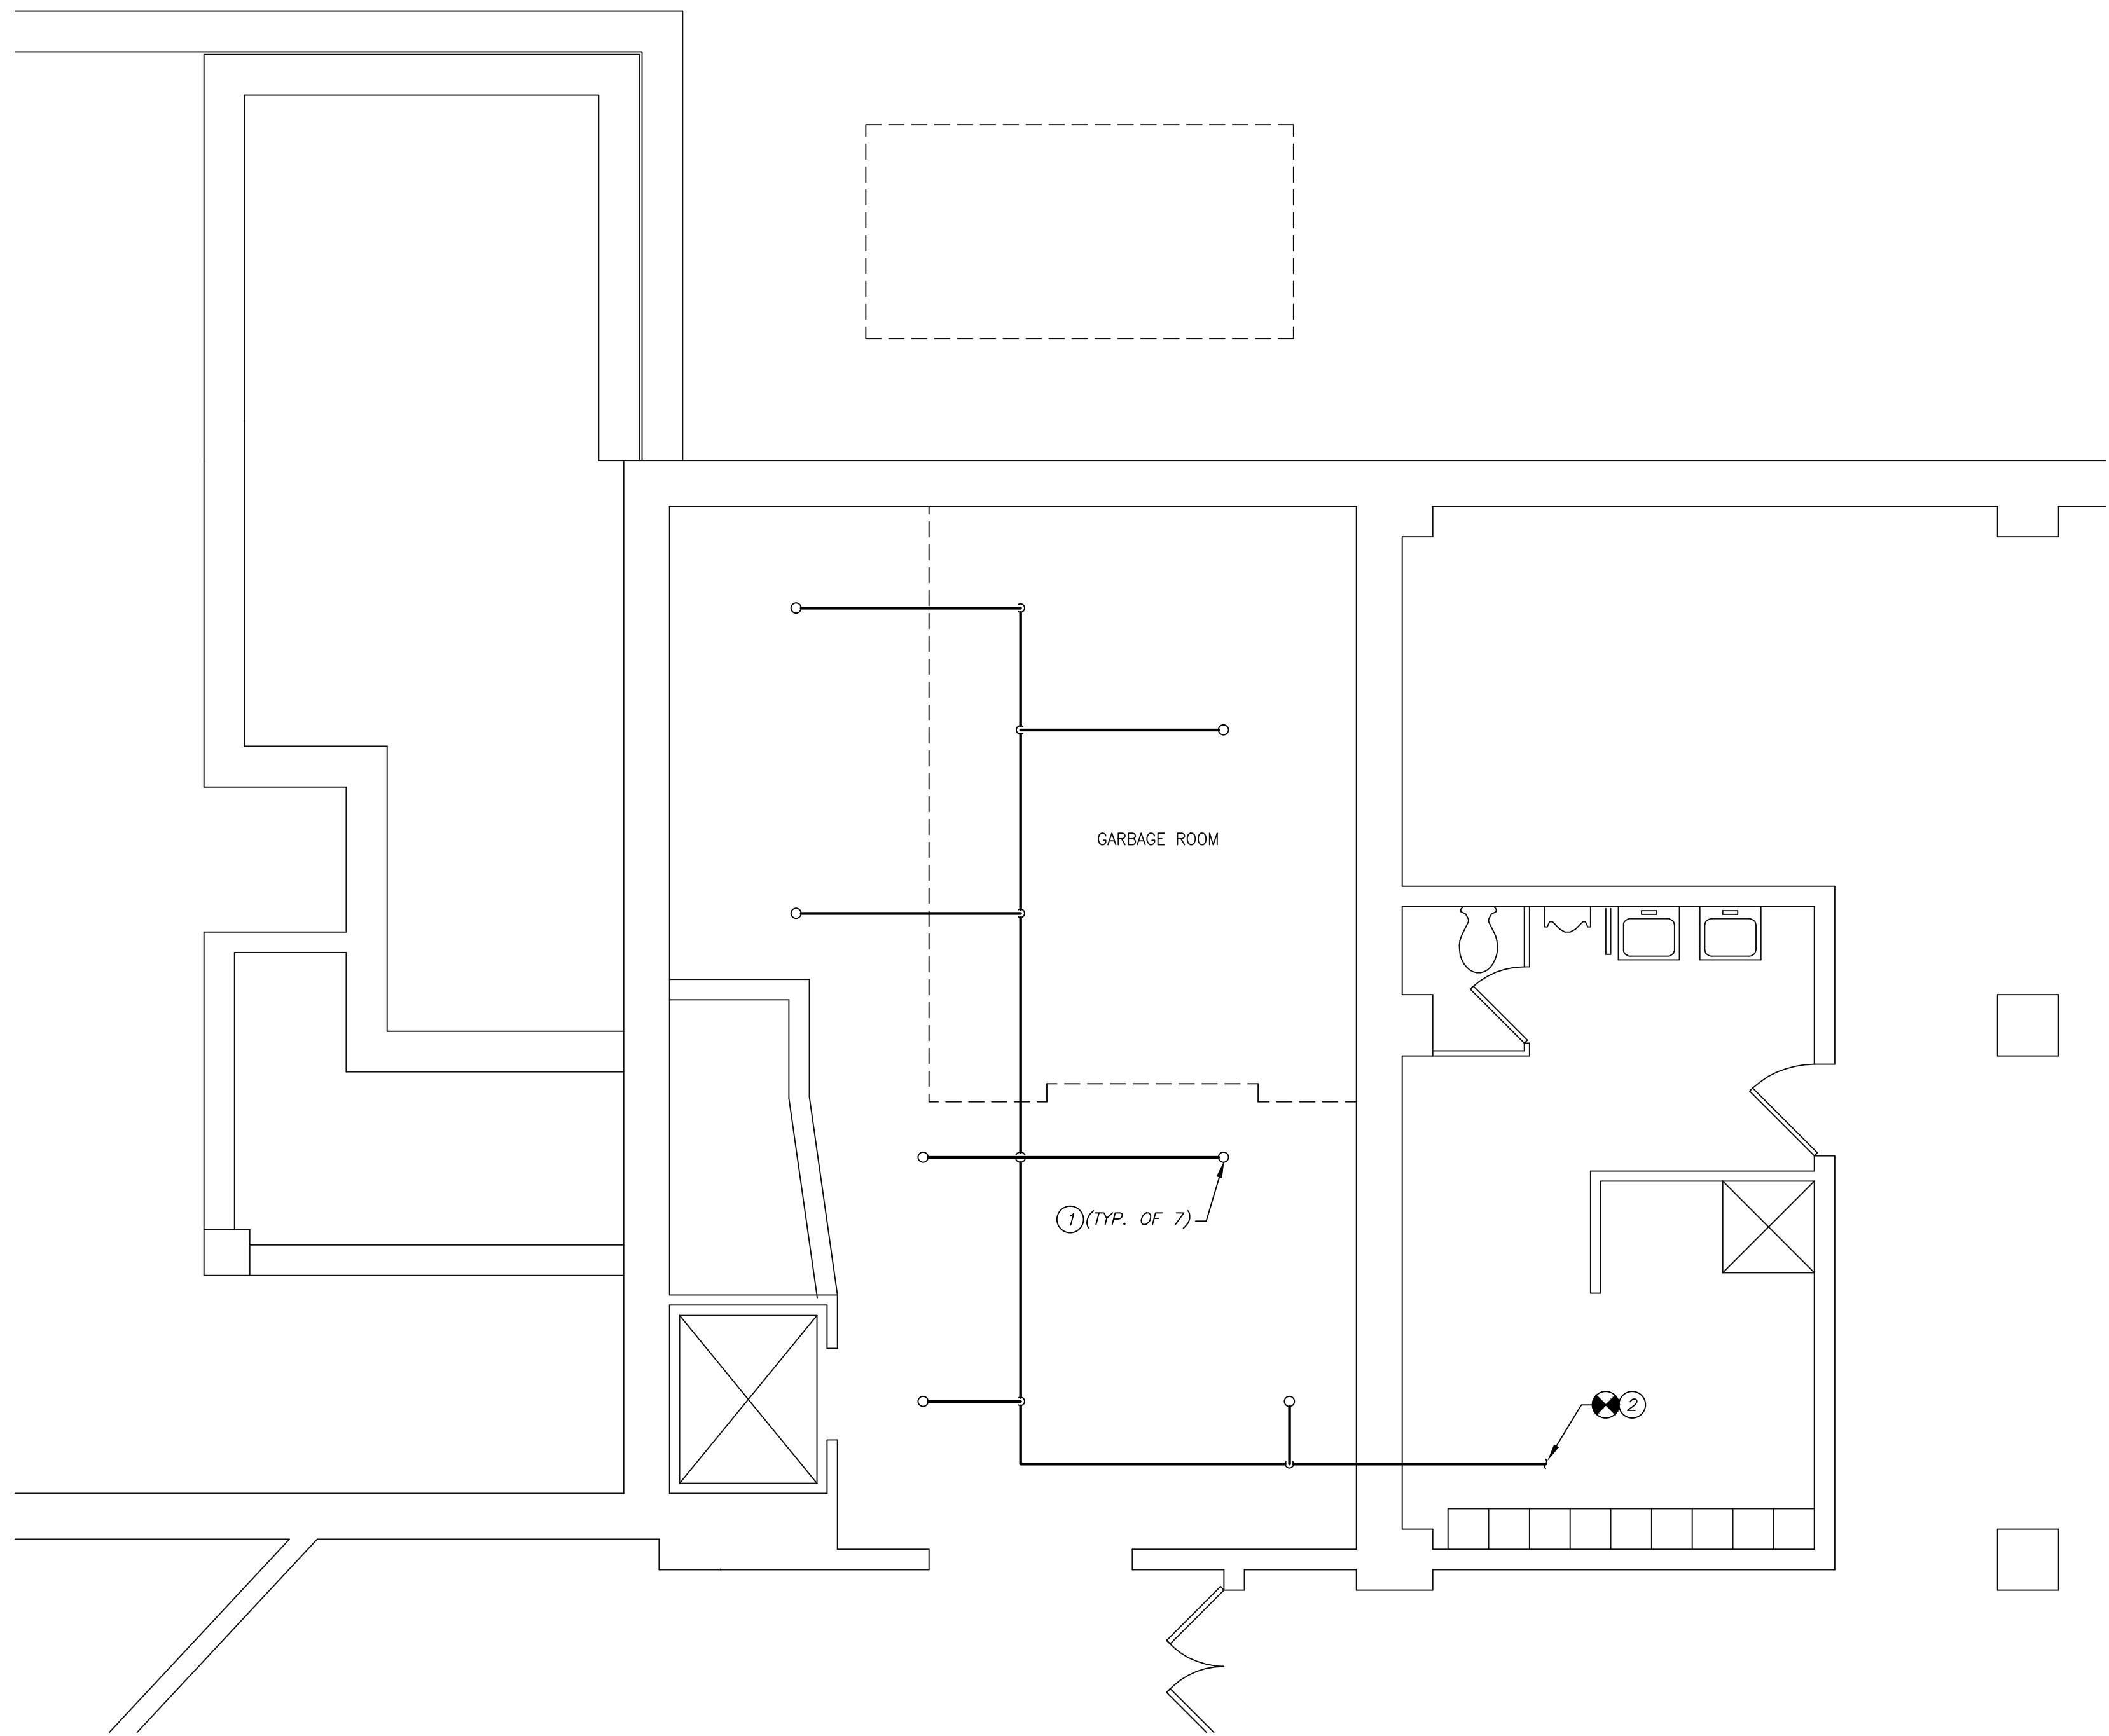

1  
FP202


SUB-BASEMENT FLOOR PLAN - FIRE PROTECTION NEW WORK

SCALE: 1/4" = 1'-0"

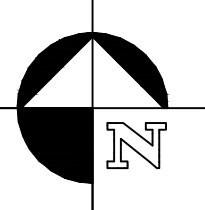

DRAWING NOTES:

- ① PROVIDE HEAD LAYOUT AS INDICATED. PROVIDE ALL PIPING AS REQUIRED FROM EXISTING SYSTEM TO ADEQUATELY SUPPLY NEW HEADS.  
② TIE INTO PIPING AT LOCATION SUITABLE TO PROVIDE ADEQUATE WATER TO SERVE WORK AREA. REVISE PIPING AS REQUIRED TO MAKE TIE-IN.

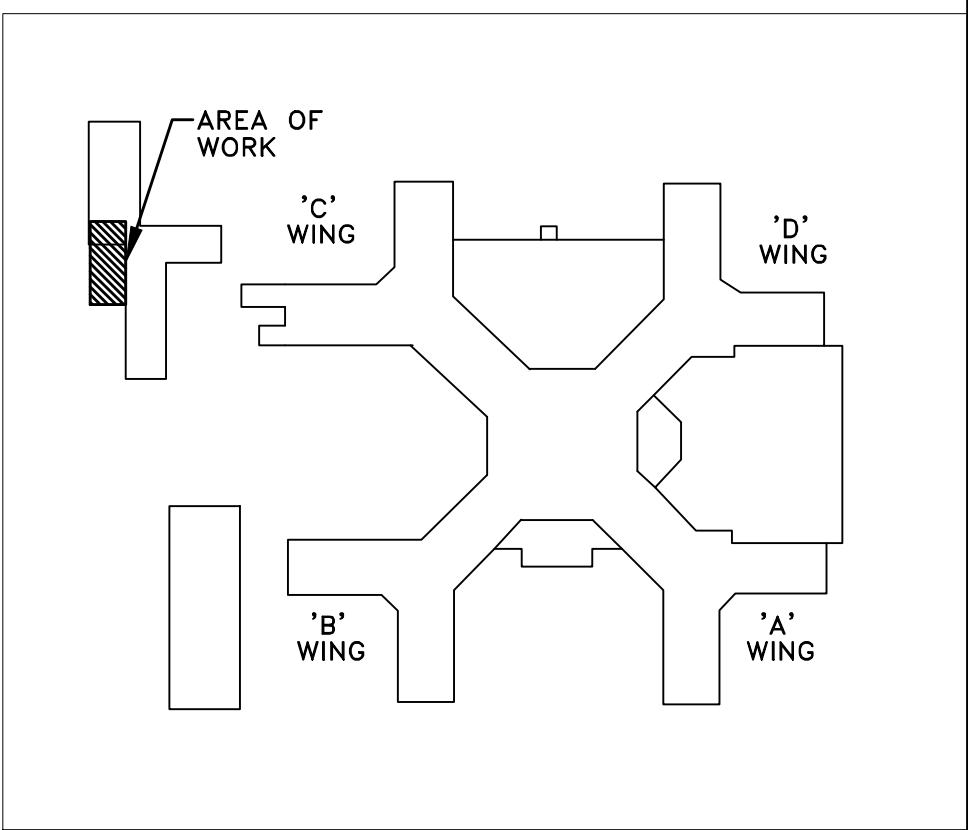

KEY PLAN  
SCALE: NONE

ISSUED FOR BID	02-15-13
Revisions	Date

VA WESTERN NEW YORK HEALTHCARE SYSTEM  
3495 BAILEY AVENUE  
BUFFALO, NEW YORK 14215



Consultant

stamp



Architect / Engineer

CARDIOLOGY MANAGER

DATE

ENGINEERING MANAGER

DATE

INFECTION CONTROL

DATE

CARELINE MANAGER

DATE

SAFETY OFFICER

DATE

CHIEF OF STAFF

DATE

Drawing Title

SUB-BASEMENT FLOOR PLAN  
FIRE PROTECTION NEW WORK

MEDICAL CENTER DIRECTOR

DATE

ASSOCIATE MEDICAL CENTER DIRECTOR

DATE

Project Title

MEDICAL WASTE TRAILER

Building Number

6

Checked

AJW

Drawn

WAB

Location

V.A.M.C. BUFFALO, NEW YORK

Date

February 15, 2013

Station No.

52B-12-102

09-372-FP202

