



three inches = one foot  
one and one half inches = one foot  
one inch = one foot  
three quarters inch = one foot  
one half inch = one foot  
three eighths inch = one foot  
one quarter inch = one foot  
one eighth inch = one foot

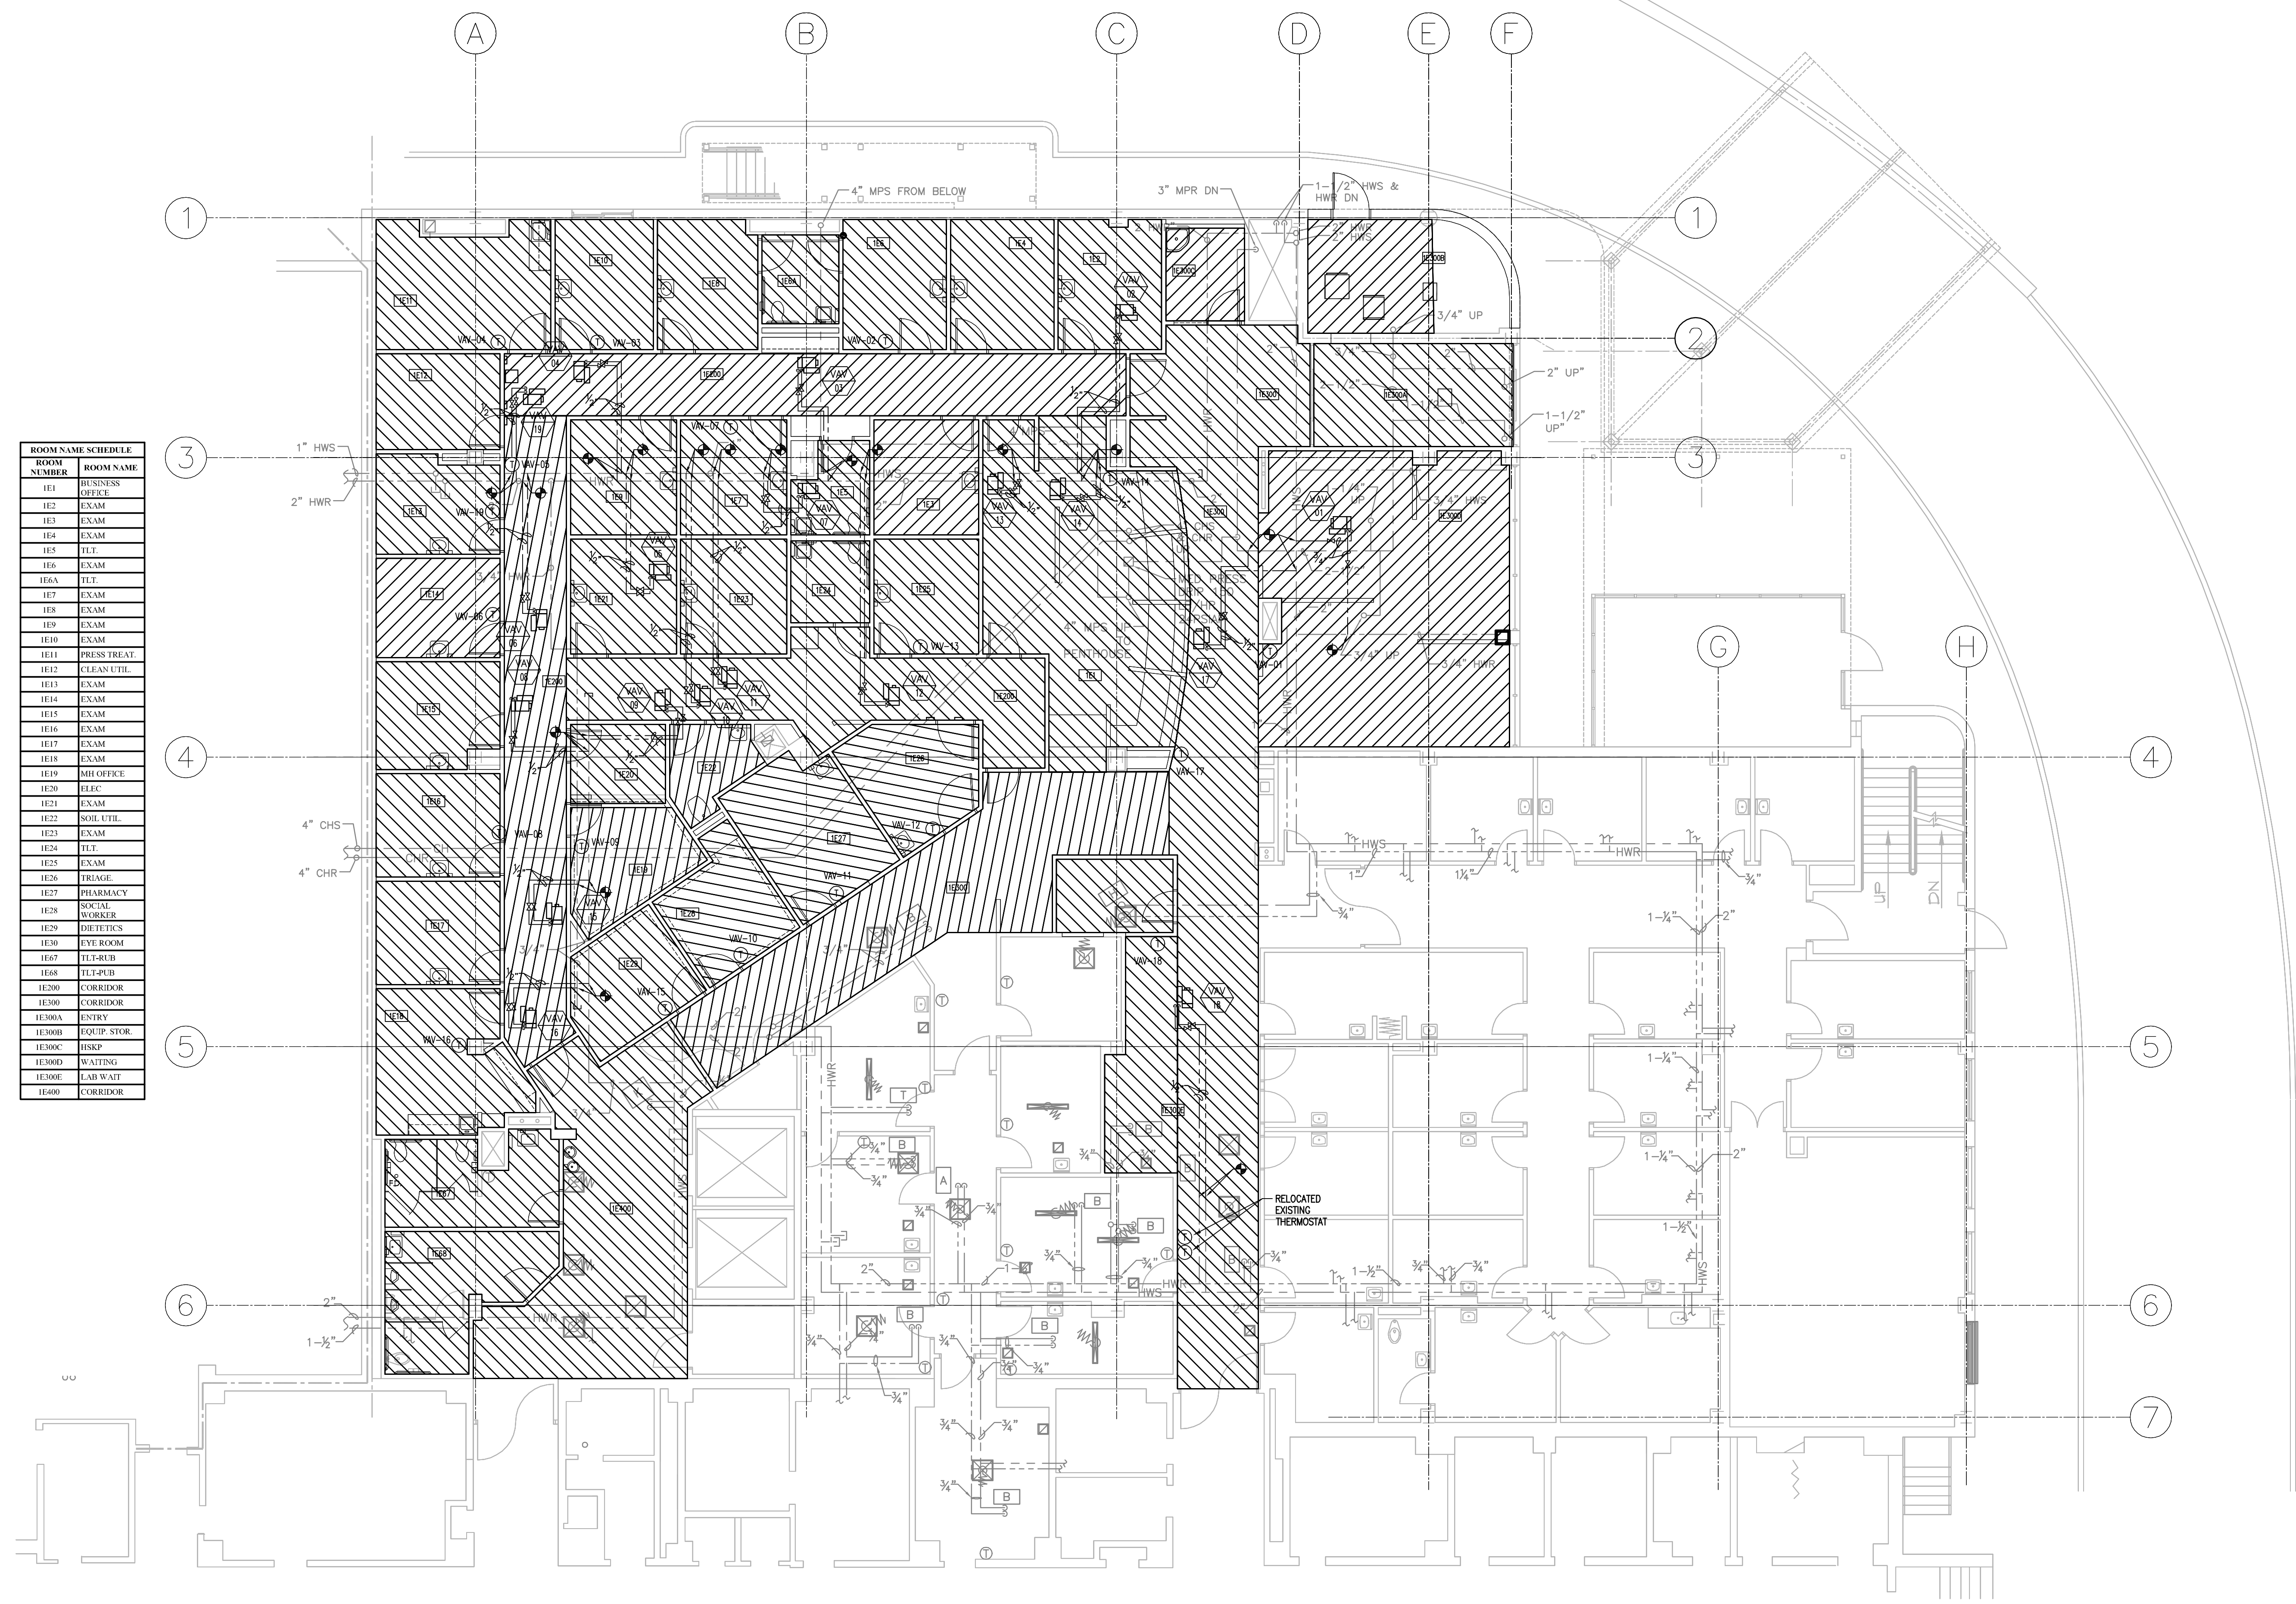

ROOM NAME SCHEDULE	
ROOM NUMBER	ROOM NAME
101	BUSINESS OFFICE
102	EXAM
103	EXAM
104	EXAM
105	TLT
106	EXAM
106A	TLT
107	EXAM
108	EXAM
109	EXAM
110	EXAM
111	PRESS TREAT
1112	CLEAN UTIL
1113	EXAM
1114	EXAM
1115	EXAM
1116	EXAM
1117	EXAM
1118	EXAM
1119	AD OFFICE
1120	ELEC
1121	EXAM
1122	BOB UTIL
1123	EXAM
1124	TLT
1125	EXAM
1126	BRIDGE
1127	PHARMACY
1128	SOCIAL
1129	WORKER
1130	DIETETICS
1131	EYE ROOM
1132	TLT-REID
1133	TLT-REID
1134	TLT-REID
1135	ORIG ROOM
1136	TLT-REID
1137	TLT-REID
1138	TLT-REID
1400	TLT-REID

FIRST FLOOR PLAN - EAST  
SCALE: 1/8"=1'-0"

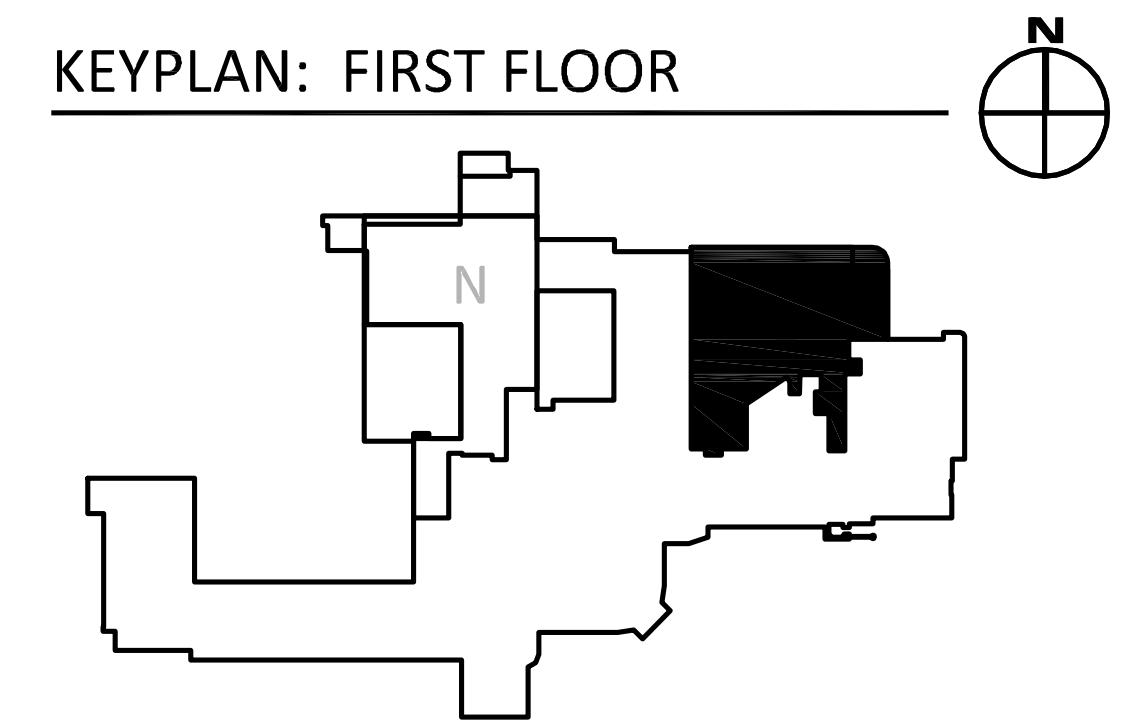

FULLY SPRINKLERED  
Scale: AS NOTED

Revisions	Date	<b>CONSULTANTS:</b>  The Estopinal Group 820 Jordan Street, Suite 507 Shreveport, LA 71101 tel. 318.424.3700 fax 318.424.3764		<b>PROJECT MANAGERS AND ENGINEERS:</b>  A VETERAN OWNED COMPANY 3 EXECUTIVE COURT, UNIT 4 SOUTH BARRINGTON, IL 60010	<b>Drawing Title</b> FIRST FLOOR-EAST MECHANICAL PIPING PLAN	<b>Project Title</b> RENOVATE ED + PRIMARY CARE	<b>Project Number</b> 667-10-100	<b>Office of Construction and Facilities Management</b> 	
					<b>Approved Project Director</b>	<b>Location</b> SHREVEPORT VAMC 510 EAST STONER AVE	<b>Building Number</b> 1N, 1E		<b>Drawing Number</b> M1.E2 Dwg. 60 of 112
						<b>Date</b> 01/09/13	<b>Checked</b> RM	<b>Drawn</b> SL	