



three inches = one foot
one and one half inches = one foot
one inch = one foot
three quarters inch = one foot
one half inch = one foot
three eighths inch = one foot
one quarter inch = one foot
one eighth inch = one foot

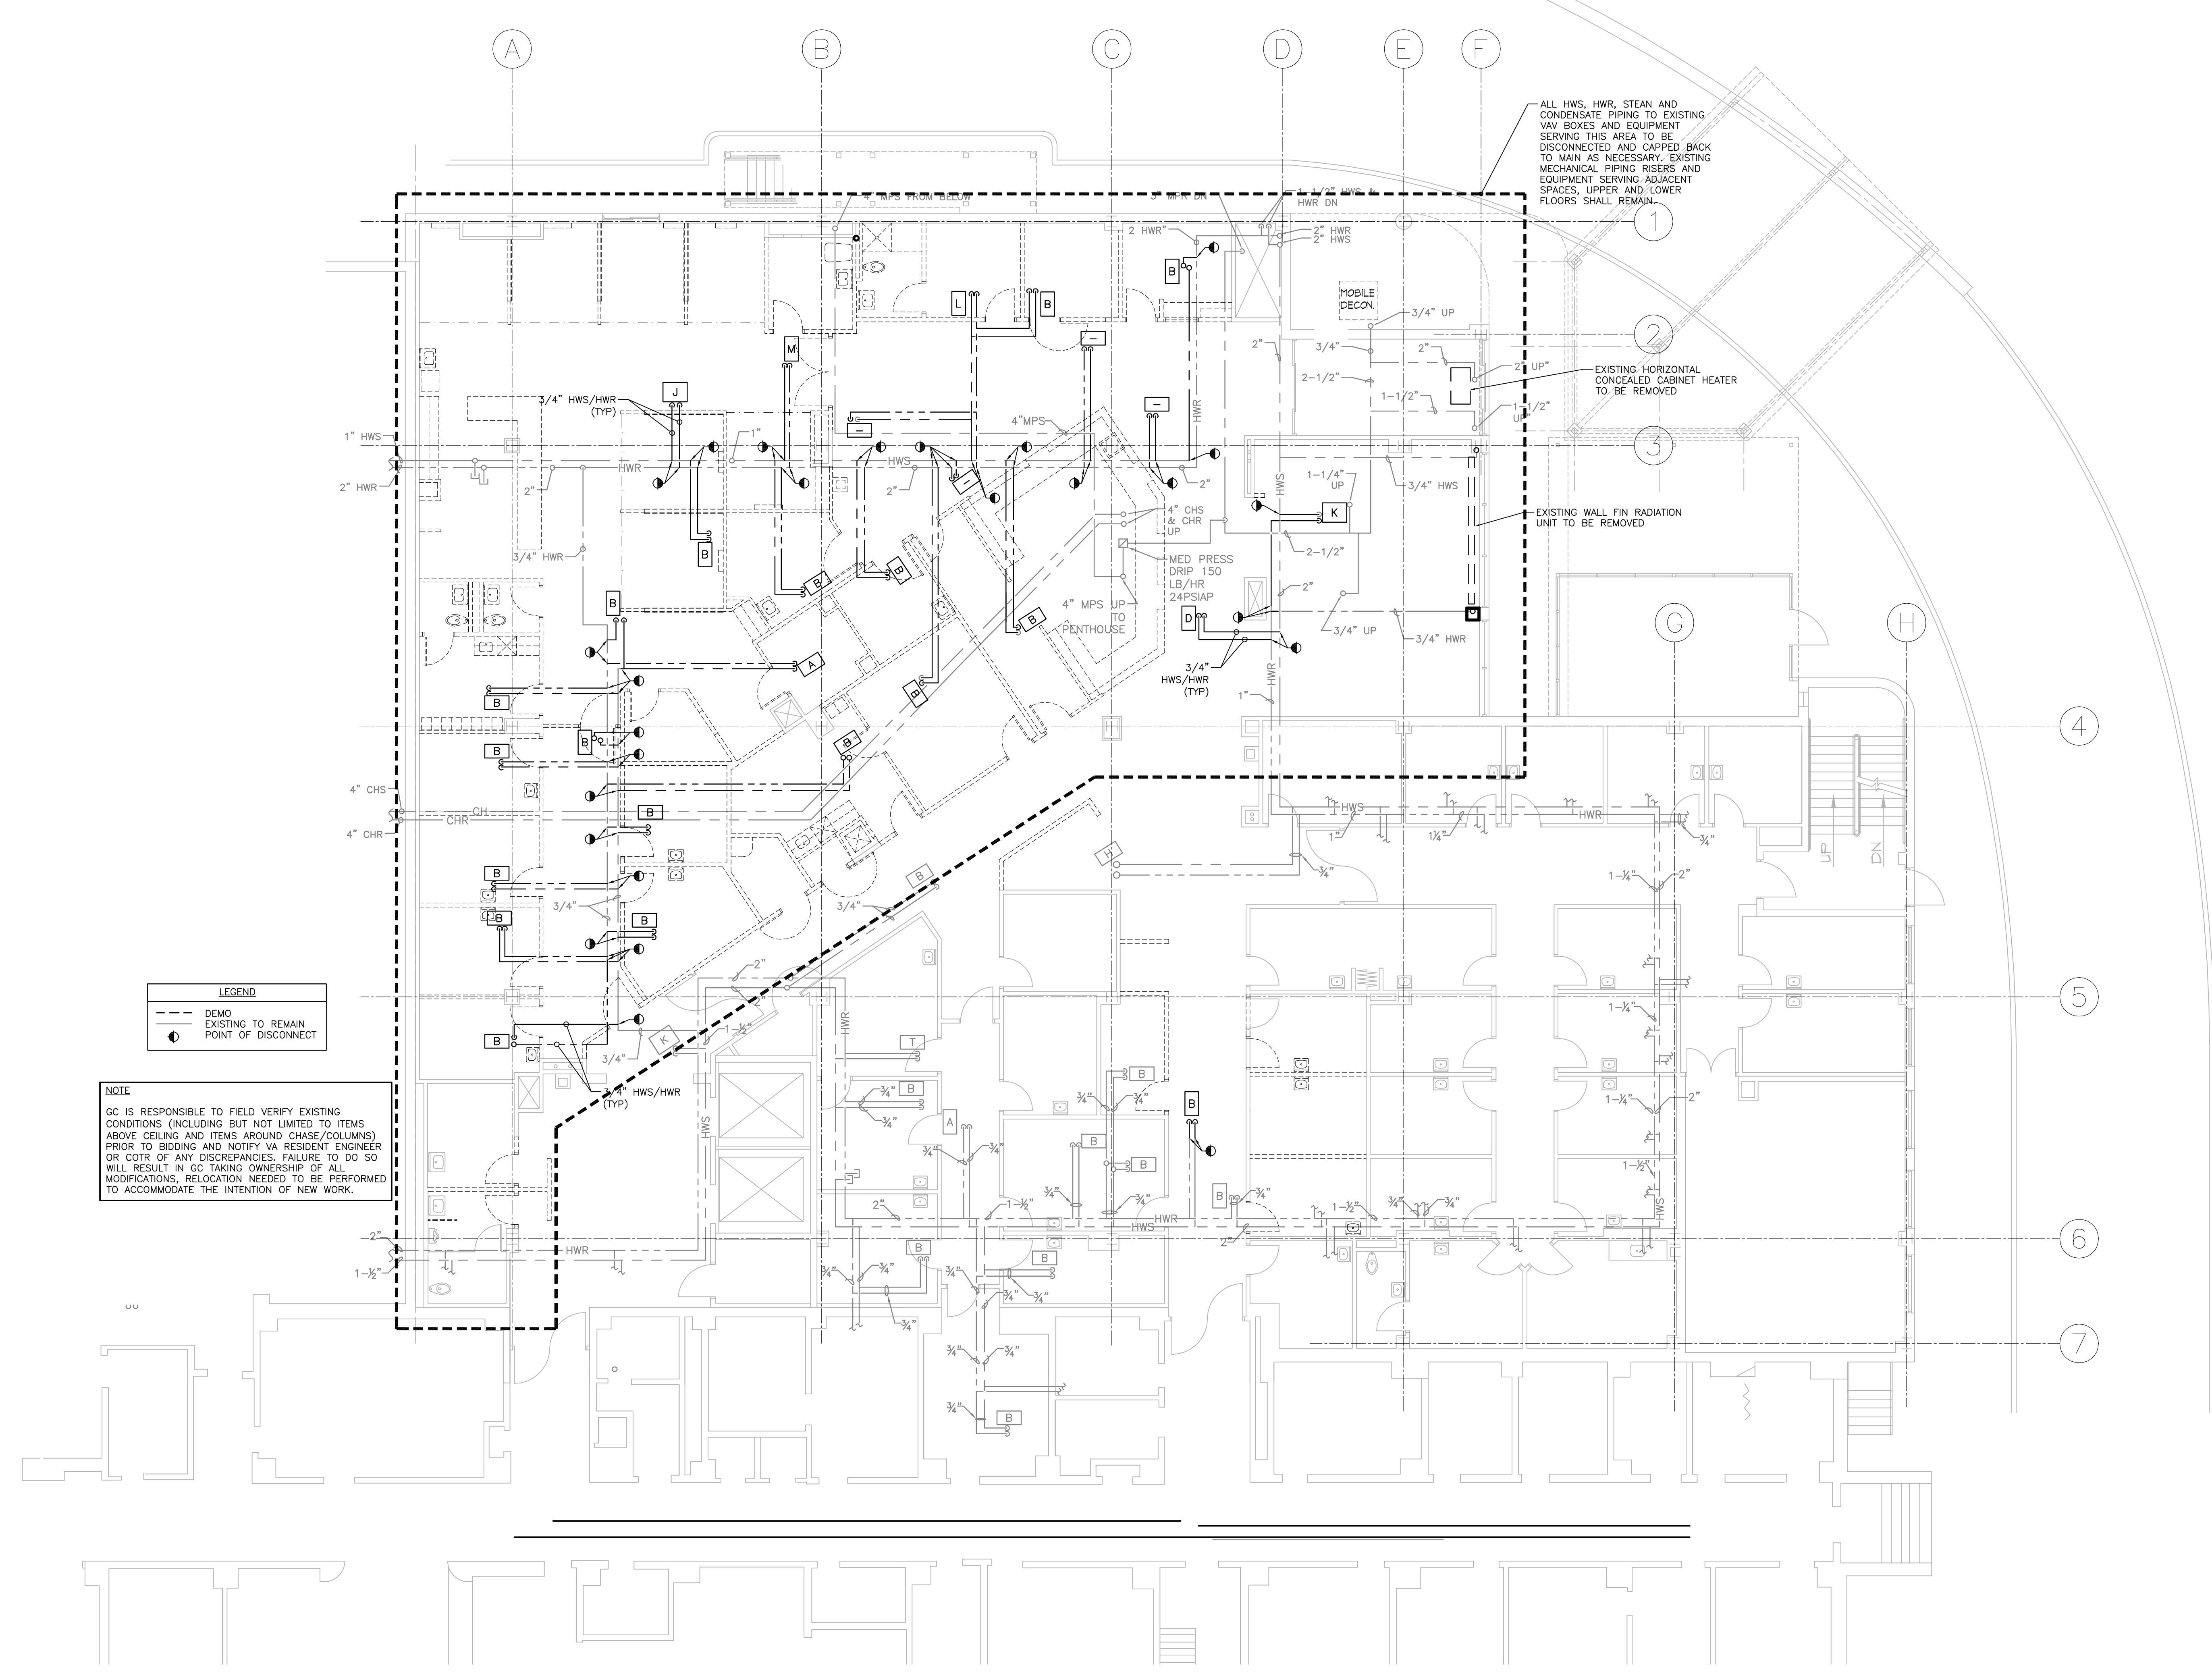

FIRST FLOOR PLAN - EAST
SCALE: 1/8"=1'-0"

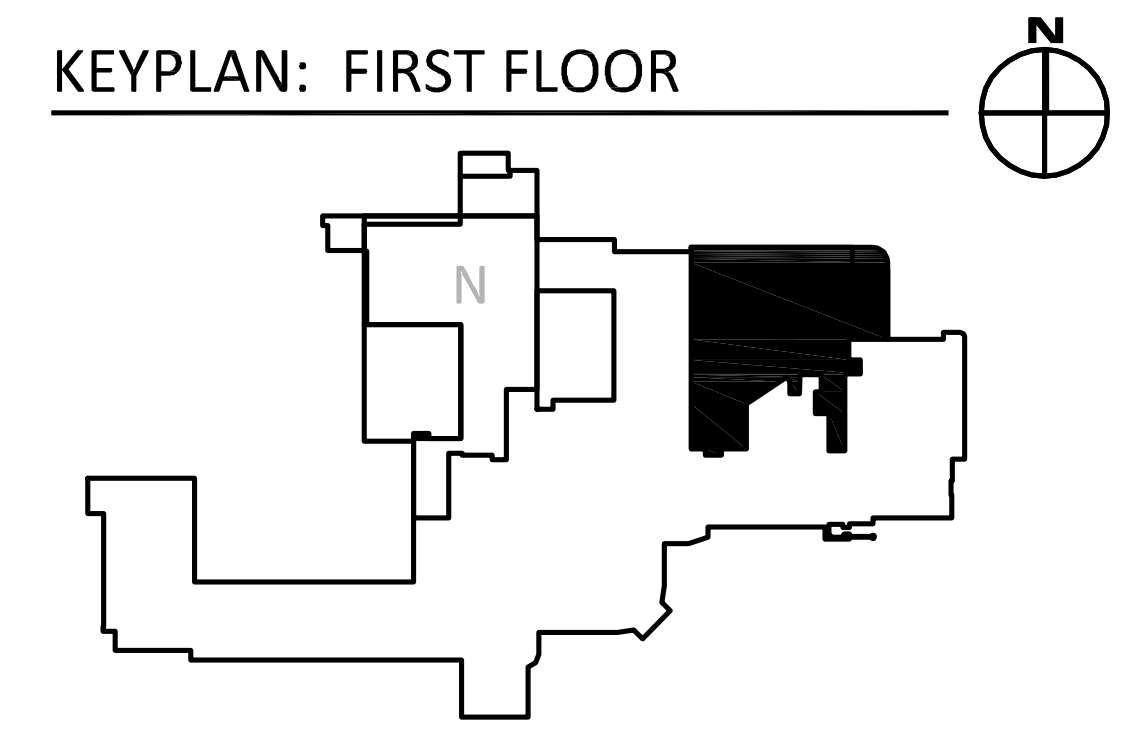

FULLY SPRINKLERED
Scale: AS NOTED

<div>Revisions</div> <div>Date</div>		<div>CONSULTANTS:</div> <div> The Estopinal Group 820 Jordan Street, Suite 507 tel. 318.424.3700 Shreveport, LA 71101 fax 318.424.3764</div>		<div>PROJECT MANAGERS AND ENGINEERS:</div> <div> A VETERAN OWNED COMPANY 3 EXECUTIVE COURT, UNIT 4 SOUTH BARRINGTON, IL 60010</div>		<div>Drawing Title</div> <div>FIRST FLOOR-EAST MECHANICAL PIPING DEMO</div> <div>Approved Project Director</div>		<div>Project Title</div> <div>RENOVATE ED + PRIMARY CARE</div> <div>Location SHREVEPORT VAMC 510 EAST STONER AVE</div> <div>Date 01/09/13</div> <div>Checked RM</div> <div>Drawn SL</div>		<div>Project Number</div> <div>667-10-100</div> <div>Building Number</div> <div>1N, 1E</div> <div>Drawing Number</div> <div>M2.E2 Dwg. 64 of 112</div>		<div>Office of Construction and Facilities Management</div> <div> Department of Veterans Affairs</div>	
--------------------------------------	--	--	--	---	--	--	--	---	--	--	--	--	--