


three inches = one foot  
one and one half inches = one foot  
one inch = one foot  
three quarters inch = one foot  
one half inch = one foot  
three eighths inch = one foot  
one quarter inch = one foot  
one eighth inch = one foot

1-09-13 12:24:17 PM singer  
C:\Users\singer\Documents\Projects\Shreveport VA\75% Dwg\VA-SH-013-FP1.N1.dwg

Revisions  
Date

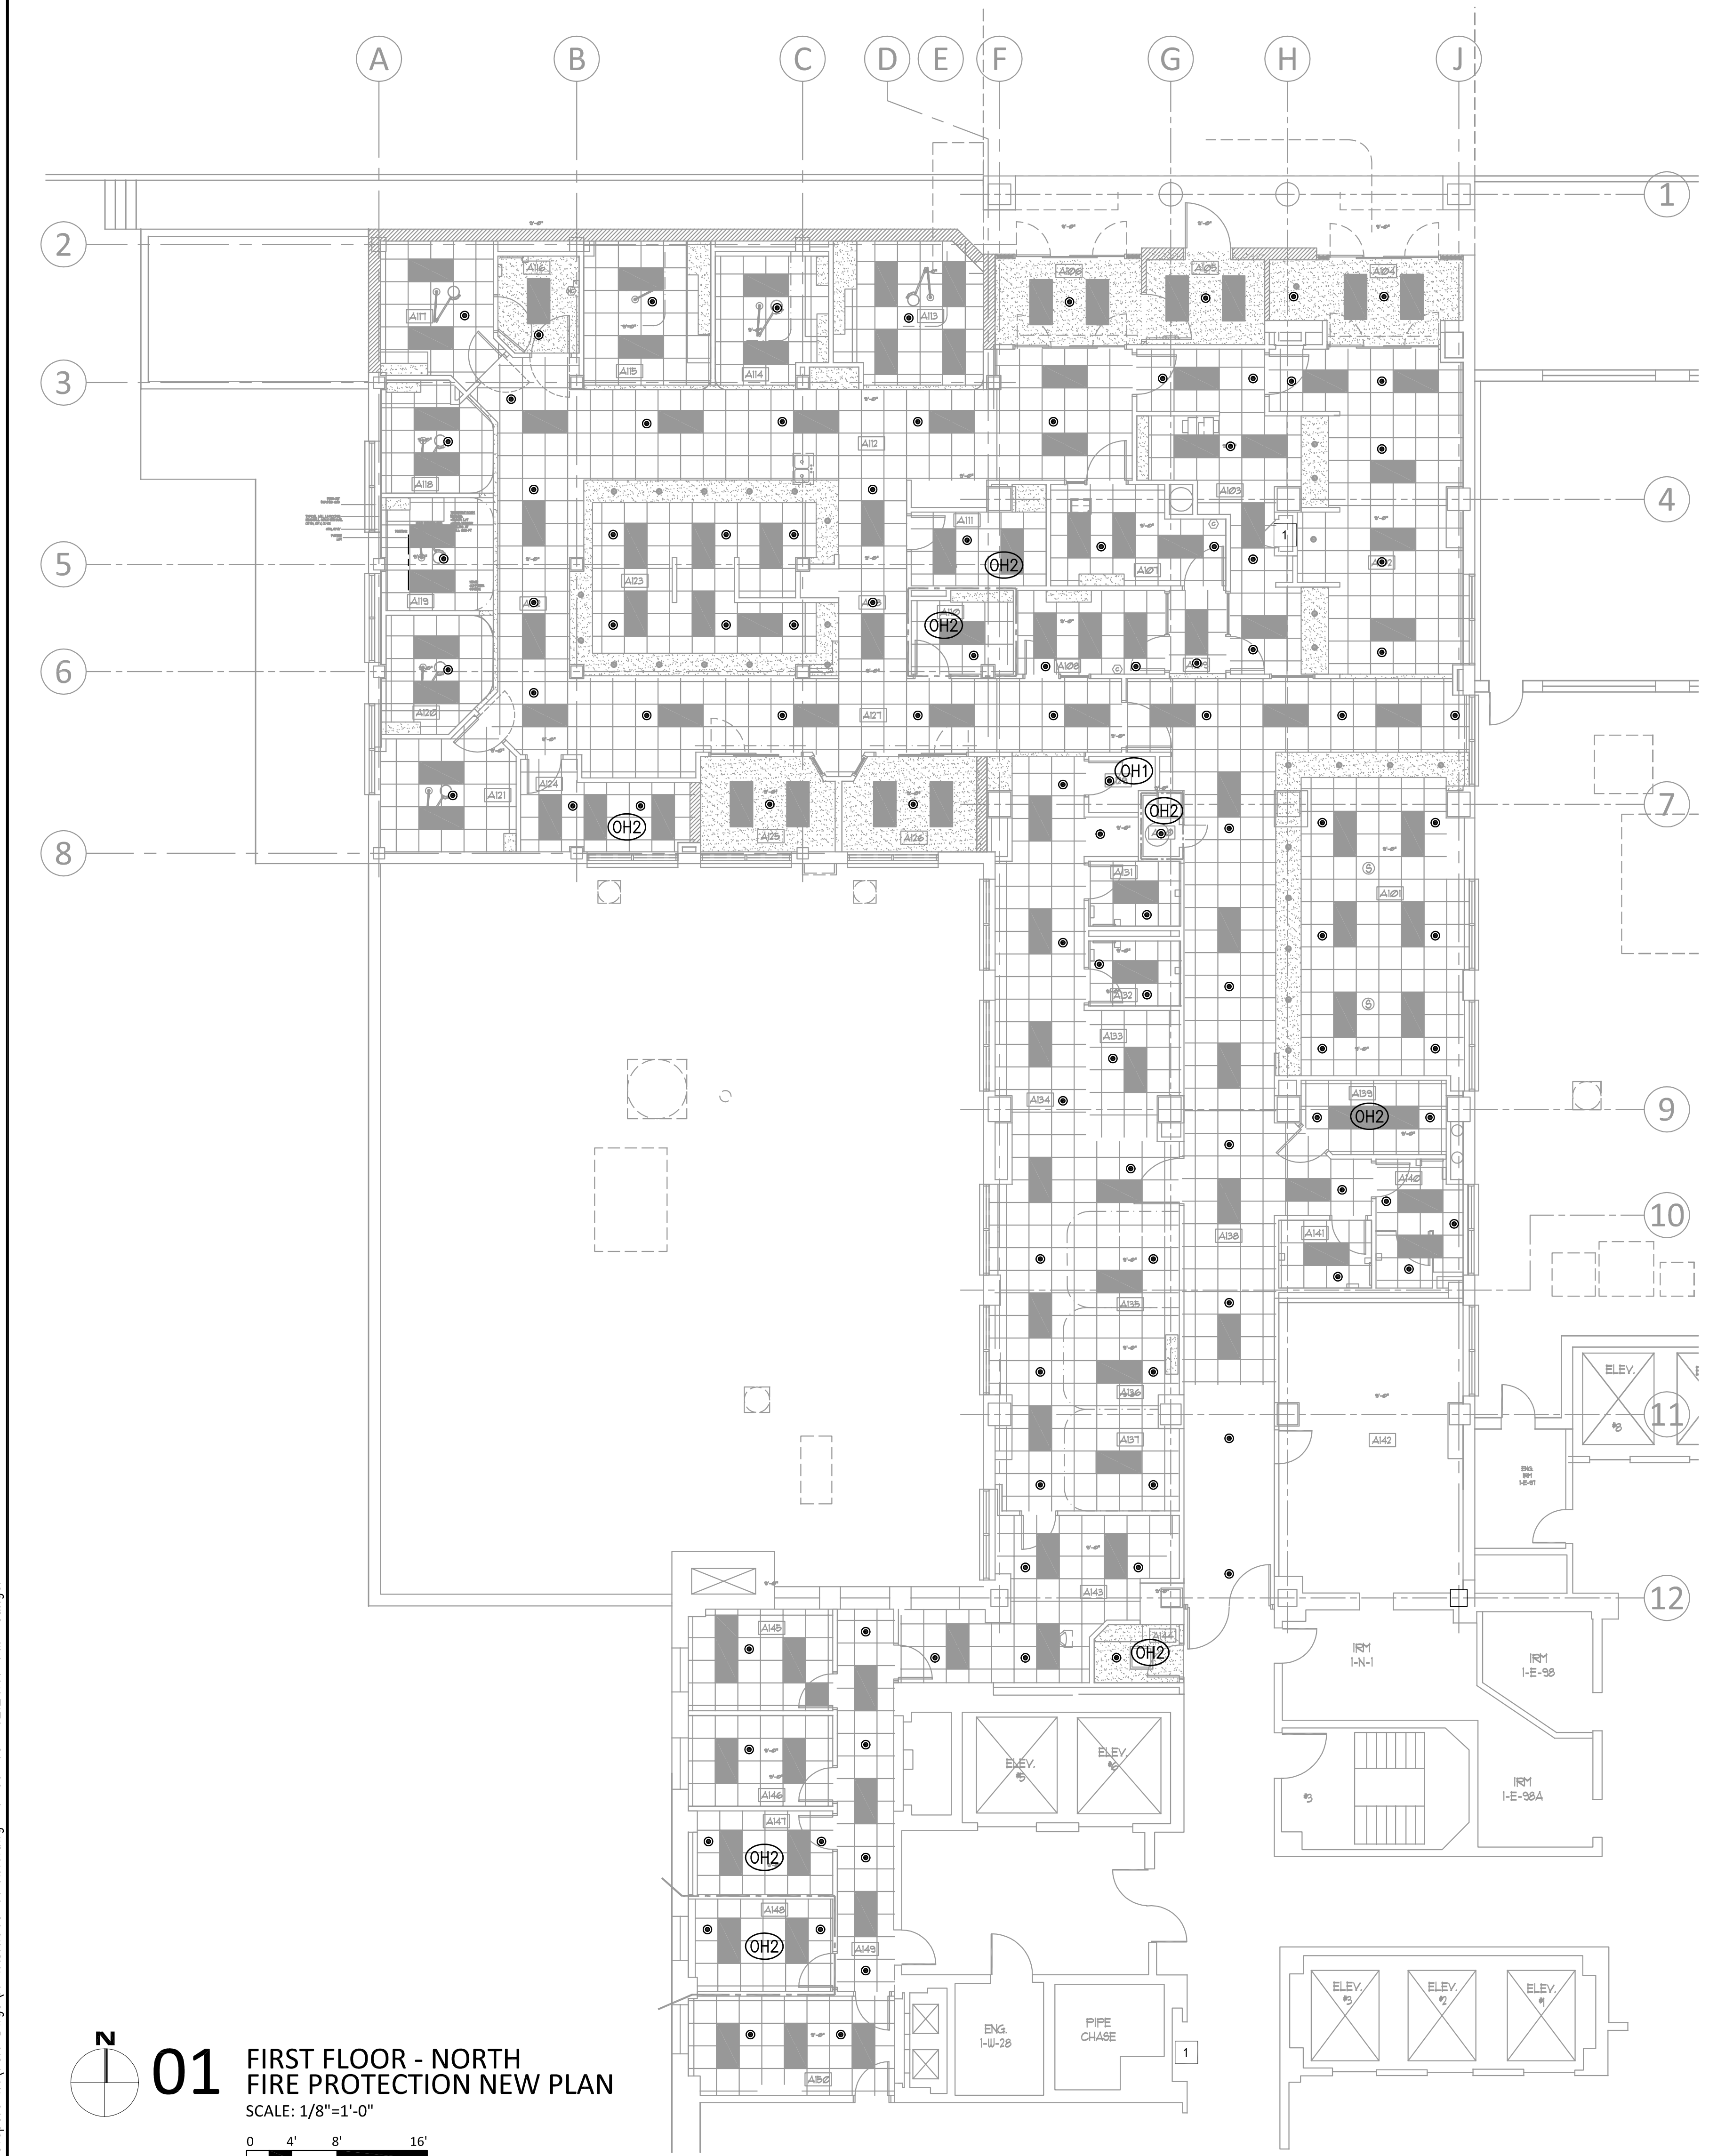

**01** FIRST FLOOR - NORTH  
FIRE PROTECTION NEW PLAN  
SCALE: 1/8"=1'-0"

0 4' 8' 16'  
1/8"=1'-0"


**SHEET NOTES:**

- SEE SHEET FP0.1 FOR SYMBOL LEGEND AND NOTES.
- INSTALL ORDINARY TEMPERATURE RATED SPRINKLERS A MINIMUM OF 30 INCHES FROM THE EDGE OF SUPPLY AIR DIFFUSERS.
- INSTALL CEILING MOUNTED SPRINKLERS IN THE CENTER OF SUSPENDED CEILING TILES.
- DRAWINGS SHOW PROPOSED SPRINKLER LOCATIONS ONLY. COORDINATE ACTUAL LAYOUT WITH OTHER BUILDING UTILITIES AND SYSTEMS.
- CONTRACTOR SHALL RE-USE THE EXISTING SPRINKLER PIPING TO THE MAXIMUM EXTENT POSSIBLE. ALL NEW SPRINKLER PIPING INSTALLATION SHALL BE IN ACCORDANCE WITH APPLICABLE CODES.

 
**KEYED NOTES**

- 1 EXISTING RISER AND ZONE CONTROL VALVE TO REMAIN AND FEED MODIFIED SYSTEM.

KEYPLAN: FIRST FLOOR

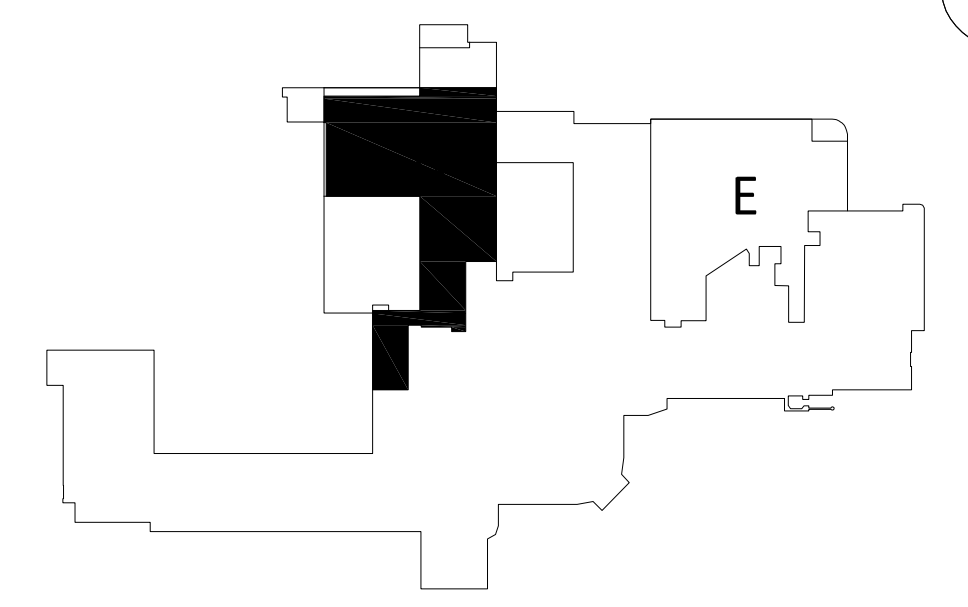

FULLY SPRINKLERED  
Scale: AS NOTED

		<b>CONSULTANTS:</b>		<b>PROJECT MANAGERS AND ENGINEERS:</b>		<b>Drawing Title</b>		<b>Project Title</b>		<b>Project Number</b>		<b>Office of Construction and Facilities Management</b>  			
		 The Estopinal Group 820 Jordan Street, Suite 507 tel. 318.424.3700 Shreveport, LA 71101 fax 318.424.3764		 HUGHES ASSOCIATES, INC. FIRE PROTECTION ENGINEERS CODE CONSULTANTS 2121 W. Spring Creek Parkway, Suite 108 Plano, Texas 75023 Phone 972-491-1900		 <b>TNF</b> A VETERAN OWNED COMPANY 3 EXECUTIVE COURT, UNIT 4 SOUTH BARRINGTON, IL 60010		FIRST FLOOR - NORTH FIRE PROTECTION NEW PLAN		RENOVATE ED + PRIMARY CARE				<b>Building Number</b> 1N, 1E	
						<b>Approved Project Director</b>		<b>Location</b> SHREVEPORT VAMC 510 EAST STONER AVE		<b>Drawing Number</b> <b>FP1.N1</b> Dwg. 88 of 112					
<b>Revisions:</b>		<b>Date</b>						<b>Date</b> 01/09/13		<b>Checked</b> SU		<b>Drawn</b> MP			