


DEPARTMENT OF VETERANS AFFAIRS MEDICAL CENTER - WADE PARK
10701 EAST BLVD. CLEVELAND, OH. 44106

STEAM TRAP MONITORING SYSTEM, INSULATION AND PIPING UPGRADES
PROJECT NO. 541-12-115

Veterans Administration
Medical Center

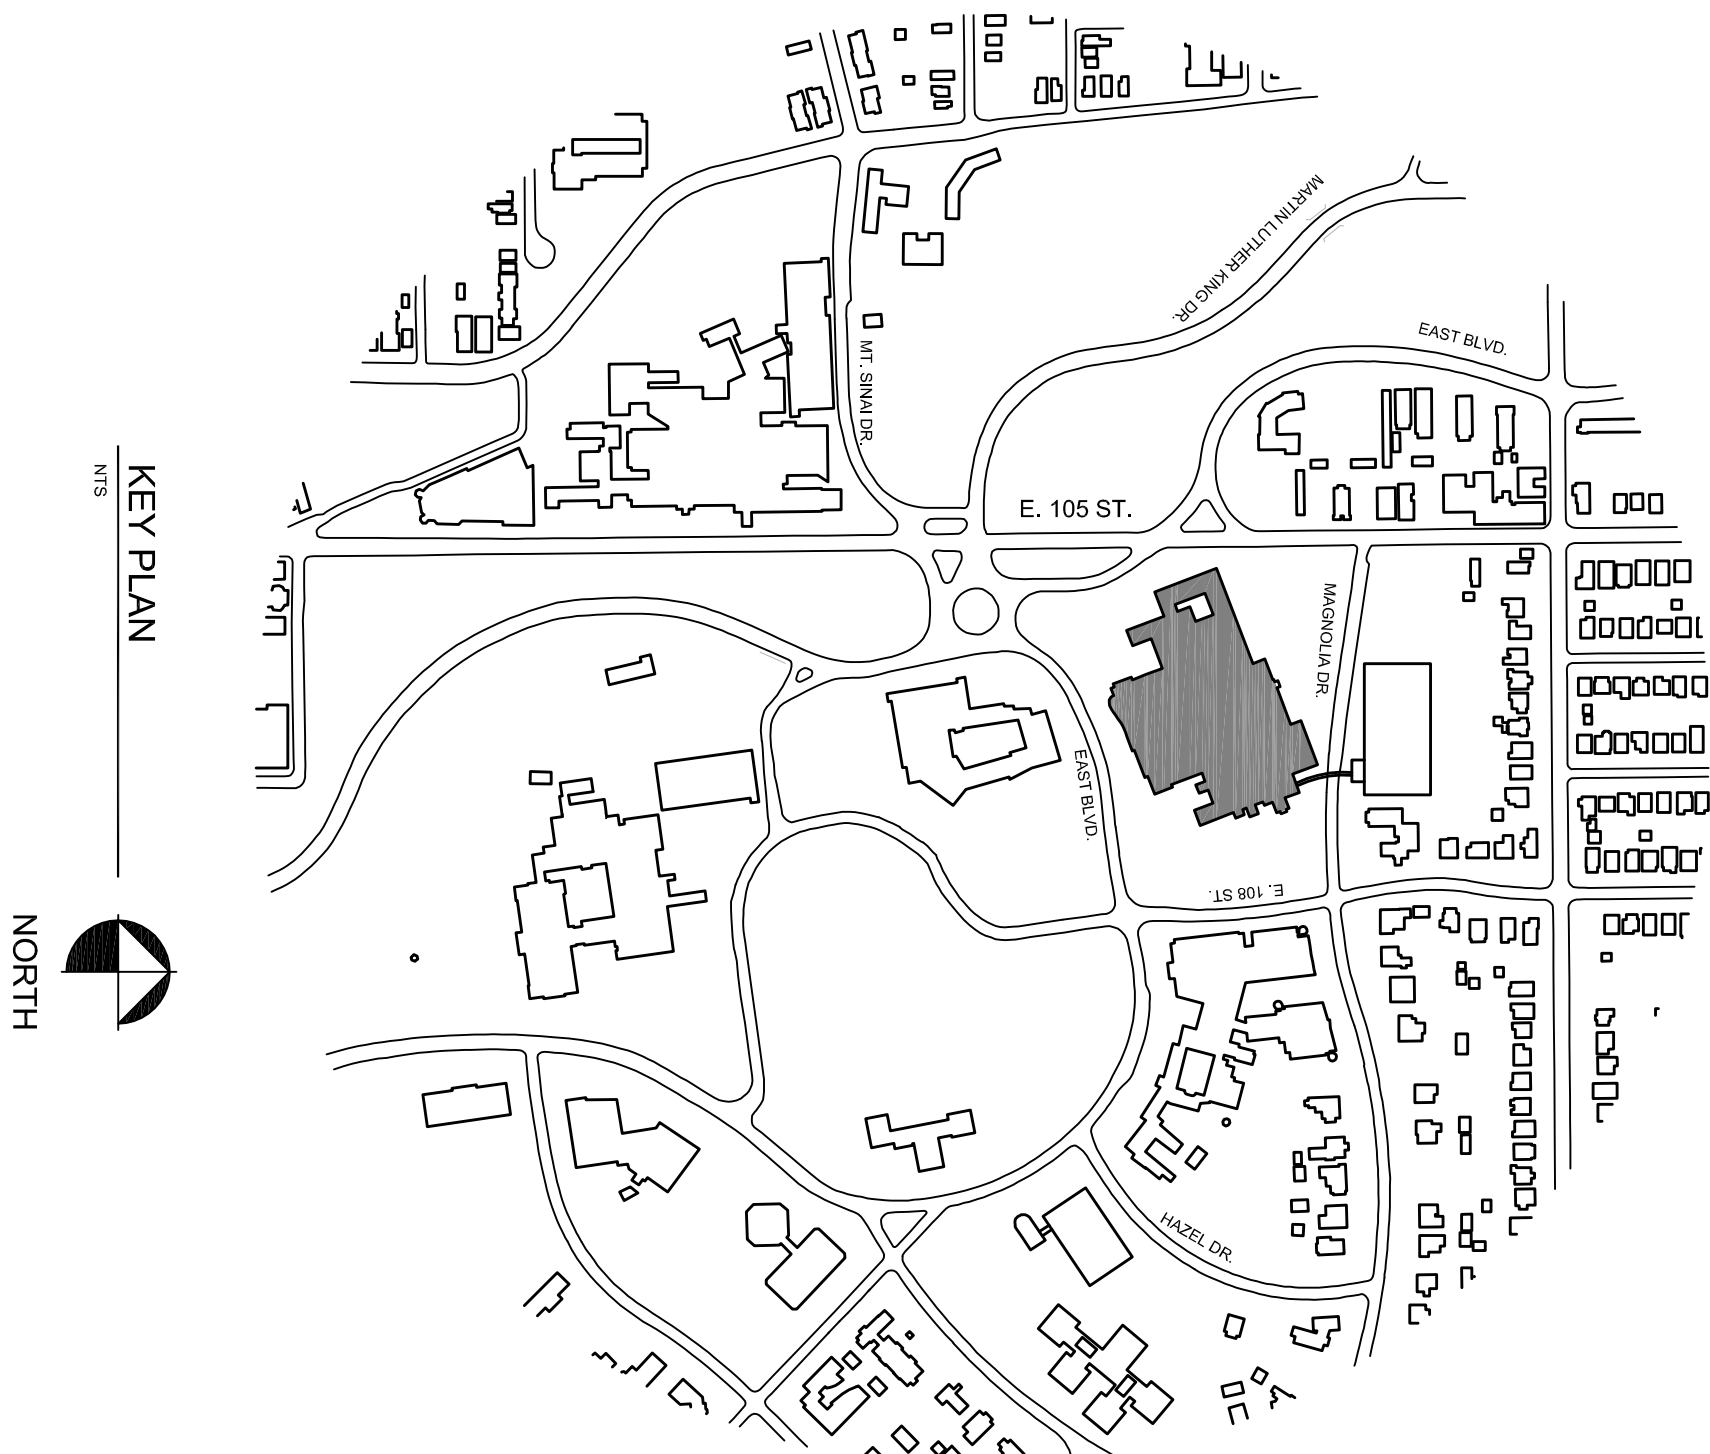

DRAWING INDEX

1-X0 COVER SHEET
MECHANICAL DRAWINGS

MECHANICAL SYMBOLS, ABBREVIATIONS AND NOTES	
1-01	MECHANICAL PIPING DETAILS
1-02	STEAM TRAP AND WORK SCHEDULE - TRAPS 1 THRU 40
2-01	STEAM TRAP AND WORK SCHEDULE - TRAPS 41 THRU 85
2-02	STEAM TRAP AND WORK SCHEDULE - TRAPS 86 THRU 128
2-03	STEAM TRAP AND WORK SCHEDULE - TRAPS 131 THRU 170
2-04	STEAM TRAP AND WORK SCHEDULE - TRAPS 171 THRU 205
2-05	STEAM TRAP AND WORK SCHEDULE - TRAPS 206 THRU 245
2-06	STEAM TRAP AND WORK SCHEDULE - TRAPS 246 THRU 285
2-07	STEAM TRAP AND WORK SCHEDULE - TRAPS 286 THRU 335
2-08	STEAM TRAP AND WORK SCHEDULE - TRAPS 336 THRU 370
2-09	STEAM TRAP AND WORK SCHEDULE - TRAPS 371 THRU 410
2-10	STEAM TRAP AND WORK SCHEDULE - TRAPS 410A THRU 450
2-11	STEAM TRAP AND WORK SCHEDULE - TRAPS 451 THRU 498
2-12	INSULATION COVER SCHEDULE - 1" C THRU 154C
2-13	INSULATION COVER SCHEDULE - 156C THRU 278C
2-14	SUB-BASEMENT FLOOR PLAN - AREA 1
3-SB-1	SUB-BASEMENT FLOOR PLAN - AREA 2
3-SB-2	SUB-BASEMENT FLOOR PLAN - AREA 3
3-SB-3	SUB-BASEMENT FLOOR PLAN - AREA 4
3-SB-4	SUB-BASEMENT FLOOR PLAN - AREA 5
3-SB-5	SUB-BASEMENT FLOOR PLAN - AREA 6
3-B-1	BASEMENT FLOOR PLAN - AREA 1
3-B-2	BASEMENT FLOOR PLAN - AREA 2
3-B-3	BASEMENT FLOOR PLAN - AREA 3
3-B-4	BASEMENT FLOOR PLAN - AREA 4
3-B-5	BASEMENT FLOOR PLAN - AREA 5
3-B-6	BASEMENT FLOOR PLAN - AREA 6
3-B-7	BASEMENT FLOOR PLAN - AREA 7
3-B-8	BASEMENT FLOOR PLAN - AREA 8
3-B-9	BASEMENT FLOOR PLAN - AREA 9
3-1-1	FIRST FLOOR PLAN - AREA 1
3-1-2	FIRST FLOOR PLAN - AREA 2
3-1-3	FIRST FLOOR PLAN - AREA 3
3-1-4	FIRST FLOOR PLAN - AREA 4
3-1-5	FIRST FLOOR PLAN - AREA 5
3-1-6	FIRST FLOOR PLAN - AREA 6
3-1-7	FIRST FLOOR PLAN - AREA 7
3-1-8	FIRST FLOOR PLAN - AREA 8
3-1-9	FIRST FLOOR PLAN - AREA 9

FINAL CD SUBMISSION - FOR CONSTRUCTION
DECEMBER 21, 2012

3-2-1	SECOND FLOOR PLAN - AREA 1
3-2-2	SECOND FLOOR PLAN - AREA 2
3-2-3	SECOND FLOOR PLAN - AREA 3
3-2-4	SECOND FLOOR PLAN - AREA 4
3-2-5	SECOND FLOOR PLAN - AREA 5
3-2-6	SECOND FLOOR PLAN - AREA 6
3-2-7	SECOND FLOOR PLAN - AREA 7
3-2-8	SECOND FLOOR PLAN - AREA 8
3-3-1	THIRD FLOOR PLAN - AREA 1
3-3-2	THIRD FLOOR PLAN - AREA 2
3-3-3	THIRD FLOOR PLAN - AREA 3
3-3-4	THIRD FLOOR PLAN - AREA 4
3-3-5	THIRD FLOOR PLAN - AREA 5
3-3-6	THIRD FLOOR PLAN - AREA 6
3-4-1	FOURTH FLOOR PLAN - AREA 1
3-4-2	FOURTH FLOOR PLAN - AREA 2
3-4-3	FOURTH FLOOR PLAN - AREA 3
3-4-4	FOURTH FLOOR PLAN - AREA 4
3-5-1	FIFTH FLOOR PLAN - AREA 1
3-5-2	FIFTH FLOOR PLAN - AREA 2
3-5-3	FIFTH FLOOR PLAN - AREA 3
3-5-4	FIFTH FLOOR PLAN - AREA 4
3-6-1	SIXTH FLOOR PLAN - AREA 1
3-6-2	SIXTH FLOOR PLAN - AREA 2
3-6-3	SIXTH FLOOR PLAN - AREA 3
3-PH-1	PENTHOUSE FLOOR PLAN - AREA 1
3-PH-2	PENTHOUSE FLOOR PLAN - AREA 2
3-PH-3	PENTHOUSE FLOOR PLAN - AREA 3
3-PH-4	PENTHOUSE FLOOR PLAN - AREA 4
4-01	BASEMENT STEAM/CONDENSATE PIPING DETAILS
4-02	BASEMENT STEAM/CONDENSATE PIPING DETAILS
4-03	BASEMENT STEAM/CONDENSATE PIPING DETAILS
4-04	BASEMENT STEAM/CONDENSATE PIPING DETAILS
4-05	BASEMENT STEAM/CONDENSATE PIPING DETAILS
4-06	PENTHOUSE STEAM/CONDENSATE PIPING DETAILS
4-07	PENTHOUSE STEAM/CONDENSATE PIPING DETAILS
ASBESTOS ABATEMENT	
1-A-1	ASBESTOS ABATEMENT ITEM TABLES & STANDARD DETAILS

Fredrick, Fredrick & Heller Engineers, Inc.
Mechanical & Electrical Engineer 672 East Royaltown Road, Broadview Heights, Ohio 44147
Stephen J. Sebesta & Associates, Inc.
Consulting Environmental Health Engineers 17830 Englewood Drive, Suite 16, Cleveland, Ohio 44130

APPROVALS		DATE		APPROVALS		DATE		APPROVALS		DATE	
DIRECTOR, 00				CHIEF Planning and Construction				FACILITY MANAGER			
ASSOCIATE DIRECTOR, 00A (B)				CHIEF - Occupational Health & Safety				SHOP FOREMAN 138			
FINAL CD SUBMISSION 85% SUBMISSION 65% SUBMISSION Revisions		12-2-12 11-30-12 11-16-12		CHIEF, ENGINEERING 138		CHIEF, HRM		Approved: Division Chief		Project Title STEAM TRAP MONITORING, INSULATION AND PIPING UPGRADES	
								Location VAMC - WADE PARK		Project Number 541-12-115 Building Number 1	
								Date 12-21-12		Checked WFW	
										Drawn JWP	
										Drawing Number 1-X0	
										Office of Facilities Management Department of Veterans Affairs	