


SECOND FLOOR KEY PLAN  
SCALE N.T.S.

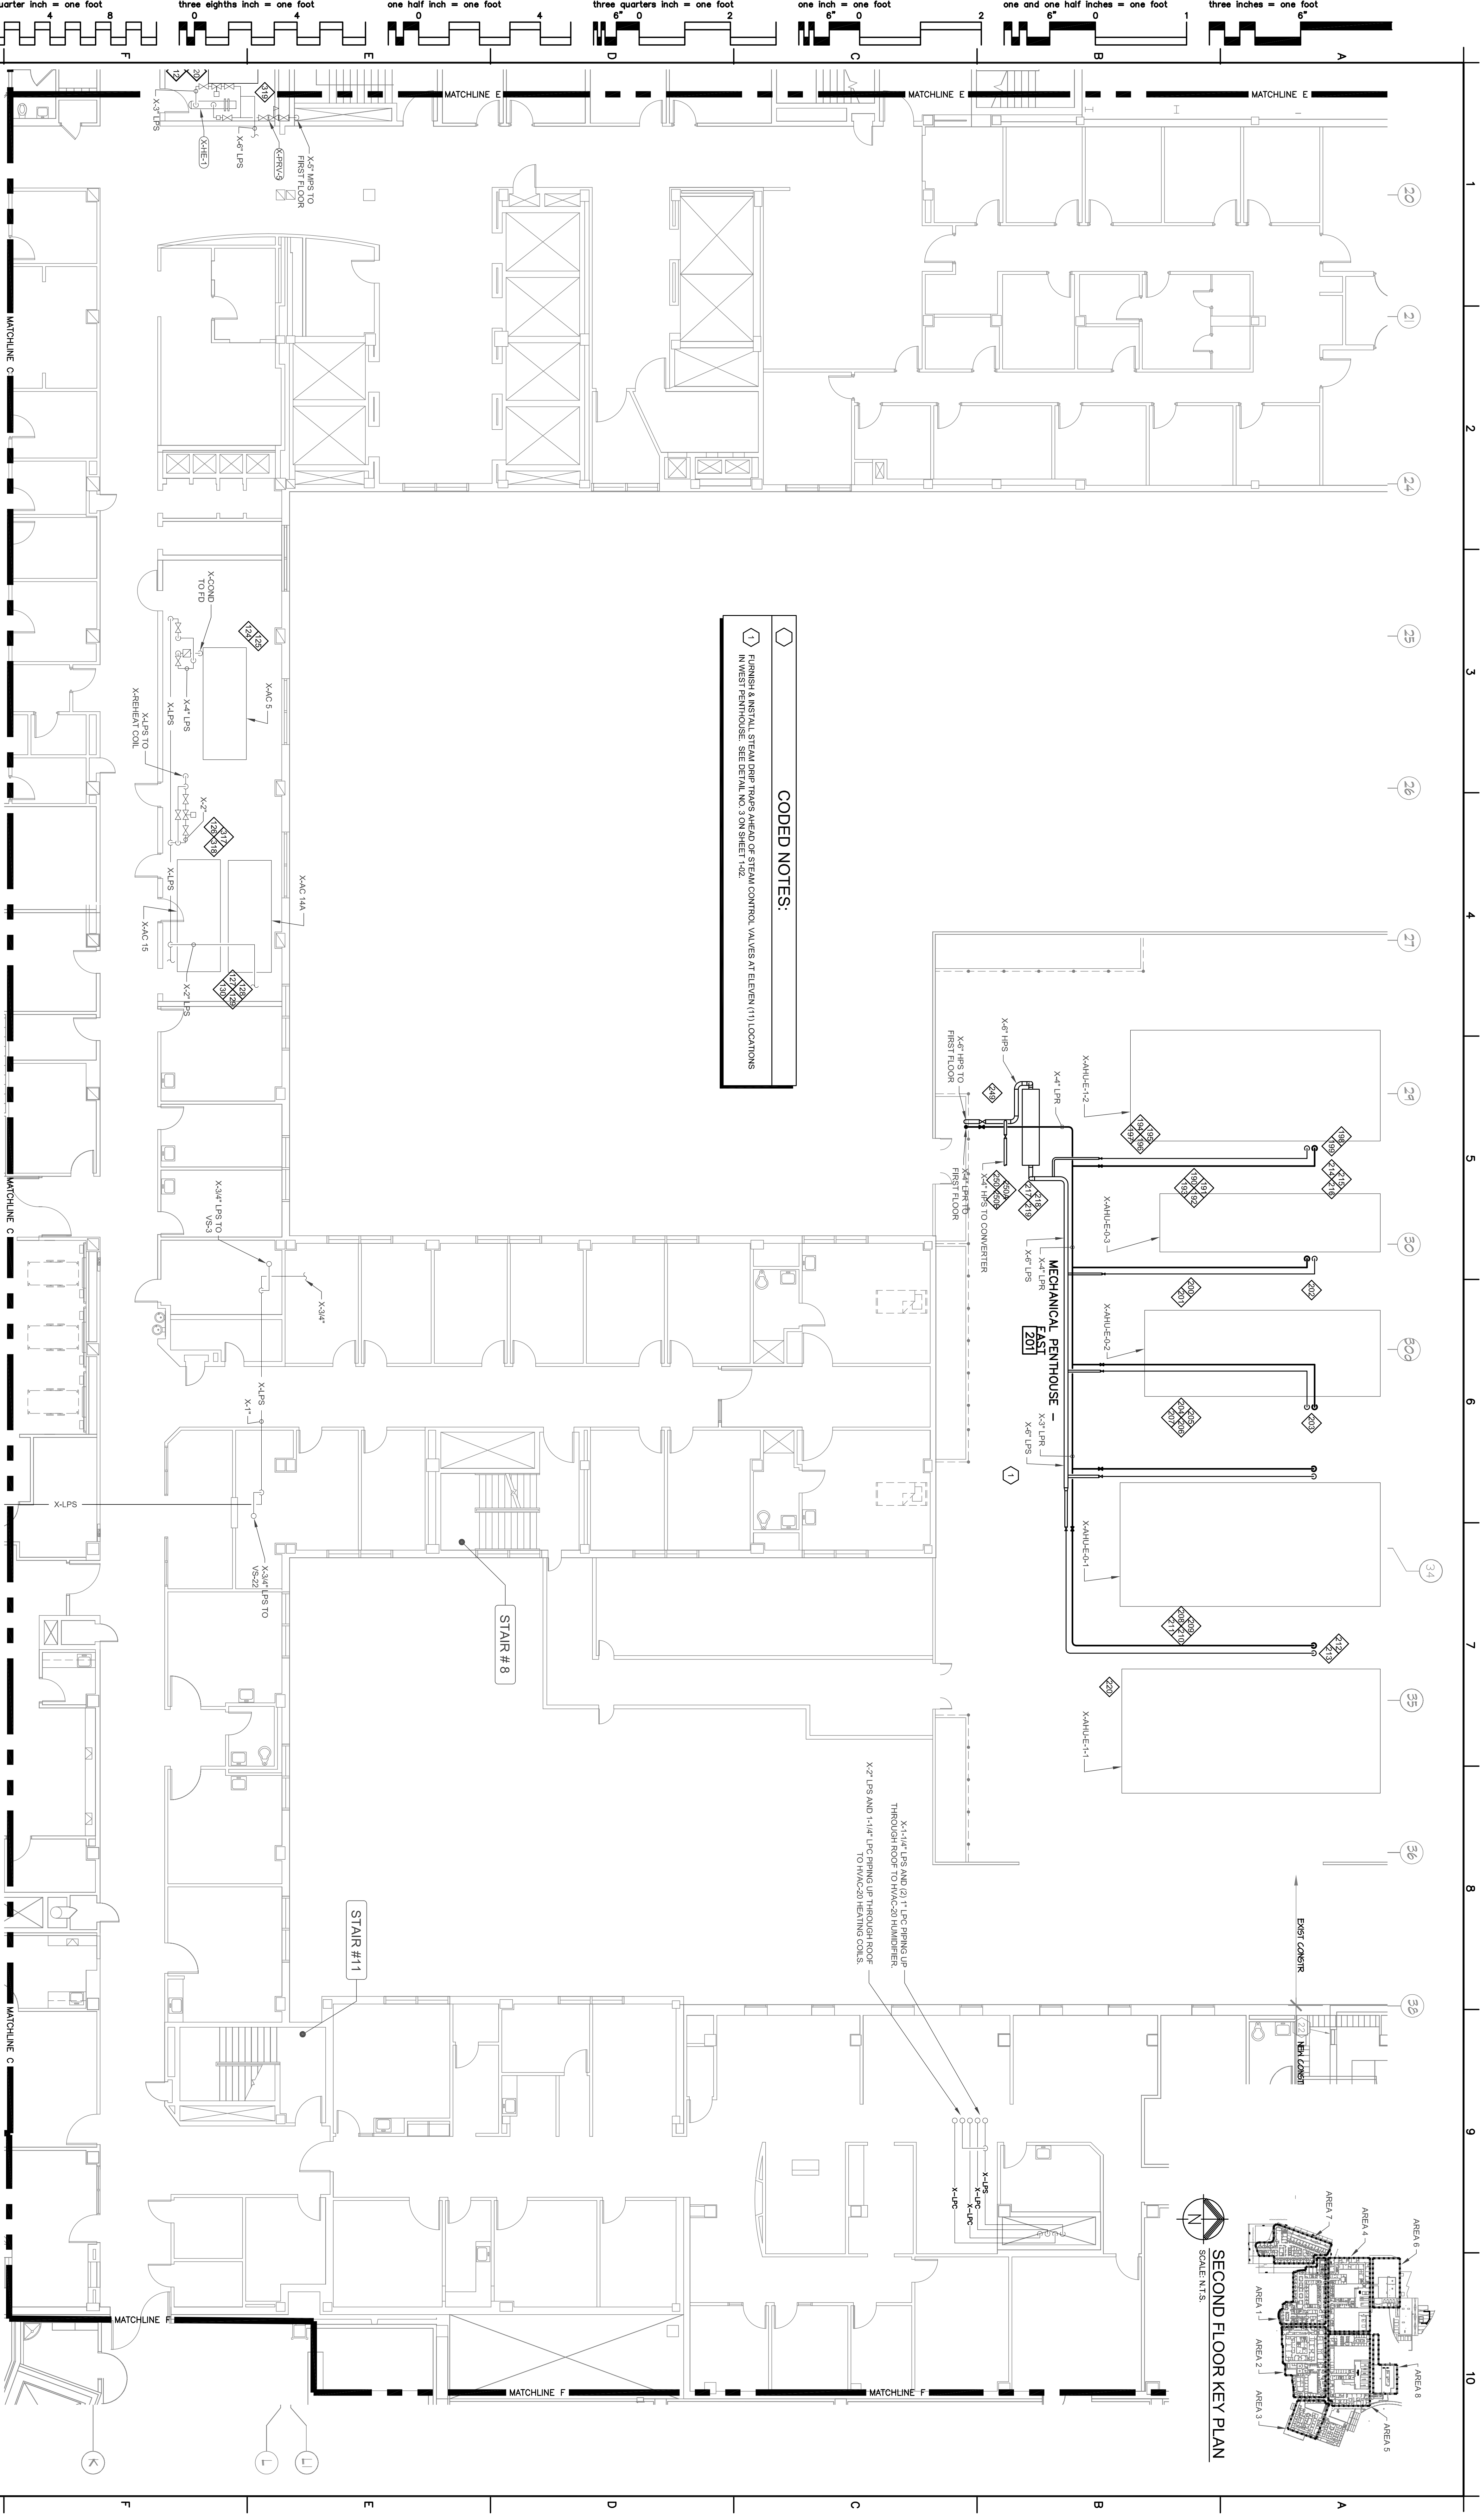


**CODED NOTES:**

1 FURNISH & INSTALL STEAM DRIP TRAPS AHEAD OF STEAM CONTROL VALVES AT ELEVEN (11) LOCATIONS IN WEST PENTHOUSE. SEE DETAIL NO. 3 ON SHEET 1-62.

PARTIAL SECOND FLOOR - STEAM PIPING - AREA 5  
SCALE: 1/8" = 1'-0"  
0 4 8 16 32

**CONSULTANTS:**

FREDERICK, FREDERICK & HELLER  
ARCHITECTS, INC.  
672 EAST ROYALTON ROAD  
BROADVIEW HTS., OHIO 44147  
TEL: (440) 546-2666  
FAX: (440) 546-2666

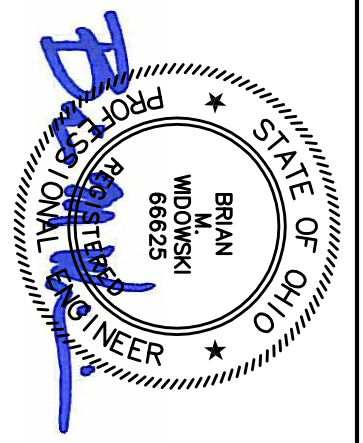

**ARCHITECT:**

SECOND FLOOR PLAN  
AREA 5

Project Title  
**STEAM TRAP MONITORING,  
INSULATION AND PIPING  
UPGRADES**

Location  
**VAMC - WADE PARK**

Approved: Project Director

WPH

JMF

Drawing Number  
**3-2-5**

Office of  
Facilities  
Management  
Department of  
Veterans Affairs