


THIRD FLOOR KEY PLAN
SCALE: N.T.S.

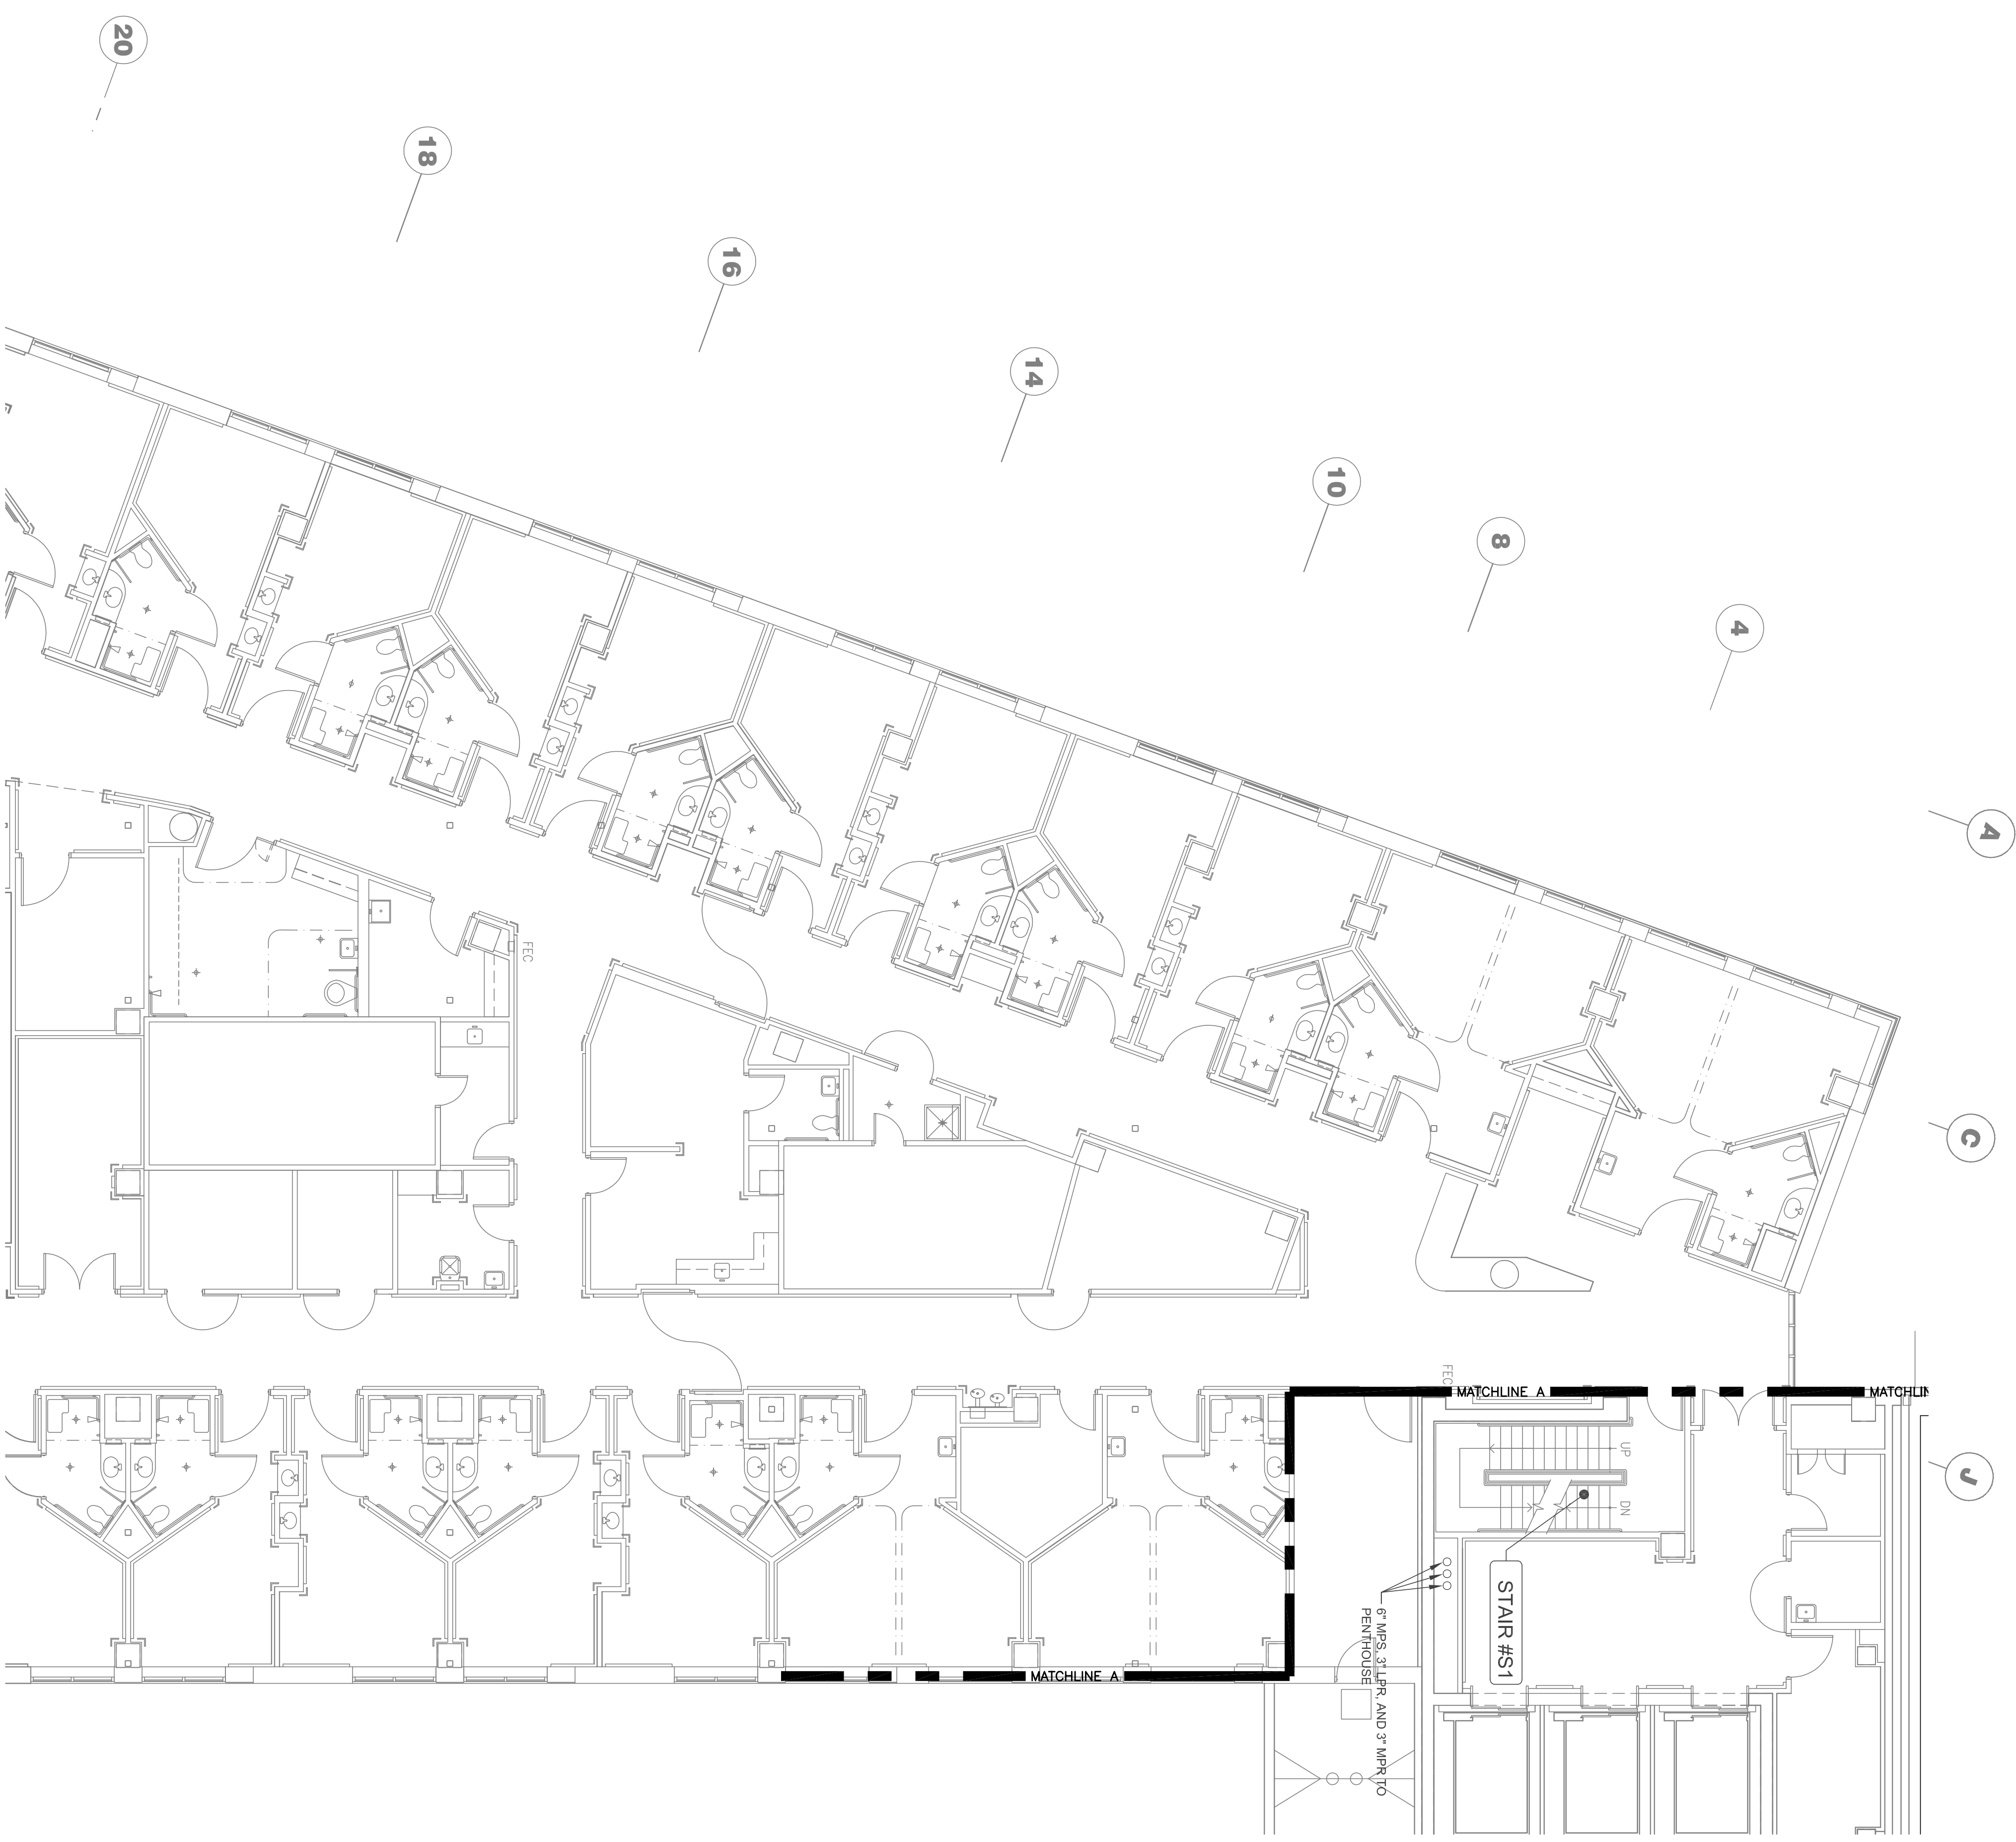


PARTIAL THIRD FLOOR - STEAM PIPING - AREA 6
SCALE: 1/8" = 1'-0"
0 4 8 16 32

1

FINAL CD-SUBMISSION	12-21-12
95% SUBMISSION	11-30-12
65% SUBMISSION	11-16-12
Revisions:	Date




FREDERICK, RUPPEL & HELLER, INC.
ARCHITECTS
672 EAST KOVALTON ROAD
BROADVIEW HTS., OHIO 44147
TEL: (440) 546-3666
FAX: (440) 546-3666

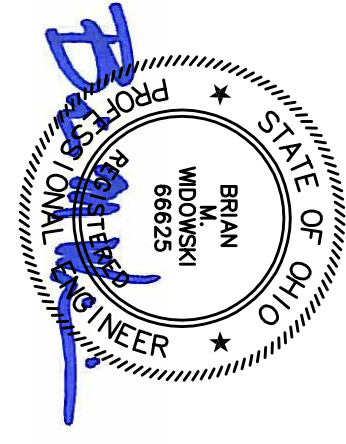

CONSULTANTS:

ARCHITECT:

Drawing Title THIRD FLOOR PLAN AREA 6		Project Title STEAM TRAP MONITORING, INSULATION AND PIPING UPGRADES		Project Number 541-12-115		Office of Facilities Management 
Approved: Project Director		Location VAMC - WADE PARK		Building Number 1		
Date 12-21-12	Checked WPH	Drawn JMF	Drawing Number 3-3-6			