


FIFTH FLOOR KEY PLAN  
SCALE: N.T.S.

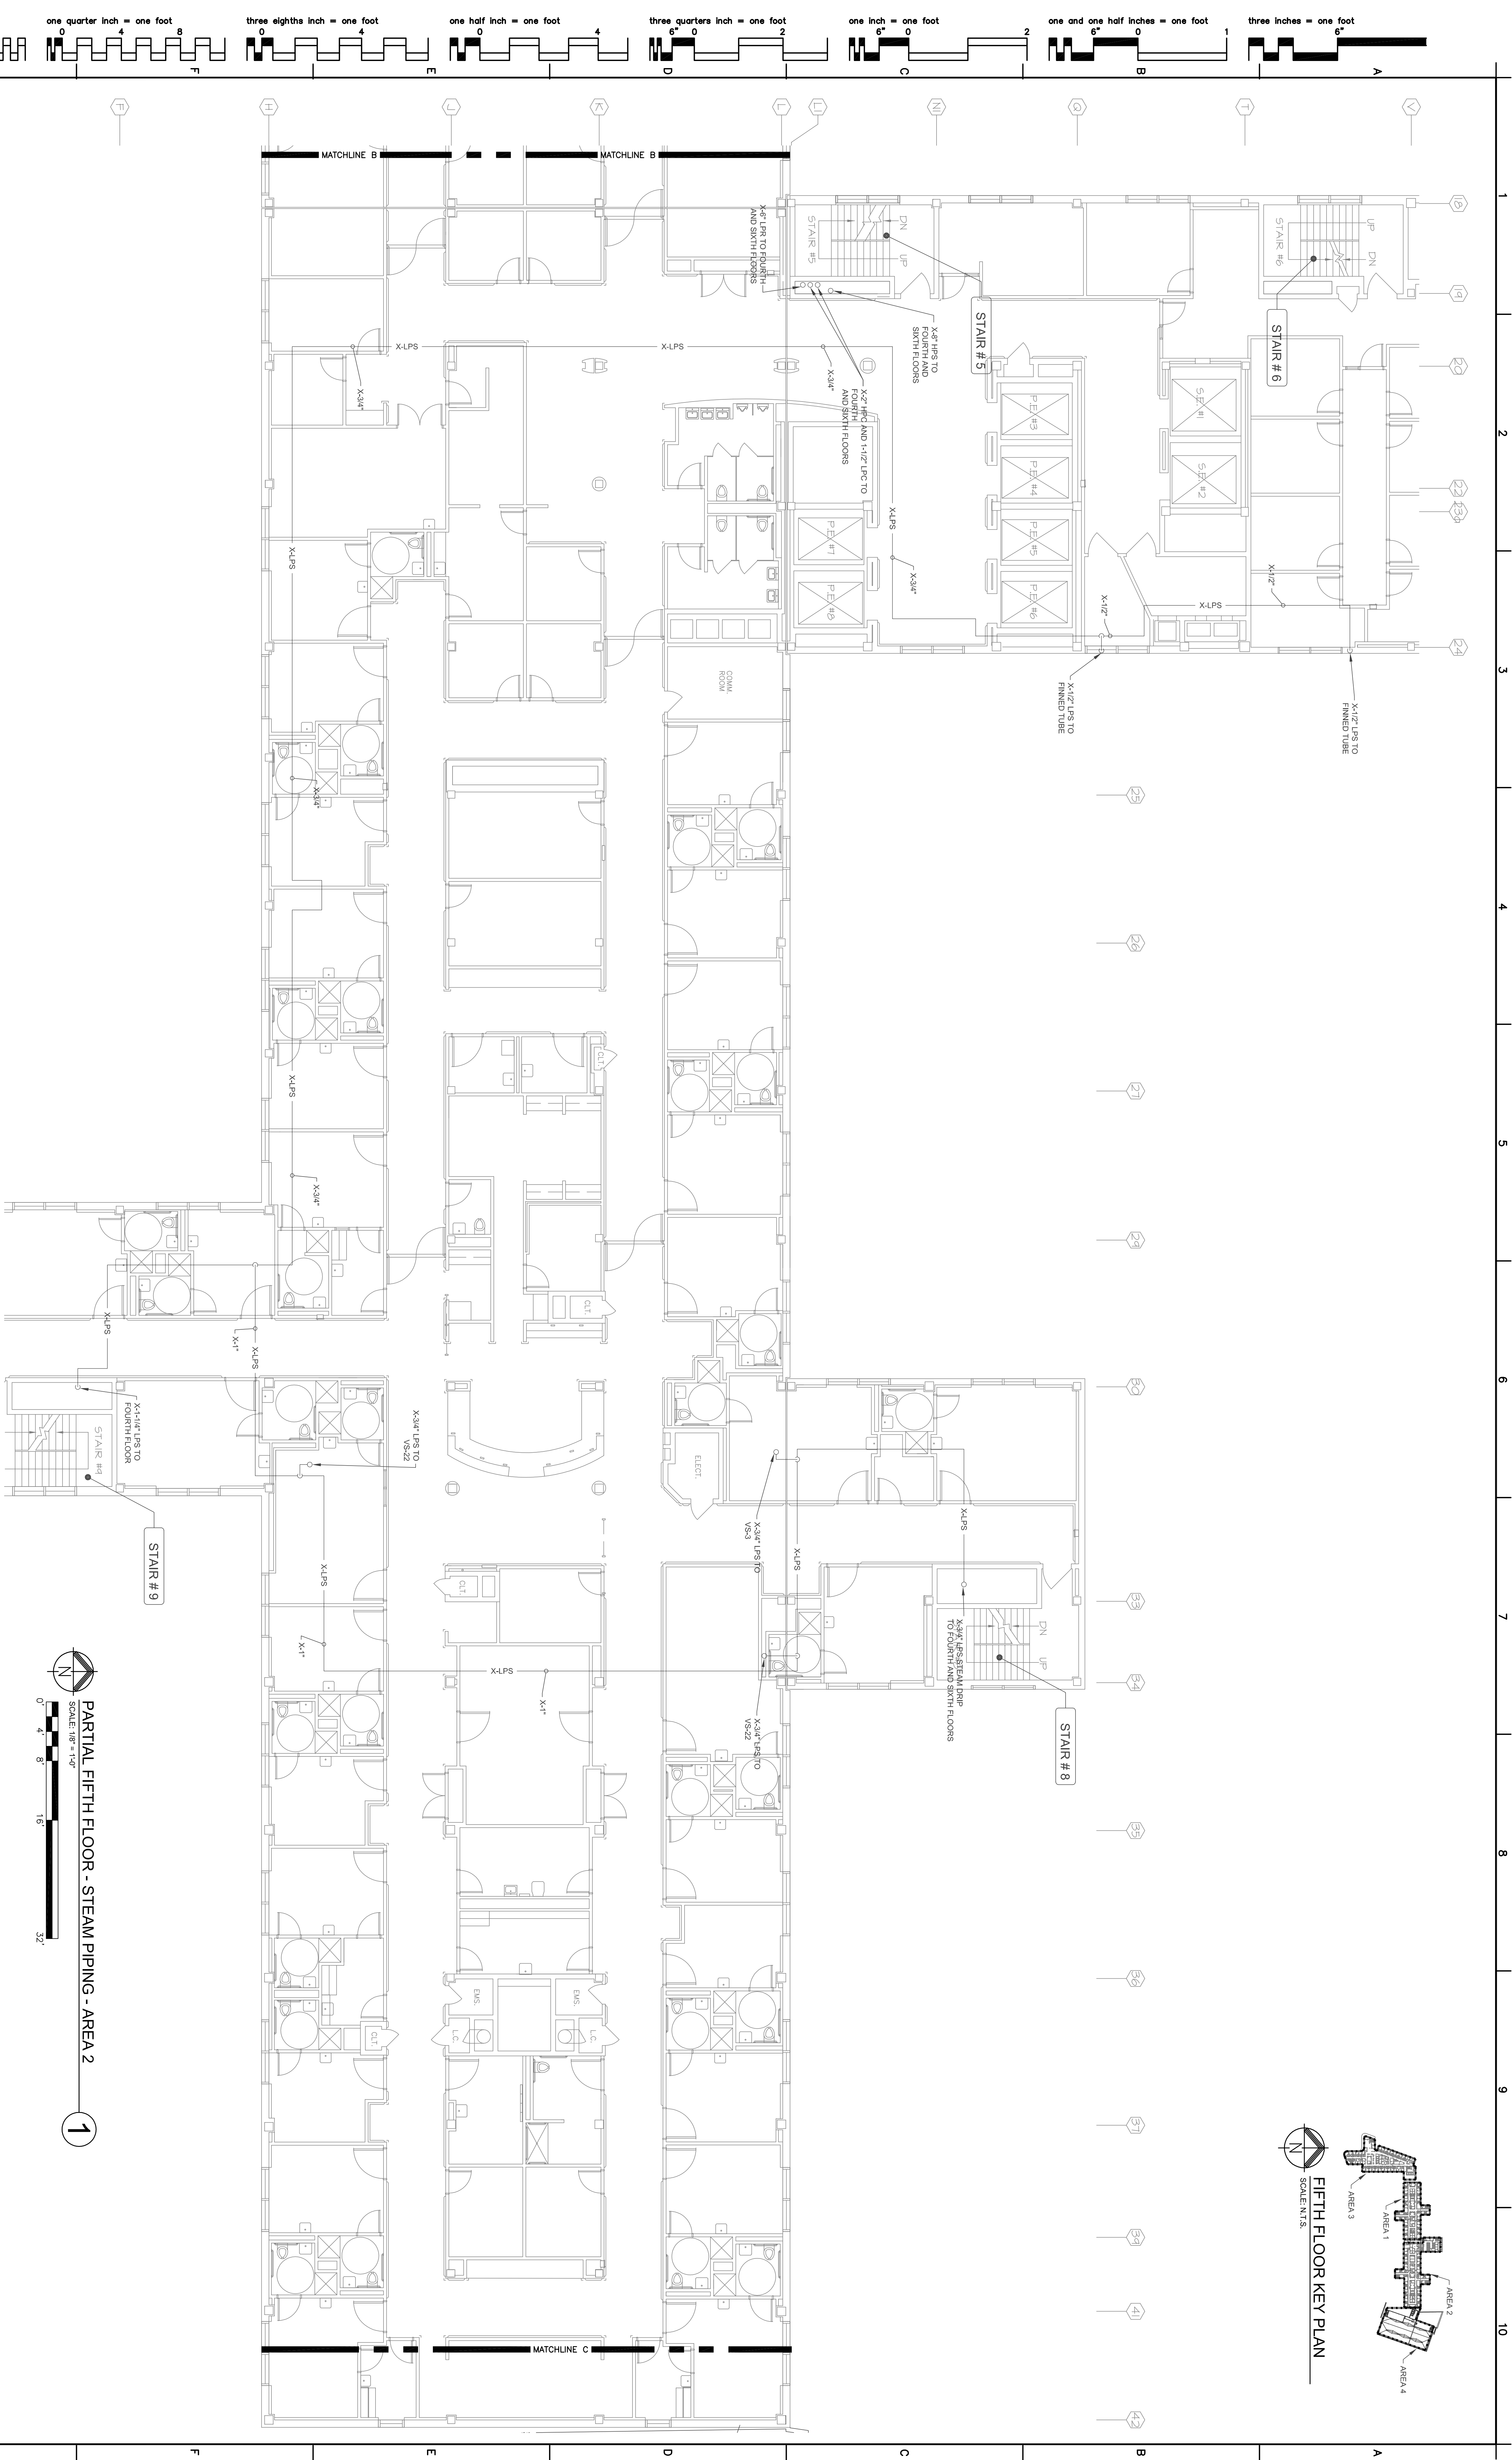

PARTIAL FIFTH FLOOR - STEAM PIPING - AREA 2  
SCALE: 1/8" = 1'-0"  
32'

<b>CONSULTANTS:</b>		<b>ARCHITECT:</b>	
FREDRICK, FREDRICK & HELLER ARCHITECTS, INC. 672 EAST ROYALTON ROAD BROADVIEW HTS., OHIO 44147 Tel: (440) 546-2666 Fax: (440) 546-2666		Drawing Title <b>PARTIAL FIFTH FLOOR STEAM PIPING PLAN - AREA 2</b>	
Revisions: 12-21-12 11-30-12 11-16-12		Project Title <b>STEAM TRAP MONITORING, INSULATION AND PIPING UPGRADES</b>	
Date		Location <b>VAMC - WADE PARK</b>	
Date		Checked <b>WPH</b>	
Date		Drawn <b>JMF</b>	
Date		Drawing Number <b>3-5-2</b>	
Date		Building Number <b>541-12-115</b>	
Date		Drawing Number <b>1</b>	
Date		Office of Facilities Management Department of Veterans Affairs	